

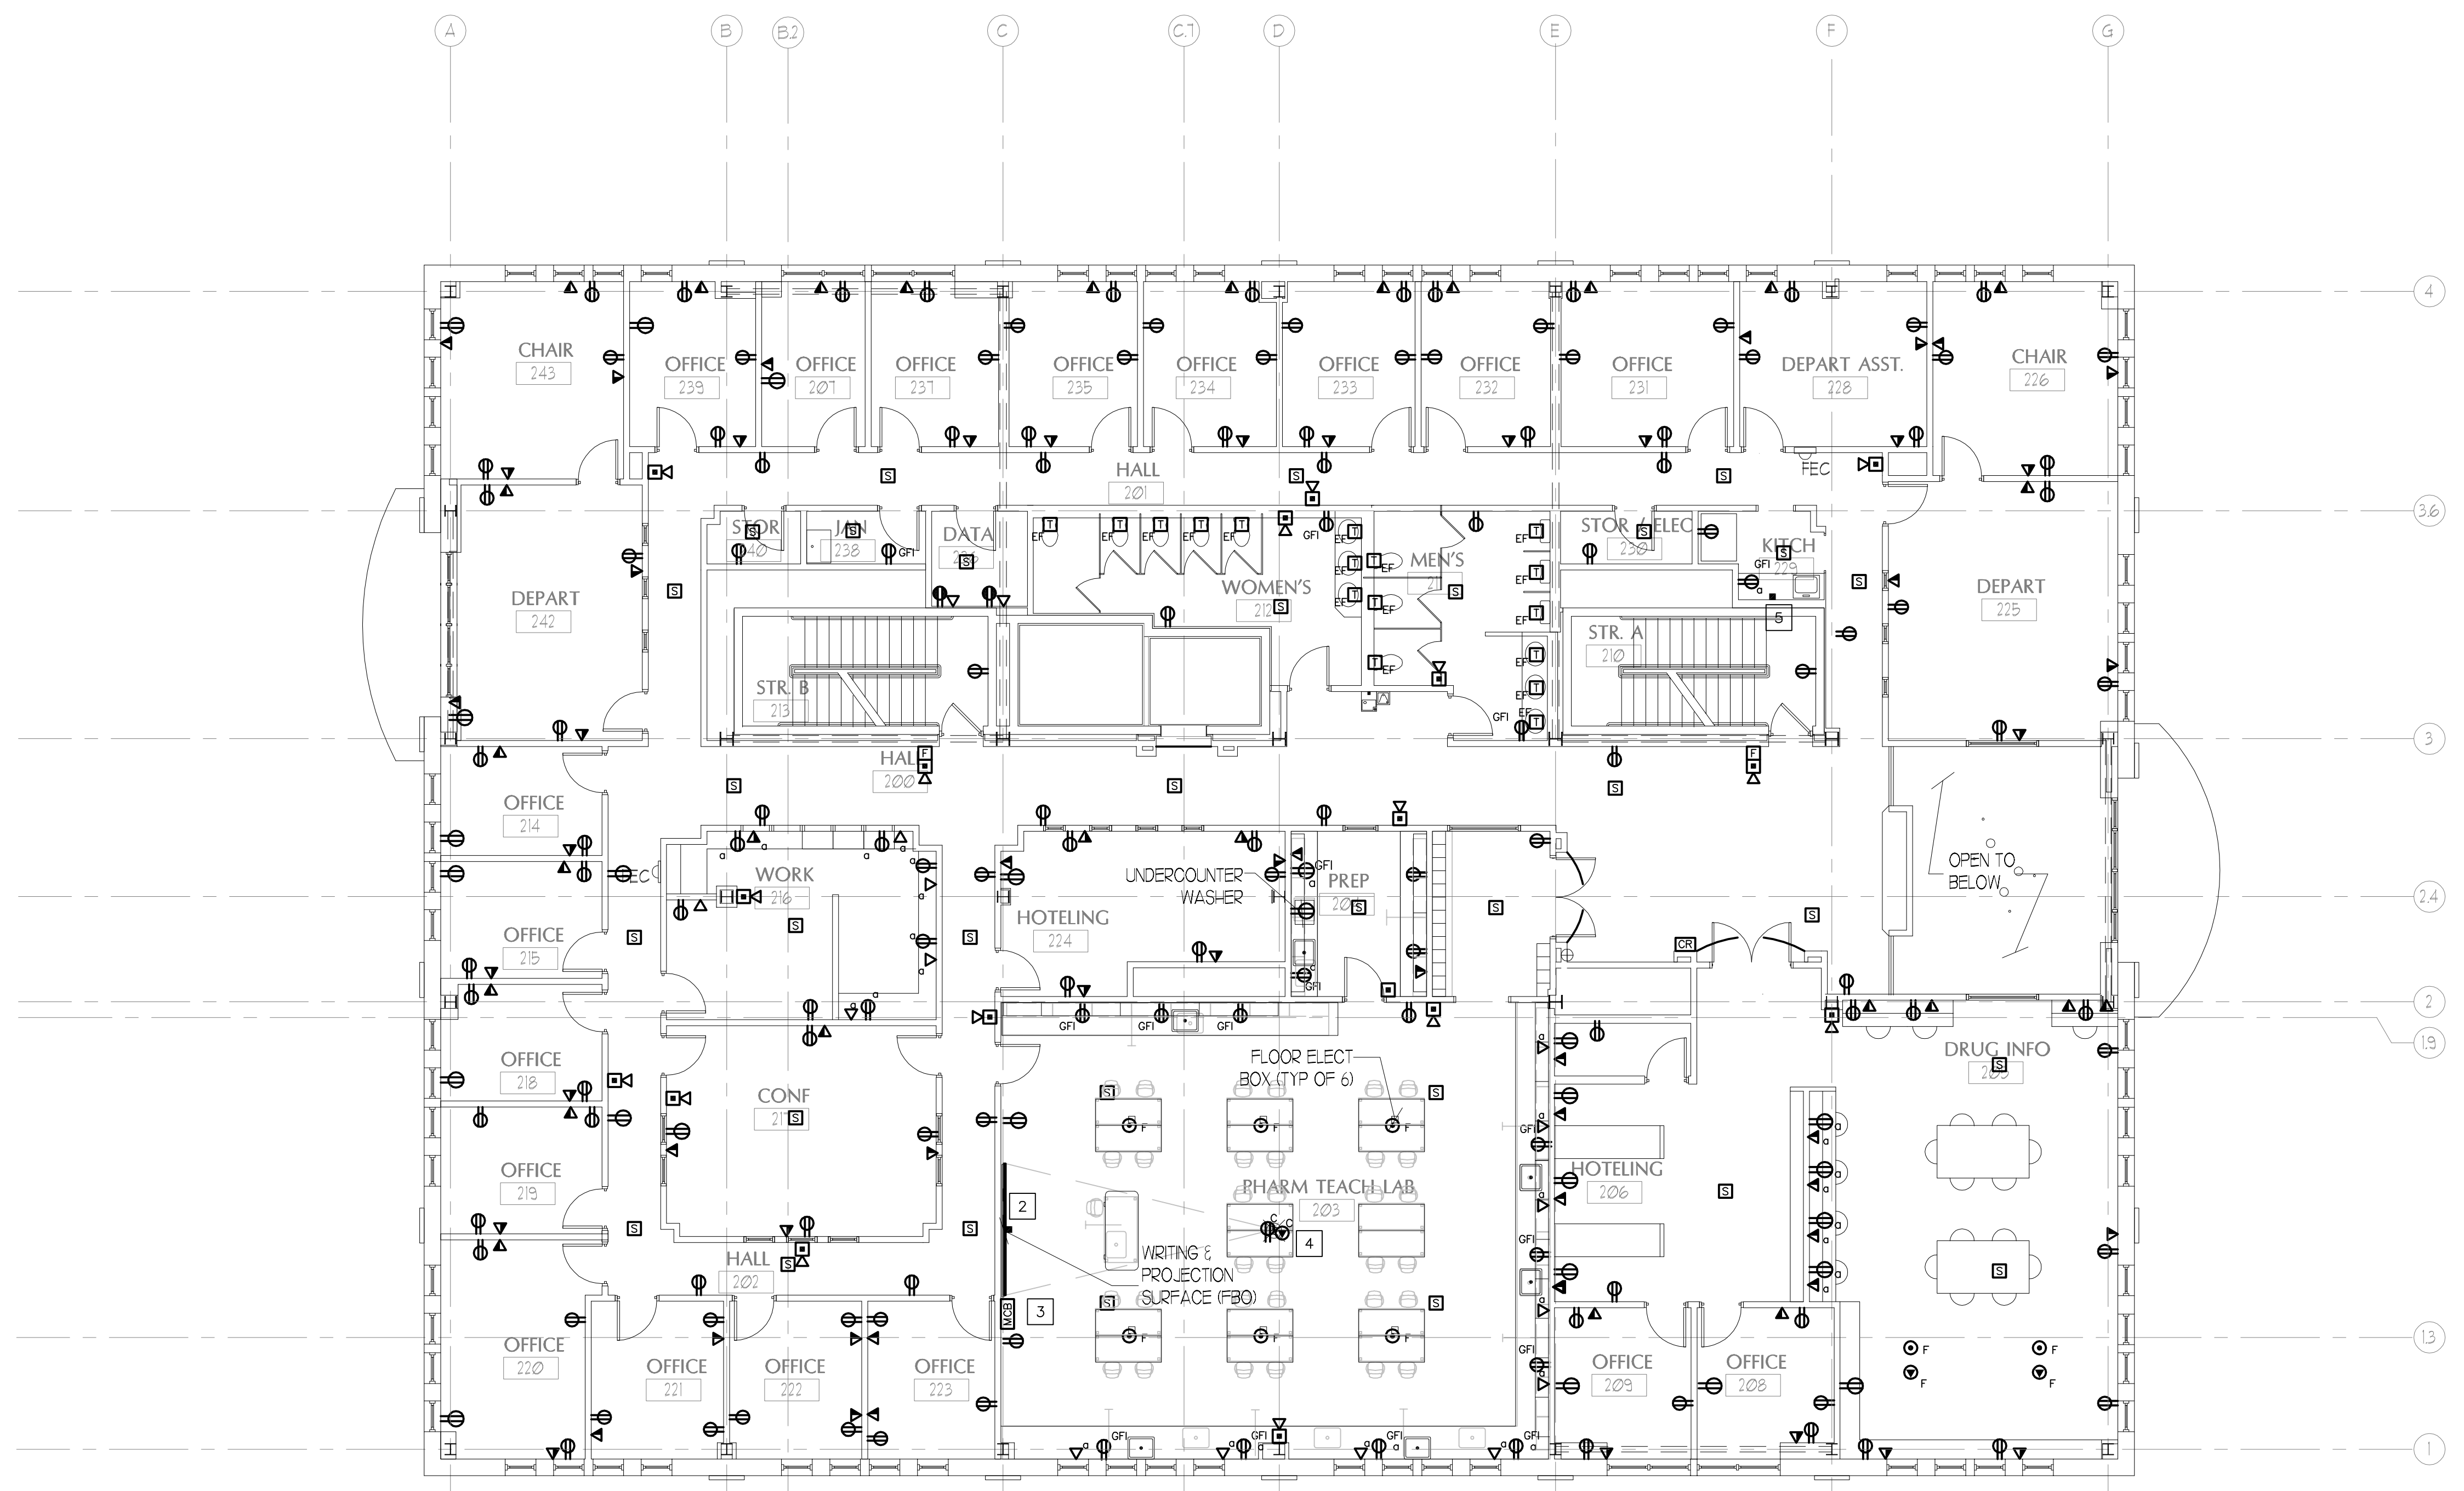


IF THIS SHEET IS NOT 24 X 36 IT IS A REDUCED SCALE PRINT - SCALE ACCORDINGLY

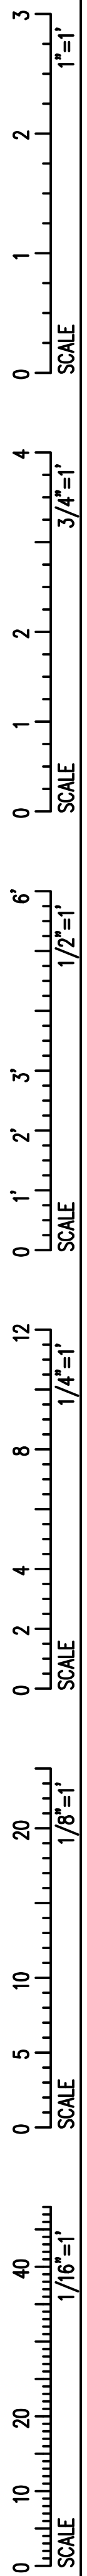


- KEYED NOTES:
1. POWER CONNECTION FOR ELECTRIC SHADES. COORDINATE WITH INSTALLER.
 2. POWER CONNECTION FOR MOTORIZED SCREEN. COORDINATE WITH INSTALLER.
 3. MEDIA CONTROL BOX FOR MOTORIZED SCREEN. COORDINATE INSTALLATION WITH INSTALLER.
 4. POWER AND DATA CONNECTIONS FOR OVERHEAD PROJECTOR. COORDINATE LOCATION WITH INSTALLER.
 5. POWER CONNECTION FOR COFFEE URN.

1 SECOND FLOOR PLAN
SCALE: 1/8" = 1'-0"

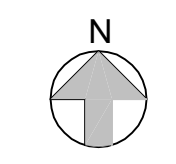


PERMIT SET - NOT FOR CONSTRUCTION

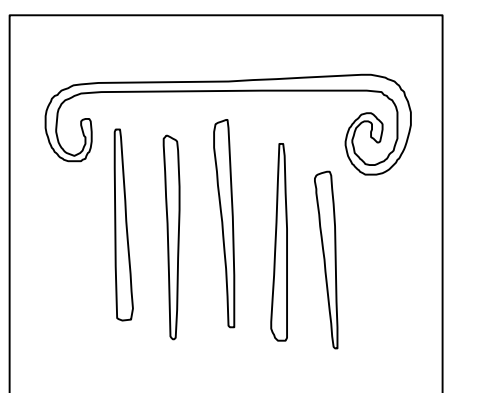

PORT CITY ARCHITECTURE

65 NEWBURY STREET
PORTLAND, ME 04101
207.761.9000
fax: 207.761.2010
lita@portcityarch.com

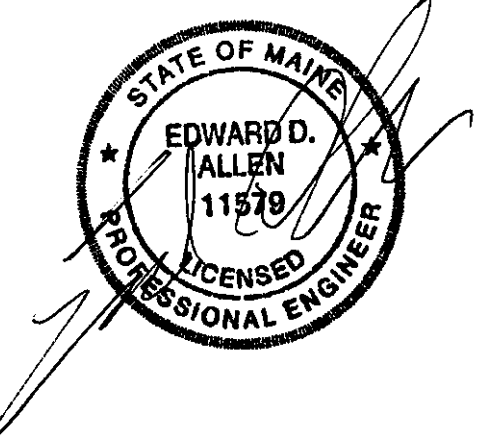

VANZELM
ENGINEERS

VANZELM HEYWOOD & SHADFORD, INC.
10 TALCOTT NOTCH FARMINGTON, CT 06032
TEL: (860)284-5964 FAX: (860)284-5968
PROJECT NO.: 2007120.00

BECKER
structural engineers, inc.

SYTDesign
CONSULTANTS
CIVIL ENGINEERING & LANDSCAPE ARCHITECTURE

ALLIED/COOK
CONSTRUCTION

Favreau
ELECTRICAL

Titan Mechanical, Inc.
Design-Build Engineering - Mechanical Contracting

#	DATE	DESCRIPTION
		PERMIT SET
	01/24/08	Date Issued
	06506	Project Number

SHEET NAME
ELECTRICAL POWER PLAN - SECOND FLOOR

Drawn By
AMM
Checked By
MER

EP1.3