

IF THIS SHEET IS NOT 24 X 36 IT IS A REDUCED SCALE PRINT - SCALE ACCORDINGLY

3 1 2 0 1 2 3 4 0 1 2 3 4 5 6 8 12 0 2 4 6 8 10 20 40 0 1 2 3 4 5 6 7 8 9 10 11 12 13 14 15 16 17 18 19 20 21 22 23 24 25 26 27 28 29 30 31 32 33 34 35 36

SCALE 1"=1'


SCALE 3/4"=1'

SCALE 1/2"=1'


SCALE 1/4"=1'

SCALE 1/8"=1'

SCALE 1/16"=1'

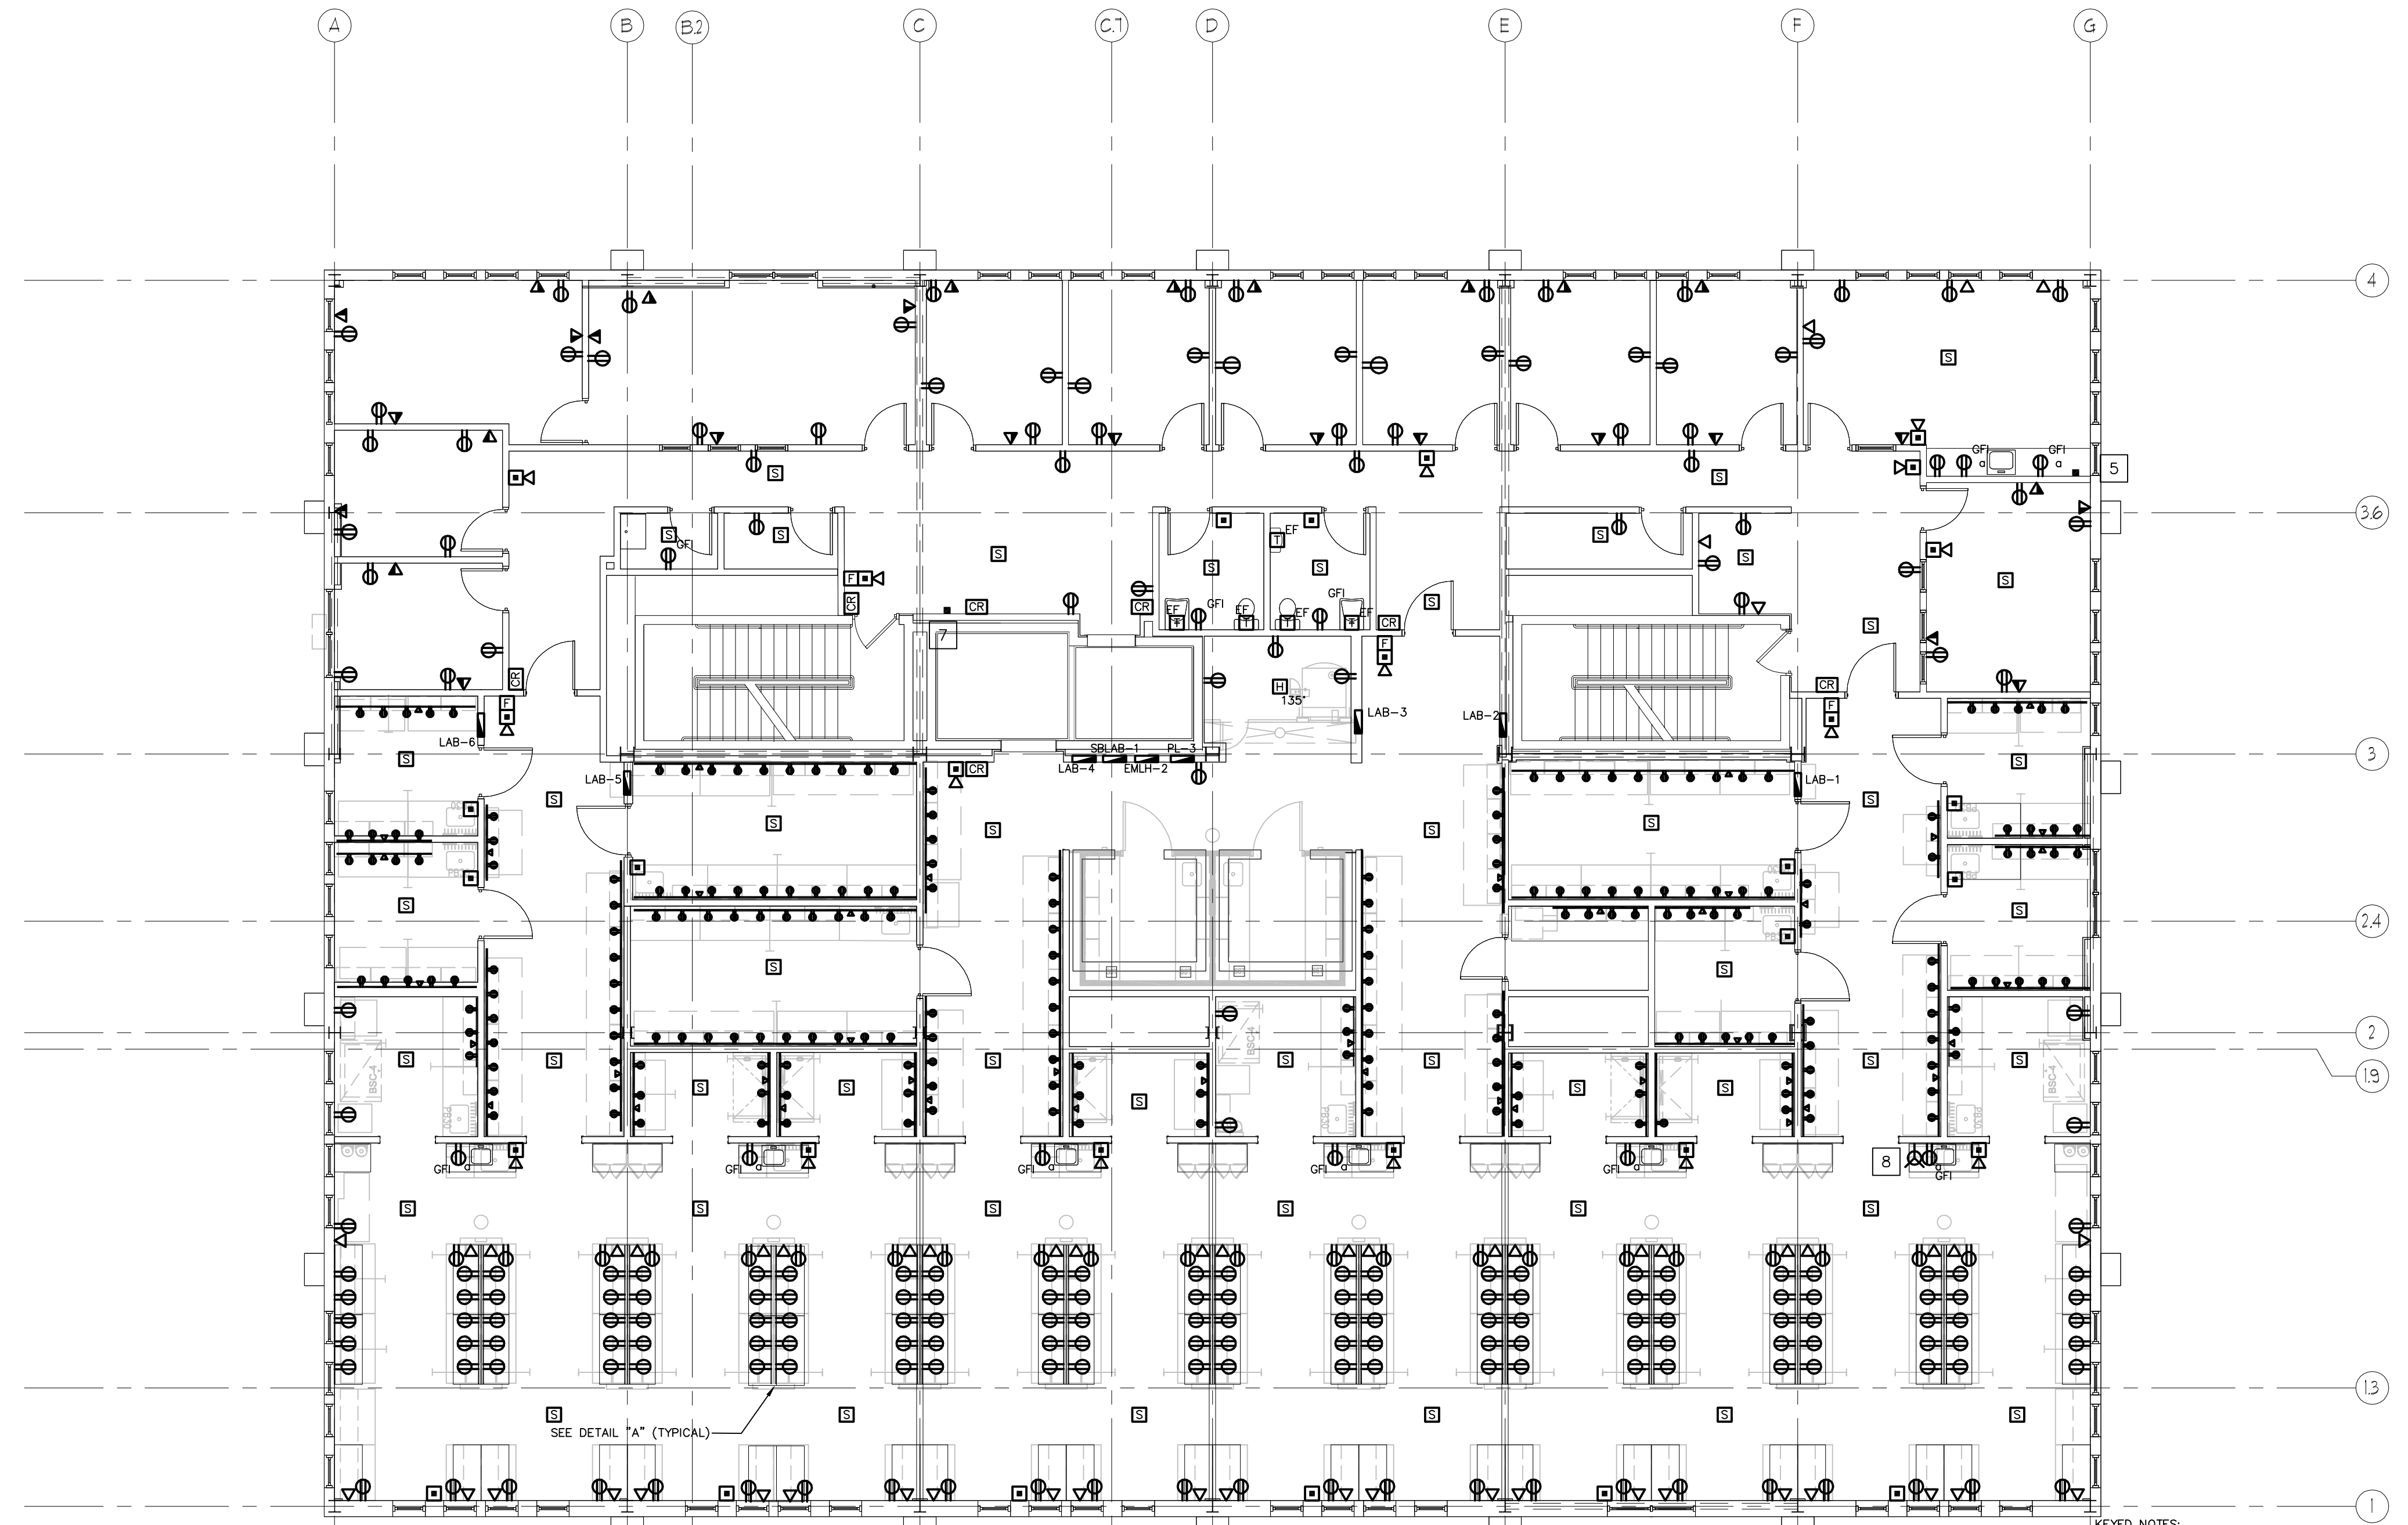


1 THIRD FLOOR PLAN
SCALE: 1/8" = 1'-0"

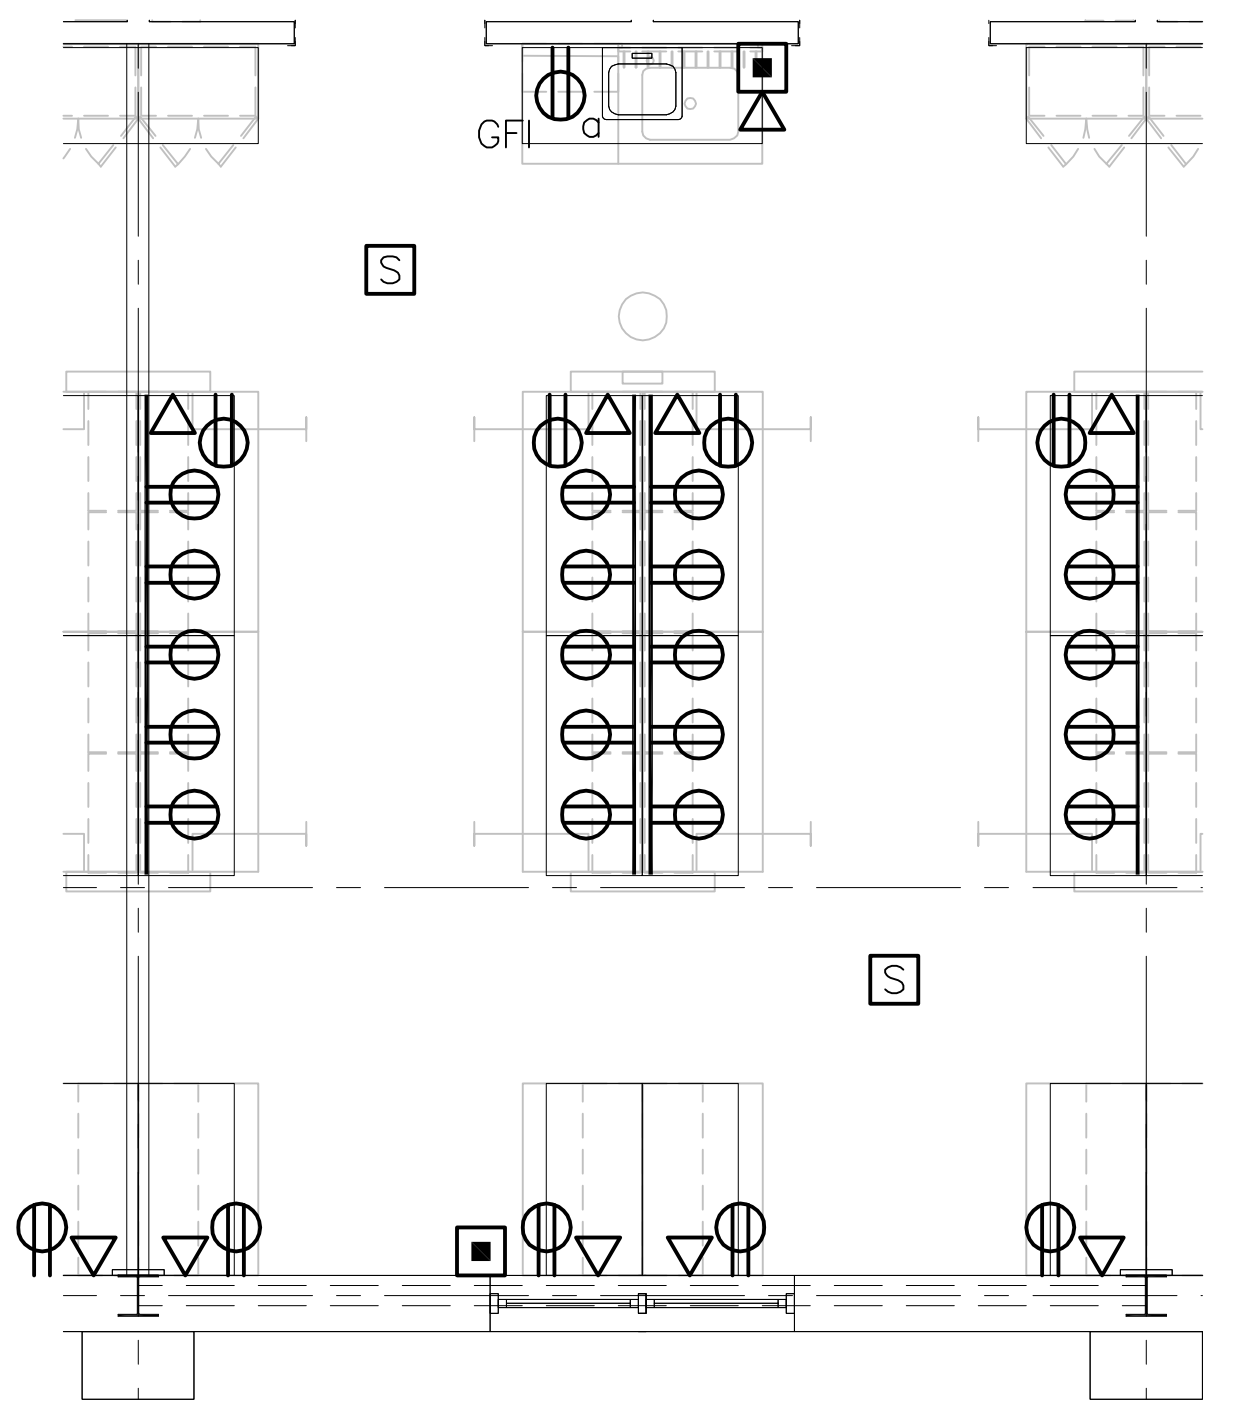


A LAB STATION LAYOUT
Scale: 1/4" = 1'

- KEYED NOTES:
1. POWER CONNECTION FOR ELECTRIC SHADES. COORDINATE WITH INSTALLER.
 2. POWER CONNECTION FOR MOTORIZED SCREEN. COORDINATE INSTALLATION WITH INSTALLER.
 3. MEDIA CONTROL BOX FOR MOTORIZED SCREEN. COORDINATE INSTALLATION WITH INSTALLER.
 4. OVERHEAD PROJECTOR. COORDINATE LOCATION WITH INSTALLER.
 5. POWER CONNECTION FOR COFFEE URN.
 6. COORDINATE INSTALLATION WITH MILLWORK.
 7. POWER CONNECTION FOR DRINKING FOUNTAIN.
 8. POWER CONNECTION FOR DISHWASHER. POWER REQUIREMENT: 3/60/208, 7 KW, 20A.

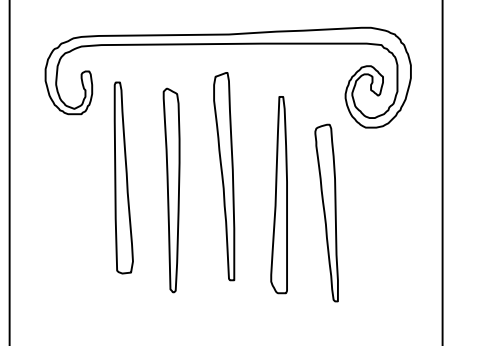

PORT CITY ARCHITECTURE

65 NEWBURY STREET
PORTLAND, ME 04101
207.761.9000
fax: 207.761.2010
lita@portcityarch.com

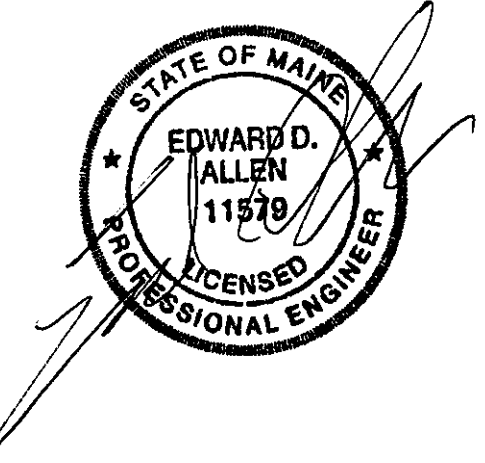

VANZELM ENGINEERS

VANZELM HEYWOOD & SHADFORD, INC.
10 TALCOTT NOYSE FARMINGTON, CT 06032
TEL: (860) 284-3064 FAX: (860) 284-3066
PROJECT NO.: 2007120.00

BECKER
structural engineers, inc.

SYTDesign CONSULTANTS
CIVIL ENGINEERING & LANDSCAPE ARCHITECTURE



#	DATE	DESCRIPTION

PERMIT SET

Date Issued 01/24/08


Project Number 06506

SHEET NAME
ELECTRICAL POWER PLAN - THIRD FLOOR

Drawn By
AMM

Checked By
MER

EP1.4

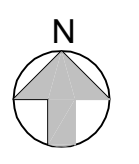

PERMIT SET - NOT FOR CONSTRUCTION

COPYRIGHT: Reuse or reproduction of the contents of this document is not permitted without written permission of PORT CITY ARCHITECTURE PA