

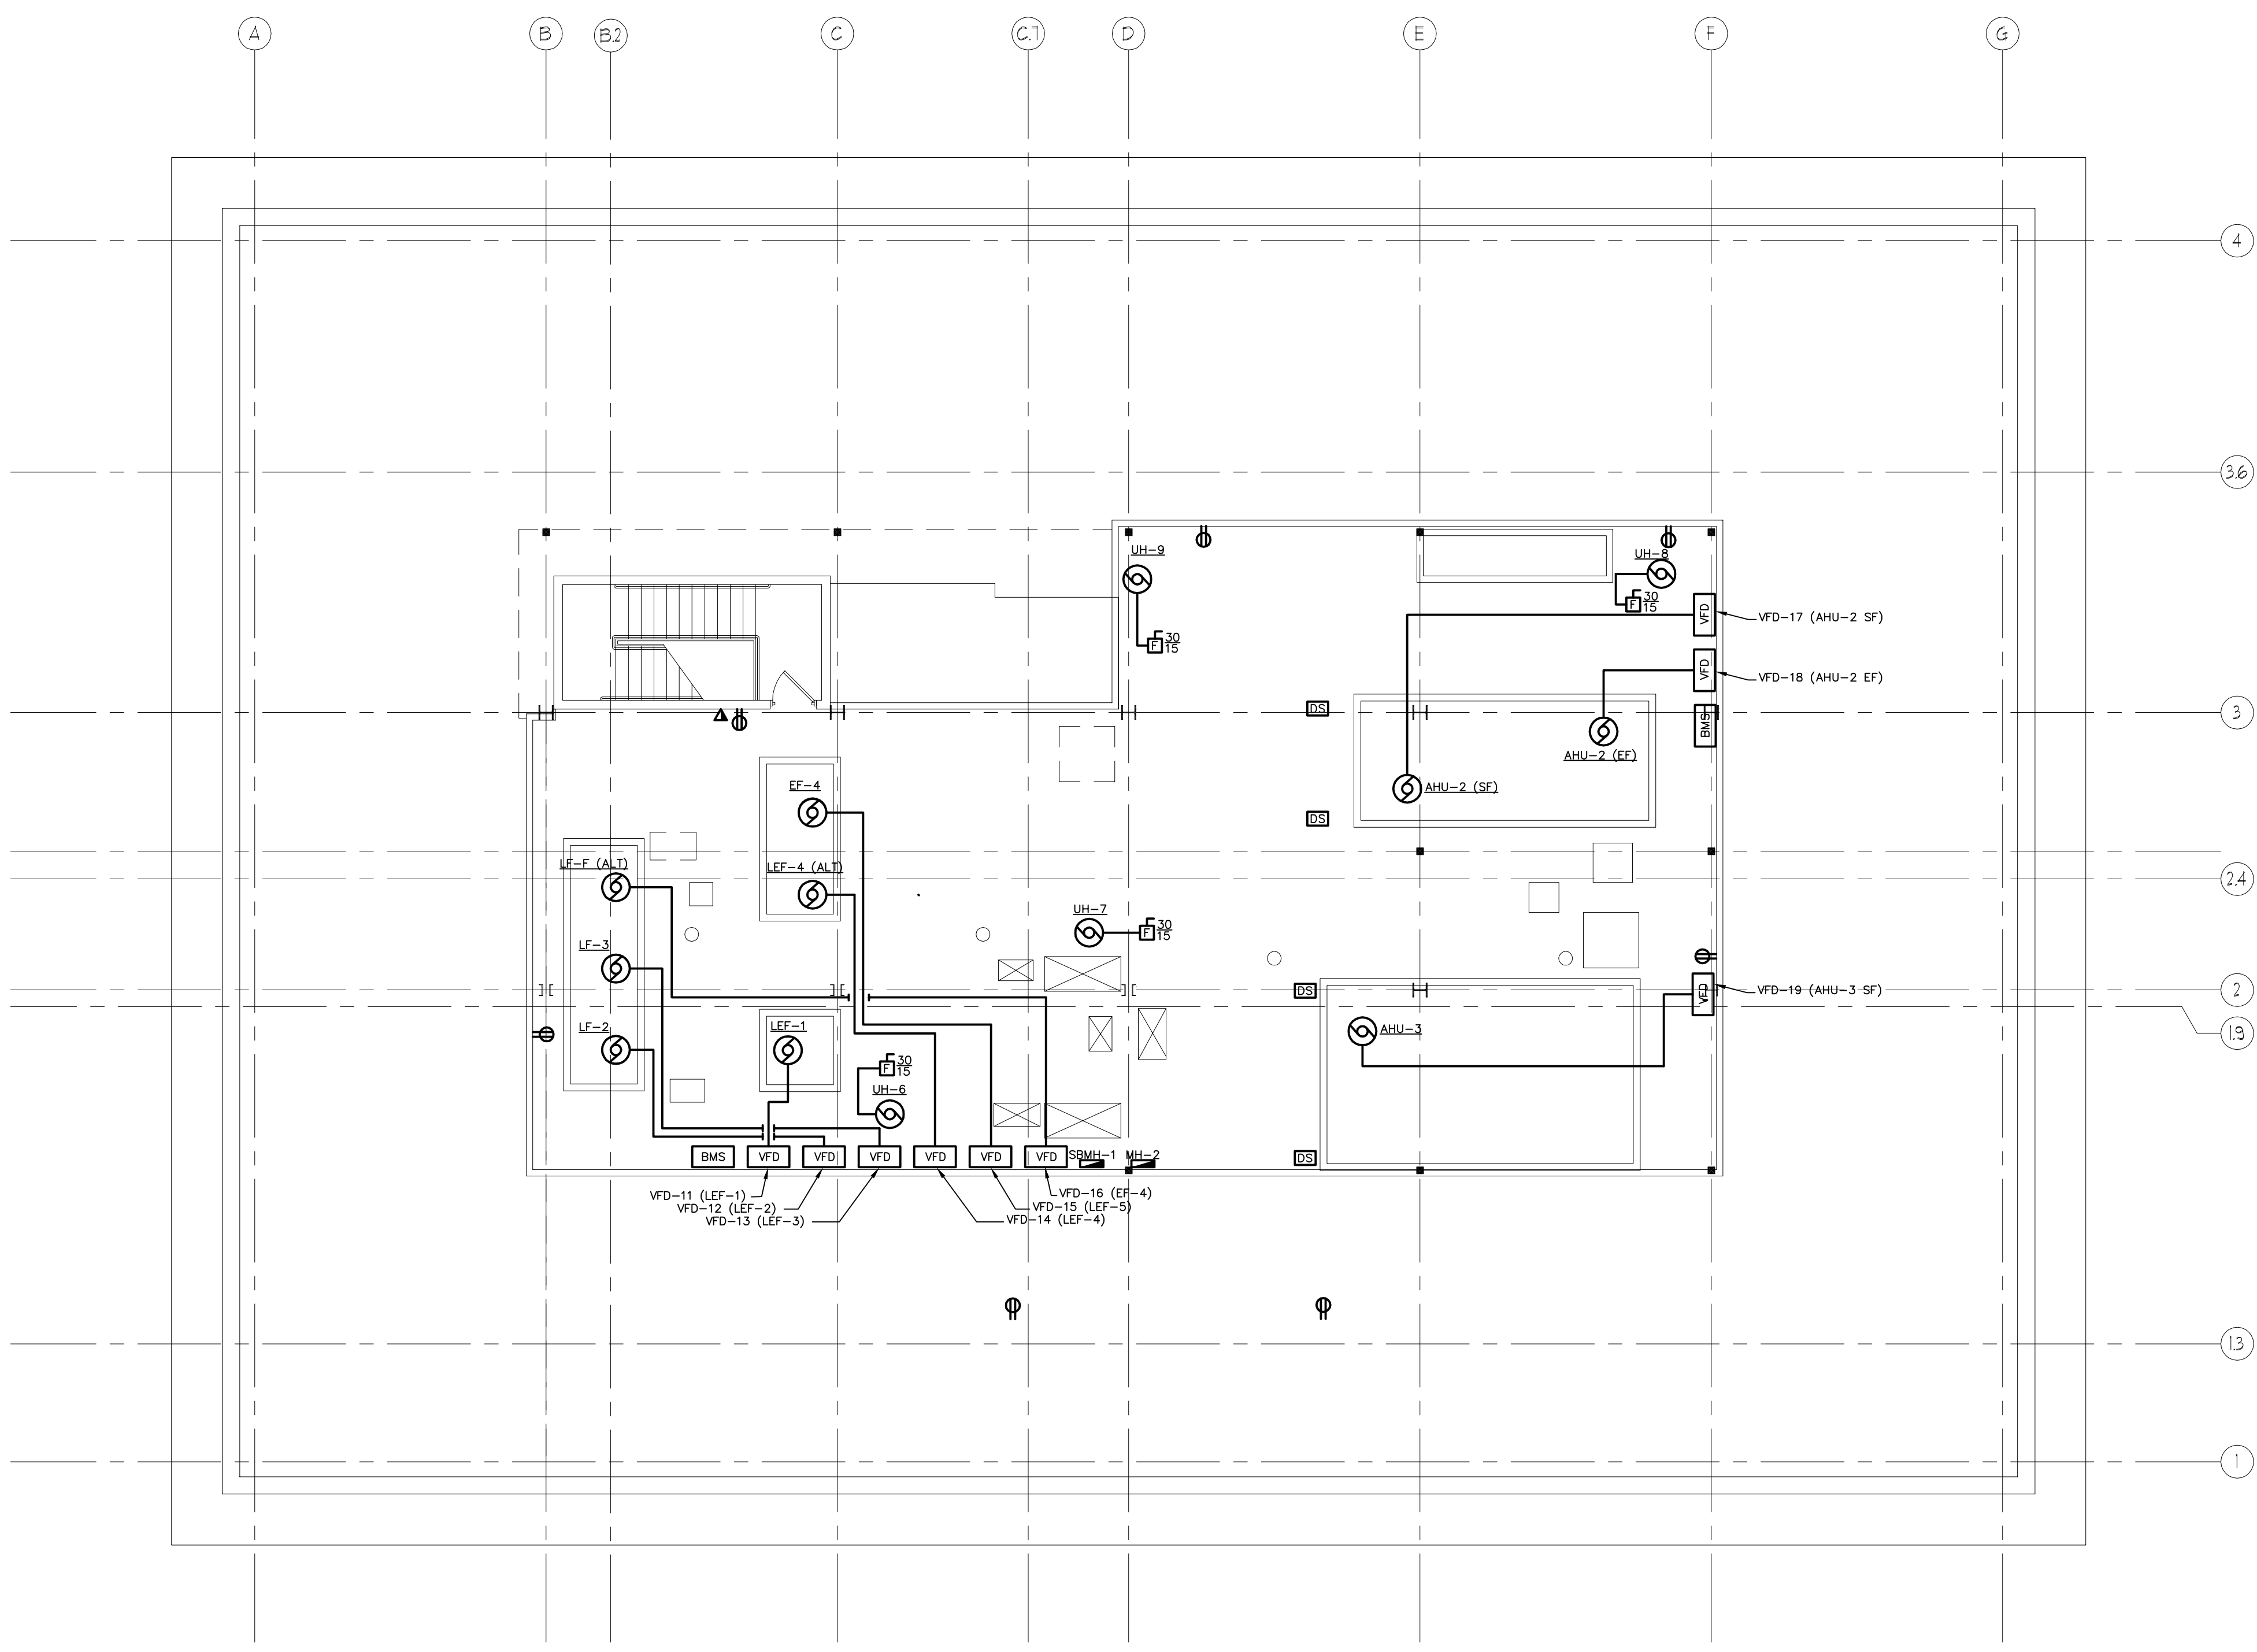



IF THIS SHEET IS NOT 24 X 36 IT IS A REDUCED SCALE PRINT - SCALE ACCORDINGLY

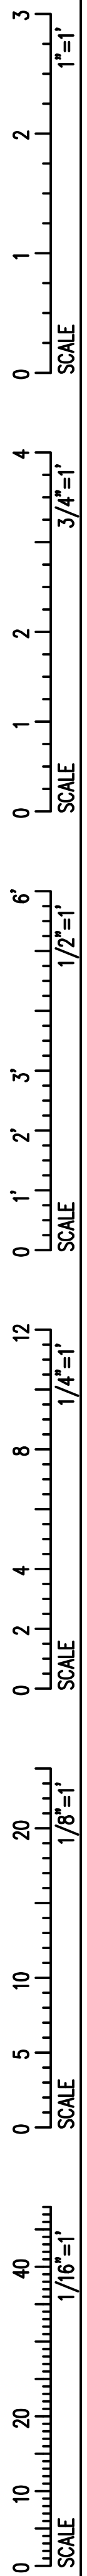

1 MECH. MEZZANINE POWER PLAN
 SCALE: 1/8" = 1'-0"

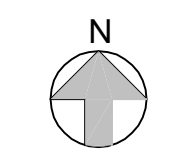


PERMIT SET - NOT FOR CONSTRUCTION

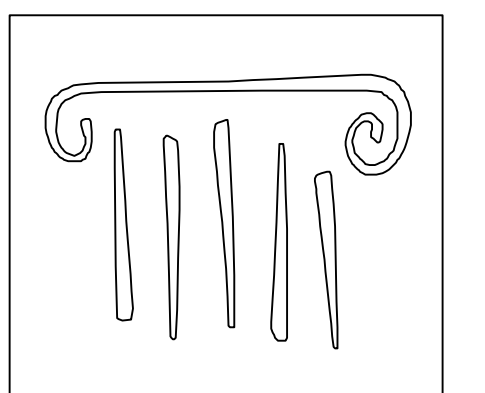

PORT CITY ARCHITECTURE

65 NEWBURY STREET
 PORTLAND, ME 04101
 207.761.9000
 fax: 207.761.2010
 lita@portcityarch.com

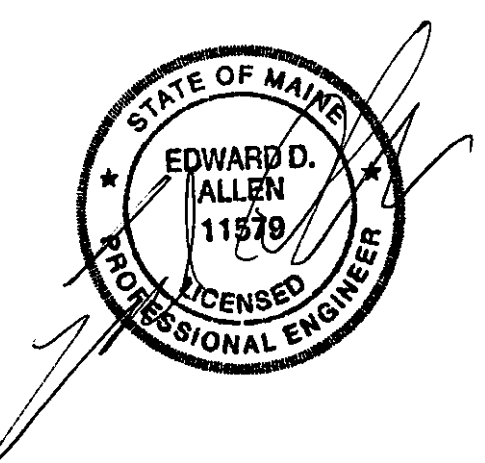

VANZELM ENGINEERS

VANZELM HEYWOOD & SHADFORD, INC.
 10 TALCOTT NOTCH FARMINGTON, CT 06032
 TEL: (860)284-5064 FAX: (860)284-5066
 PROJECT NO.: 2007120.00

BECKER structural engineers, inc.

SYTDesign CONSULTANTS
 CIVIL ENGINEERING & LANDSCAPE ARCHITECTURE

ALLIED/COOK CONSTRUCTION

Favreau Electric

Titan Mechanical, Inc.
 Design-Build Engineering - Mechanical Contracting

| # | DATE | DESCRIPTION |
|---|----------|----------------|
| | | PERMIT SET |
| | 01/24/08 | Date Issued |
| | 06506 | Project Number |

SHEET NAME
ELECTRICAL POWER PLAN - MECH. MEZZANINE
 Drawn By: AMM
 Checked By: MER

EP1.5