

IF THIS SHEET IS NOT 24 X 36 IT IS A REDUCED SCALE PRINT - SCALE ACCORDINGLY

3
2
1
0
SCALE
1"=1'


4
3
2
1
0
SCALE
3/4"=1'

6'
5'
4'
3'
2'
1'
0
SCALE
1/2"=1'

12
8
4
0
SCALE
1/4"=1'


20
10
0
SCALE
1/8"=1'

40
20
0
SCALE
1/16"=1'

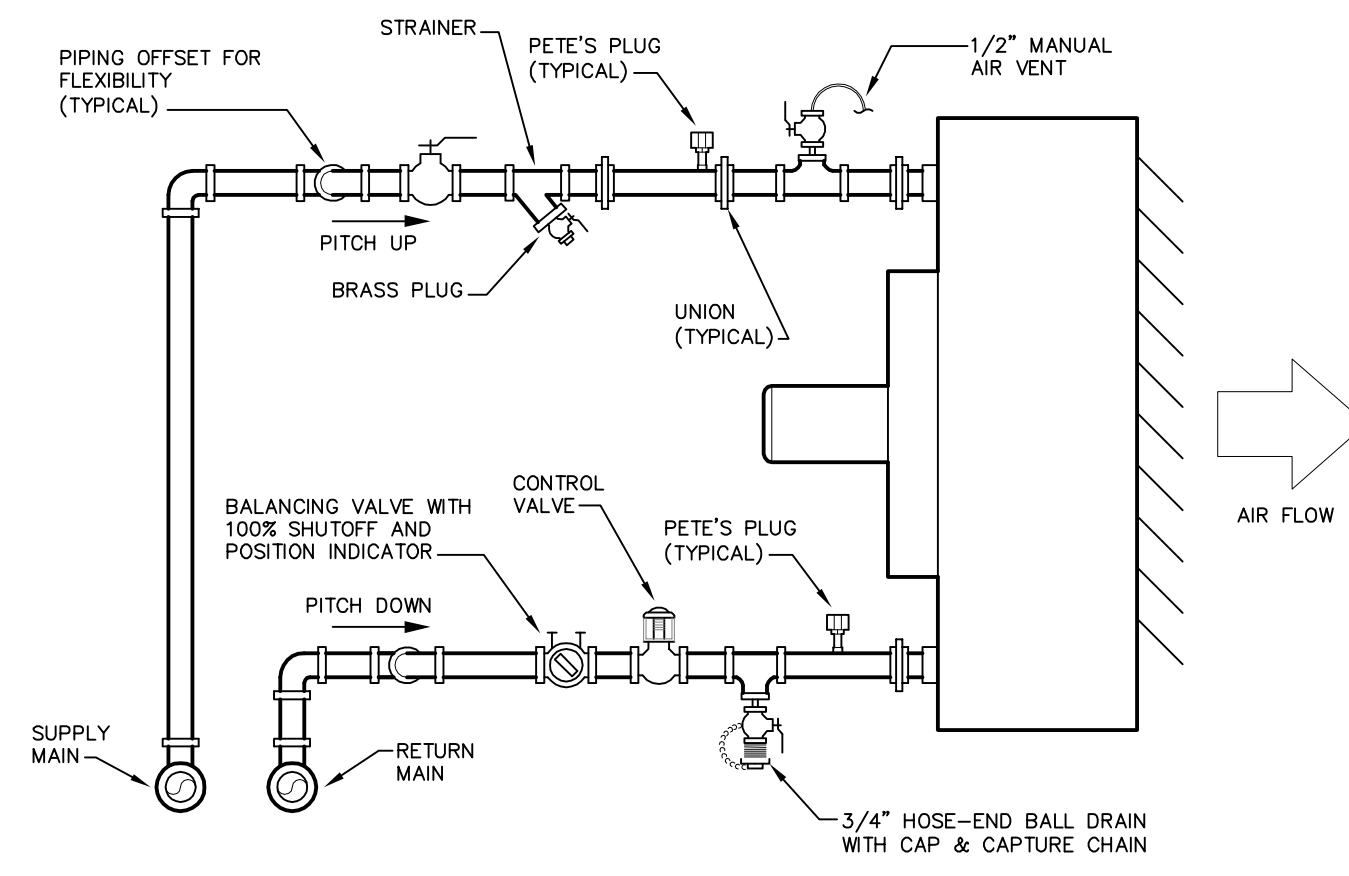


HORIZONTAL HOT WATER UNIT HEATER PIPING DIAGRAM
NOT TO SCALE


NOTES:
1. THIS DETAIL IS DIAGRAMMATIC ONLY. ARRANGE PIPING TO FACILITATE COIL REMOVAL AND SO AS NOT TO OBSTRUCT ADJACENT EQUIPMENT. FOR FLANGED INSTALLATION OMIT UNIONS.

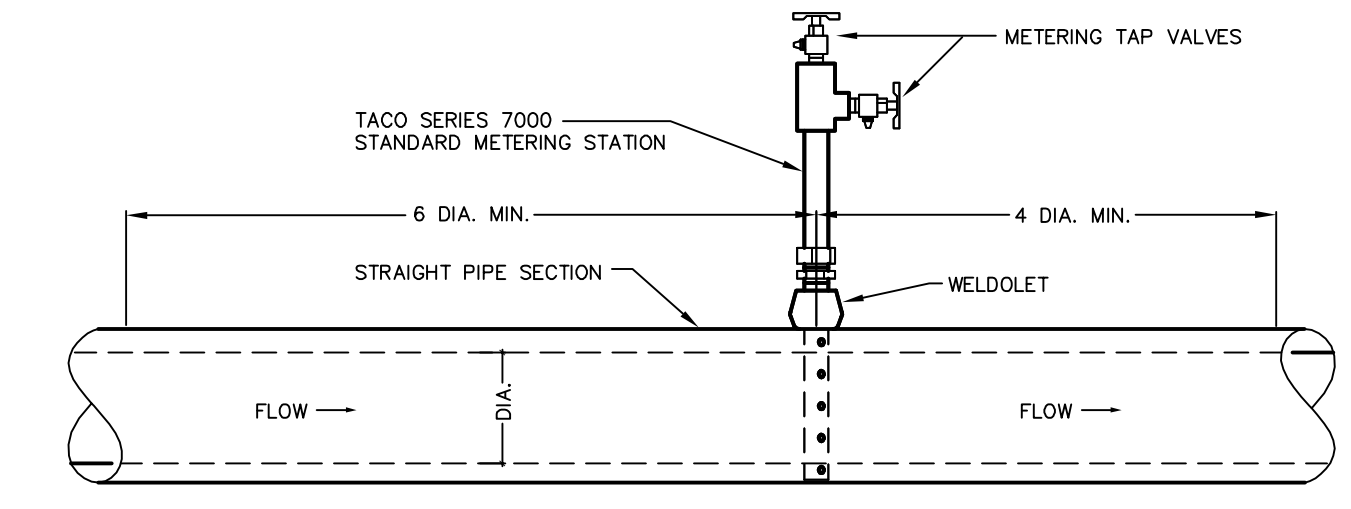


FLOW MEASURING DEVICE INSTALLATION

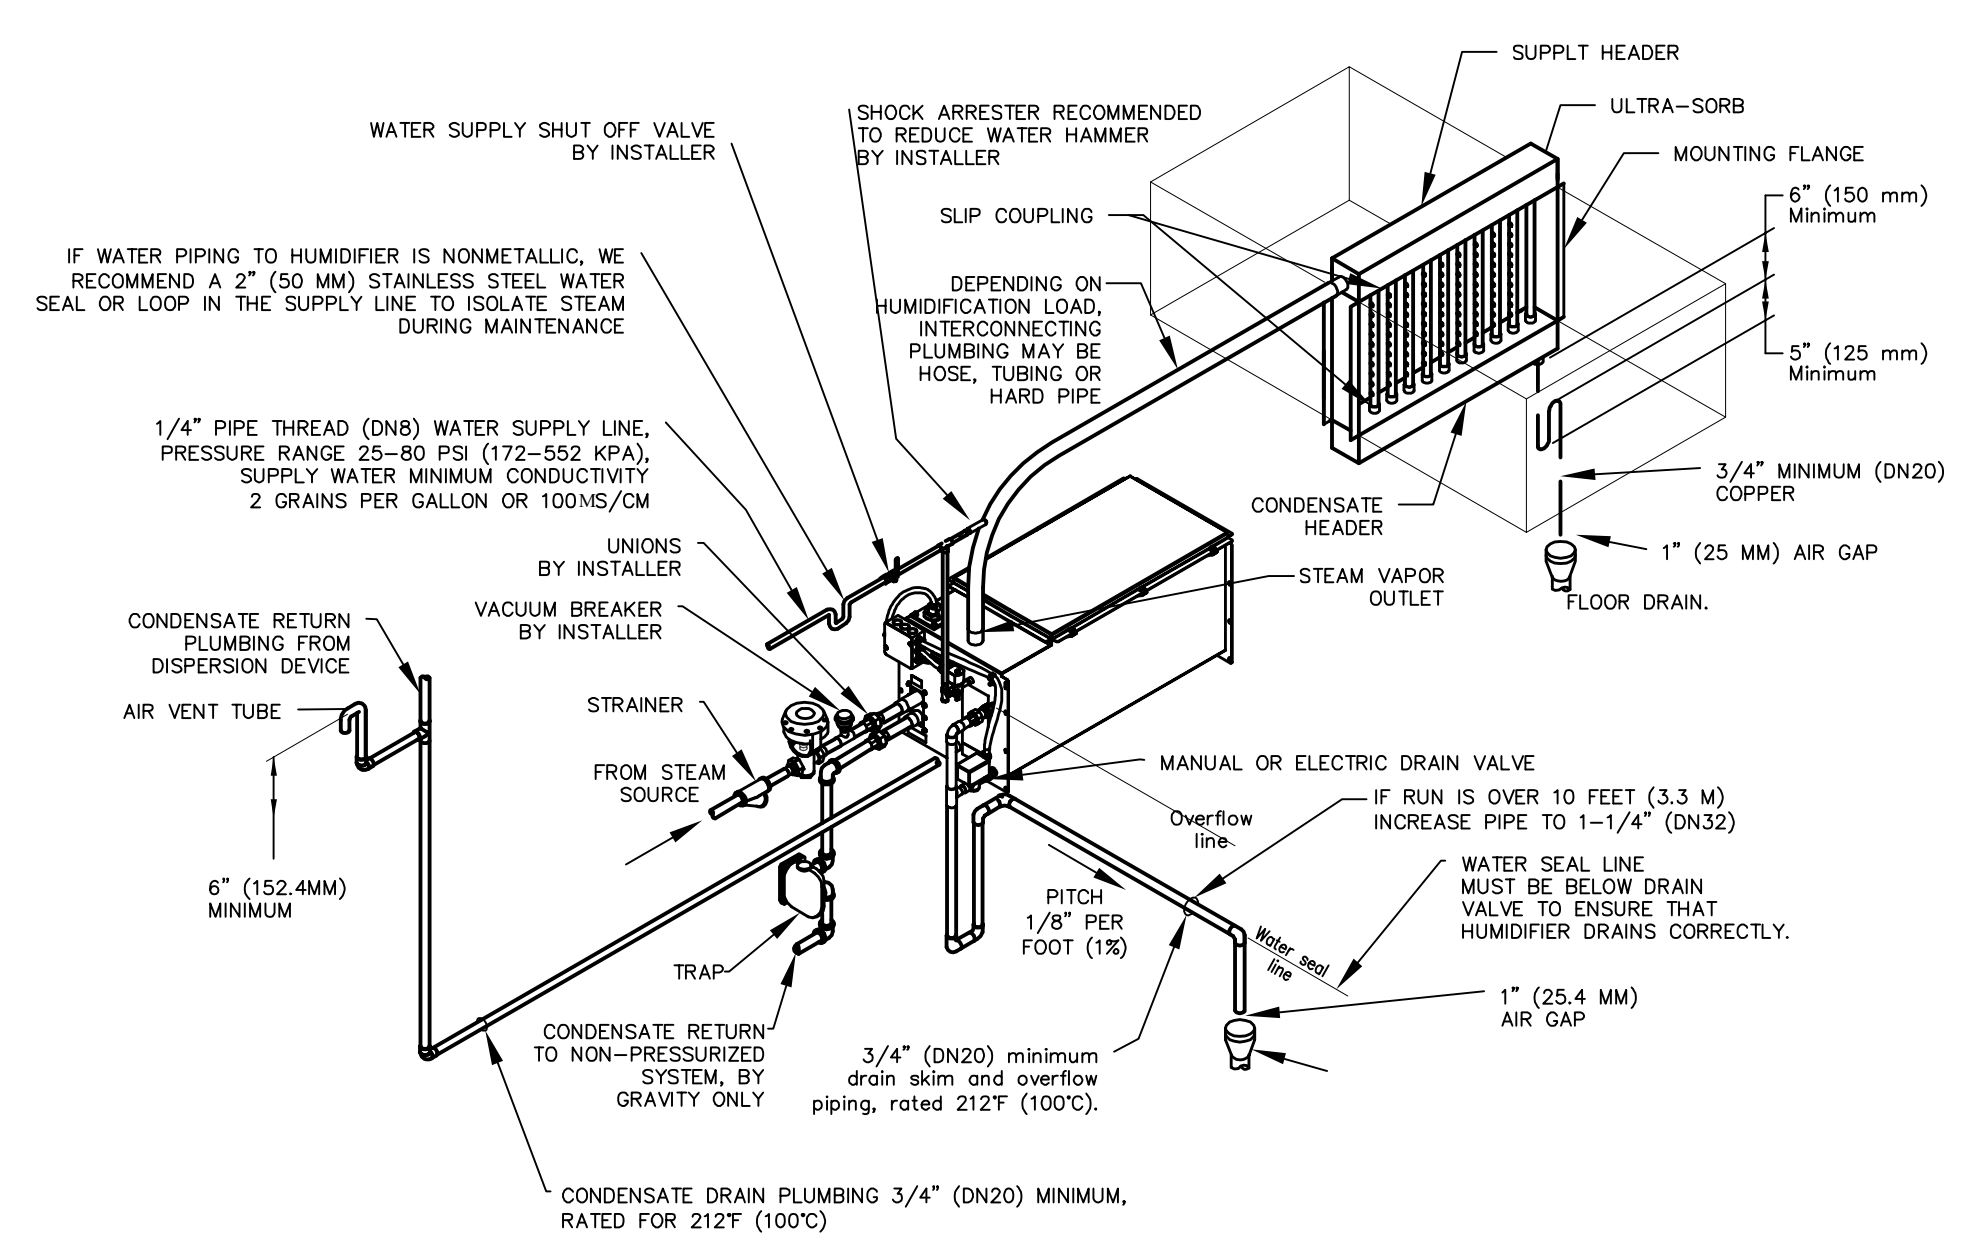


STEAM TO STEAM HUMIDIFIER DETAIL (H-1 ALTERNATE)
NOT TO SCALE

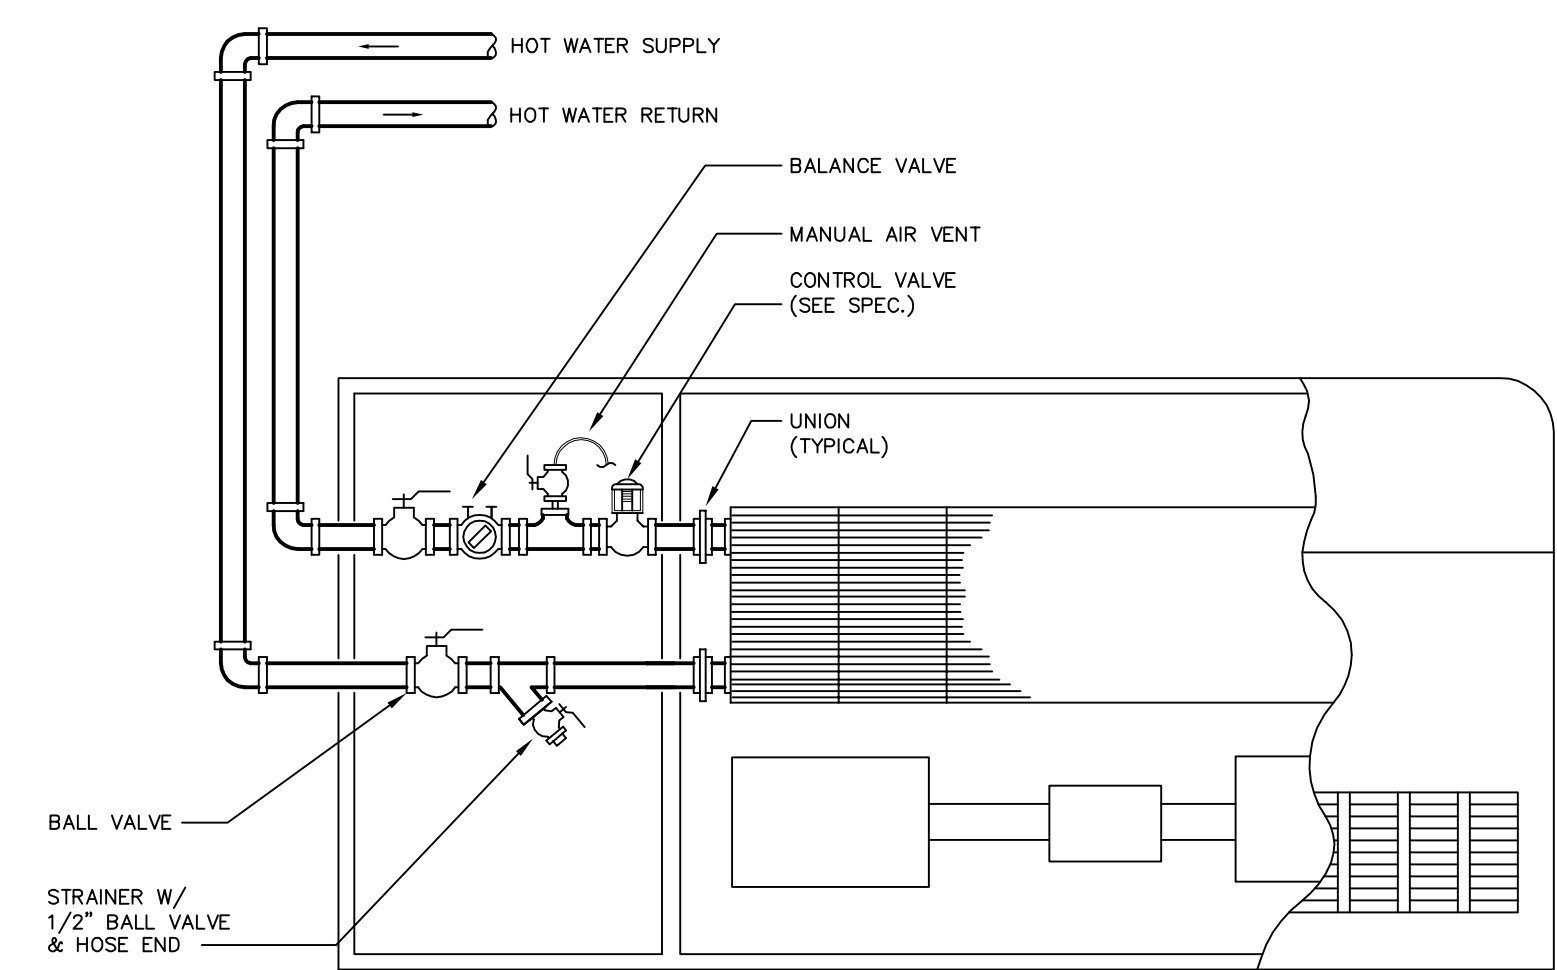

HOT WATER CABINET UNIT HEATER PIPING DETAIL (DOWNFEED)
NOT TO SCALE

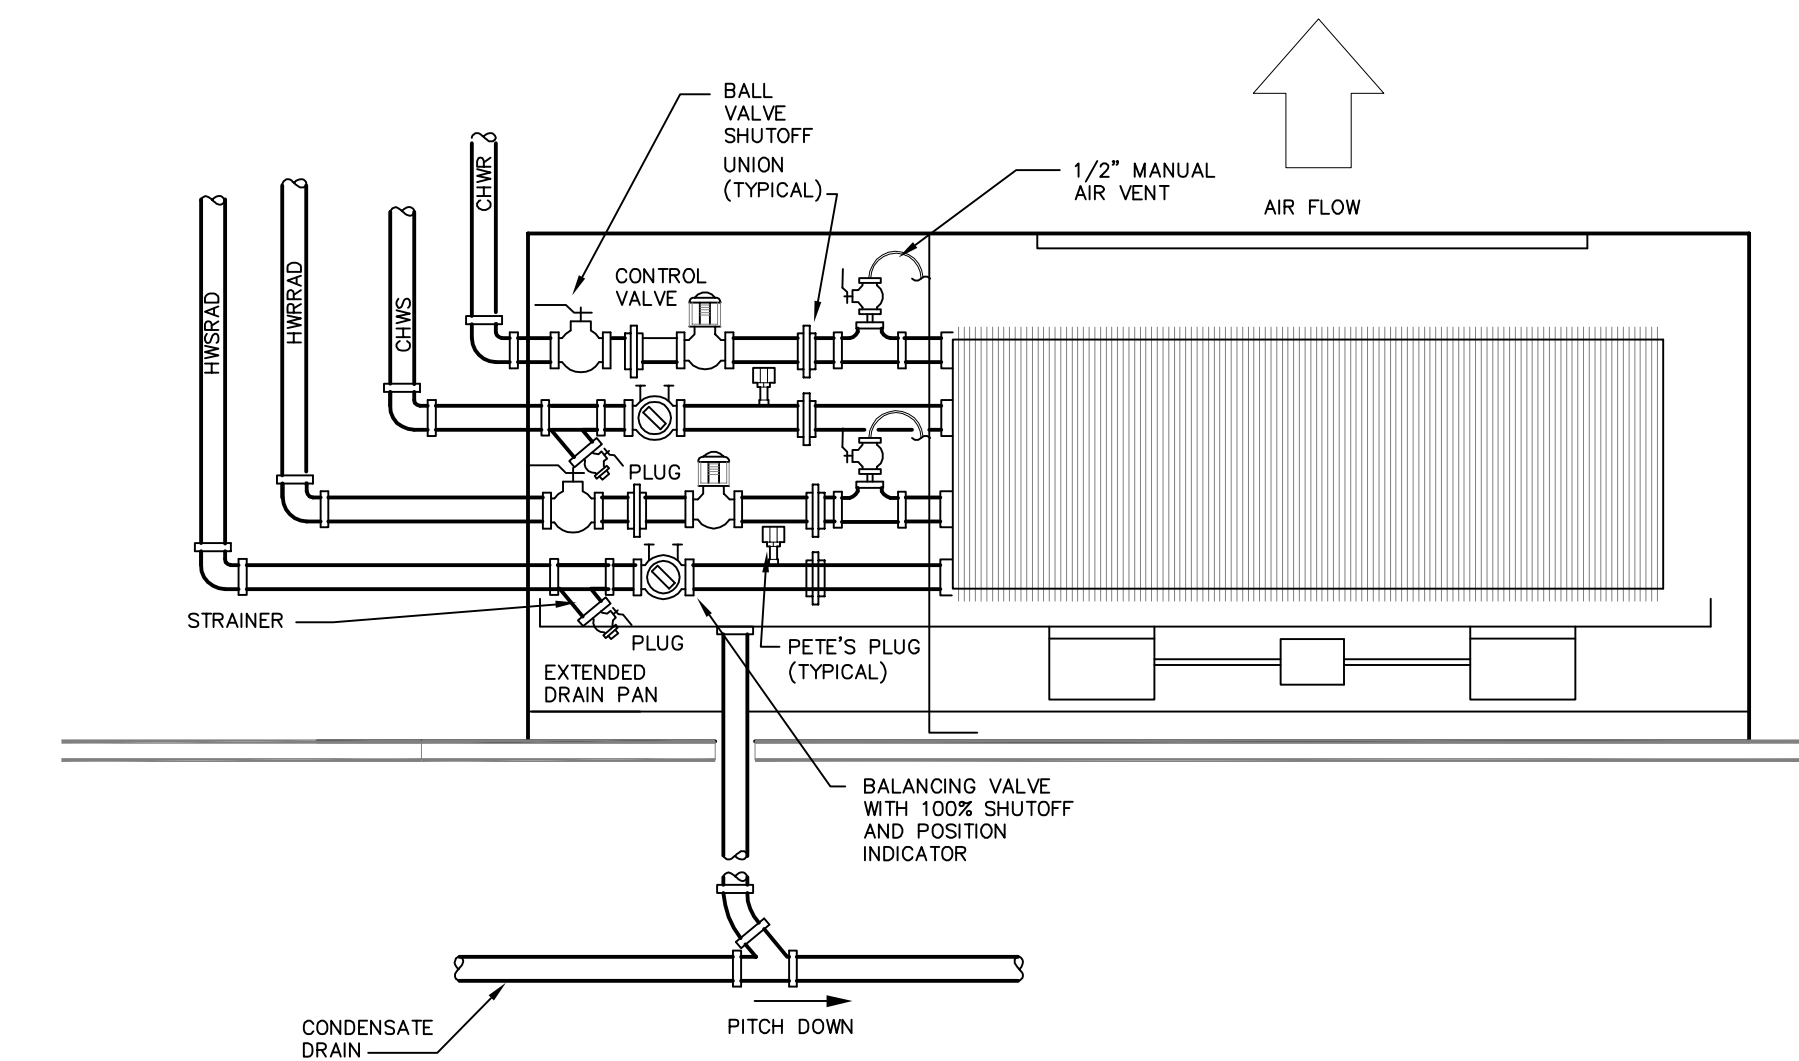


FAN-COIL UNIT PIPING (4-PIPE SYSTEM)
NOT TO SCALE

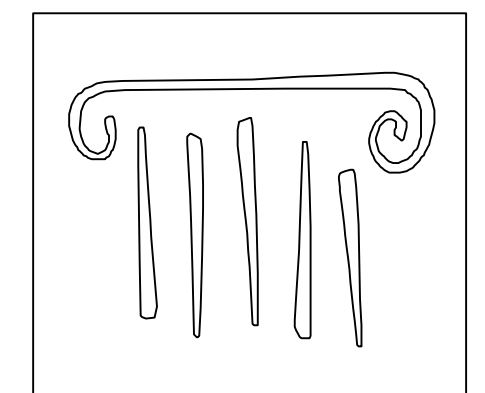

PORT CITY ARCHITECTURE

65 NEWBURY STREET
PORTLAND, ME 04101
207.761.9000
fax: 207.761.2010
lita@portcityarch.com

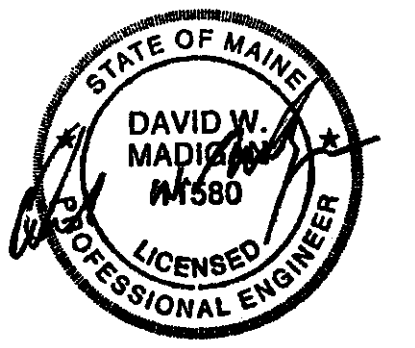


VANZELM ENGINEERS

VANZELM HEYWOOD & SHADFORD, INC.
16 TALCOTT NOTCH FARMINGTON, CT 06032
TEL: (860) 296-3964 FAX: (860) 296-3968
PROJECT NO.: 2007120.00

BECKER
structural engineers, inc.

SYTDesign
CONSULTANTS
CIVIL ENGINEERING & LANDSCAPE ARCHITECTURE

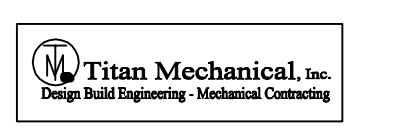

#	DATE	DESCRIPTION
		PERMIT SET
	Date Issued	01/24/08
	Project Number	06506

SHEET NAME
MECHANICAL DETAILS

Drawn By
AMM
Checked By
DWM/FBH

M4.5

PERMIT SET - NOT FOR CONSTRUCTION