

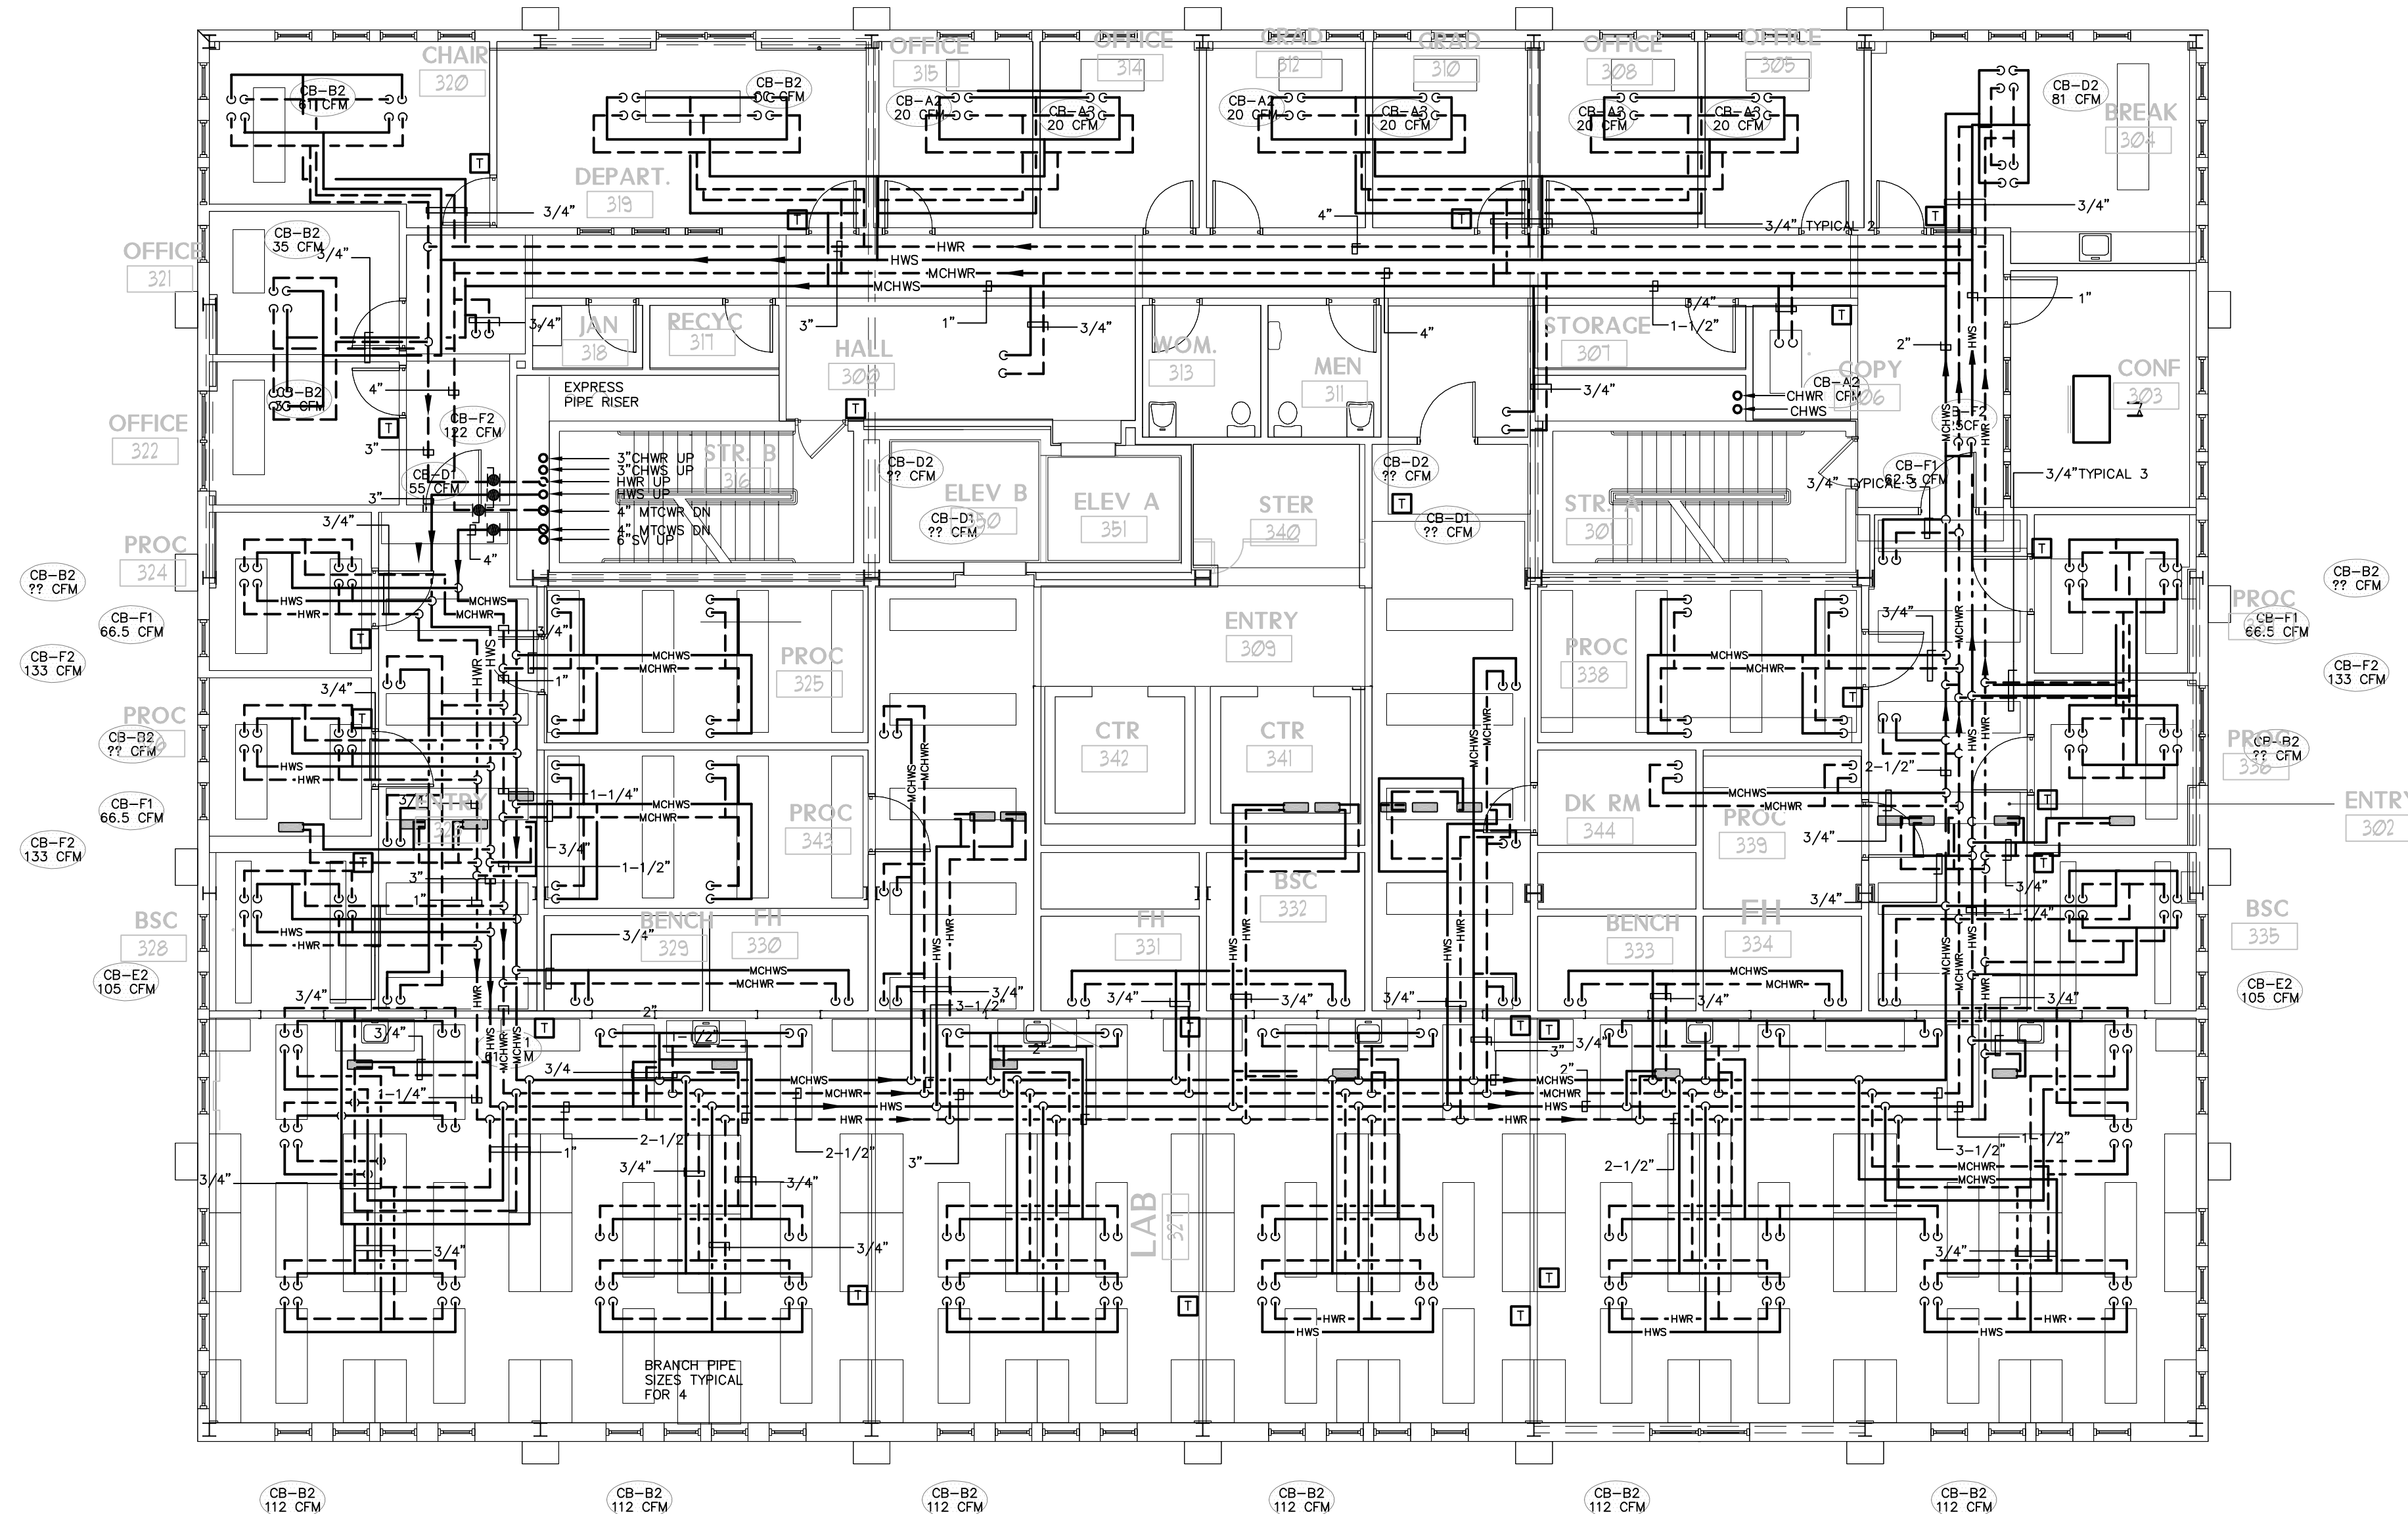


IF THIS SHEET IS NOT 24 X 36 IT IS A REDUCED SCALE PRINT - SCALE ACCORDINGLY

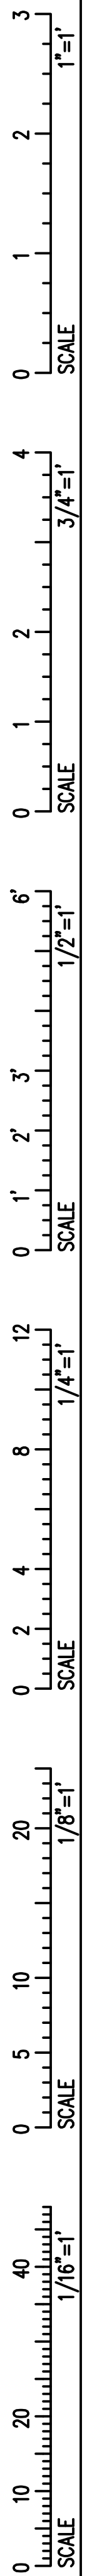


MECHANICAL PIPING THIRD FLOOR PLAN
 Scale: 1/8"=1'-0"

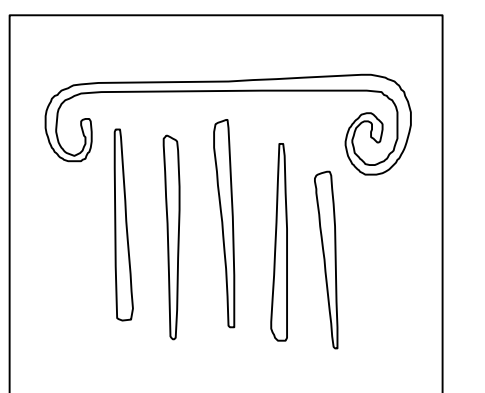

PORT CITY ARCHITECTURE

65 NEWBURY STREET
 PORTLAND, ME 04101
 207.761.9000
 fax: 207.761.2010
 lita@portcityarch.com

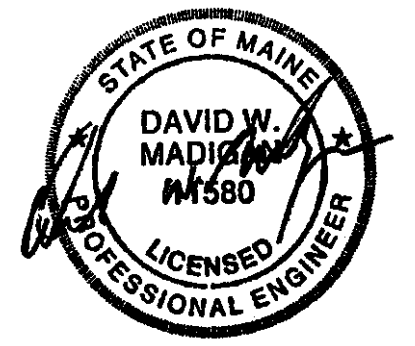

VANZELM ENGINEERS

VANZELM HEYWOOD & SHADFORD, INC.
 10 TALCOTT NOTCH FARMINGTON, CT 06032
 TEL:(860)284-2064 FAX:(860)284-2066
 PROJECT NO.: 2007120.00

BECKER
 structural engineers, inc.

SYTDesign
 CONSULTANTS
 CIVIL ENGINEERING & LANDSCAPE ARCHITECTURE



#	DATE	DESCRIPTION
		PERMIT SET
	01/24/08	Date Issued
	06506	Project Number

SHEET NAME
**MECHANICAL PIPING
 THIRD FLOOR PLAN**

Drawn By
 WGS
 Checked By
 DW/MFBH

MP1.4

PERMIT SET - NOT FOR CONSTRUCTION

