

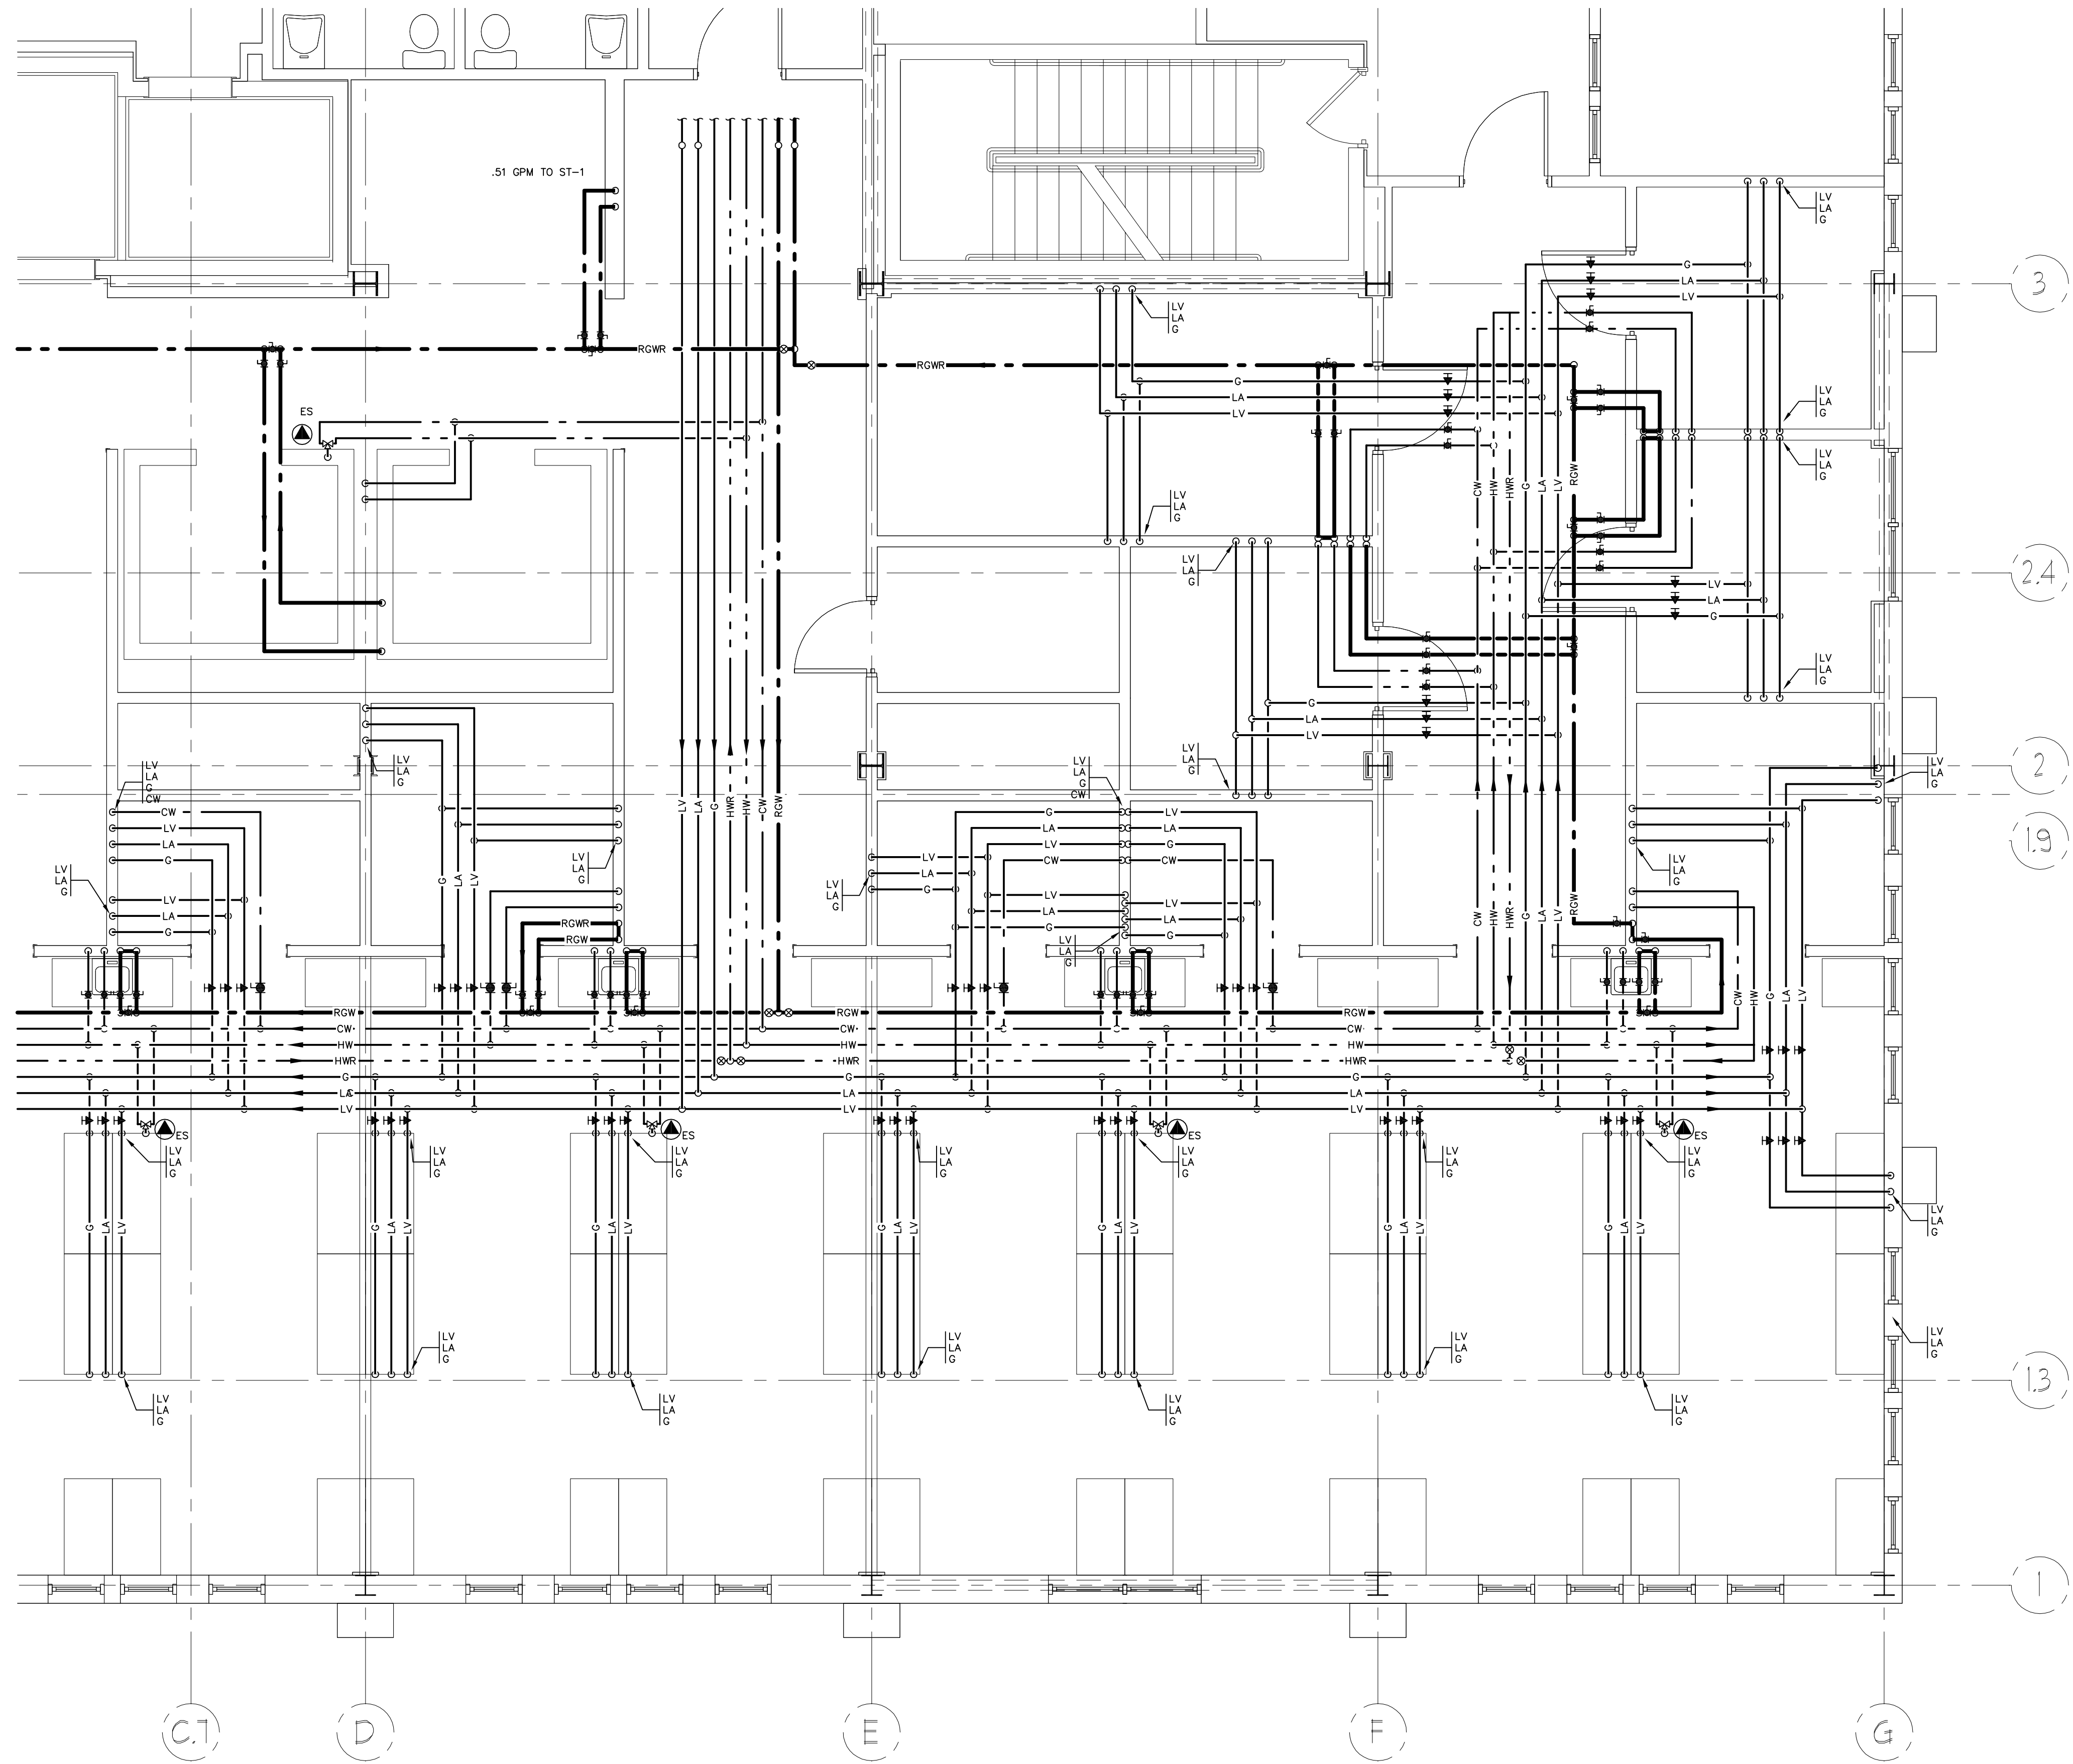


IF THIS SHEET IS NOT 24 X 36 IT IS A REDUCED SCALE PRINT - SCALE ACCORDINGLY

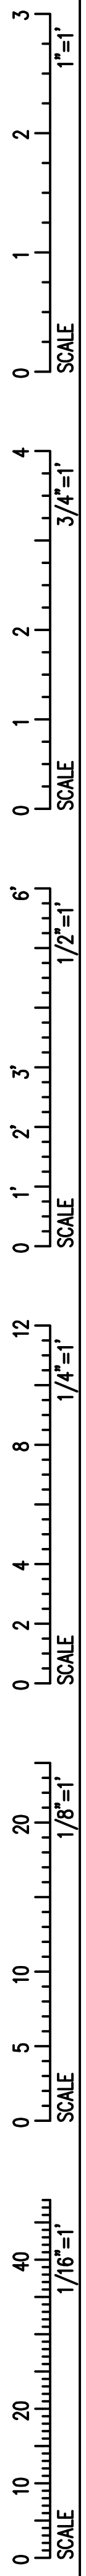


1 PLUMBING THIRD FLOOR PLAN - ENLARGED
Scale: 1/8"=1'-0"

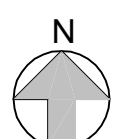

PERMIT SET - NOT FOR CONSTRUCTION

PORT CITY ARCHITECTURE
65 NEWBURY STREET
PORTLAND, ME 04101
207.761.9000
fax: 207.761.2010
lita@portcityarch.com

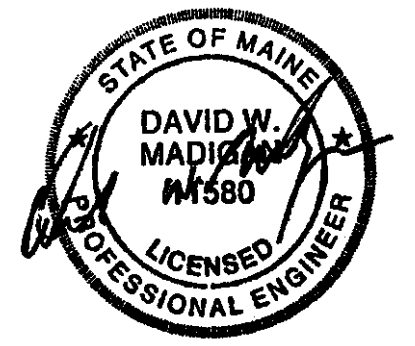

VANZELM ENGINEERS
VANZELM HEYWOOD & SHADFORD, INC.
10 TALCOTT NOYSE FARMINGTON, CT 06032
TEL: (860) 284-2064 FAX: (860) 284-2066
PROJECT NO.: 2007120.00

BECKER
structural engineers, inc.

SYTDesign
CONSULTANTS
CIVIL ENGINEERING & LANDSCAPE ARCHITECTURE

Titan Mechanical, Inc.
Design-Build Engineering - Mechanical Contracting

#	DATE	DESCRIPTION
		PERMIT SET
	01/24/08	Date Issued
	06506	Project Number

SHEET NAME
PLUMBING THIRD FLOOR PLAN ENLARGED - A

Drawn By: **SMS**
Checked By: **FBH**

P2.0