

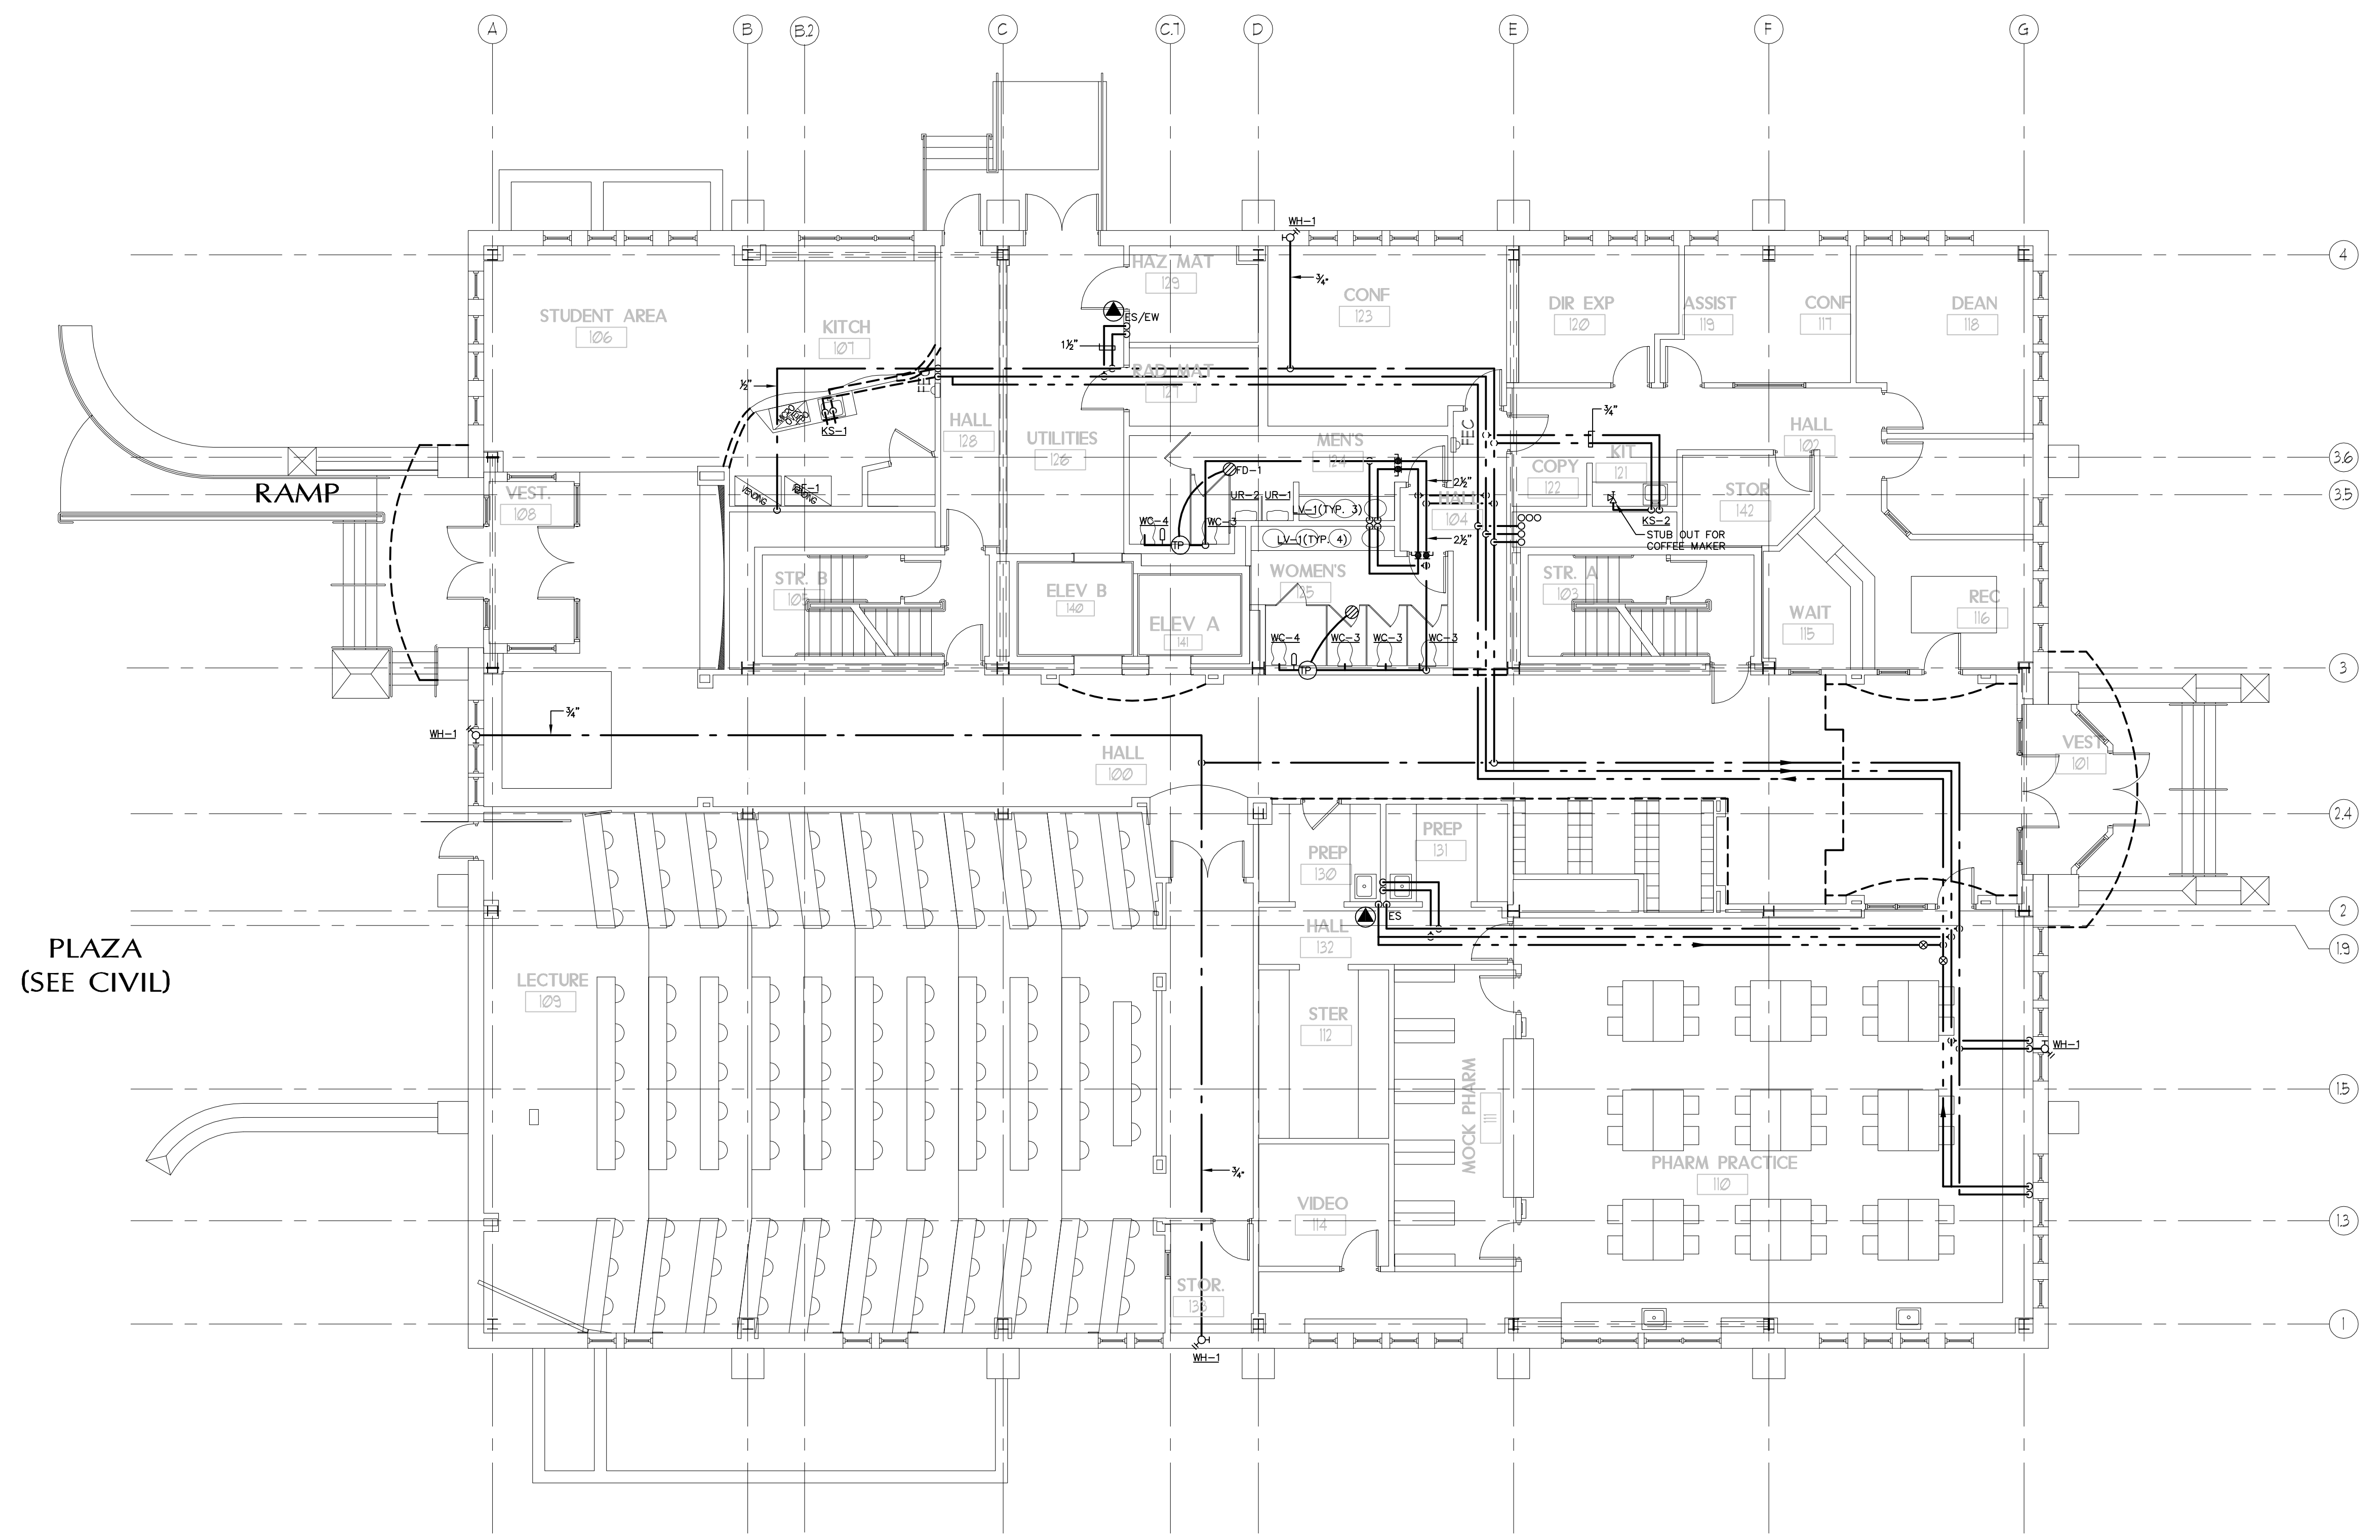


IF THIS SHEET IS NOT 24 X 36 IT IS A REDUCED SCALE PRINT - SCALE ACCORDINGLY

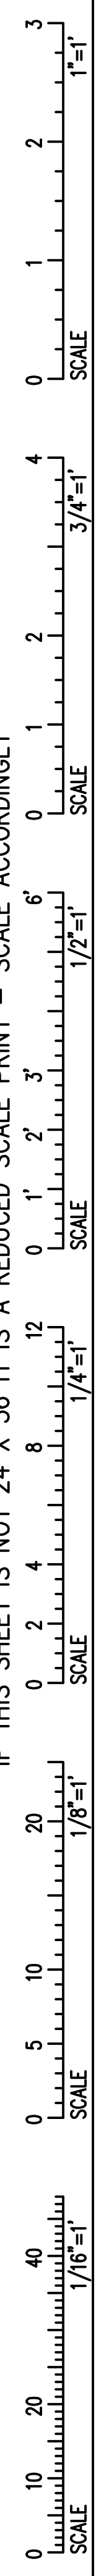


**1 PLUMBING FIRST FLOOR PLAN - SUPPLY**  
 Scale: 1/8"=1'-0"

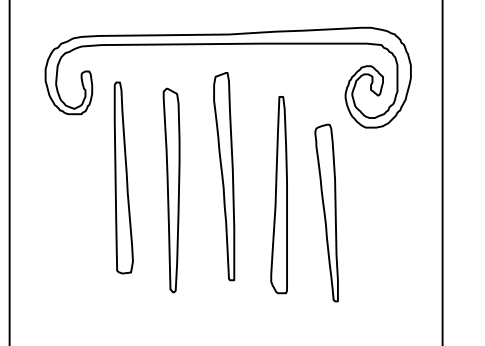

**PORT CITY ARCHITECTURE**

65 NEWBURY STREET  
 PORTLAND, ME 04101  
 207.761.9000  
 fax: 207.761.2010  
 lita@portcityarch.com

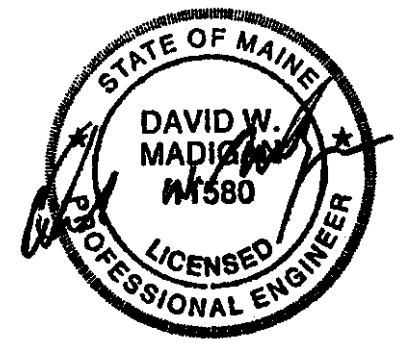

**VANZELM ENGINEERS**

VANZELM HEYWOOD & SHADFORD, INC.  
 10 TALCOTT NOYCE FARMINGTON, CT 06032  
 TEL: (860)284-5064 FAX: (860)284-5066  
 PROJECT NO.: 2007120.00

**BECKER**  
 structural engineers, inc.

**SYTDesign**  
 CONSULTANTS  
 CIVIL ENGINEERING & LANDSCAPE ARCHITECTURE




#	DATE	DESCRIPTION
		PERMIT SET
	01/24/08	Date Issued
	06506	Project Number

**PLUMBING FIRST FLOOR PLAN SUPPLY**

Drawn By: SHS  
 Checked By: DUM

**PS1.2**

**PERMIT SET - NOT FOR CONSTRUCTION**

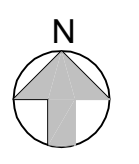

COPYRIGHT: Reuse or reproduction of the contents of this document is not permitted without written permission of PORT CITY ARCHITECTURE PA