

PORT CITY ARCHITECTURE

65 NEWBURY STREET
 PORTLAND, ME 04101
 207.761.9000
 fax: 207.761.2010
 lita@portcityarch.com

VANZELM ENGINEERS

VANZELM HEYWOOD & SHADFORD, INC.
 10 TALCOTT NOTCH FARMINGTON, CT 06032
 TEL: (860) 284-1064 FAX: (860) 284-1098

PROJECT NO.: 2007120.00

BECKER
 structural engineers, inc.

SYTDesign
 CONSULTANTS
 CIVIL ENGINEERING & LANDSCAPE ARCHITECTURE

ALLIED/COOK
 CONSTRUCTION

Faireau

Titan Mechanical, Inc.
 Design Build Engineering - Mechanical Contractors

UNIVERSITY OF NEW ENGLAND

COLLEGE OF PHARMACY

716 STEVENS AVENUE,
 PORTLAND, ME

#	DATE	DESCRIPTION
		BID SET
	Date Issued	02/08/08
	Project Number	06506


SHEET NAME
MECHANICAL LOWER LEVEL PLAN

Drawn By
 WGS
 Checked By
 DW/MFBH

M1.0

BID SET - NOT FOR CONSTRUCTION

COPYRIGHT: Reuse or reproduction of the contents of this document is not permitted without written permission of PORT CITY ARCHITECTURE PA

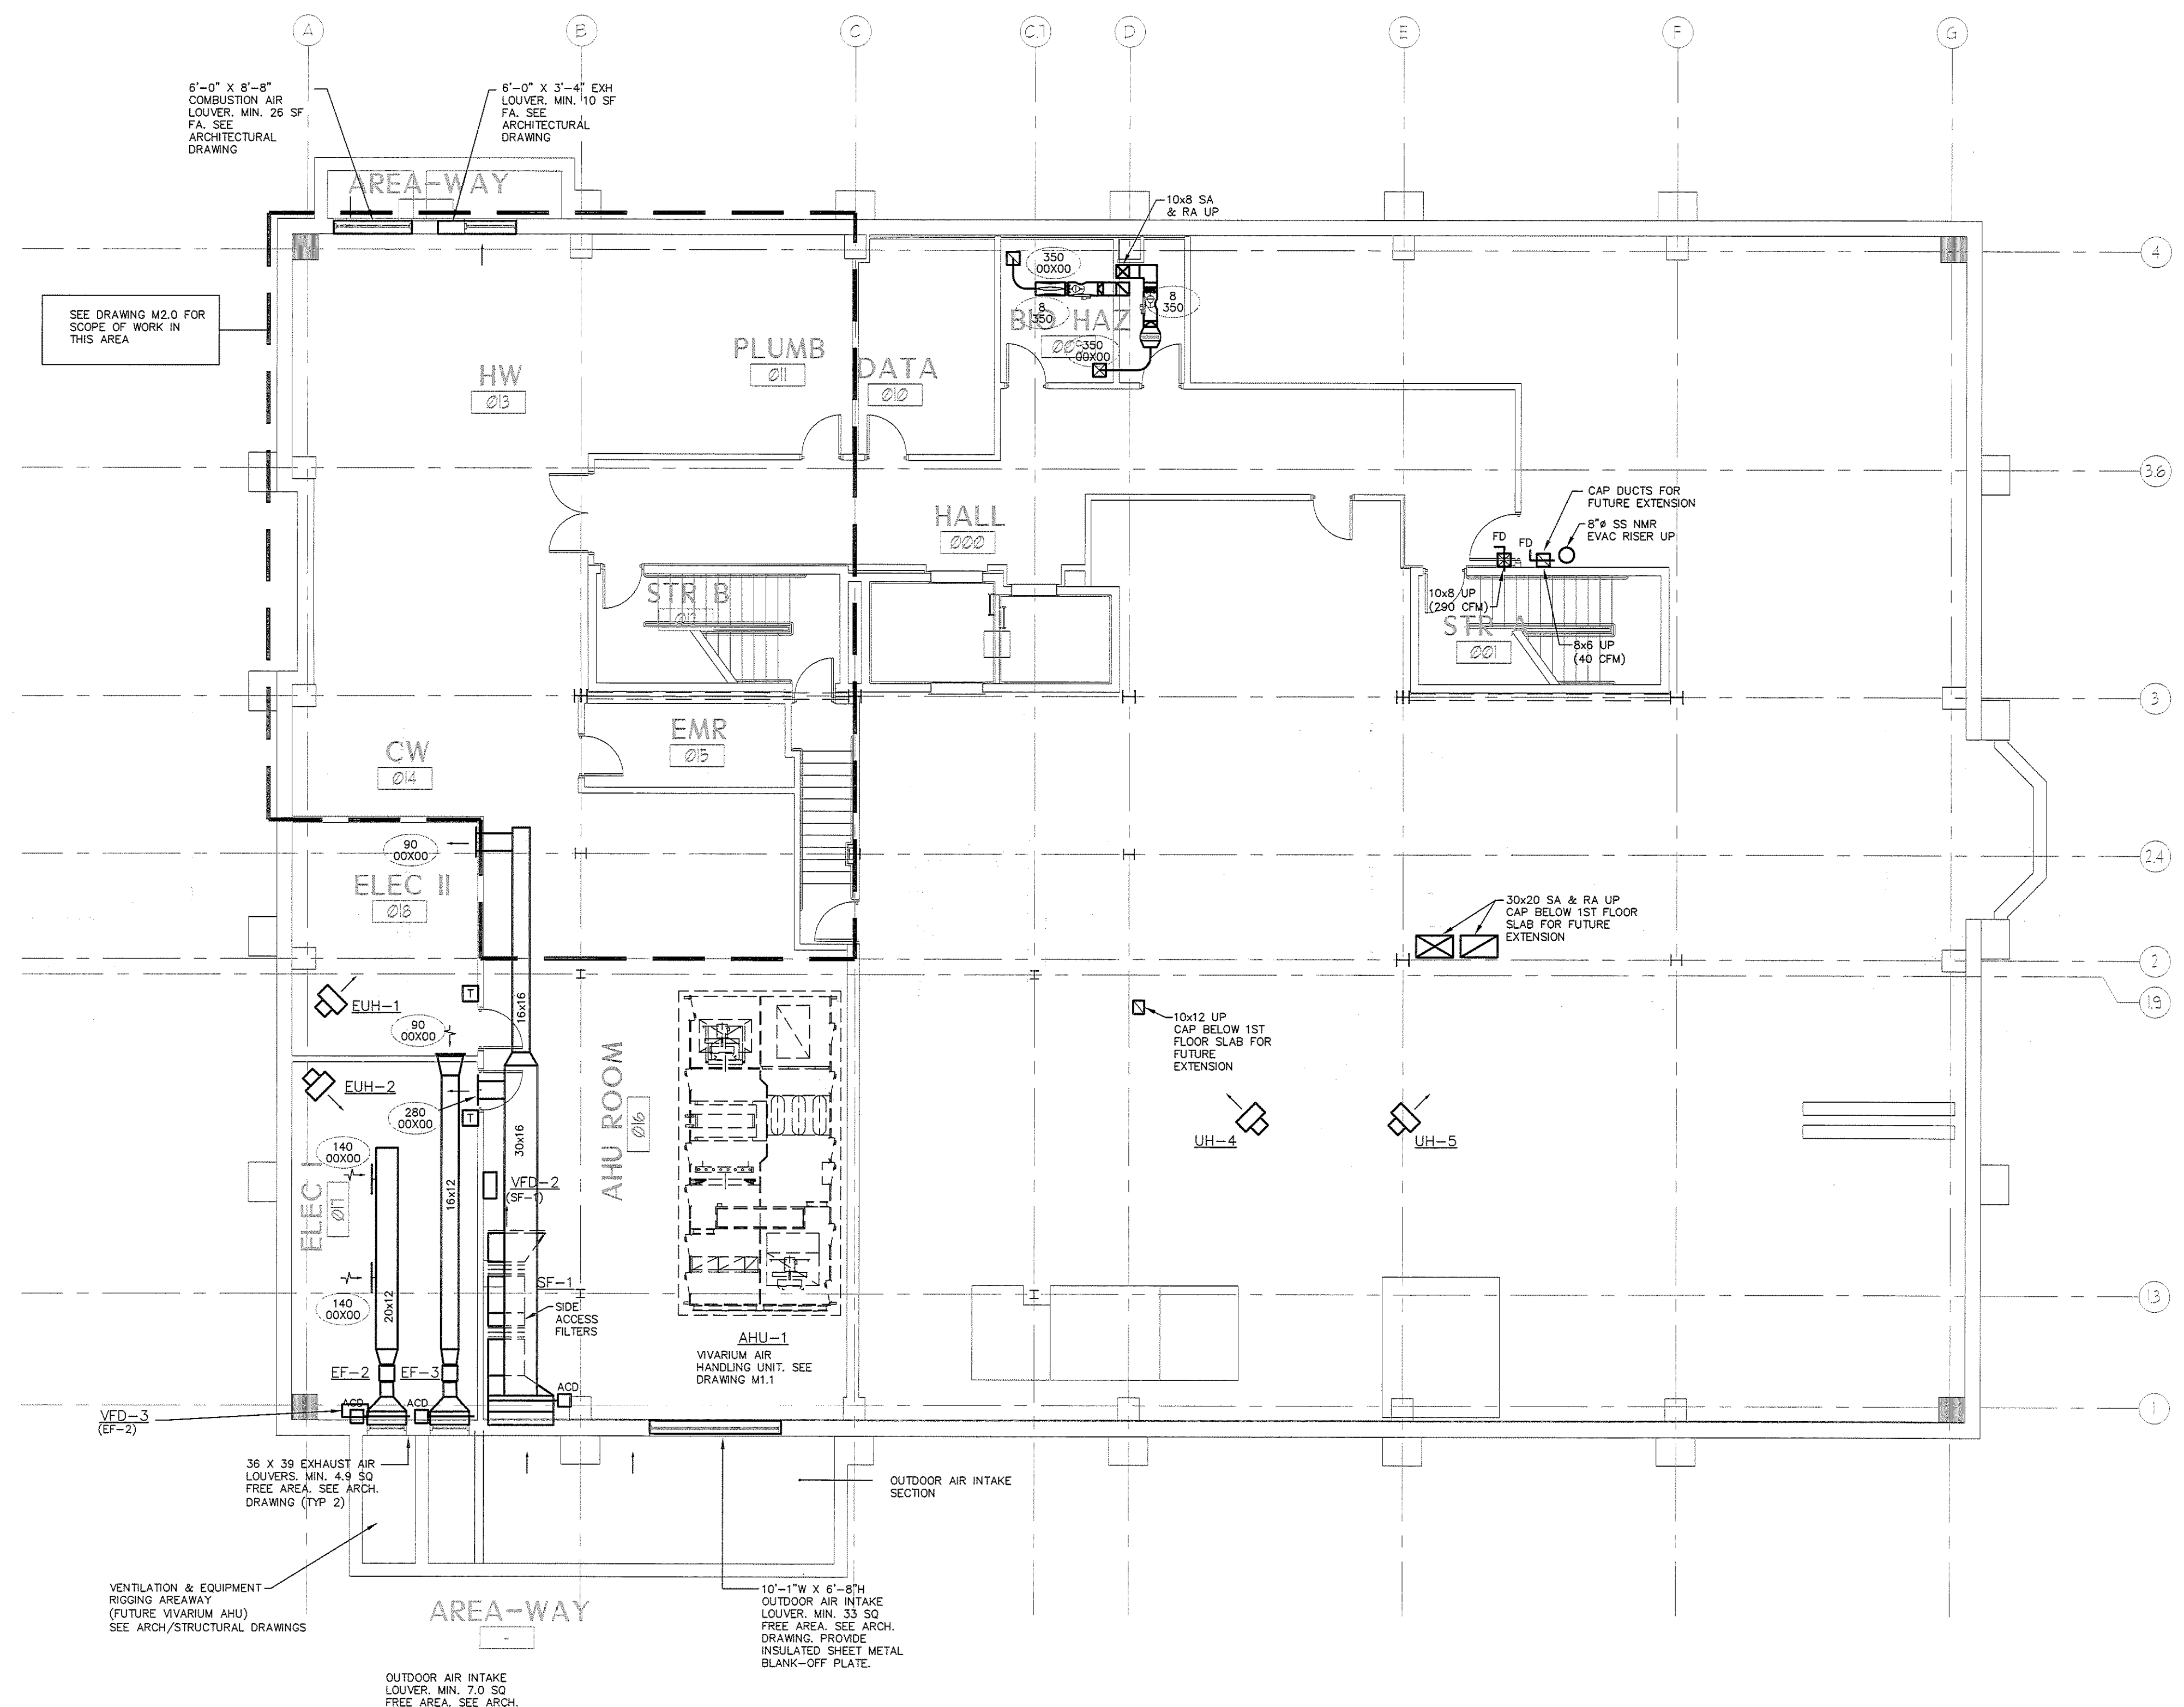

1 MECHANICAL LOWER LEVEL FLOOR PLAN
 Scale: 1/8"=1'-0"

IF THIS SHEET IS NOT 24 X 36 IT IS A REDUCED SCALE PRINT - SCALE ACCORDINGLY

Scale 1"=1' (0 to 3)
 Scale 3/4"=1' (0 to 4)
 Scale 1/2"=1' (0 to 6)
 Scale 1/4"=1' (0 to 12)
 Scale 1/8"=1' (0 to 20)
 Scale 1/16"=1' (0 to 40)

