

PORT CITY ARCHITECTURE

65 NEWBURY STREET
 PORTLAND, ME 04101
 207.761.9000
 fax: 207.761.2010
 lita@portcityarch.com

VANZELM ENGINEERS

VANZELM HEYWOOD & SHADFORD, INC.
 15 TALCOTT NOTCH FARMINGTON, CT 06032
 TEL: (860) 284-3994 FAX: (860) 284-3999

PROJECT NO.: 2007120.00

BECKER
 structural engineers, inc.

SYTDesign CONSULTANTS
 CIVIL ENGINEERING & LANDSCAPE ARCHITECTURE

ALLIED/COOK CONSTRUCTION

Faireau
 electrical

Titan Mechanical, Inc.
 Design-Build Engineering - Mechanical Contracting

UNIVERSITY OF NEW ENGLAND

COLLEGE OF PHARMACY

716 STEVENS AVENUE,
 PORTLAND, ME

3
2
1
0
SCALE
1"=1'


4
2
0
SCALE
3/4"=1'

6
3
0
SCALE
1/2"=1'

12
8
4
0
SCALE
1/4"=1'

20
10
0
SCALE
1/8"=1'

40
20
0
SCALE
1/16"=1'

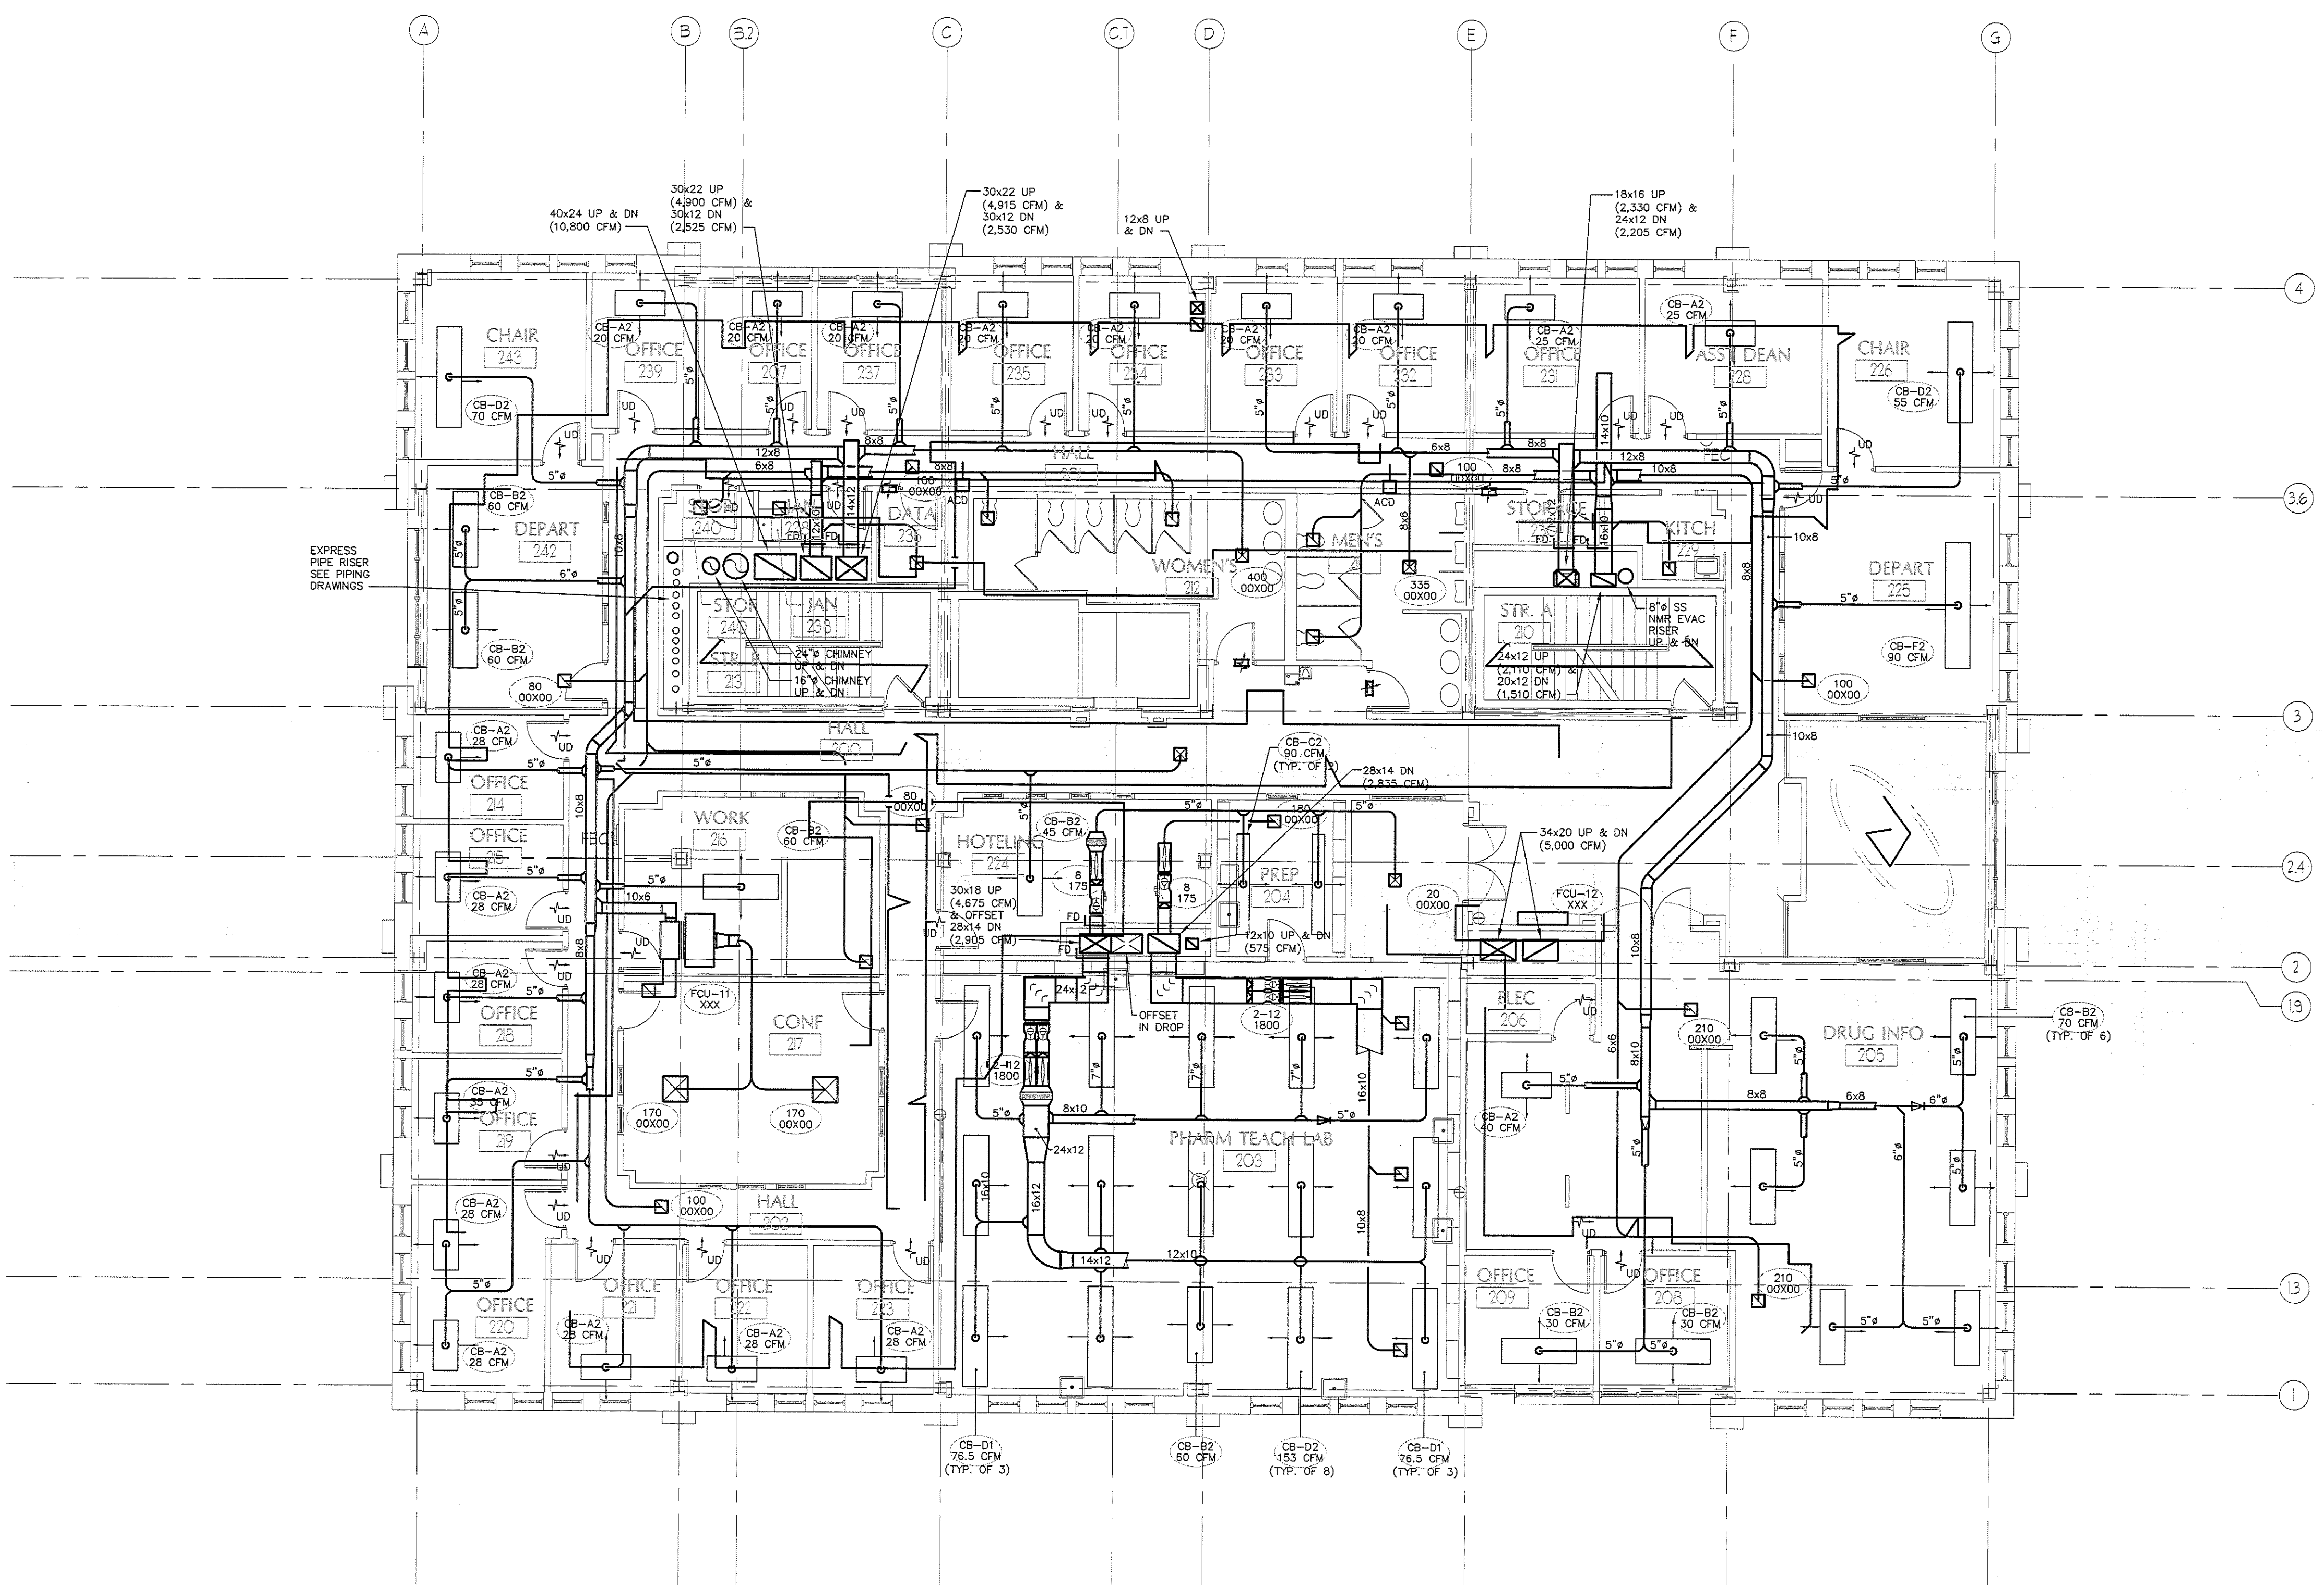

1 MECHANICAL SECOND FLOOR PLAN
 Scale: 1/8"=1'-0"

BID SET - NOT FOR CONSTRUCTION

#	DATE	DESCRIPTION
		BID SET
	01/08/08	Date Issued
	06506	Project Number

SHEET NAME
MECHANICAL SECOND FLOOR PLAN

Drawn By
 WGS
 Checked By
 DWM/FSB
M1.3