

PORT CITY ARCHITECTURE

65 NEWBURY STREET
 PORTLAND, ME 04101
 207.761.9000
 fax: 207.761.2010
 lita@portcityarch.com

VANZELM ENGINEERS

VANZELM HEYWOOD & SHADLOW, INC.
 19 TALCOTT NOTCH FARMINGTON, CT 06032
 TEL: 860.234.0066 FAX: 860.234.0066

PROJECT NO.: 2007120.00

BECKER
 structural engineers, inc.

SYTDesign CONSULTANTS
 CIVIL ENGINEERING & LANDSCAPE ARCHITECTURE

ALLIED/COOK CONSTRUCTION

Favreau
 GROUP

Titan Mechanical, Inc.
 Design-Build Engineering - Mechanical Contracting


UNIVERSITY OF NEW ENGLAND

COLLEGE OF PHARMACY


716 STEVENS AVENUE,
 PORTLAND, ME

IF THIS SHEET IS NOT 24 X 36 IT IS A REDUCED SCALE PRINT - SCALE ACCORDINGLY

SCALE 1"=1'
 SCALE 3/4"=1'
 SCALE 1/2"=1'
 SCALE 1/4"=1'
 SCALE 1/8"=1'
 SCALE 1/16"=1'

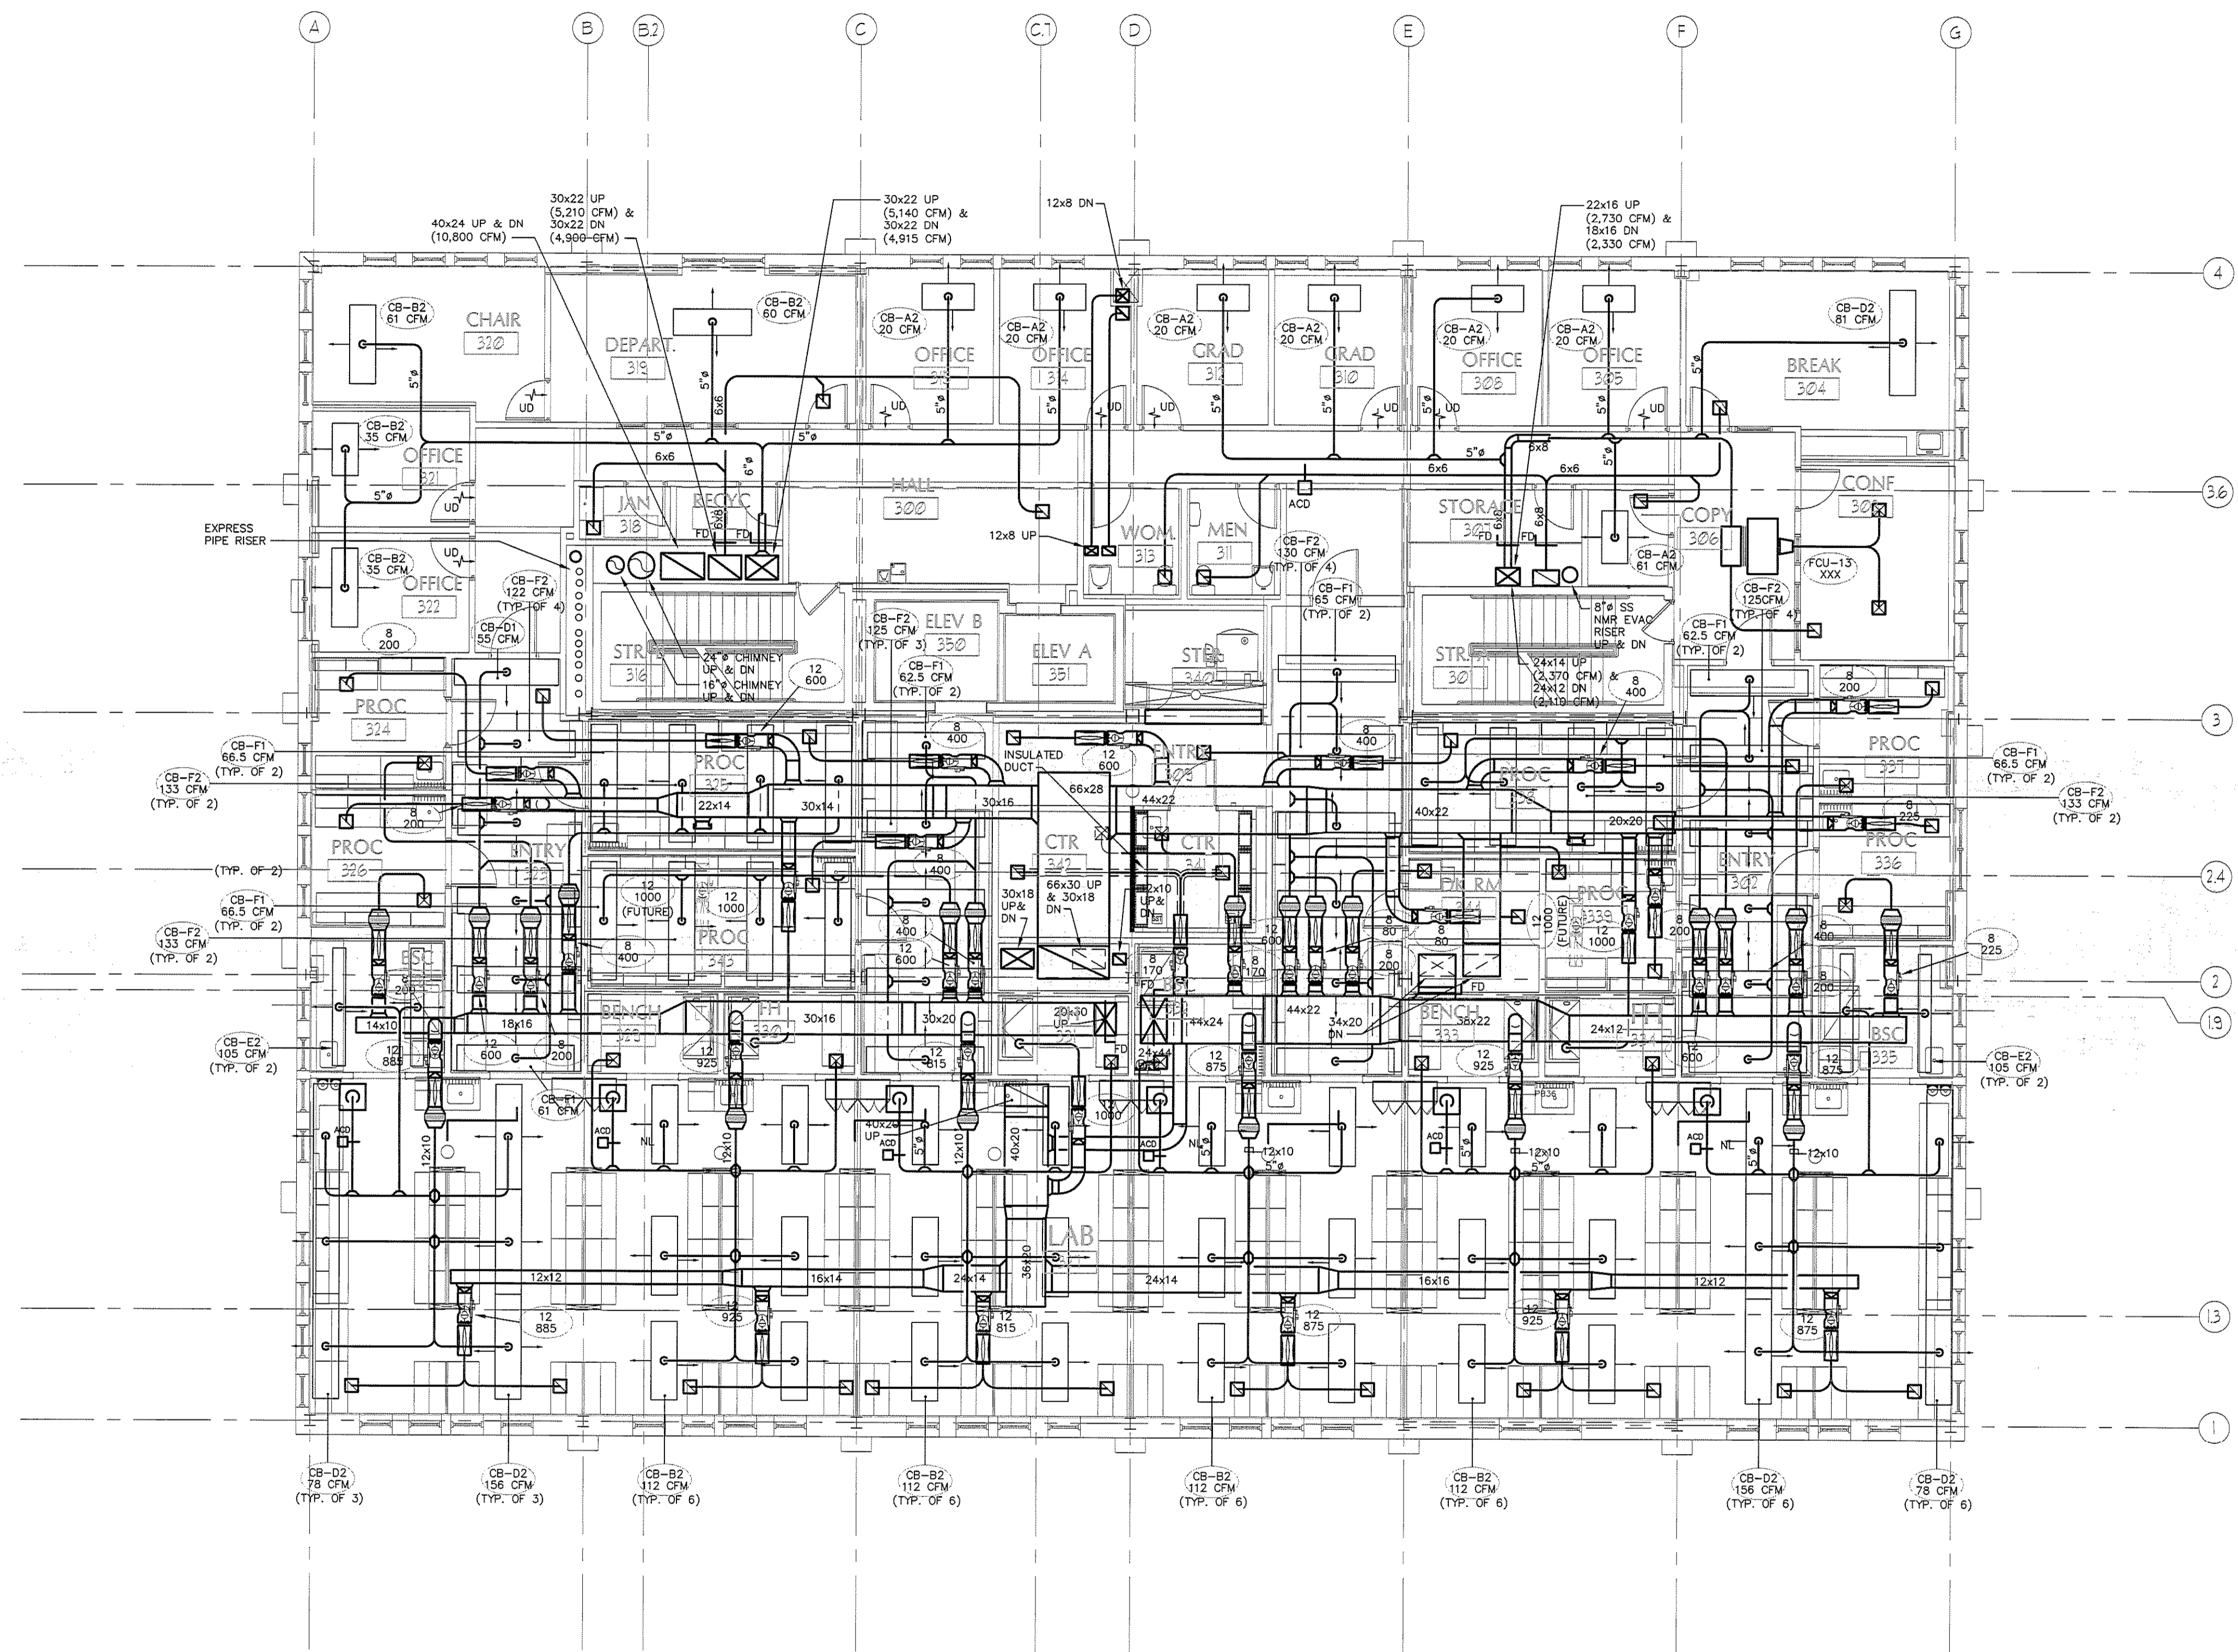

MECHANICAL THIRD FLOOR PLAN
 Scale: 1/8"=1'-0"

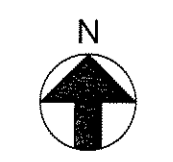

BID SET - NOT FOR CONSTRUCTION

#	DATE	DESCRIPTION
		BID SET
	02/08/08	Date Issued
	06506	Project Number

SHEET NAME
MECHANICAL THIRD FLOOR PLAN

Drawn By
 WGS
 Checked By
 DWMM/FBH
M1.4