

PORT CITY ARCHITECTURE

65 NEWBURY STREET
PORTLAND, ME 04101
207.761.9000
fax: 207.761.2010
lita@portcityarch.com



VANZELM
ENGINEERS

VANZELM HEYWOOD & SHADFORD, INC.
10 TALCOTT NOTCH FARMINGTON, CT 06032
TEL: (860) 284-2064 FAX: (860) 284-2098

PROJECT NO.: 2007120.00

BECKER
structural engineers, inc.

SYTDesign
CONSULTANTS
CIVIL ENGINEERING & LANDSCAPE ARCHITECTURE

ALLIED/COOK
CONSTRUCTION

Favreau
CONSTRUCTION

Titan Mechanical, Inc.
Design-Build Engineering - Mechanical Contracting

UNIVERSITY OF NEW ENGLAND

COLLEGE OF PHARMACY

716 STEVENS AVENUE,
PORTLAND, ME


| # | DATE | DESCRIPTION |
|---|----------|----------------|
| | | BID SET |
| | 02/08/08 | Date issued |
| | 06306 | Project Number |

SHEET NAME
**ROOF LEVEL
MECHANICAL PLAN**

| | |
|-------------------|-------------|
| Drawn By XXX | M1.6 |
| Checked By FBH | |

BID SET - NOT FOR CONSTRUCTION

COPYRIGHT: Reuse or reproduction of the contents of this document is not permitted without written permission of PORT CITY ARCHITECTURE, PA

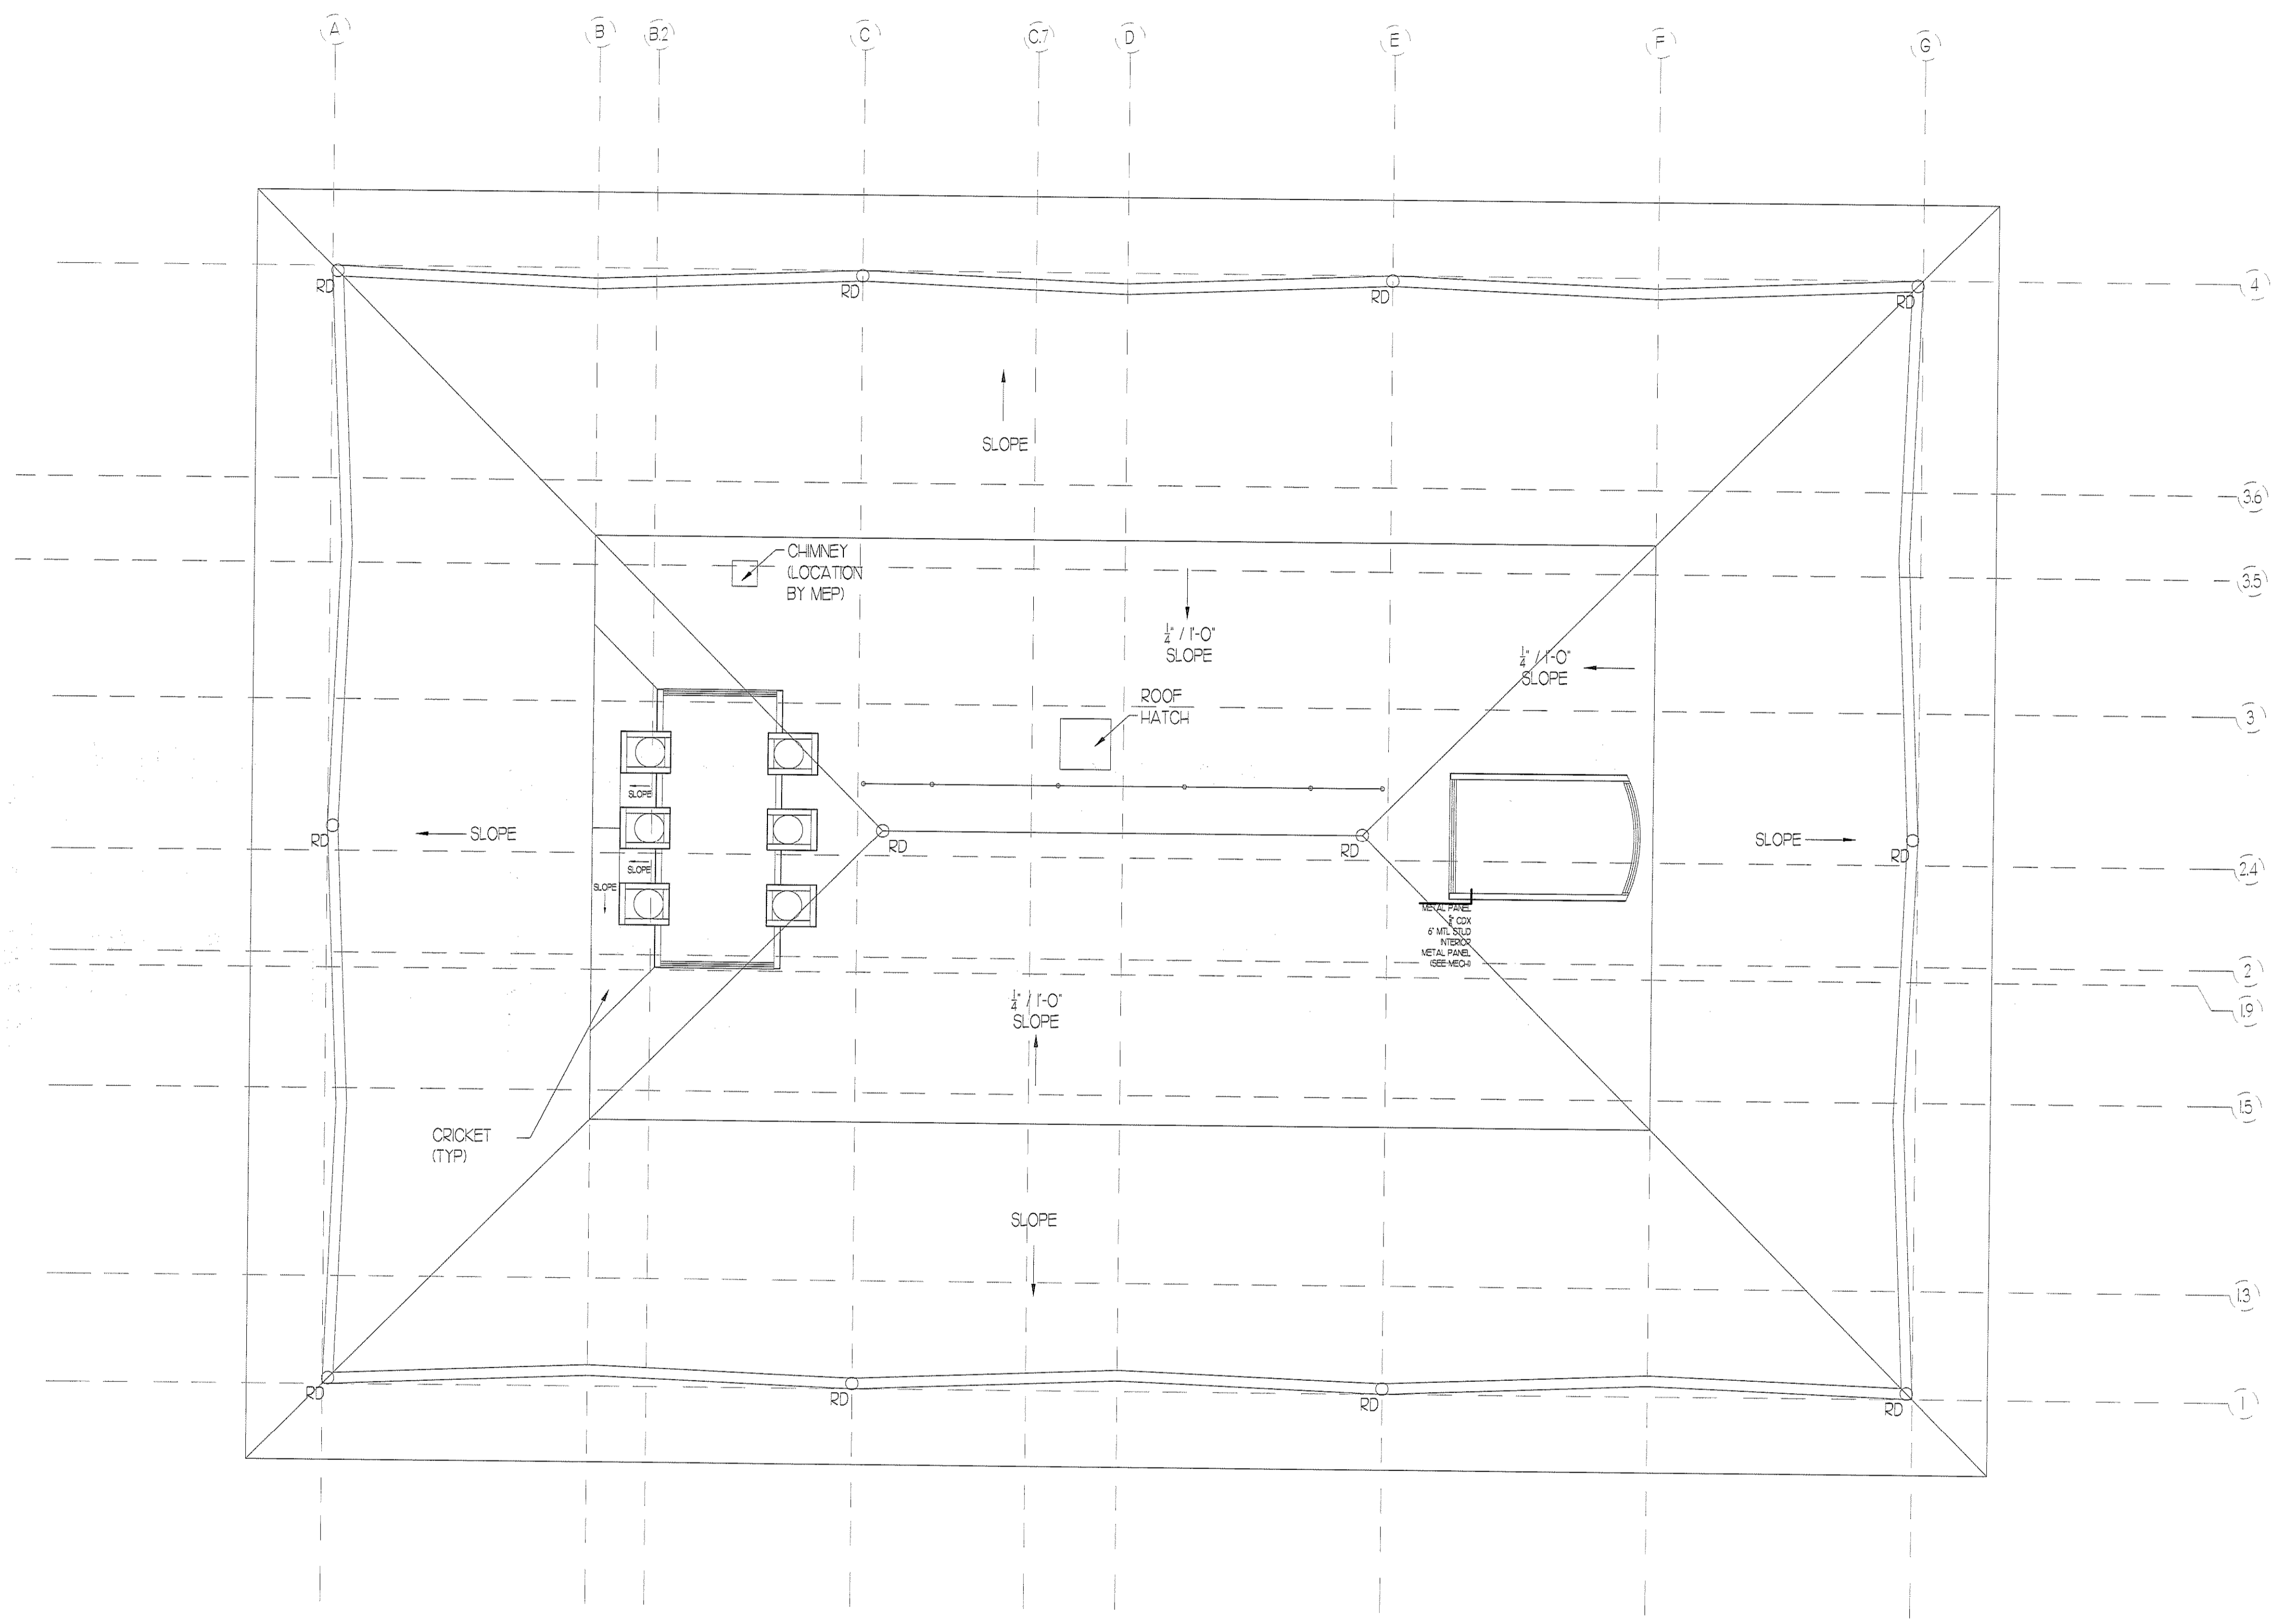

1 ROOF LEVEL PLAN
SCALE: 1/8" = 1'-0"



IF THIS SHEET IS NOT 24 X 36 IT IS A REDUCED SCALE PRINT - SCALE ACCORDINGLY

0 1 2 3 4 5 6 7 8 9 10 11 12
SCALE 1/4" = 1'

0 1 2 3 4 5 6 7 8 9 10 11 12
SCALE 1/2" = 1'

0 1 2 3 4 5 6 7 8 9 10 11 12
SCALE 3/4" = 1'

0 1 2 3 4 5 6 7 8 9 10 11 12
SCALE 1" = 1'

0 10 20 30 40
SCALE 1/16" = 1'