

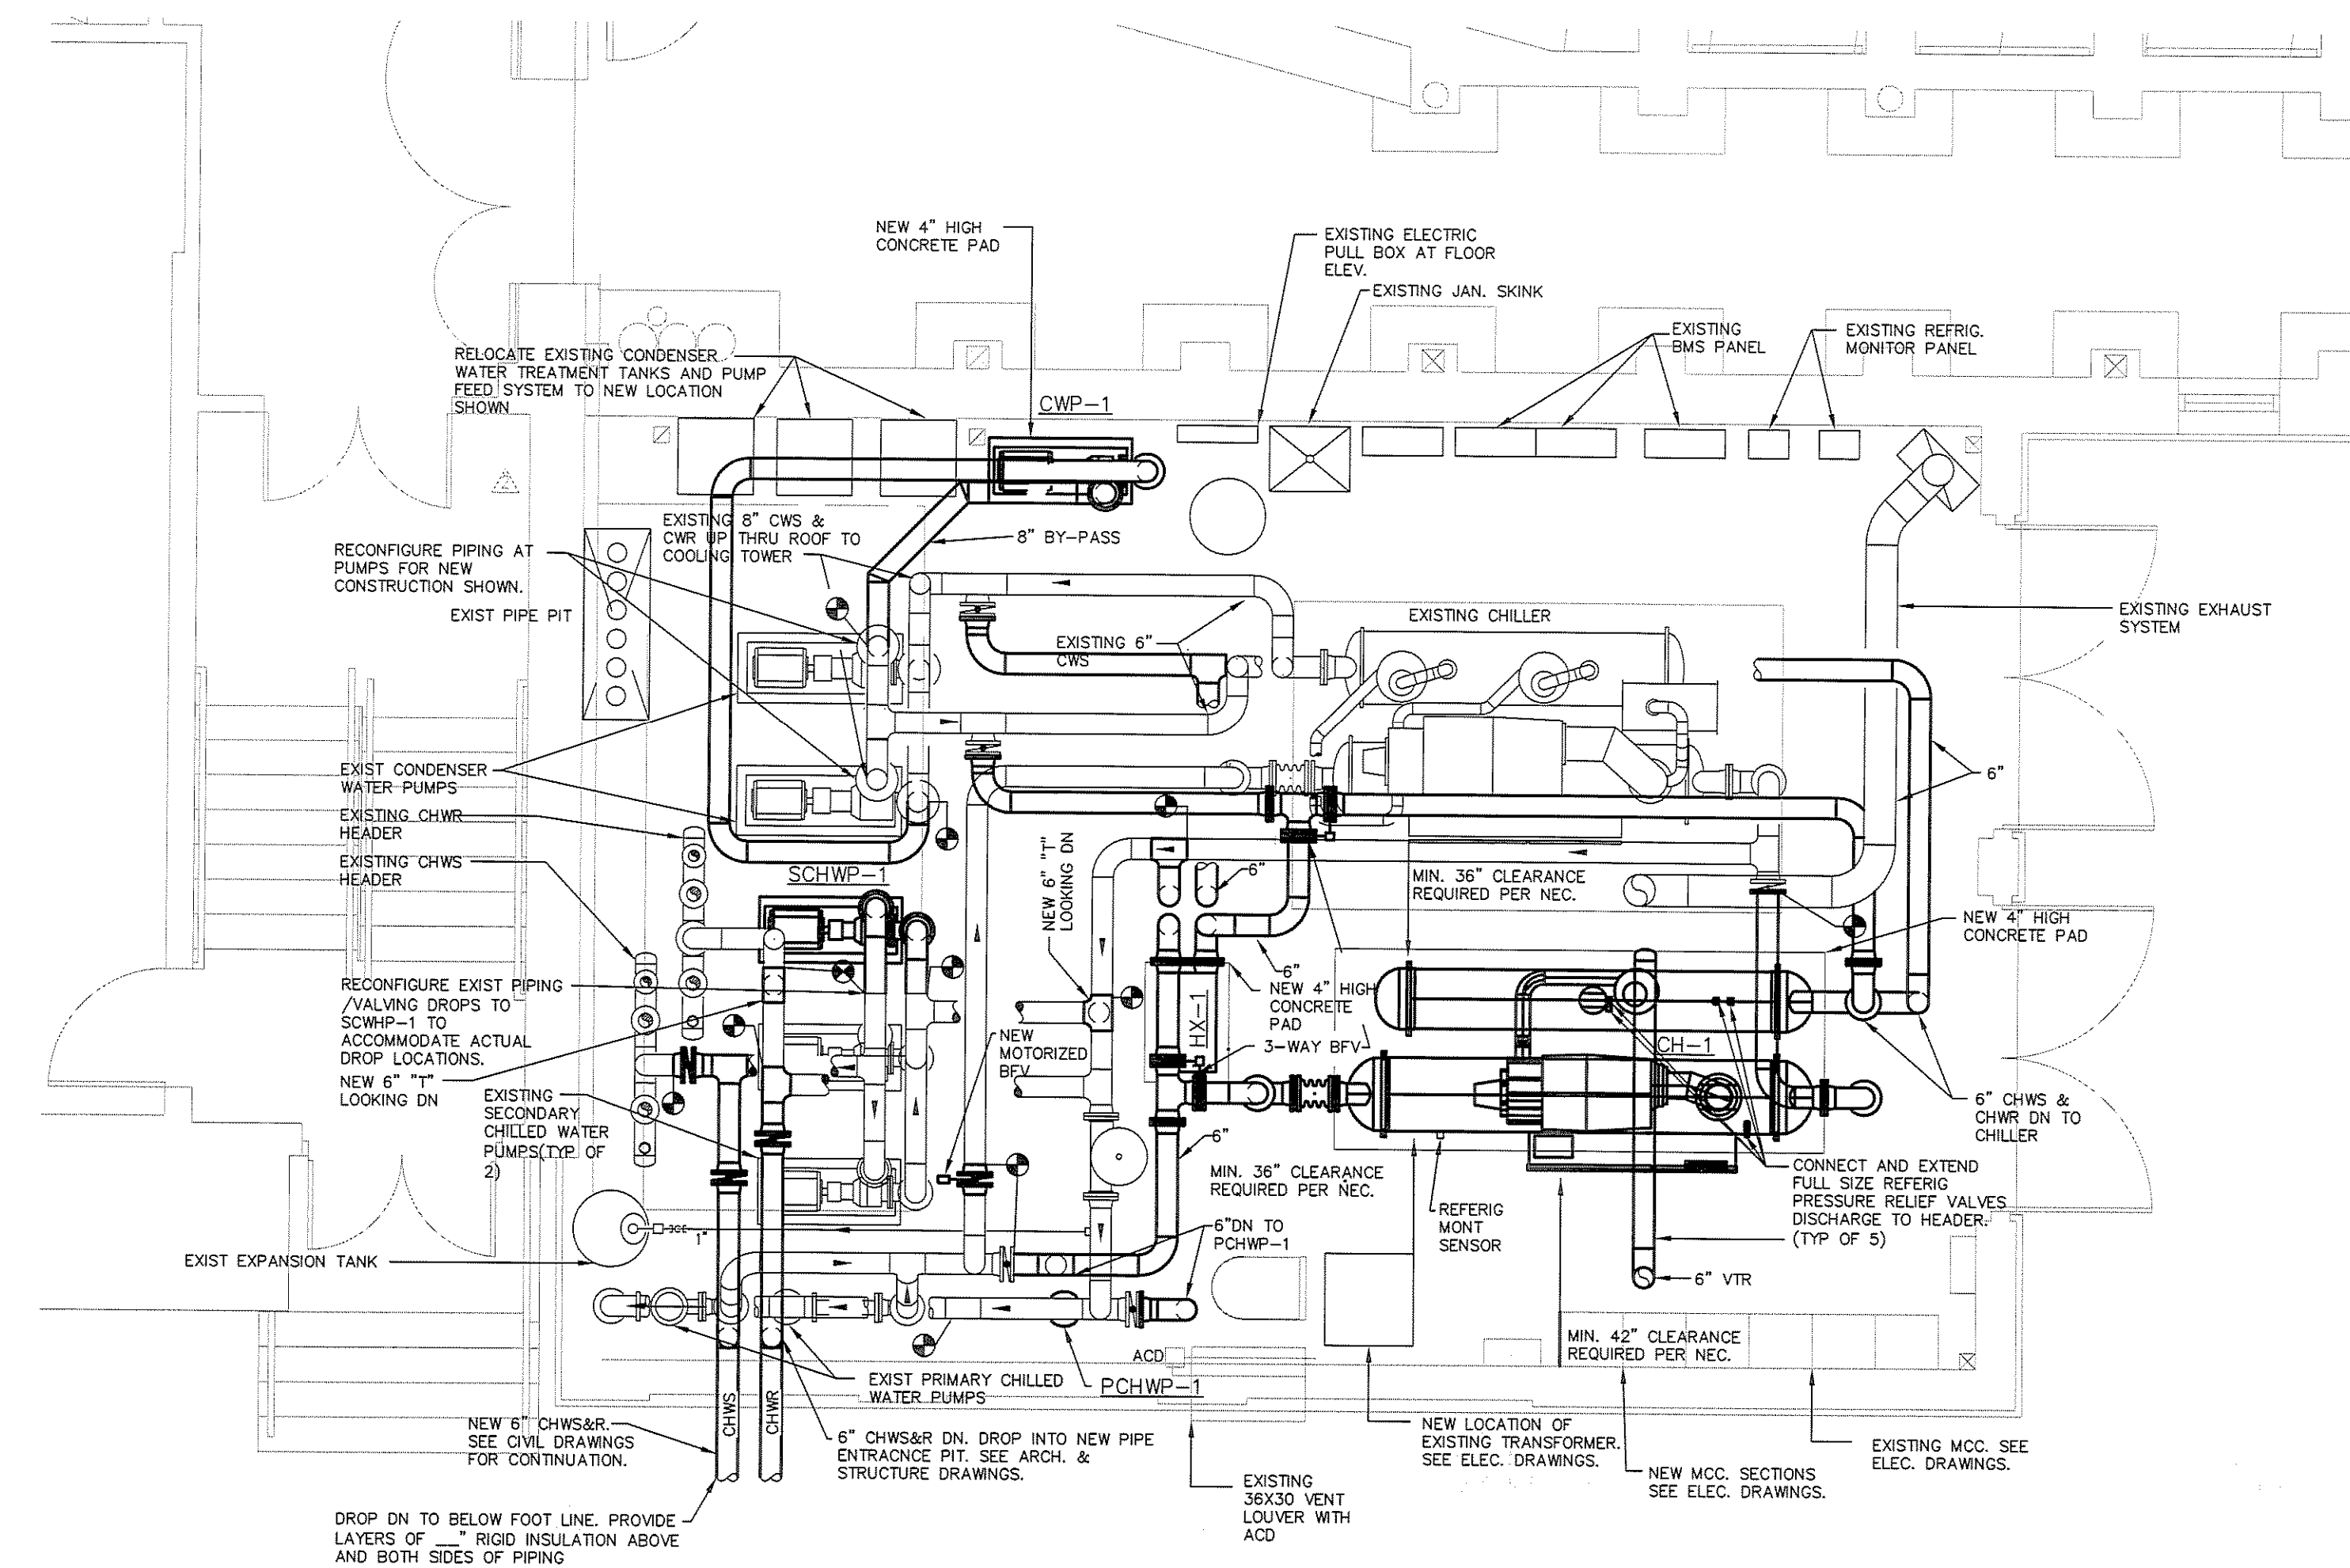


IF THIS SHEET IS NOT 24 X 36 IT IS A REDUCED SCALE PRINT - SCALE ACCORDINGLY

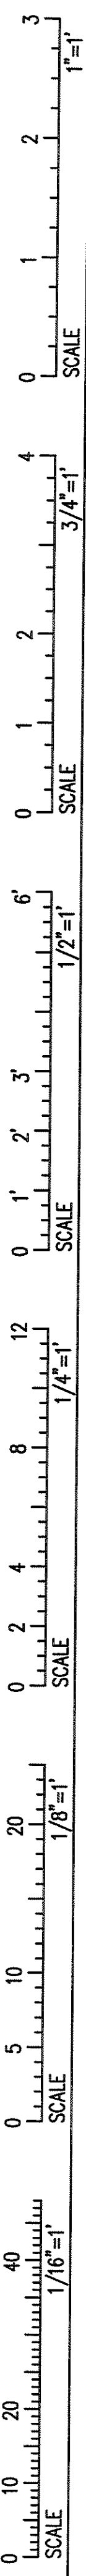


2.1 CHILLER PLANT FLOOR PLAN
Scale: 1/4"=1'-0"

NOTE: VFD'S FOR NEW COOLING TOWER, NEW SECONDARY CHILLED WATER PUMP AND EXISTING SECONDARY CHILLED WATER PUMP SHALL BE LOCATED IN MCC. VFD'S PROVIDED UNER DIV. 26.

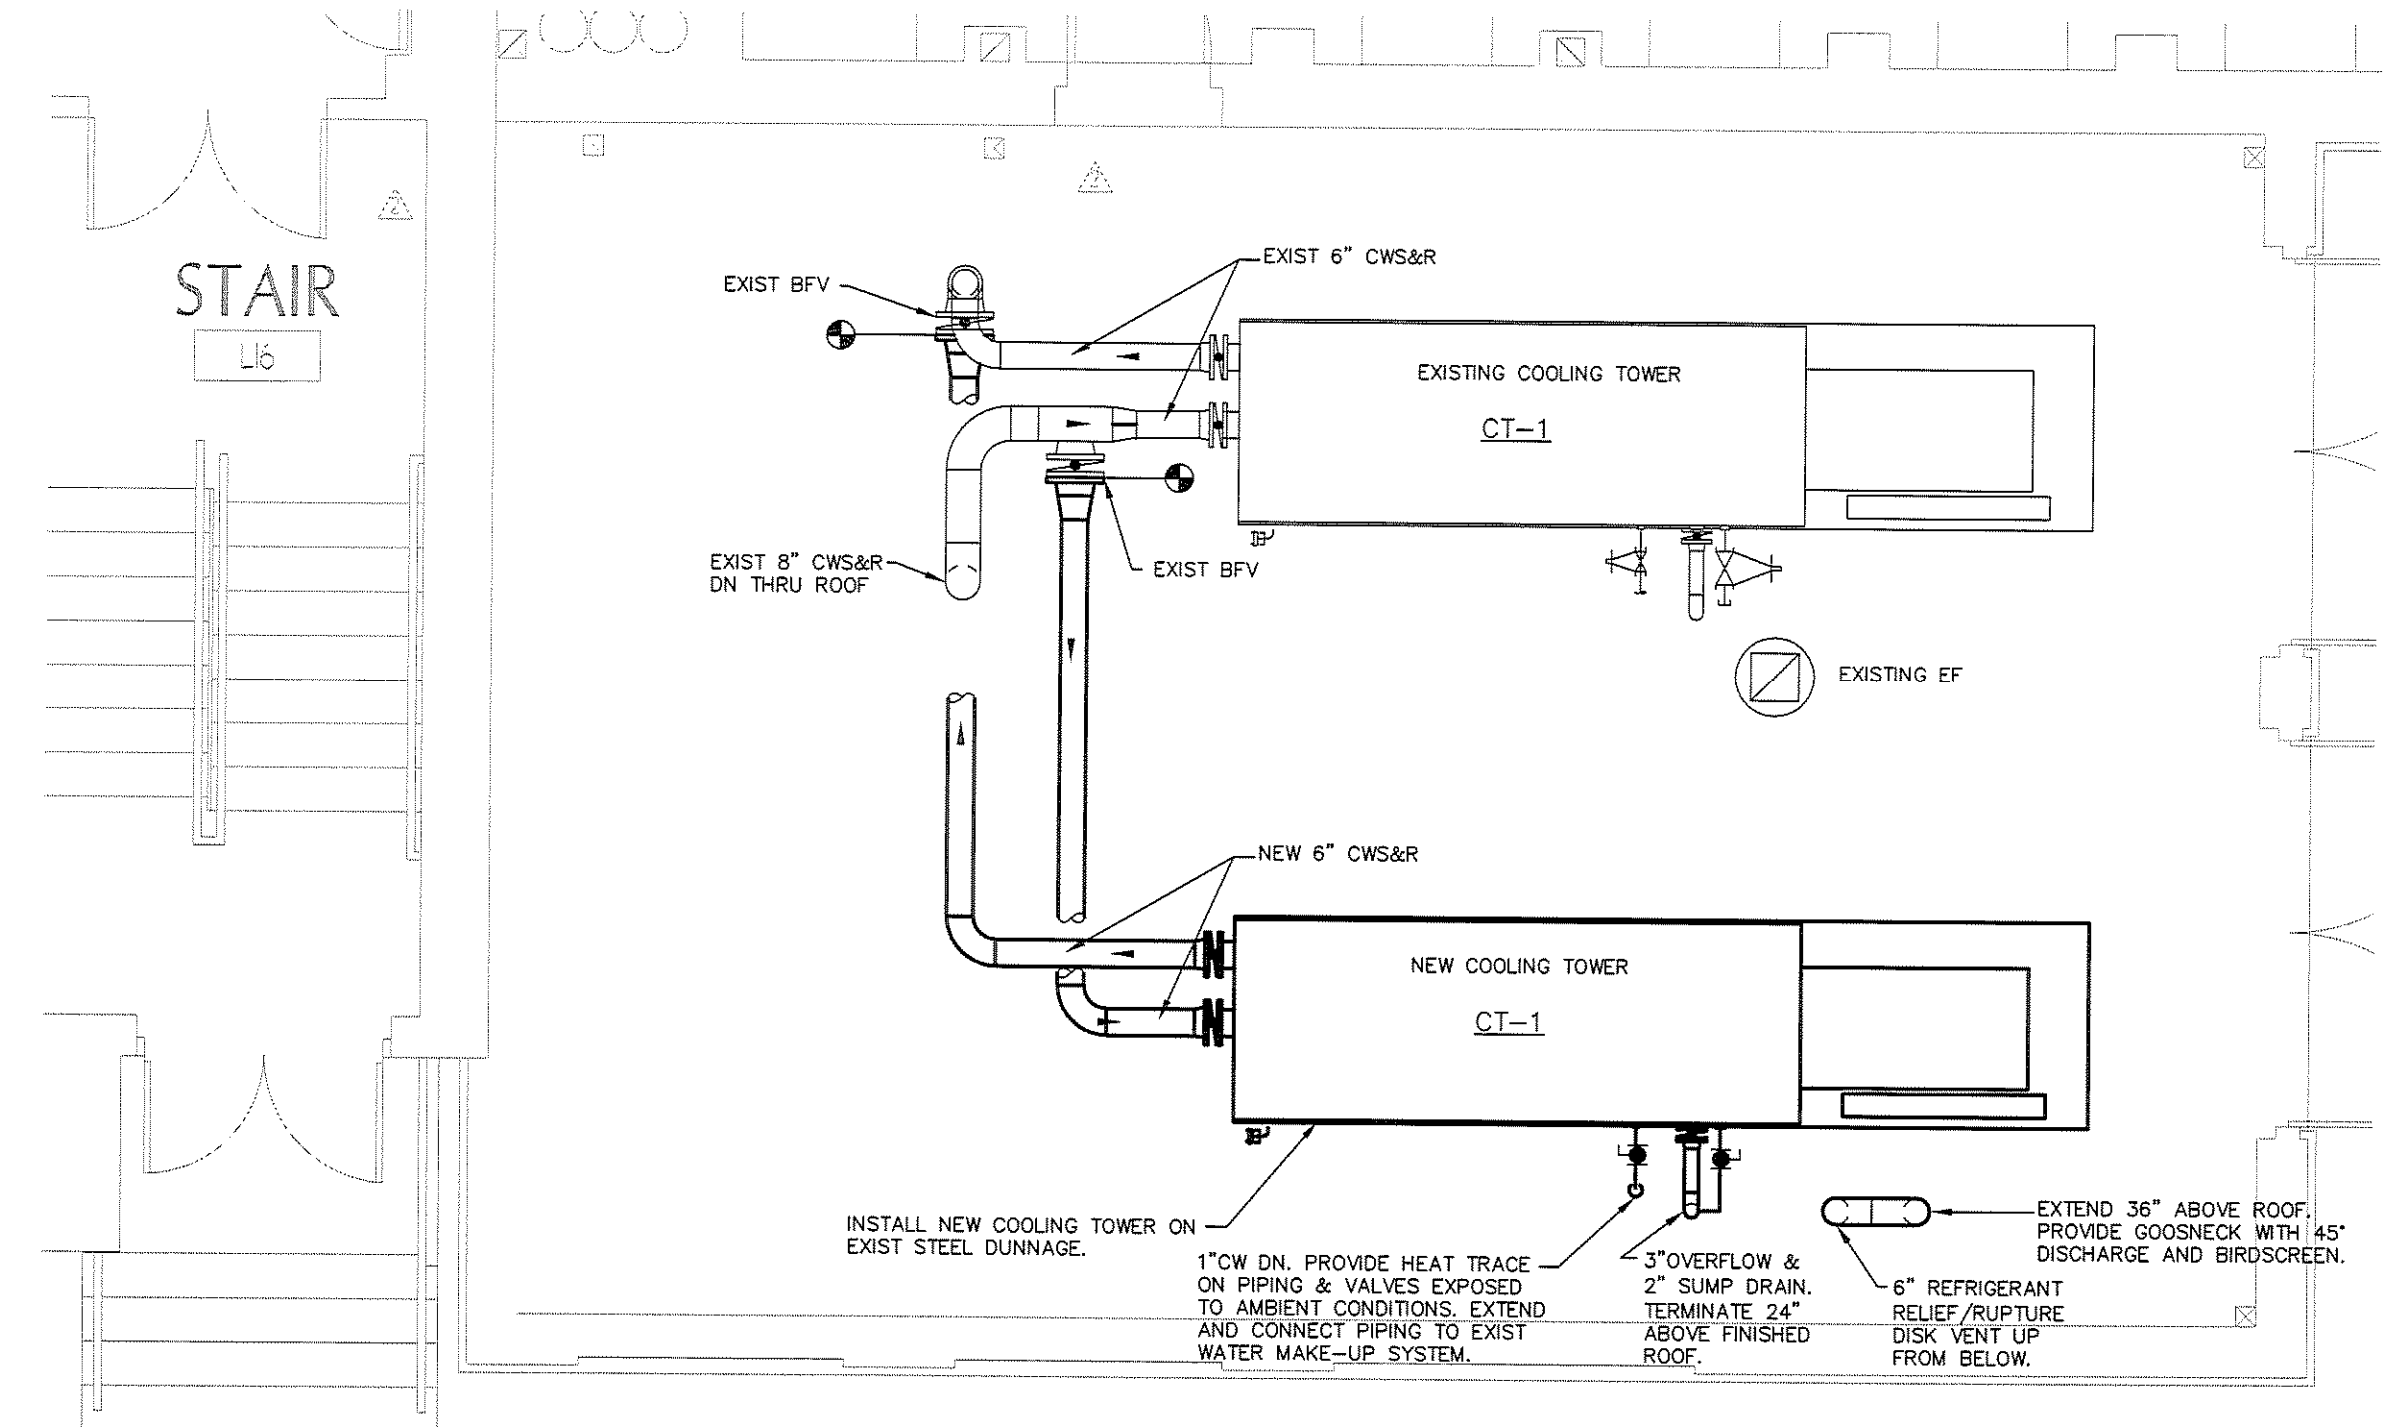

2.2 CHILLED PLANT ROOF PLAN
Scale: 1/4"=1'-0"

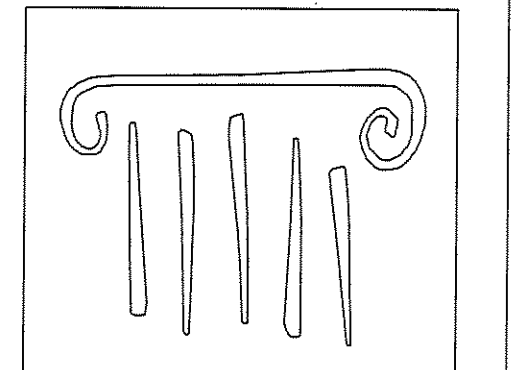

PORT CITY ARCHITECTURE

65 NEWBURY STREET
PORTLAND, ME 04101
207.761.9000
fax: 207.761.2010
lita@portcityarch.com

VANZELM ENGINEERS

VANZELM HEYWOOD & SHADFORD, INC.
10 TALCOTT NOTCH FARMINGTON, CT 06032
TEL: (860) 284-2064 FAX: (860) 284-2098

PROJECT NO.: 2007120.00

BECKER
structural engineers, inc.

SYTDesign CONSULTANTS
CIVIL ENGINEERING & LANDSCAPE ARCHITECTURE

ALLIED/COOK CONSTRUCTION

Favreau
ELECTRIC

Titan Mechanical, Inc.
Design-Build Engineering - Mechanical Contracting

UNIVERSITY OF NEW ENGLAND

COLLEGE OF PHARMACY


716 STEVENS AVENUE,
PORTLAND, ME

#	DATE	DESCRIPTION
		BID SET
	02/08/08	Date Issued
	06506	Project Number

SHEET NAME
MECHANICAL CHILLER PLANT PART PLANS

Drawn By
WGS
Checked By
DWM/FBH

M2.4

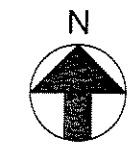

BID SET - NOT FOR CONSTRUCTION