



IF THIS SHEET IS NOT 24 X 36 IT IS A REDUCED SCALE PRINT - SCALE ACCORDINGLY


SCALE 1"=1'  
 SCALE 3/4"=1'  
 SCALE 1/2"=1'  
 SCALE 1/4"=1'  
 SCALE 1/8"=1'

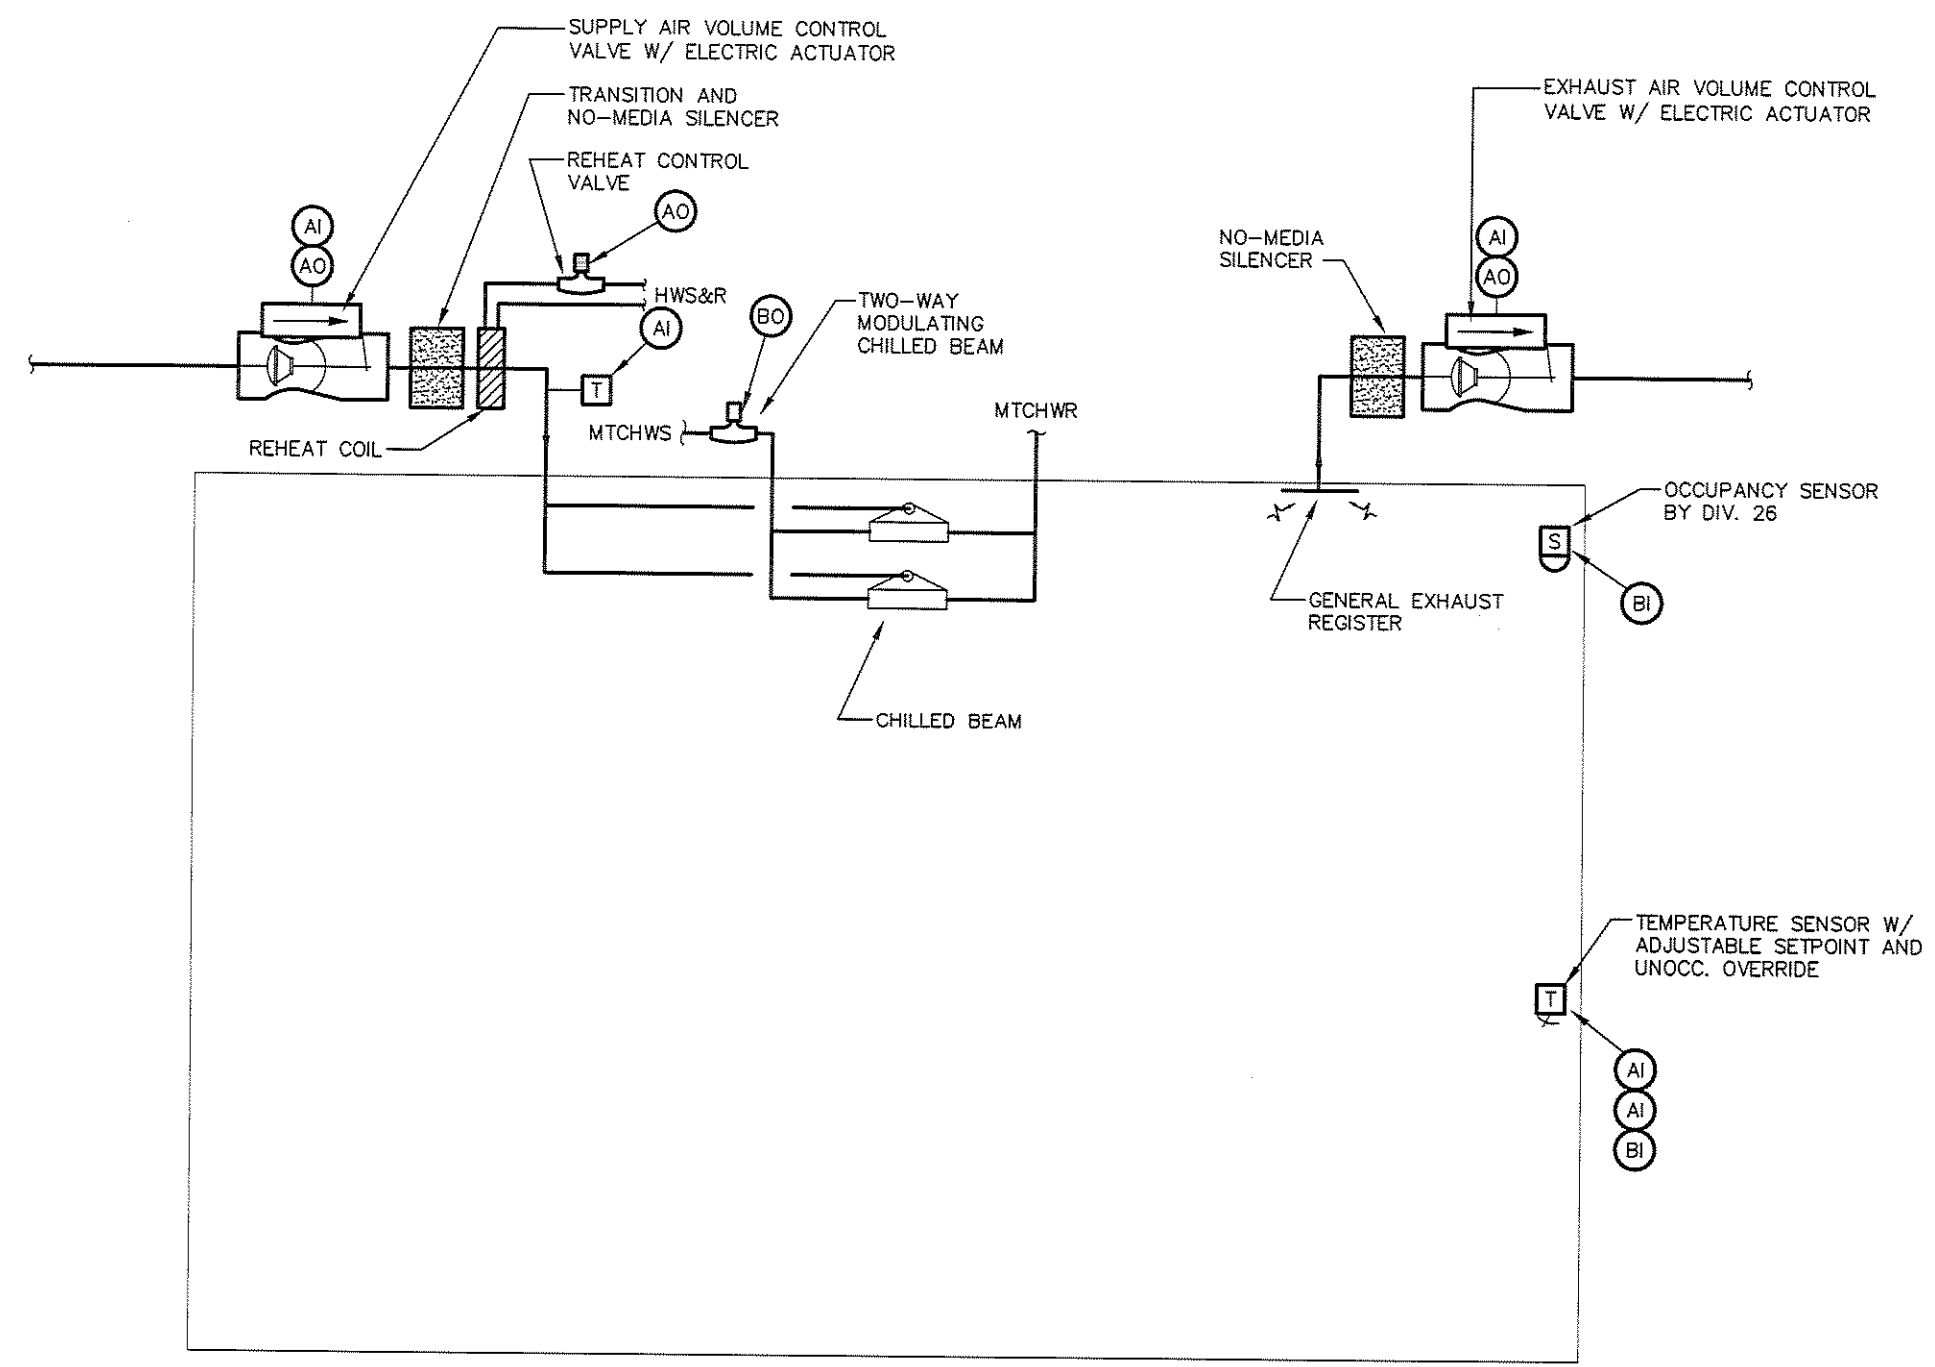

TYPICAL LABORATORY SUPPORT CONTROL DIAGRAM  
 NOT TO SCALE

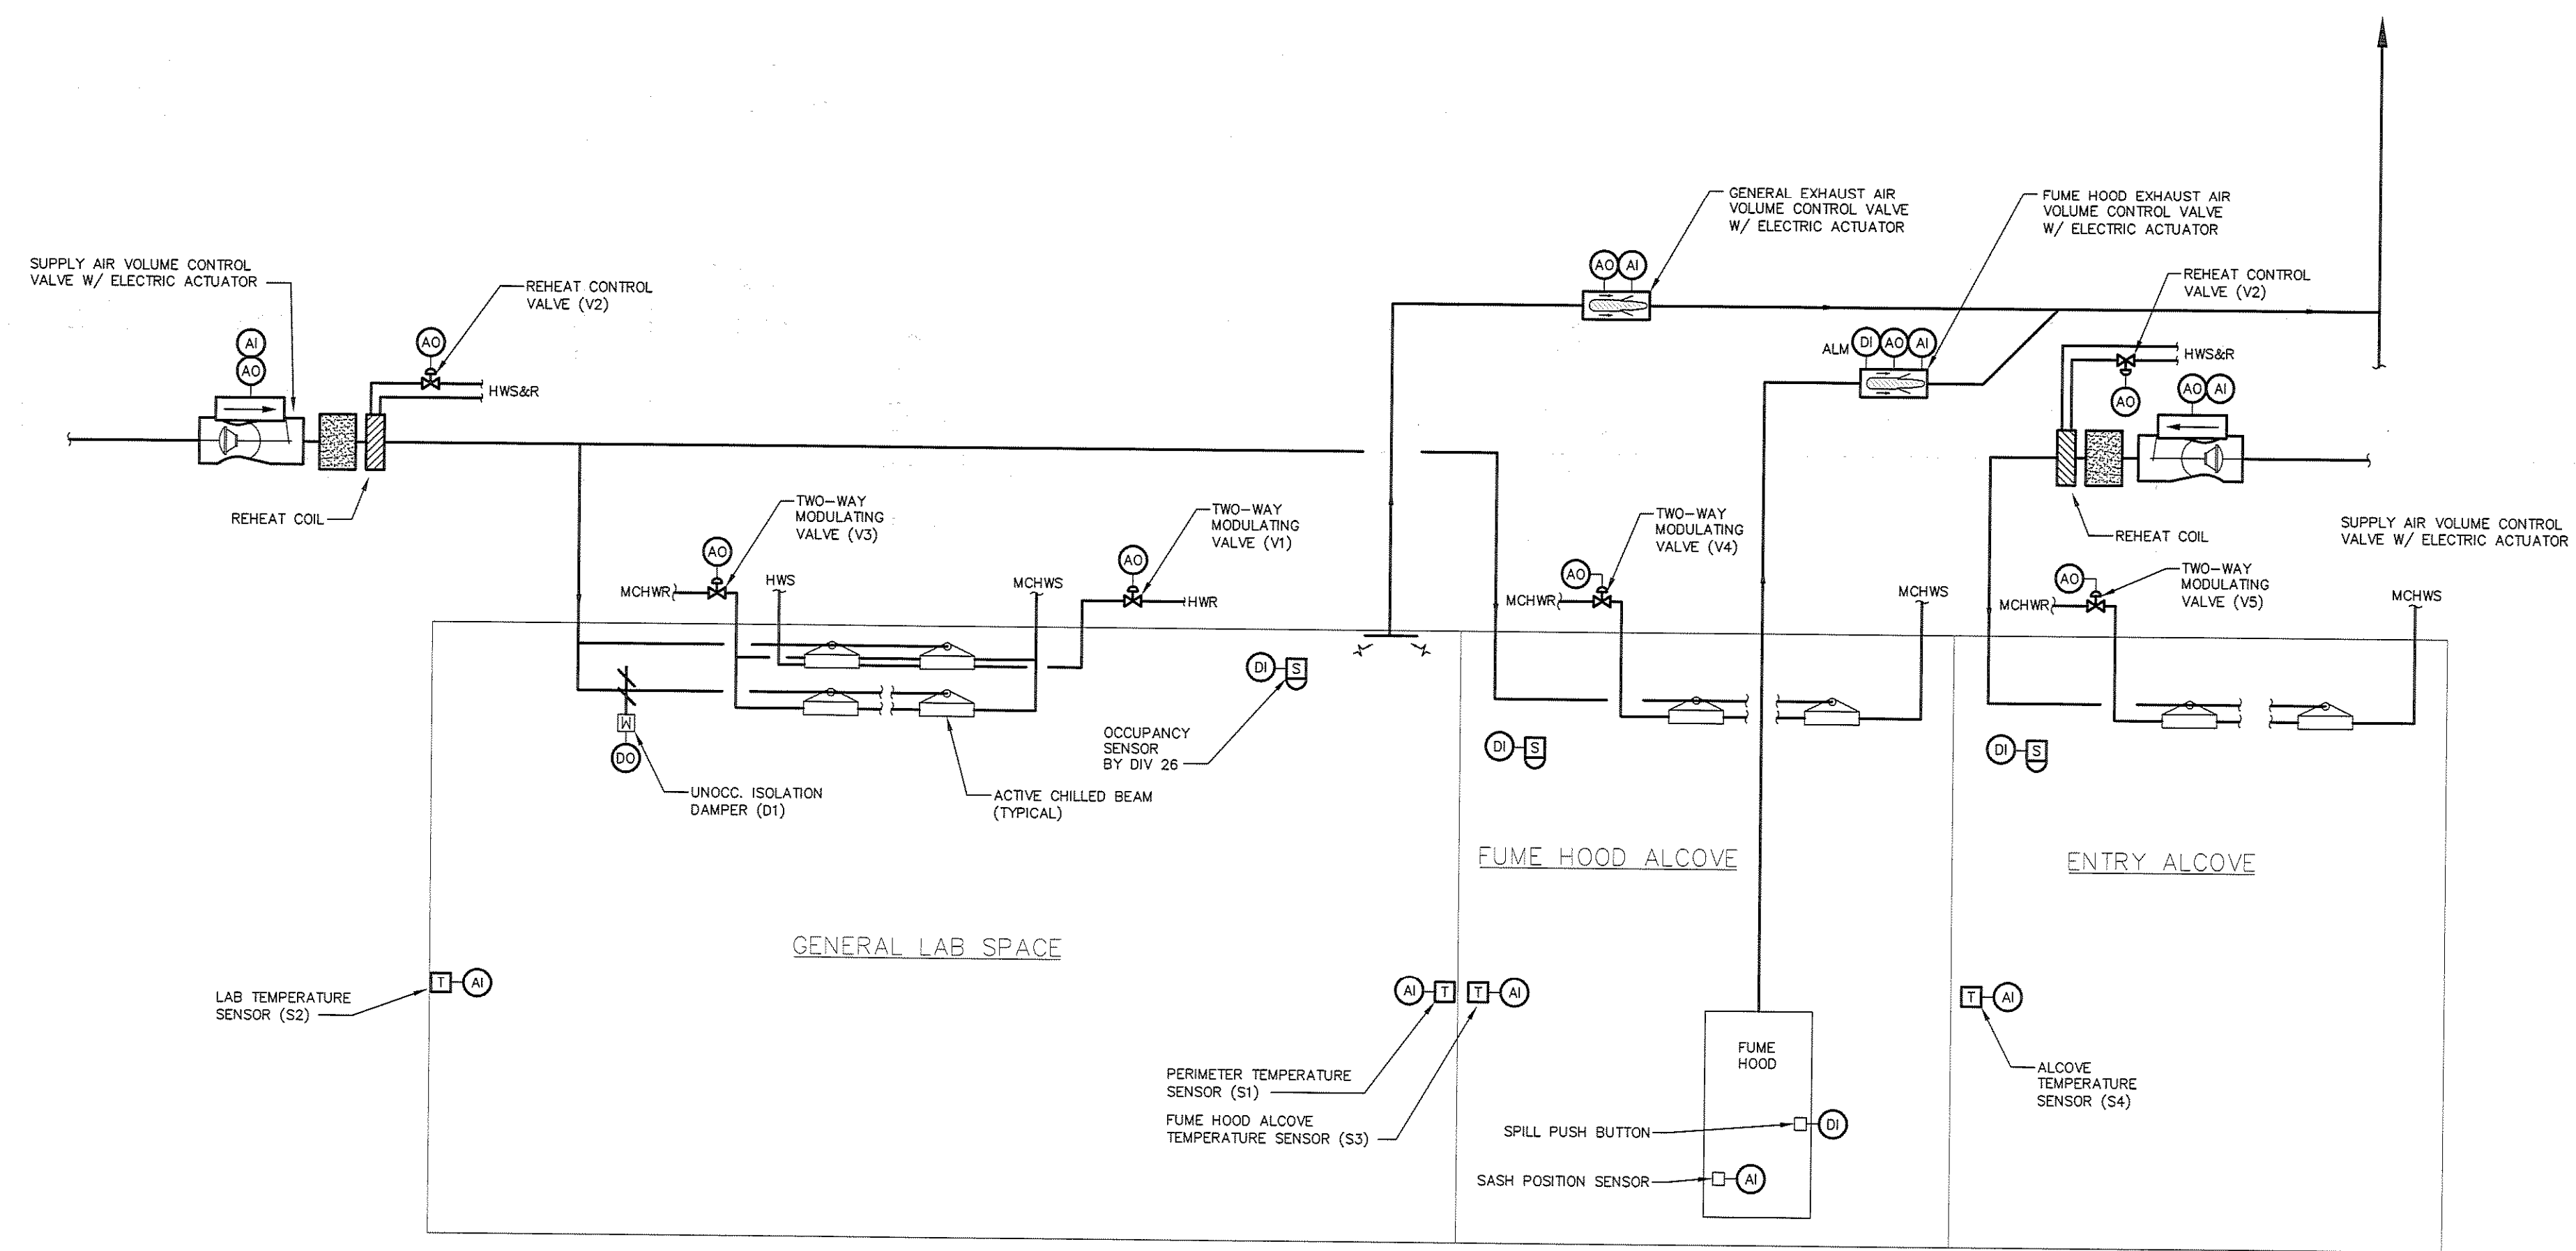

TYPICAL LABORATORY CONTROL DIAGRAM  
 NOT TO SCALE

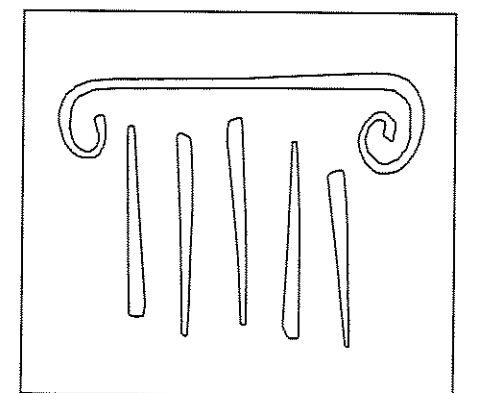

PORT CITY ARCHITECTURE

65 NEWBURY STREET  
 PORTLAND, ME 04101  
 207.761.9000  
 fax: 207.761.2010  
 lita@portcityarch.com

VANZELM ENGINEERS

VANZELM HEYWOOD & SHADFORD, INC.  
 16 TALCOTT NOTCH FARMINGTON, CT 06032  
 TEL: (860)284-2064 FAX: (860)284-2066

PROJECT NO.: 2007120.00

BECKER structural engineers, inc.

SYTDesign CONSULTANTS  
 CIVIL ENGINEERING & LANDSCAPE ARCHITECTURE

ALLIED/COOK CONSTRUCTION

Favreau CONSULTANTS

Titan Mechanical, Inc.  
 Group Building Engineering - Mechanical Contracting

UNIVERSITY OF NEW ENGLAND


COLLEGE OF PHARMACY

716 STEVENS AVENUE,  
 PORTLAND, ME

#	DATE	DESCRIPTION
		BID SET
	02/08/08	Date Issued
	06506	Project Number

SHEET NAME  
**MECHANICAL SYSTEMS CONTROL DIAGRAMS**

Drawn By: ANM  
 Checked By: DWM/FBH  
**M5.2**

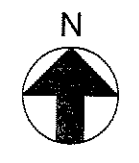

**BID SET - NOT FOR CONSTRUCTION**