

PORT CITY ARCHITECTURE

65 NEWBURY STREET
PORTLAND, ME 04101
207.761.9000
fax: 207.761.2010
lita@portcityarch.com

VANZELM
ENGINEERS

VANZELM HEYWOOD & SHADFORD, INC.
10 TALCOTT NOTCH FARMINGTON, CT 06032
TEL: (860) 284-2064 FAX: (860) 284-2068

PROJECT NO.: 2007120.00

BECKER
Structural Engineers, Inc.

SYTDesign
CONSULTANTS
CIVIL ENGINEERING & LANDSCAPE ARCHITECTURE

ALLIED/COOK
CONSTRUCTION

Fareau
GROUP

Titan Mechanical, Inc.
Design-Build Engineering - Mechanical Contracting

UNIVERSITY OF NEW ENGLAND

COLLEGE OF PHARMACY


716 STEVENS AVENUE,
PORTLAND, ME

#	DATE	DESCRIPTION
		BID SET
	Date Issued	02/02/08
	Project Number	06506

SHEET NAME
ELECTRICAL LIGHTING PLAN - ATTIC

Drawn By
AMM
Checked By
MER

EL1.5

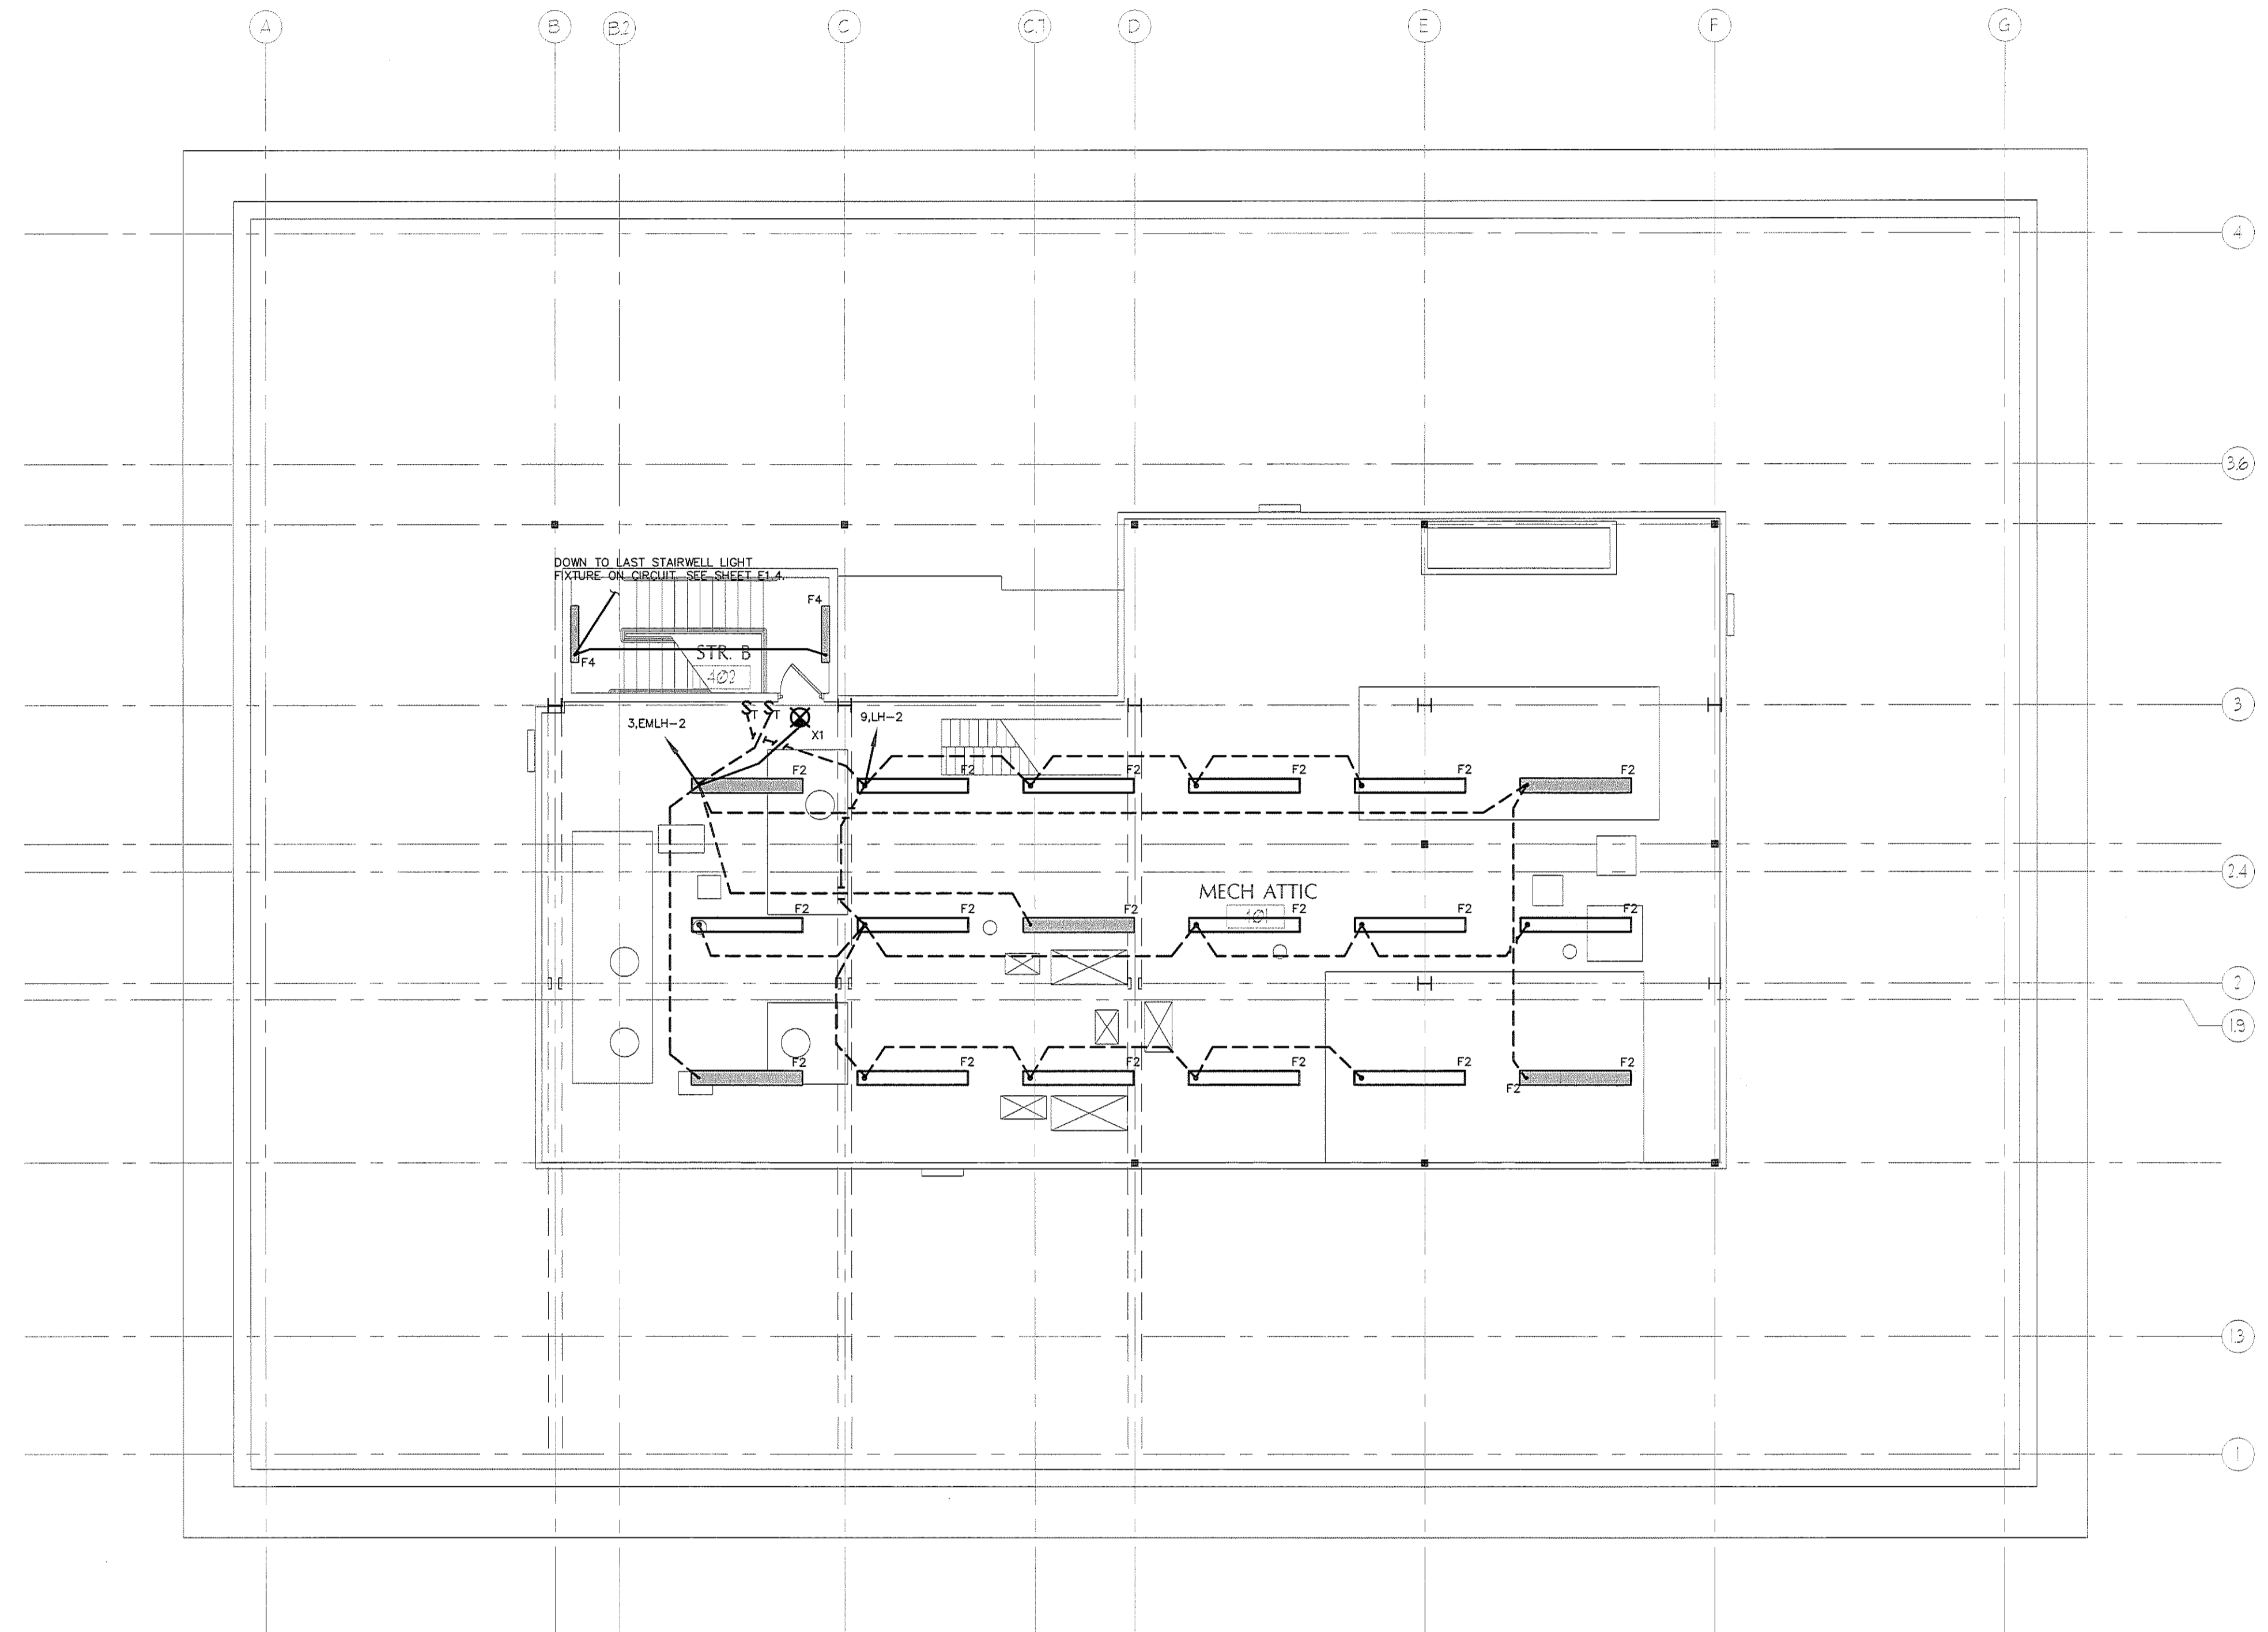

NOTE:
COORDINATE LIGHT FIXTURE LOCATIONS WITH MECHANICAL EQUIPMENT, DUCTWORK, AND PIPING.

1 ATTIC LIGHTING PLAN
Scale: 1/8"=1'-0"

IF THIS SHEET IS NOT 24 X 36 IT IS A REDUCED SCALE PRINT - SCALE ACCORDINGLY

SCALE 1"=1'


SCALE 3/4"=1'

SCALE 1/2"=1'

SCALE 1/4"=1'

SCALE 1/8"=1'

SCALE 1/16"=1'

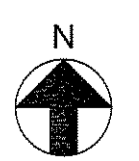

BID SET - NOT FOR CONSTRUCTION