

PORT CITY ARCHITECTURE

65 NEWBURY STREET
 PORTLAND, ME 04101
 207.761.9000
 fax: 207.761.2010
 lita@portcityarch.com

VANZELM ENGINEERS

VANZELM HEYWOOD & SHADFORD, INC.
 10 TALCOTT NOTCH FARMINGTON, CT 06031
 TEL:(860)284-2064 FAX:(860)284-2088

PROJECT NO.: 2007120.00

BECKER structural engineers, inc.

SYTDesign CONSULTANTS
 CIVIL ENGINEERING & LANDSCAPE ARCHITECTURE

ALLIED/COOK CONSTRUCTION

Faireau ELECTRIC

Titan Mechanical, Inc.
 Design-Build Engineering - Mechanical Contractors

UNIVERSITY OF NEW ENGLAND

COLLEGE OF PHARMACY

716 STEVENS AVENUE,
 PORTLAND, ME

#	DATE	DESCRIPTION
		BID SET
	Date Issued	02/08/08
	Project Number	06506

SHEET NAME
ELECTRICAL POWER PLAN - FIRST FLOOR


Drawn By
 AMM
 Checked By
 MER

EP1.2

BID SET - NOT FOR CONSTRUCTION

- KEYED NOTES:
1. POWER CONNECTION FOR ELECTRIC SHADES. CONTROLLER TO BE INSTALLED IN AV RACK RM 133. COORDINATE WITH INSTALLER.
 2. POWER CONNECTION FOR MOTORIZED SCREEN. COORDINATE WITH INSTALLER.
 3. MEDIA CONTROL PANEL FOR MOTORIZED SCREEN. COORDINATE LOCATION WITH INSTALLER.
 4. POWER AND DATA CONNECTIONS FOR OVERHEAD PROJECTOR. COORDINATE LOCATION WITH INSTALLER.
 5. POWER CONNECTION FOR COFFEE URN.
 6. INSTALL ONE 1/2" EMPTY CONDUIT FROM CARD READER/POWER SUPPLY TO ACCESS CONTROL SYSTEM CONTROLLER IN STORAGE ROOM 142. PROVIDE PULL STRING IN CONDUIT.
 7. POWER CONNECTION FROM DOOR CONTROL POWER SUPPLY IN STORAGE ROOM 142. COORDINATE LOCATION WITH INSTALLER.
 8. CONTROLLER FOR ACCESS CONTROL SYSTEM. COORDINATE LOCATION WITH INSTALLER.

1 FIRST FLOOR PLAN
 SCALE: 1/8" = 1'-0"

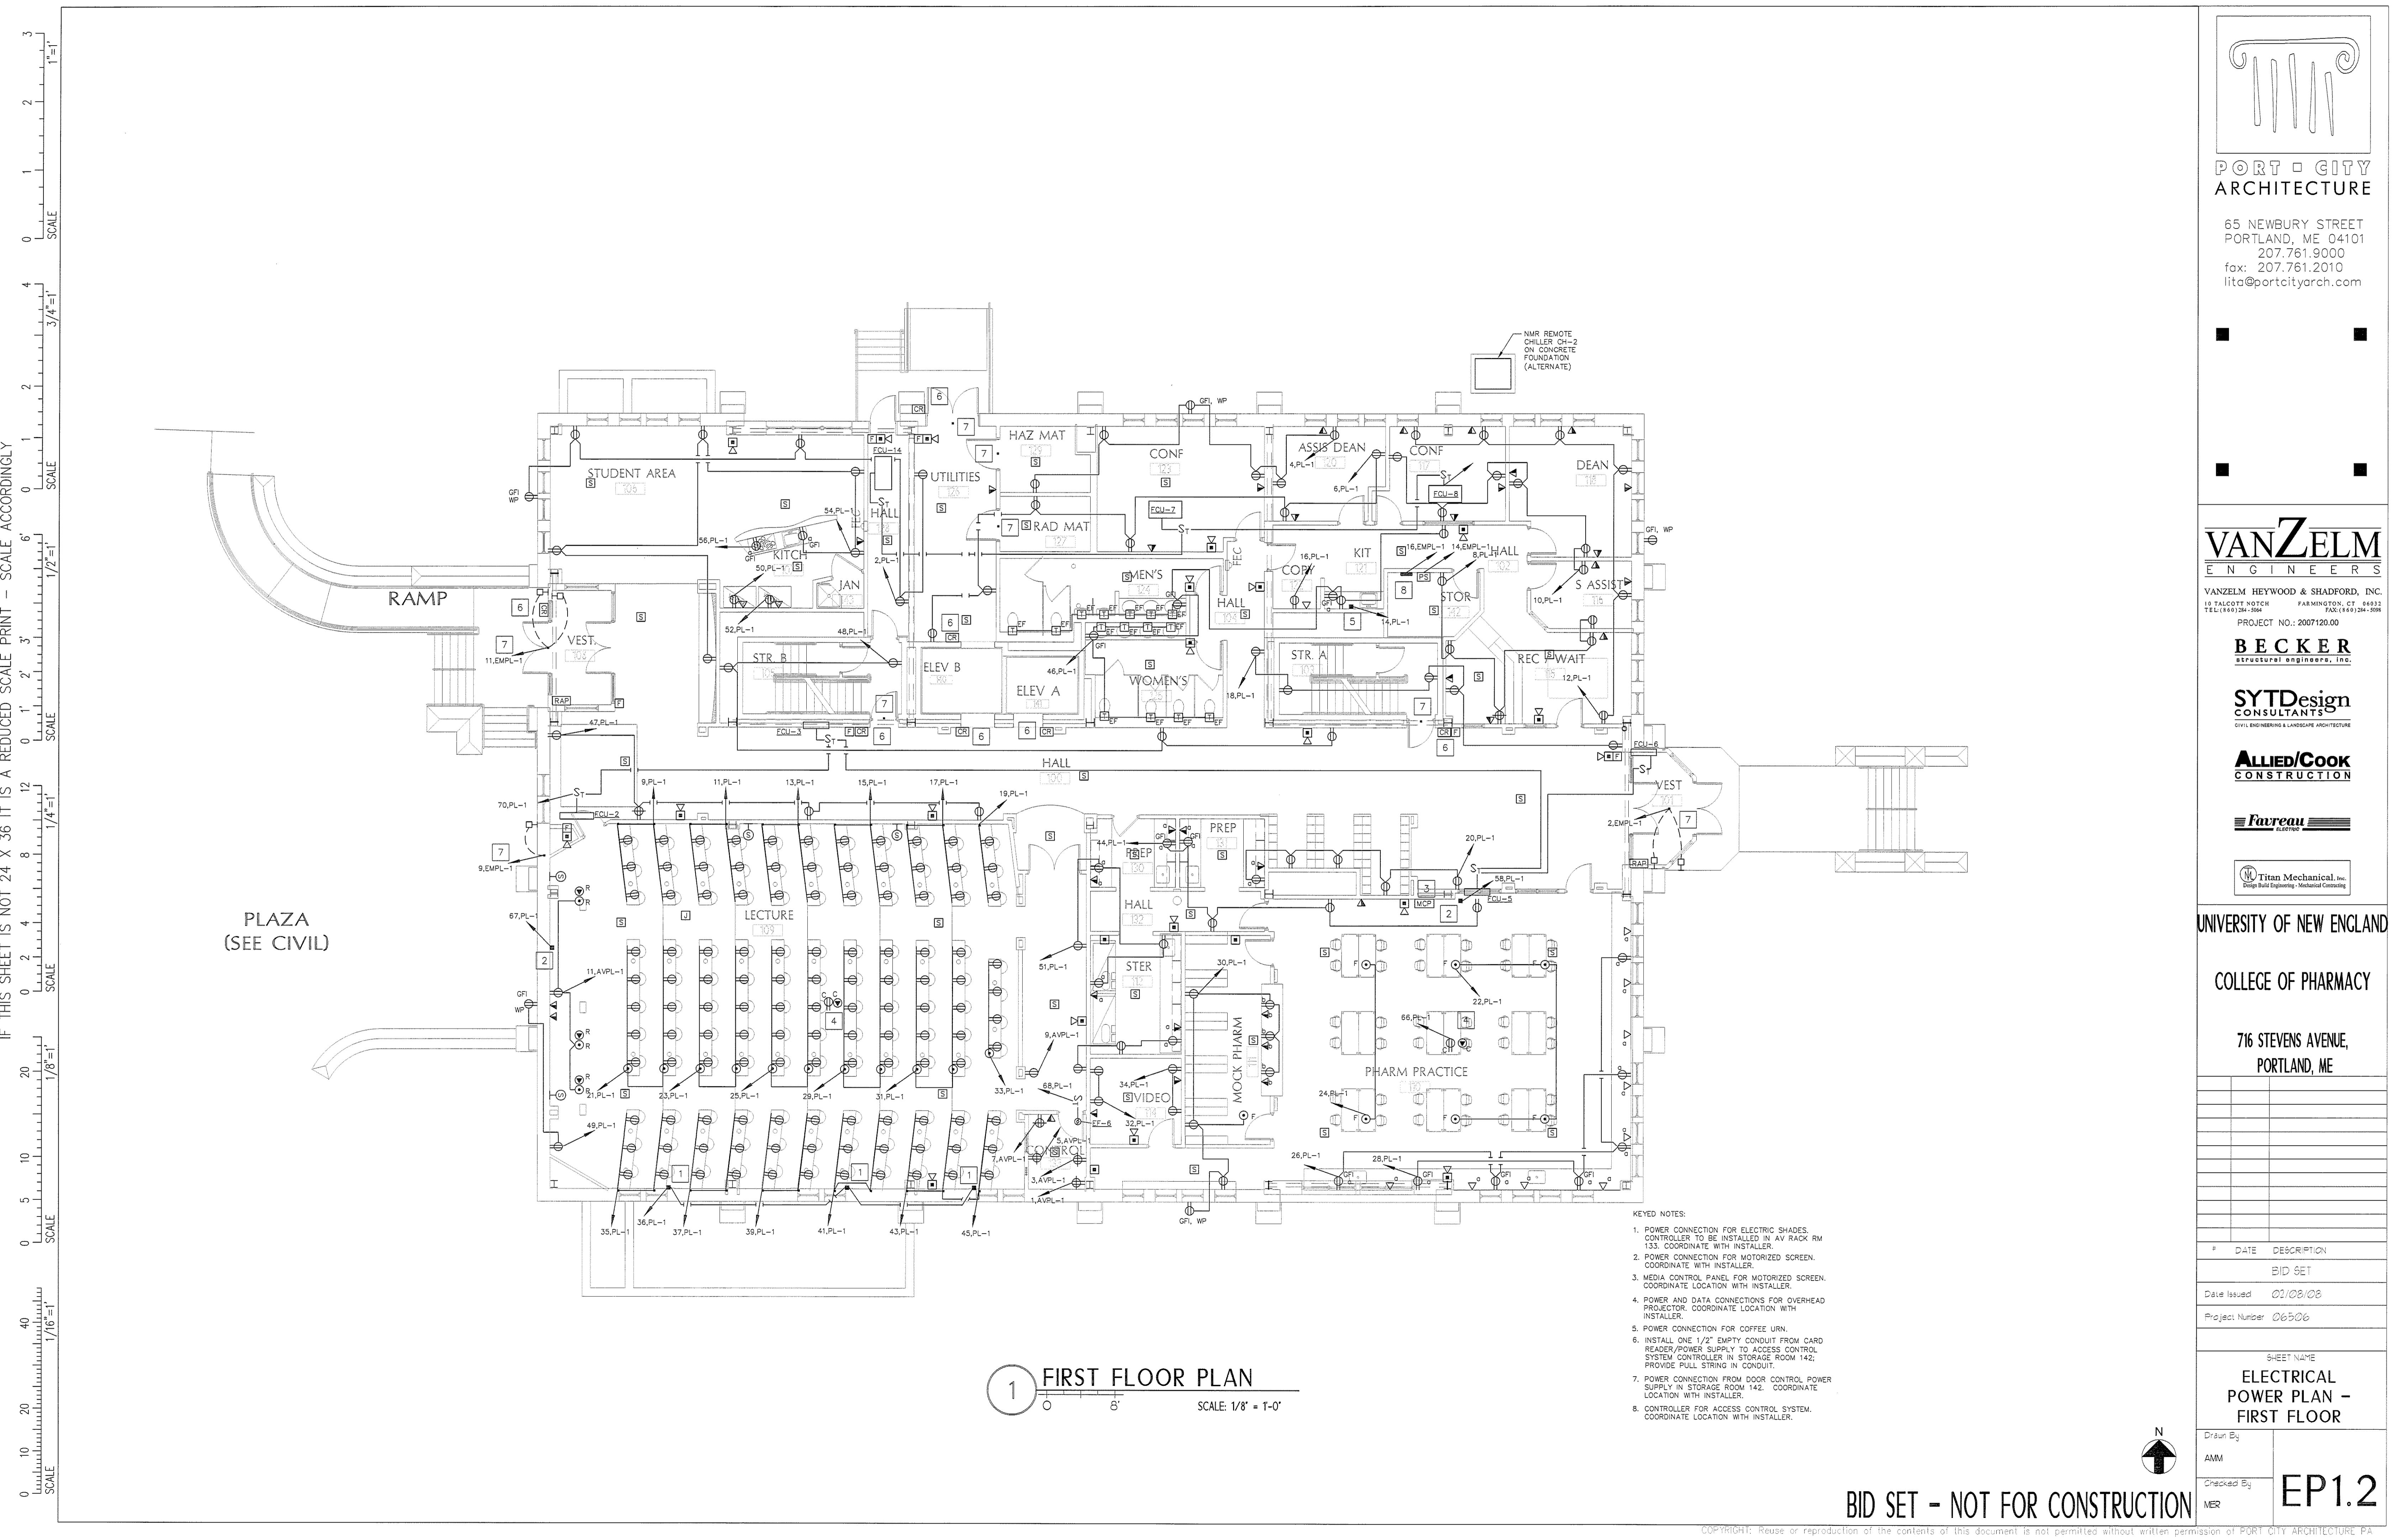

IF THIS SHEET IS NOT 24 X 36 IT IS A REDUCED SCALE PRINT - SCALE ACCORDINGLY

SCALE 1"=1'
 SCALE 3/4"=1'
 SCALE 1/2"=1'
 SCALE 1/4"=1'
 SCALE 1/8"=1'
 SCALE 1/16"=1'

