

PORT CITY ARCHITECTURE

65 NEWBURY STREET  
PORTLAND, ME 04101  
207.761.9000  
fax: 207.761.2010  
lita@portcityarch.com

**VANZELM**  
ENGINEERS

VANZELM HEYWOOD & SHADFORD, INC.  
19 TALCOTT NOTCH FARMINGTON, CT 06032  
TEL: (860) 384-5966 FAX: (860) 384-5986

PROJECT NO.: 2007120.00

**BECKER**  
structural engineers, inc.

**SYTDesign**  
CONSULTANTS  
CIVIL ENGINEERING & LANDSCAPE ARCHITECTURE

**ALLIED/COOK**  
CONSTRUCTION

**Favreau**  
LLC

**Titan Mechanical, Inc.**  
Design Build Engineering - Mechanical Contracting

UNIVERSITY OF NEW ENGLAND


COLLEGE OF PHARMACY

716 STEVENS AVENUE,  
PORTLAND, ME


#	DATE	DESCRIPTION
		BID SET
	02/08/08	Date Issued
	06306	Project Number

SHEET NAME  
**ELECTRICAL  
POWER PLAN -  
ATTIC**

Drawn By  
AMM  
Checked By  
MER  
**EP1.5**

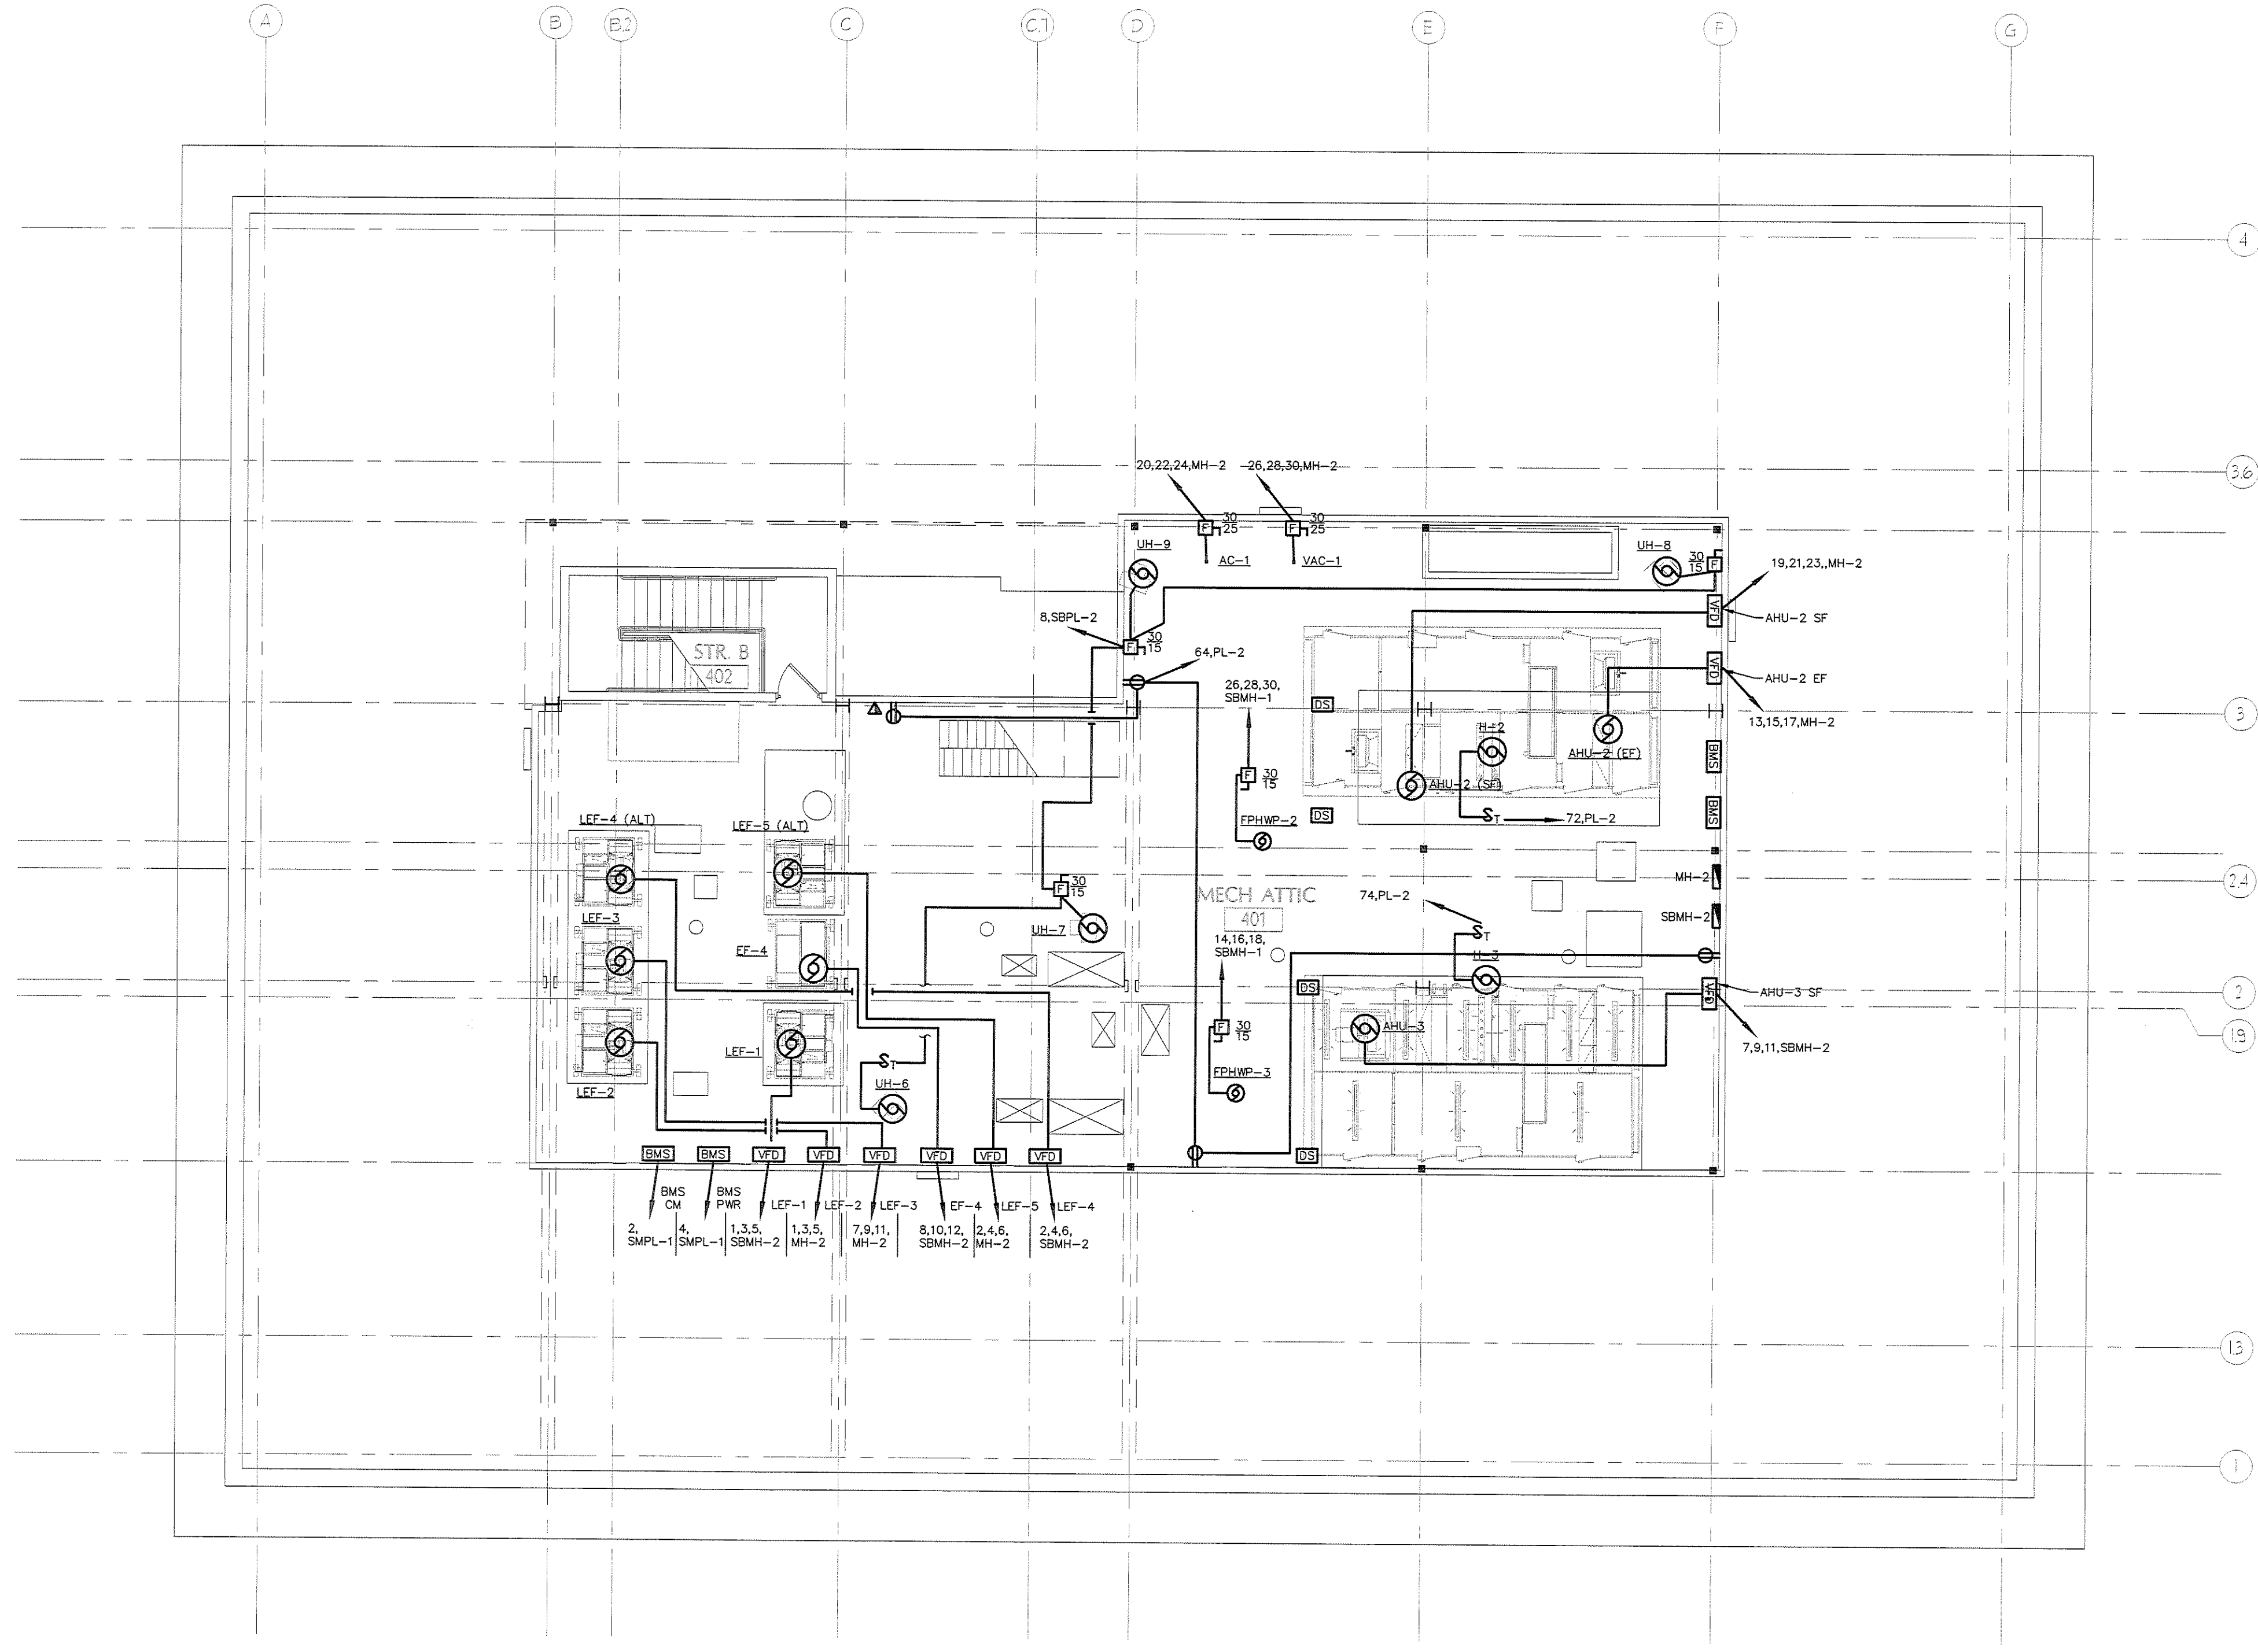

**1** ATTIC POWER PLAN  
SCALE 1/8" = 1'-0"

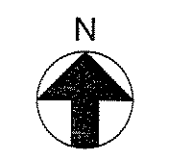

**BID SET - NOT FOR CONSTRUCTION**

IF THIS SHEET IS NOT 24 X 36 IT IS A REDUCED SCALE PRINT - SCALE ACCORDINGLY

0 1 2 3 4 5 6 7 8 9 10 11 12 13 14 15 16 17 18 19 20 21 22 23 24  
SCALE 1/16"=1'

0 1 2 3 4 5 6 7 8 9 10 11 12 13 14 15 16 17 18 19 20 21 22 23 24  
SCALE 1/8"=1'

0 1 2 3 4 5 6 7 8 9 10 11 12 13 14 15 16 17 18 19 20 21 22 23 24  
SCALE 1/4"=1'

0 1 2 3 4 5 6 7 8 9 10 11 12 13 14 15 16 17 18 19 20 21 22 23 24  
SCALE 3/4"=1'

0 1 2 3 4 5 6 7 8 9 10 11 12 13 14 15 16 17 18 19 20 21 22 23 24  
SCALE 1"=1'