


IF THIS SHEET IS NOT 24 X 36 IT IS A REDUCED SCALE PRINT - SCALE ACCORDINGLY

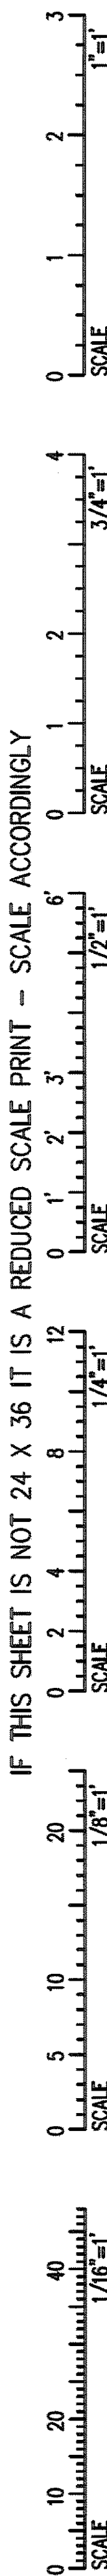

PANEL: EMLH-1, LOCATION: ELEC II 018, MAIN: 100A MCB, AIC: 22K. Table with columns: AMP, POLES, LOAD DESCRIPTION, KVA, VOLTAGE, MISC, REC, LTG, A, B, C, LOAD DESCRIPTION, AMP, POLES. Includes summary: CONNECTED LOAD (KVA): 3.5, DEMAND LOAD (KVA): 3.5, TOTAL CONNECTED LOAD (KV): 3.5, TOTAL DEMAND LOAD (KVA): 3.5, CONNECTED LOAD (A): 4.2, DEMAND LOAD (A): 4.2.

PANEL: EMLH-2, LOCATION: ENTRY 309, MAIN: 50A MCB, AIC: 22K. Table with columns: AMP, POLES, LOAD DESCRIPTION, KVA, VOLTAGE, MISC, REC, LTG, A, B, C, LOAD DESCRIPTION, AMP, POLES. Includes summary: CONNECTED LOAD (KVA): 1.3, DEMAND LOAD (KVA): 1.3, TOTAL CONNECTED LOAD (KV): 2.9, TOTAL DEMAND LOAD (KVA): 2.9, CONNECTED LOAD (A): 3.5, DEMAND LOAD (A): 3.5.

PANEL: EMLP-1, LOCATION: ELEC II 018, MAIN: 50A MCB, AIC: 10K. Table with columns: AMP, POLES, LOAD DESCRIPTION, KVA, VOLTAGE, MISC, REC, LTG, A, B, C, LOAD DESCRIPTION, AMP, POLES. Includes summary: CONNECTED LOAD (KVA): 2.2, DEMAND LOAD (KVA): 2.2, TOTAL CONNECTED LOAD (KV): 9.2, TOTAL DEMAND LOAD (KVA): 7.8, CONNECTED LOAD (A): 25.6, DEMAND LOAD (A): 21.7.


PANEL: SBPH-2, LOCATION: ELEC II 018, MAIN: 300A MCB, AIC: 22K. Table with columns: AMP, POLES, LOAD DESCRIPTION, KVA, VOLTAGE, MISC, REC, LTG, A, B, C, LOAD DESCRIPTION, AMP, POLES. Includes summary: CONNECTED LOAD (KVA): 11.4, DEMAND LOAD (KVA): 9.1, TOTAL CONNECTED LOAD (KV): 124.6, TOTAL DEMAND LOAD (KVA): 99.7, CONNECTED LOAD (A): 150.1, DEMAND LOAD (A): 120.1.

PANEL: AVPL-1, LOCATION: ELEC I 017, MAIN: 200A MCB, AIC: 10K. Table with columns: AMP, POLES, LOAD DESCRIPTION, KVA, VOLTAGE, MISC, REC, LTG, A, B, C, LOAD DESCRIPTION, AMP, POLES. Includes summary: CONNECTED LOAD (KVA): 2.6, DEMAND LOAD (KVA): 2.6, TOTAL CONNECTED LOAD (KV): 2.8, TOTAL DEMAND LOAD (KVA): 2.8, CONNECTED LOAD (A): 7.8, DEMAND LOAD (A): 7.8.

PANEL: SBPL-1, LOCATION: ELEC II 018, MAIN: 100A MCB, AIC: 10K. Table with columns: AMP, POLES, LOAD DESCRIPTION, KVA, VOLTAGE, MISC, REC, LTG, A, B, C, LOAD DESCRIPTION, AMP, POLES. Includes summary: CONNECTED LOAD (KVA): 1.0, DEMAND LOAD (KVA): 0.8, TOTAL CONNECTED LOAD (KV): 6.7, TOTAL DEMAND LOAD (KVA): 5.4, CONNECTED LOAD (A): 18.6, DEMAND LOAD (A): 15.0.

PANEL: SBMH-1, LOCATION: ELEC II 018, MAIN: 100A MCB, AIC: 22K. Table with columns: AMP, POLES, LOAD DESCRIPTION, KVA, VOLTAGE, MISC, REC, LTG, A, B, C, LOAD DESCRIPTION, AMP, POLES. Includes summary: CONNECTED LOAD (KVA): 49.2, DEMAND LOAD (KVA): 39.4, TOTAL CONNECTED LOAD (KV): 65.1, TOTAL DEMAND LOAD (KVA): 52.1, CONNECTED LOAD (A): 78.4, DEMAND LOAD (A): 62.7.

PANEL: SBLAB-1, LOCATION: ENTRY 309, MAIN: 100A MCB, AIC: 10K. Table with columns: AMP, POLES, LOAD DESCRIPTION, KVA, VOLTAGE, MISC, REC, LTG, A, B, C, LOAD DESCRIPTION, AMP, POLES. Includes summary: CONNECTED LOAD (KVA): 5.6, DEMAND LOAD (KVA): 5.6, TOTAL CONNECTED LOAD (KV): 11.4, TOTAL DEMAND LOAD (KVA): 11.4, CONNECTED LOAD (A): 31.7, DEMAND LOAD (A): 31.7.

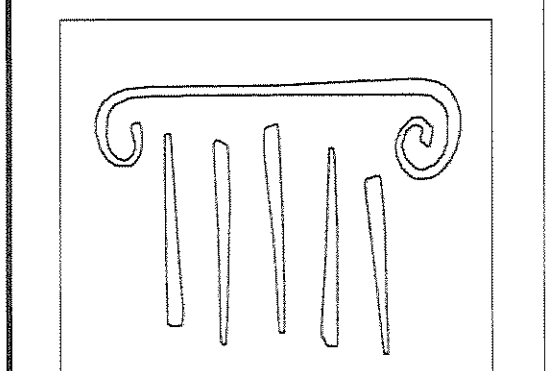

PORT CITY ARCHITECTURE, 65 NEWBURY STREET, PORTLAND, ME 04101, 207.761.9000, 207.761.2010, lita@portcityarch.com



VANZELM HEYWOOD & SHADFORD, INC., 19 TALCOTT NOTCH, FARMINGTON, CT 06032, TEL: (860) 394-3999, FAX: (860) 394-3998

PROJECT NO.: 2007120.00



CIVIL ENGINEERING & LANDSCAPE ARCHITECTURE



Design-Build Engineering - Mechanical Consulting

UNIVERSITY OF NEW ENGLAND COLLEGE OF PHARMACY

716 STEVENS AVENUE, PORTLAND, ME

Table with columns: #, DATE, DESCRIPTION. Includes entries for BID SET (01/08/08) and Project Number 06506.

SHEET NAME: ELECTRICAL SCHEDULES

Drawn By: AMM, Checked By: MER, E4.3

BID SET - NOT FOR CONSTRUCTION

COPYRIGHT: Reuse or reproduction of the contents of this document is not permitted without written permission of PORT CITY ARCHITECTURE PA