



IF THIS SHEET IS NOT 24 X 36 IT IS A REDUCED SCALE PRINT - SCALE ACCORDINGLY


Scale 1"=1'
 Scale 3/4"=1'
 Scale 1/2"=1'
 Scale 1/4"=1'
 Scale 1/8"=1'
 Scale 1/16"=1'

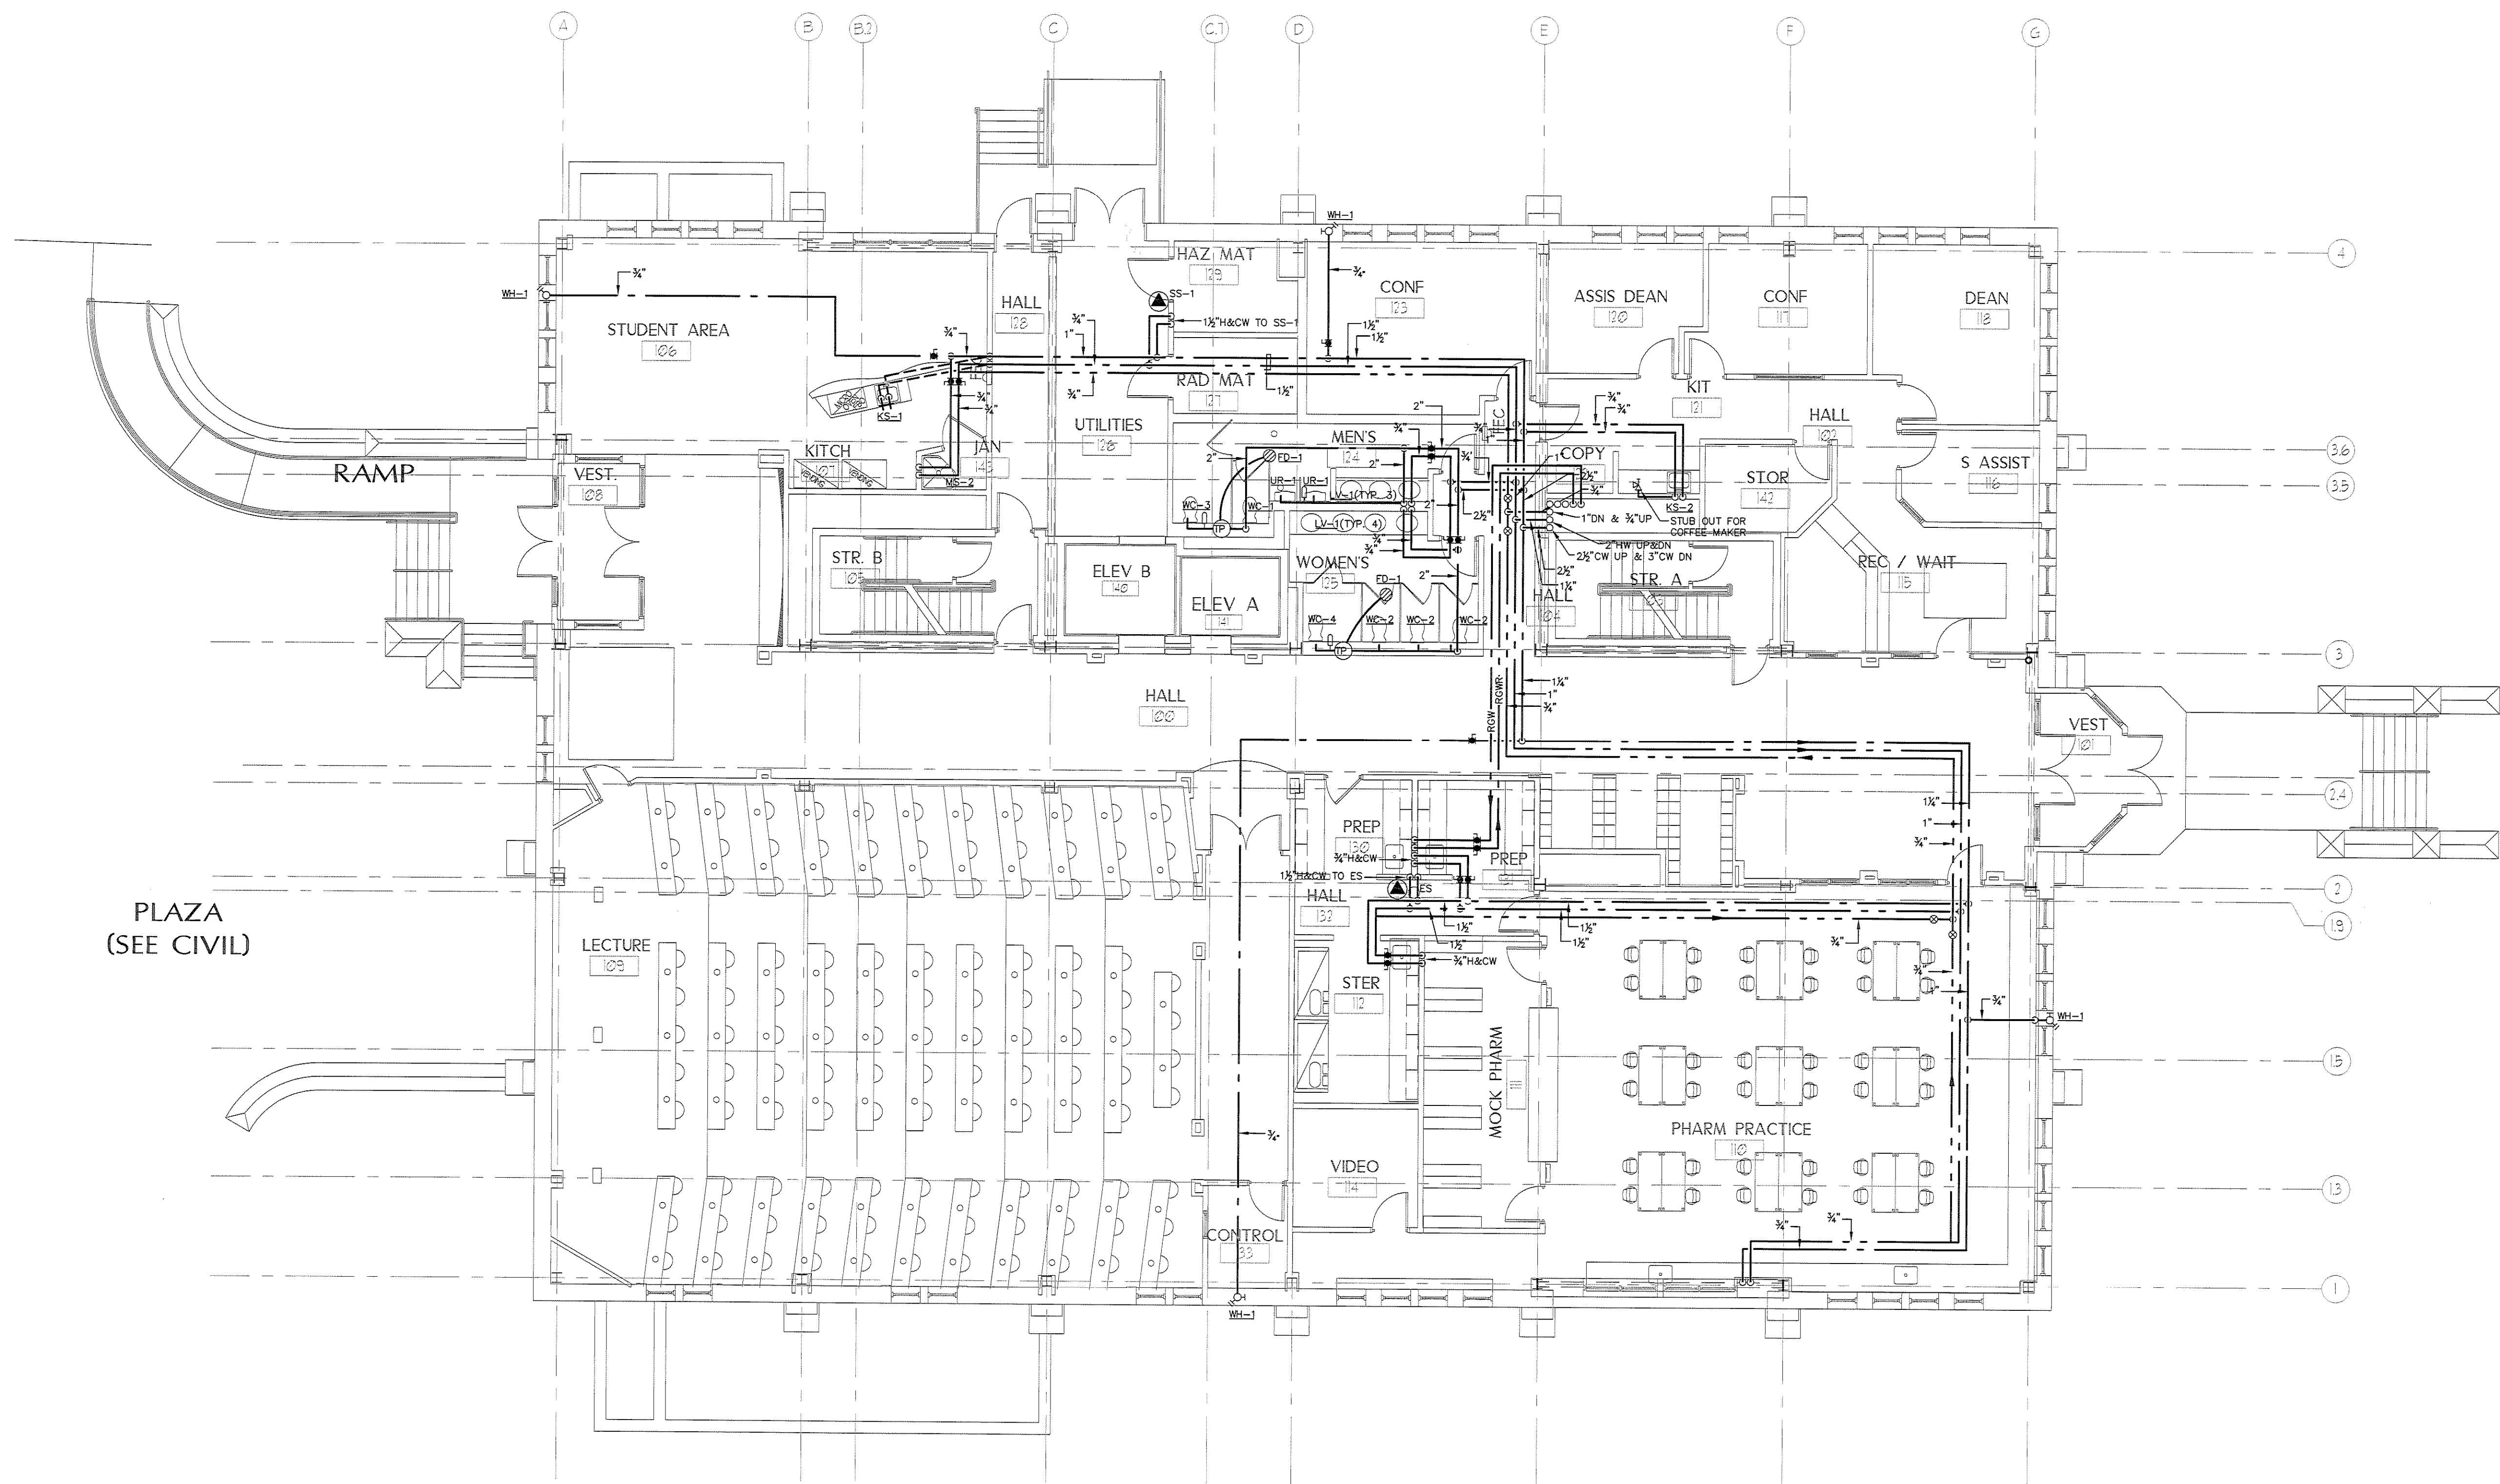

1 PLUMBING FIRST FLOOR PLAN - SUPPLY
 Scale: 1/8"=1'-0"

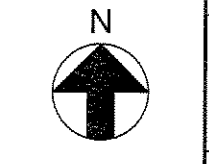

BID SET - NOT FOR CONSTRUCTION

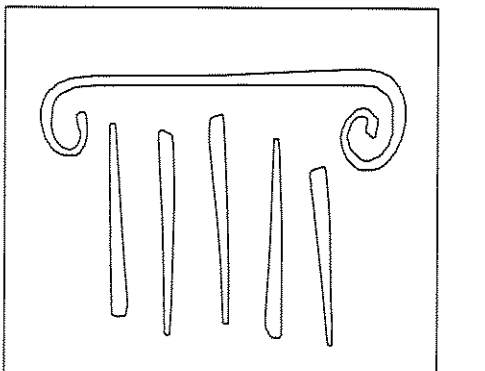

PORT CITY ARCHITECTURE

65 NEWBURY STREET
 PORTLAND, ME 04101
 207.761.9000
 fax: 207.761.2010
 lita@portcityarch.com

VANZELM ENGINEERS

VANZELM HEYWOOD & SHADFORD, INC.
 18 TALCOTT NOTCH FARMINGTON, CT 06032
 TEL: (860) 284-2964 FAX: (860) 284-2988
 PROJECT NO.: 2007120.00

BECKER
 structural engineers, inc.

SYTDesign CONSULTANTS
 CIVIL ENGINEERING & LANDSCAPE ARCHITECTURE

ALLIED/COOK CONSTRUCTION

Faireau
 FLOORING

Titan Mechanical, Inc.
 Design-Build Engineers - Mechanical Contractors

UNIVERSITY OF NEW ENGLAND

COLLEGE OF PHARMACY

**716 STEVENS AVENUE,
 PORTLAND, ME**

#	DATE	DESCRIPTION
		BID SET
	02/08/08	Date Issued
	06506	Project Number

PLUMBING FIRST FLOOR PLAN SUPPLY

Drawn By	SMS
Checked By	DUM

PS1.2