

PORT CITY ARCHITECTURE

65 NEWBURY STREET  
PORTLAND, ME 04101  
207.761.9000  
fax: 207.761.2010  
lita@portcityarch.com

**VANZELM**  
ENGINEERS

VANZELM HEYWOOD & SHADFORD, INC.  
10 TALCOTT NOTCH FARMINGTON, CT 06032  
TEL: (860) 284-0044 FAX: (860) 284-2098

PROJECT NO.: 2007120.00

**BECKER**  
structural engineers, inc.

**SYTDesign**  
CONSULTANTS  
CIVIL ENGINEERING & LANDSCAPE ARCHITECTURE

**ALLIED/COOK**  
CONSTRUCTION

**Favreau**  
GROUP

Titan Mechanical, Inc.  
Design-Build Engineering - Mechanical Contracting

UNIVERSITY OF NEW ENGLAND

COLLEGE OF PHARMACY

716 STEVENS AVENUE,  
PORTLAND, ME


#	DATE	DESCRIPTION
		BID SET
	02/08/08	Date Issued
	06506	Project Number

SHEET NAME  
**PLUMBING  
THIRD FLOOR  
PLAN SUPPLY**


Drawn By  
SMS  
Checked By  
DWM  
**PS1.4**

**BID SET - NOT FOR CONSTRUCTION**

COPYRIGHT: Reuse or reproduction of the contents of this document is not permitted without written permission of PORT CITY ARCHITECTURE PA

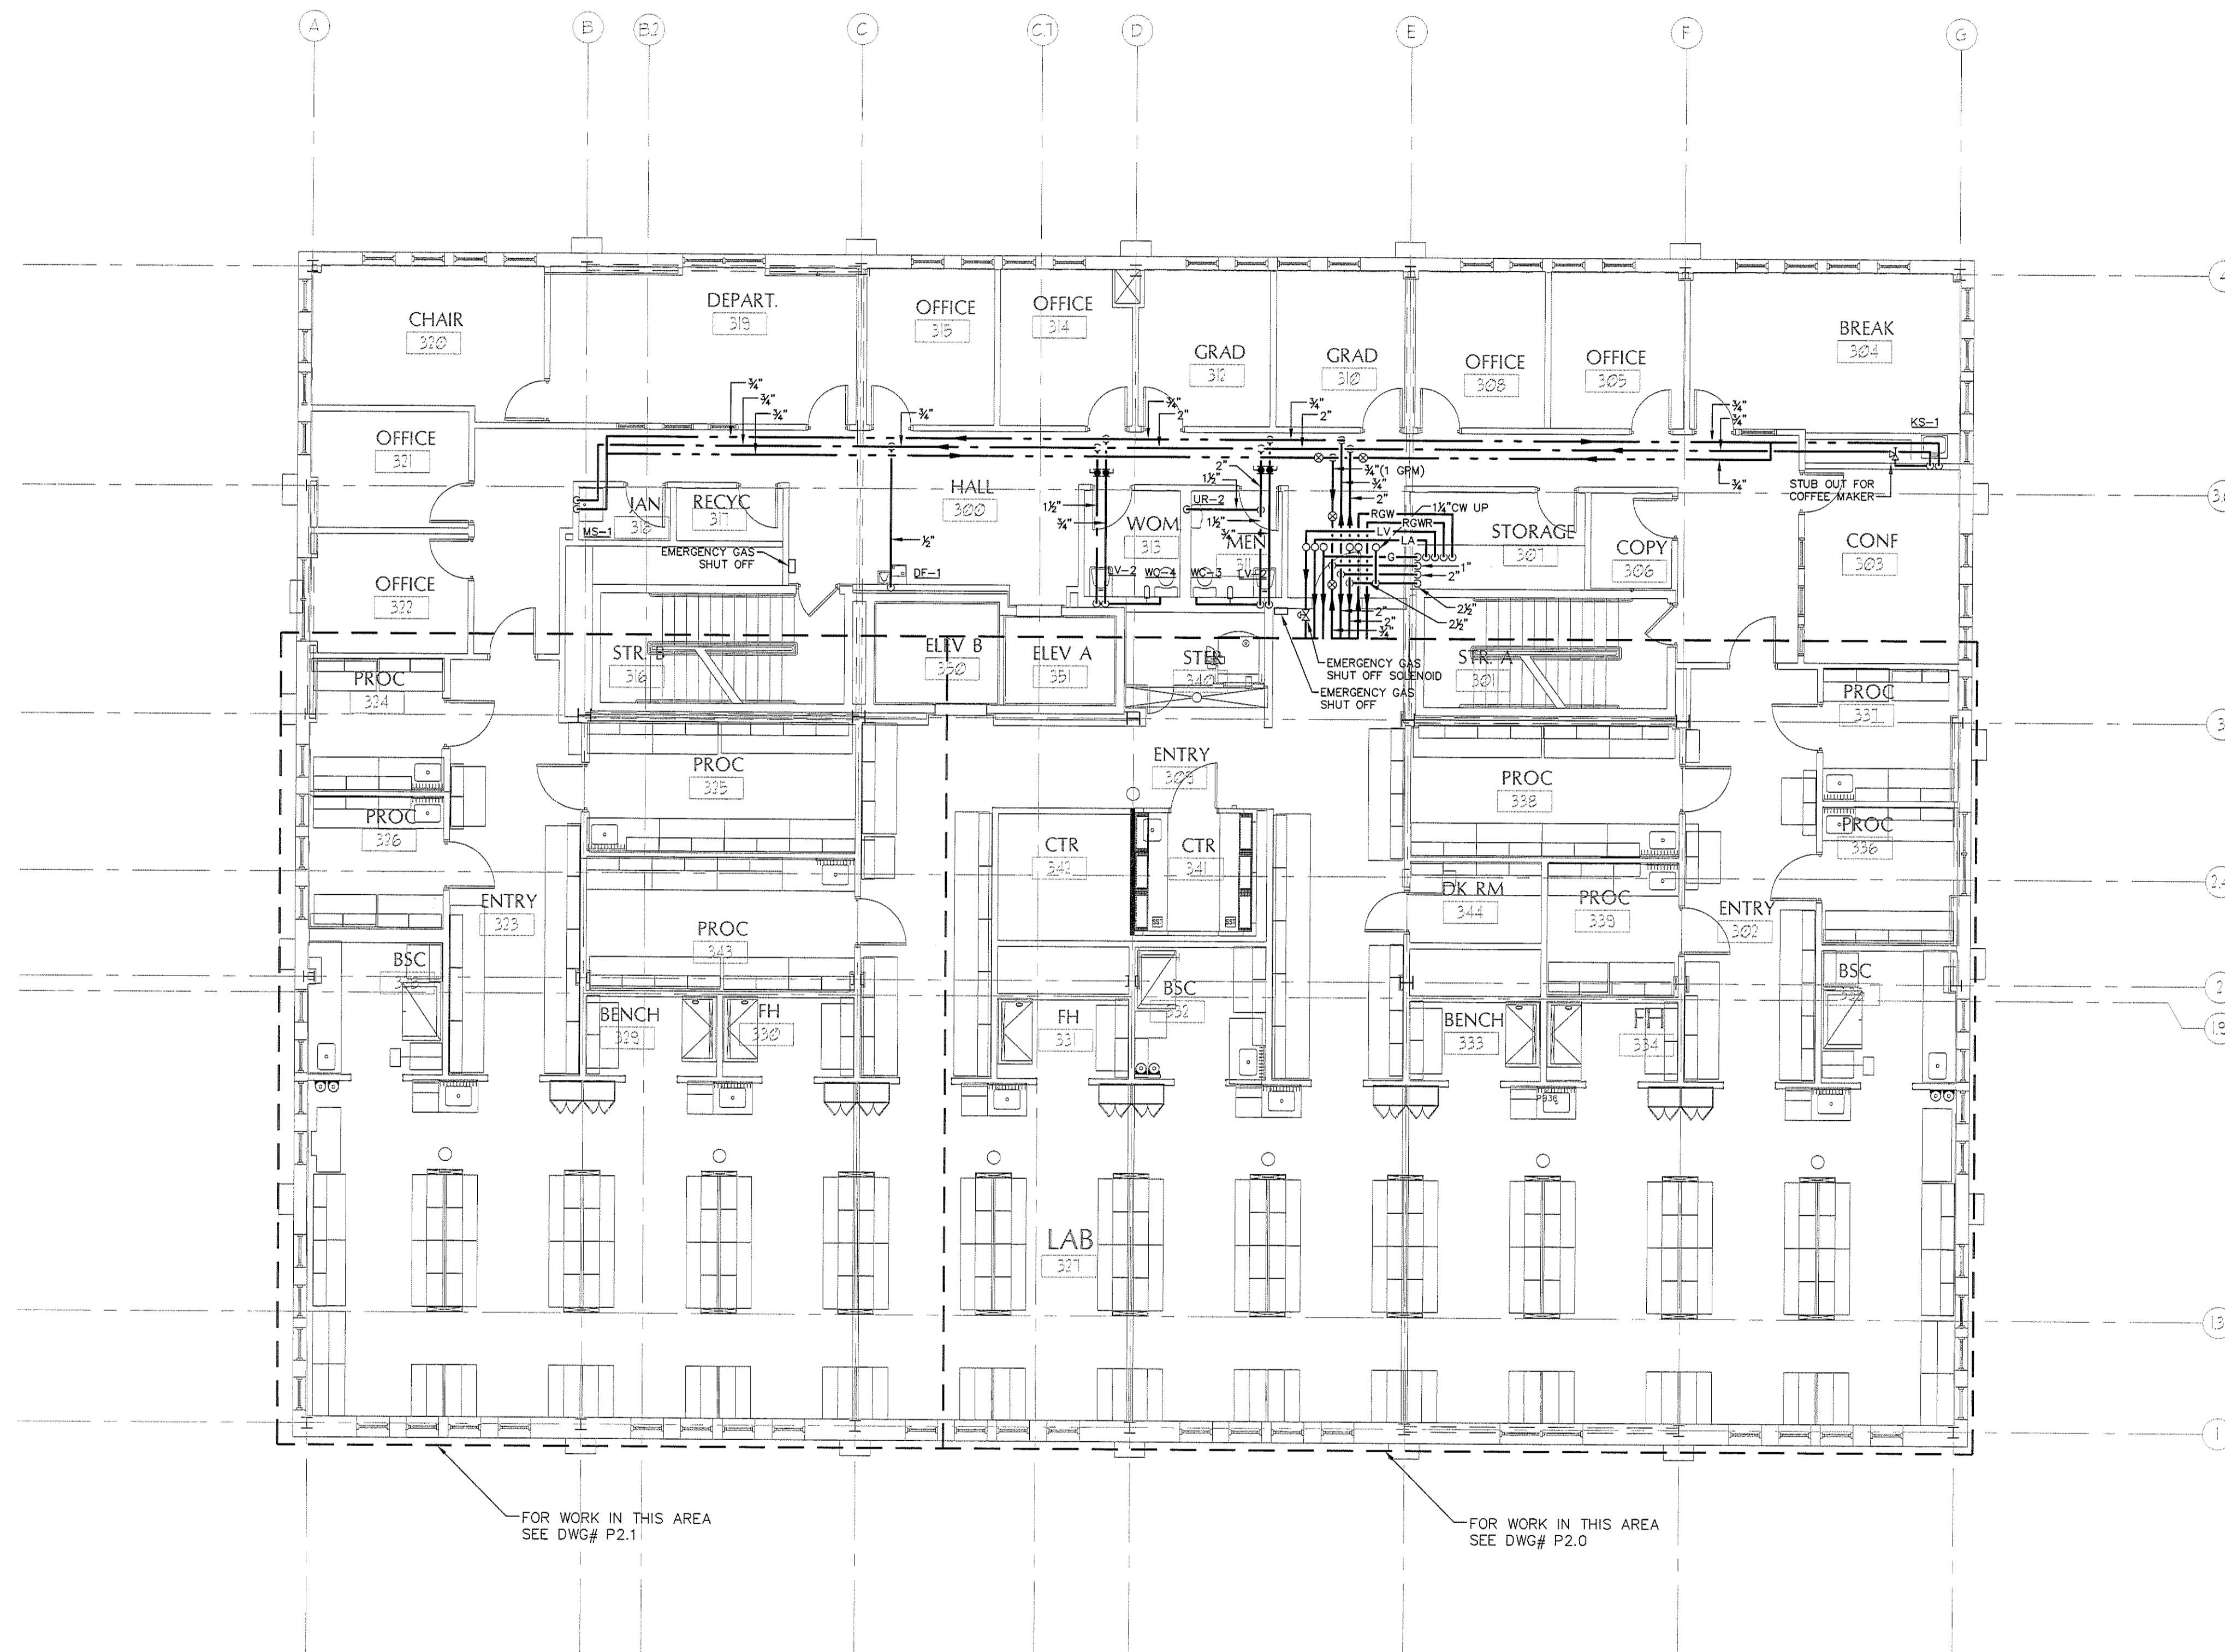

**1 PLUMBING THIRD FLOOR PLAN - SUPPLY**  
Scale: 1/8"=1'-0"

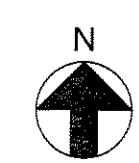

IF THIS SHEET IS NOT 24 X 36 IT IS A REDUCED SCALE PRINT - SCALE ACCORDINGLY

0 1 2 3  
SCALE 1"=1'

0 1 2 3 4  
SCALE 3/4"=1'

0 1 2 3 4 5 6  
SCALE 1/2"=1'

0 1 2 3 4 5 6 7 8 9 10 11 12  
SCALE 1/4"=1'

0 2 4 6 8 10 12 14 16 18 20  
SCALE 1/8"=1'

0 10 20 30 40  
SCALE 1/16"=1'