

PORT CITY ARCHITECTURE

65 NEWBURY STREET
PORTLAND, ME 04101
207.761.9000
fax: 207.761.2010
lita@portcityarch.com

VANZELM
ENGINEERS

VANZELM HEYWOOD & SHADFORD, INC.
16 TALCOTT NOTCH FARMINGTON, CT 06032
TEL: (860) 334-3564 FAX: (860) 334-3568

PROJECT NO.: 2007120.00

BECKER
structural engineers, inc.

SYTDesign
CONSULTANTS
CIVIL, ENGINEERING & LANDSCAPE ARCHITECTURE

ALLIED/COOK
CONSTRUCTION

Favreau
PLUMBING

Titan Mechanical, Inc.
Design-Build Engineering - Mechanical Contracting

UNIVERSITY OF NEW ENGLAND

COLLEGE OF PHARMACY

716 STEVENS AVENUE,
PORTLAND, ME

| # | DATE | DESCRIPTION |
|---|----------|----------------|
| | | BID SET |
| | 01/08/08 | Date Issued |
| | 06506 | Project Number |

PLUMBING FIRST FLOOR PLAN WASTE

Drawn By: SMS
Checked By: DIM
PW1.2

BID SET - NOT FOR CONSTRUCTION

IF THIS SHEET IS NOT 24 X 36 IT IS A REDUCED SCALE PRINT - SCALE ACCORDINGLY

0 1 2 3
SCALE 1"=1'


0 1 2 3 4
SCALE 3/4"=1'

0 1 2 3 4 5 6
SCALE 1/2"=1'

0 1 2 3 4 5 6 7 8 9 10 11 12
SCALE 1/4"=1'

0 1 2 3 4 5 6 7 8 9 10 11 12 13 14 15 16 17 18 19 20
SCALE 1/8"=1'

0 10 20 30 40
SCALE 1/16"=1'

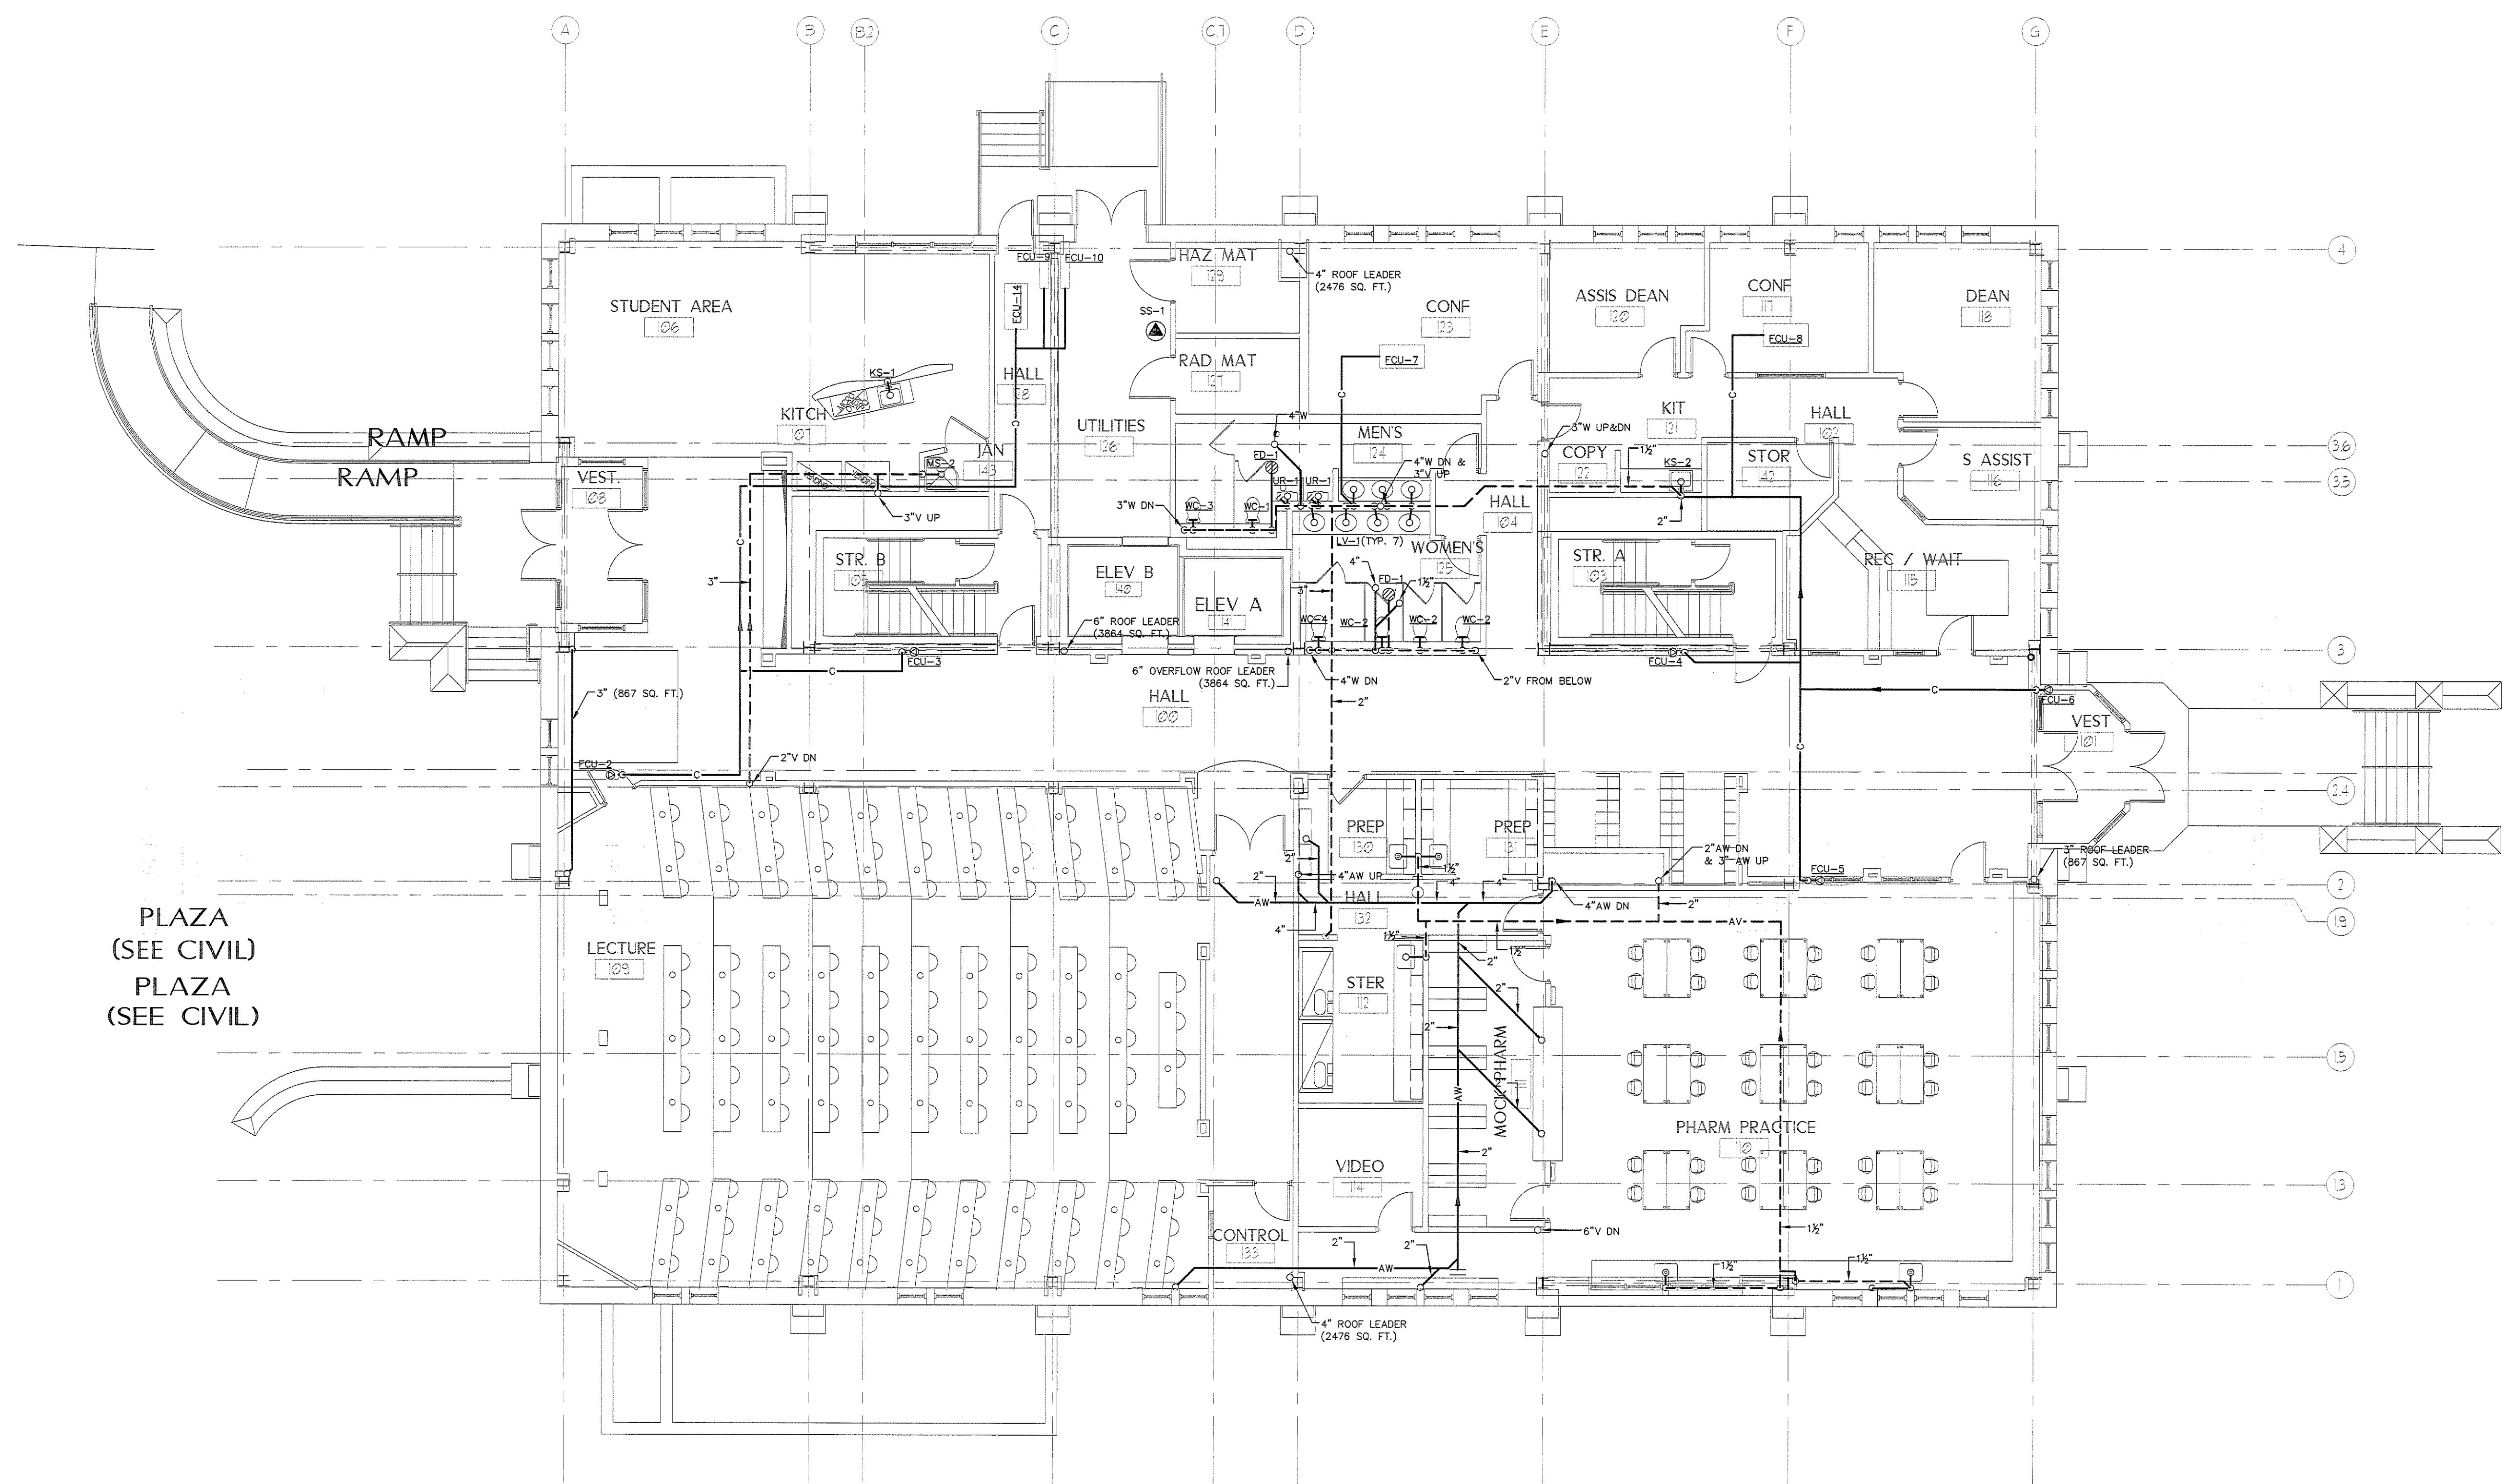

1 PLUMBING FIRST FLOOR PLAN - WASTE
Scale: 1/8"=1'-0"

