

**PORT CITY ARCHITECTURE**

65 NEWBURY STREET  
 PORTLAND, ME 04101  
 207.761.9000  
 fax: 207.761.2010  
 lita@portcityarch.com

**VANZELM ENGINEERS**

VANZELM HEYWOOD & SHADFORD, INC.  
 19 TALCOTT NOTCH FARMINGTON, CT 06032  
 TEL: (860) 384-1066 FAX: (860) 384-2998

PROJECT NO.: 2007120.00

**BECKER**  
 structural engineers, inc.

**SYTDesign**  
 CONSULTANTS  
 CIVIL ENGINEERING & LANDSCAPE ARCHITECTURE

**ALLIED/COOK**  
 CONSTRUCTION

**Faireau**  
 CLIMATE CONTROL

**Titan Mechanical, Inc.**  
 Design/Build Engineering - Mechanical Contracting


**UNIVERSITY OF NEW ENGLAND**

**COLLEGE OF PHARMACY**


716 STEVENS AVENUE,  
 PORTLAND, ME

IF THIS SHEET IS NOT 24 X 36 IT IS A REDUCED SCALE PRINT - SCALE ACCORDINGLY

SCALE 1"=1'  
 SCALE 3/4"=1'  
 SCALE 1/2"=1'  
 SCALE 1/4"=1'  
 SCALE 1/8"=1'  
 SCALE 1/16"=1'

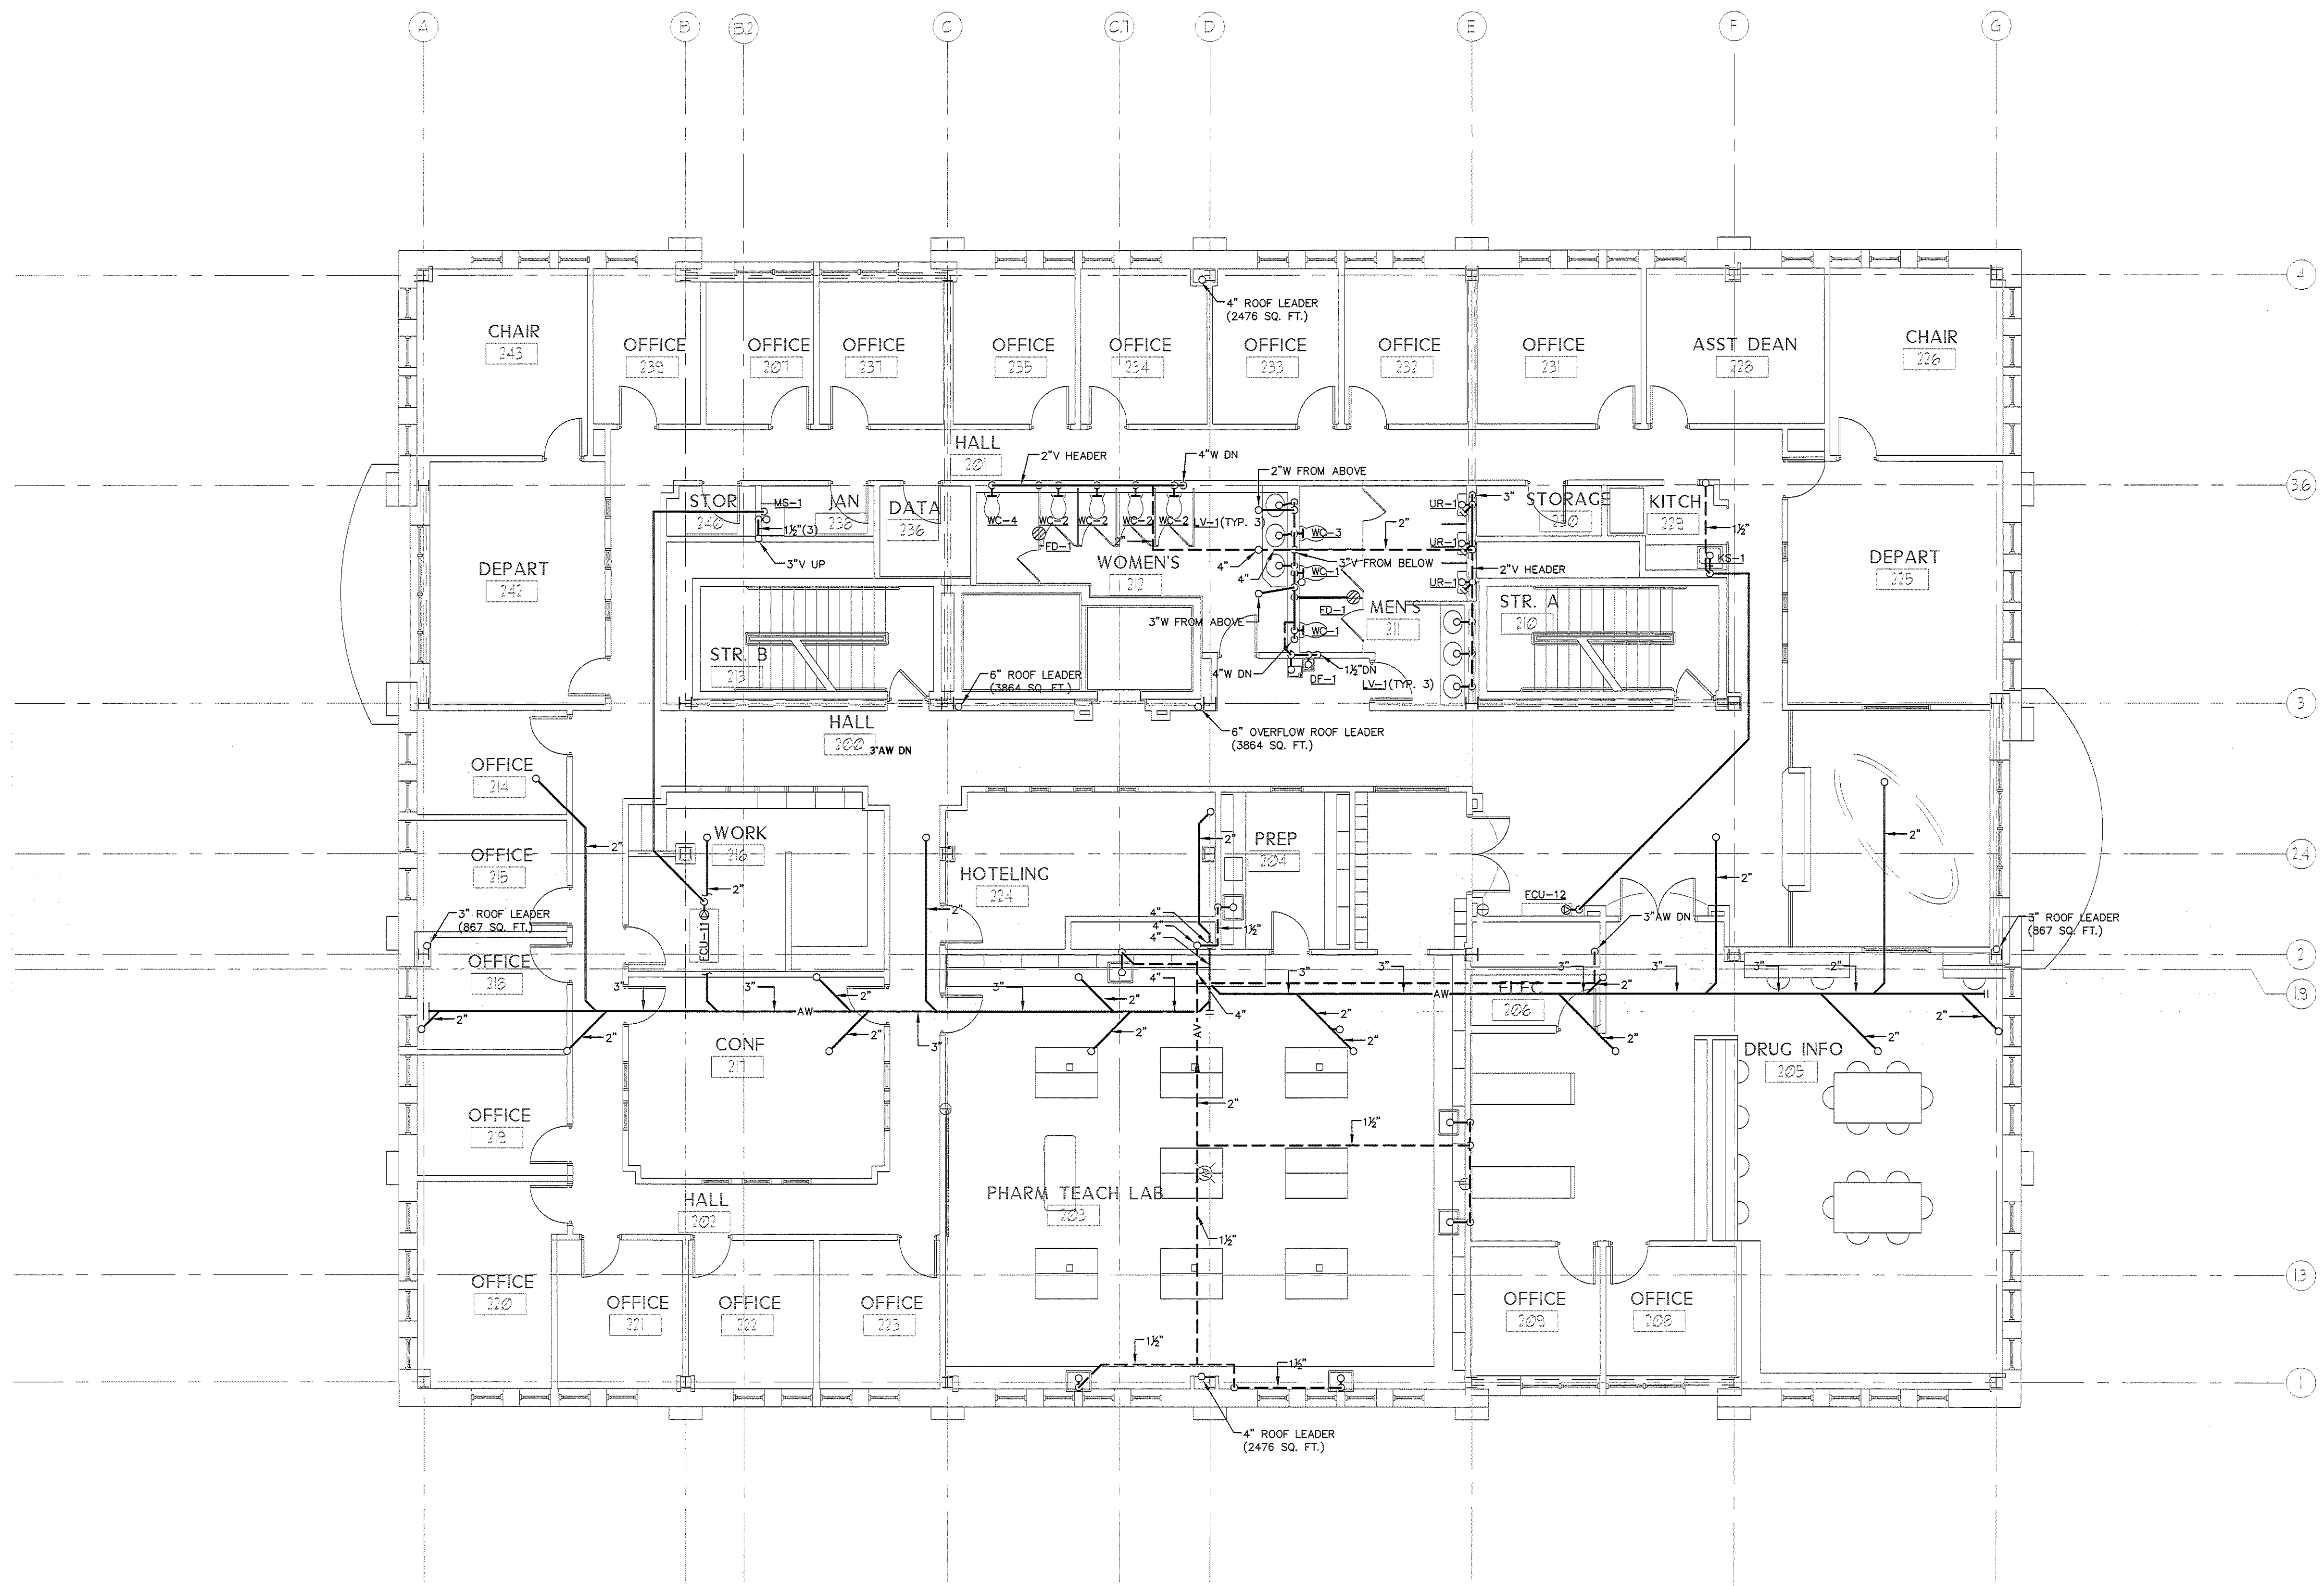

**1 PLUMBING SECOND FLOOR PLAN - WASTE**  
 Scale: 1/8"=1'-0"

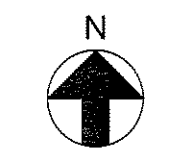

**BID SET - NOT FOR CONSTRUCTION**

#	DATE	DESCRIPTION
		BID SET
	02/08/08	Date Issued
	06506	Project Number
SHEET NAME		
<b>PLUMBING SECOND FLOOR PLAN WASTE</b>		
Drawn By	SMS	<b>PW1.3</b>
Checked By	DUM	