

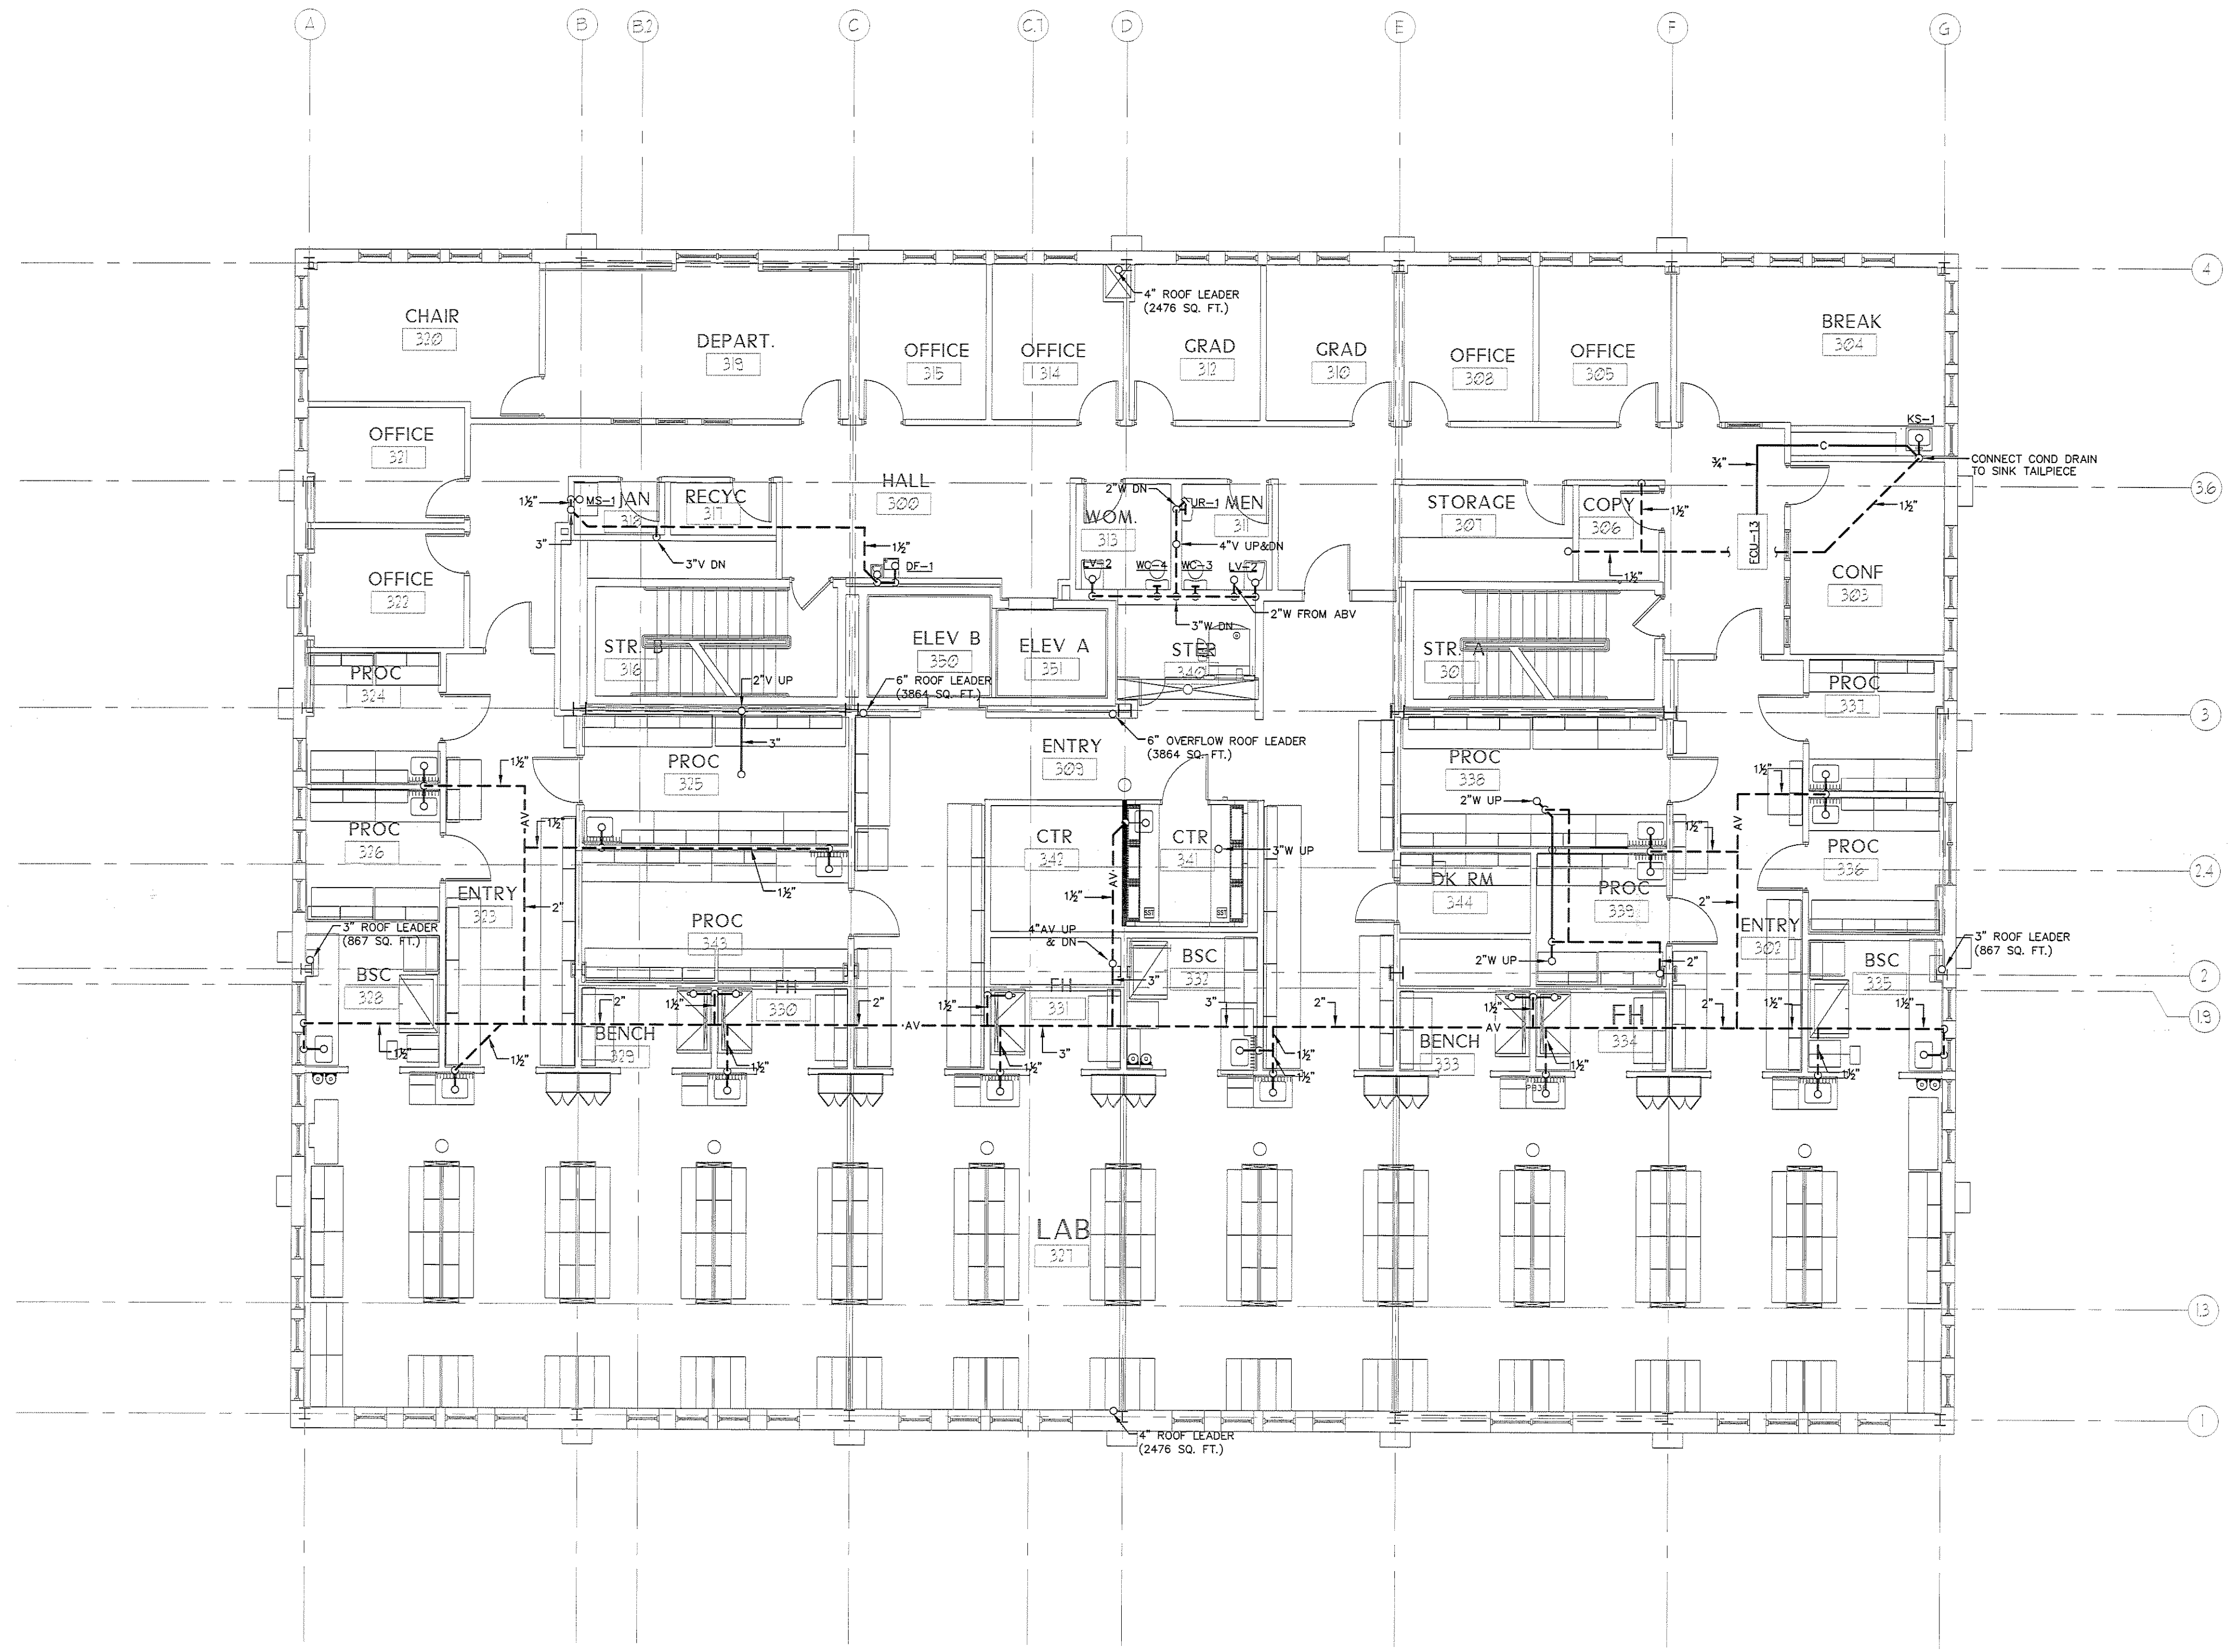


IF THIS SHEET IS NOT 24 X 36 IT IS A REDUCED SCALE PRINT - SCALE ACCORDINGLY

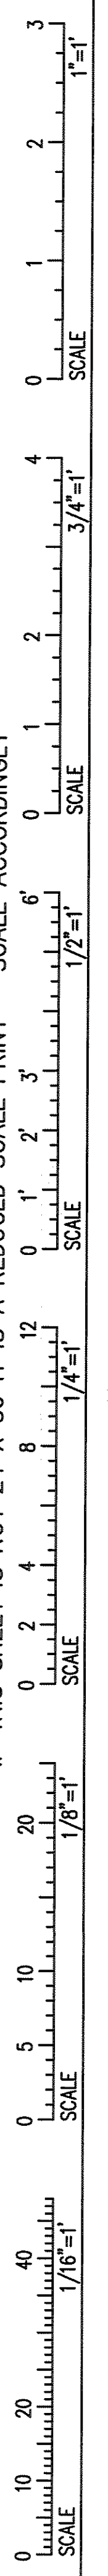

1 PLUMBING THIRD FLOOR PLAN - WASTE
Scale: 1/8"=1'-0"

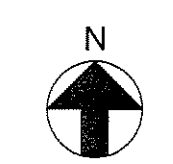

PORT CITY ARCHITECTURE
65 NEWBURY STREET
PORTLAND, ME 04101
207.761.9000
fax: 207.761.2010
lita@portcityarch.com

VANZELM ENGINEERS
VANZELM HEYWOOD & SHADFORD, INC.
10 TALCOTT NOTCH FARMINGTON, CT 06032
TEL: (860) 284-3004 FAX: (860) 284-3099
PROJECT NO.: 2007120.00

BECKER
Structural engineers, Inc.

SYTDesign CONSULTANTS
CIVIL ENGINEERING & LANDSCAPE ARCHITECTURE

ALLIED/COOK CONSTRUCTION

Favreau
ELECTRICAL

Titan Mechanical, Inc.
Mechanical Engineering - Mechanical Contracting

UNIVERSITY OF NEW ENGLAND
COLLEGE OF PHARMACY
716 STEVENS AVENUE,
PORTLAND, ME

#	DATE	DESCRIPTION
		BID SET
	01/08/08	Date Issued
	06506	Project Number

SHEET NAME	
PLUMBING THIRD FLOOR PLAN WASTE	
Drawn By	SMS
Checked By	DWM

PW1.4

BID SET - NOT FOR CONSTRUCTION