

PORT CITY ARCHITECTURE

65 NEWBURY STREET
PORTLAND, ME 04101
207.761.9000
fax: 207.761.2010
lita@portcityarch.com

VANZELM
ENGINEERS

VANZELM HEYWOOD & SHADFORD, INC.
18 FALCOTT NOTCH FARMINGTON, CT 06032
TEL: (860) 284-5966 FAX: (860) 284-5968

PROJECT NO.: 2007120.00

BECKER
structural engineers, inc.

SYTDesign
CONSULTANTS
CIVIL ENGINEERING & LANDSCAPE ARCHITECTURE

ALLIED/COOK
CONSTRUCTION

Faireau
CLERKS

Titan Mechanical, Inc.
Design-Build Engineering - Mechanical Contracting

UNIVERSITY OF NEW ENGLAND


COLLEGE OF PHARMACY

716 STEVENS AVENUE,
PORTLAND, ME


#	DATE	DESCRIPTION
		BID SET
	02/03/08	Date issued
	06506	Project Number

SHEET NAME
PLUMBING ROOF PLAN

Drawn By: SMS
Checked By: DWM
P1.6

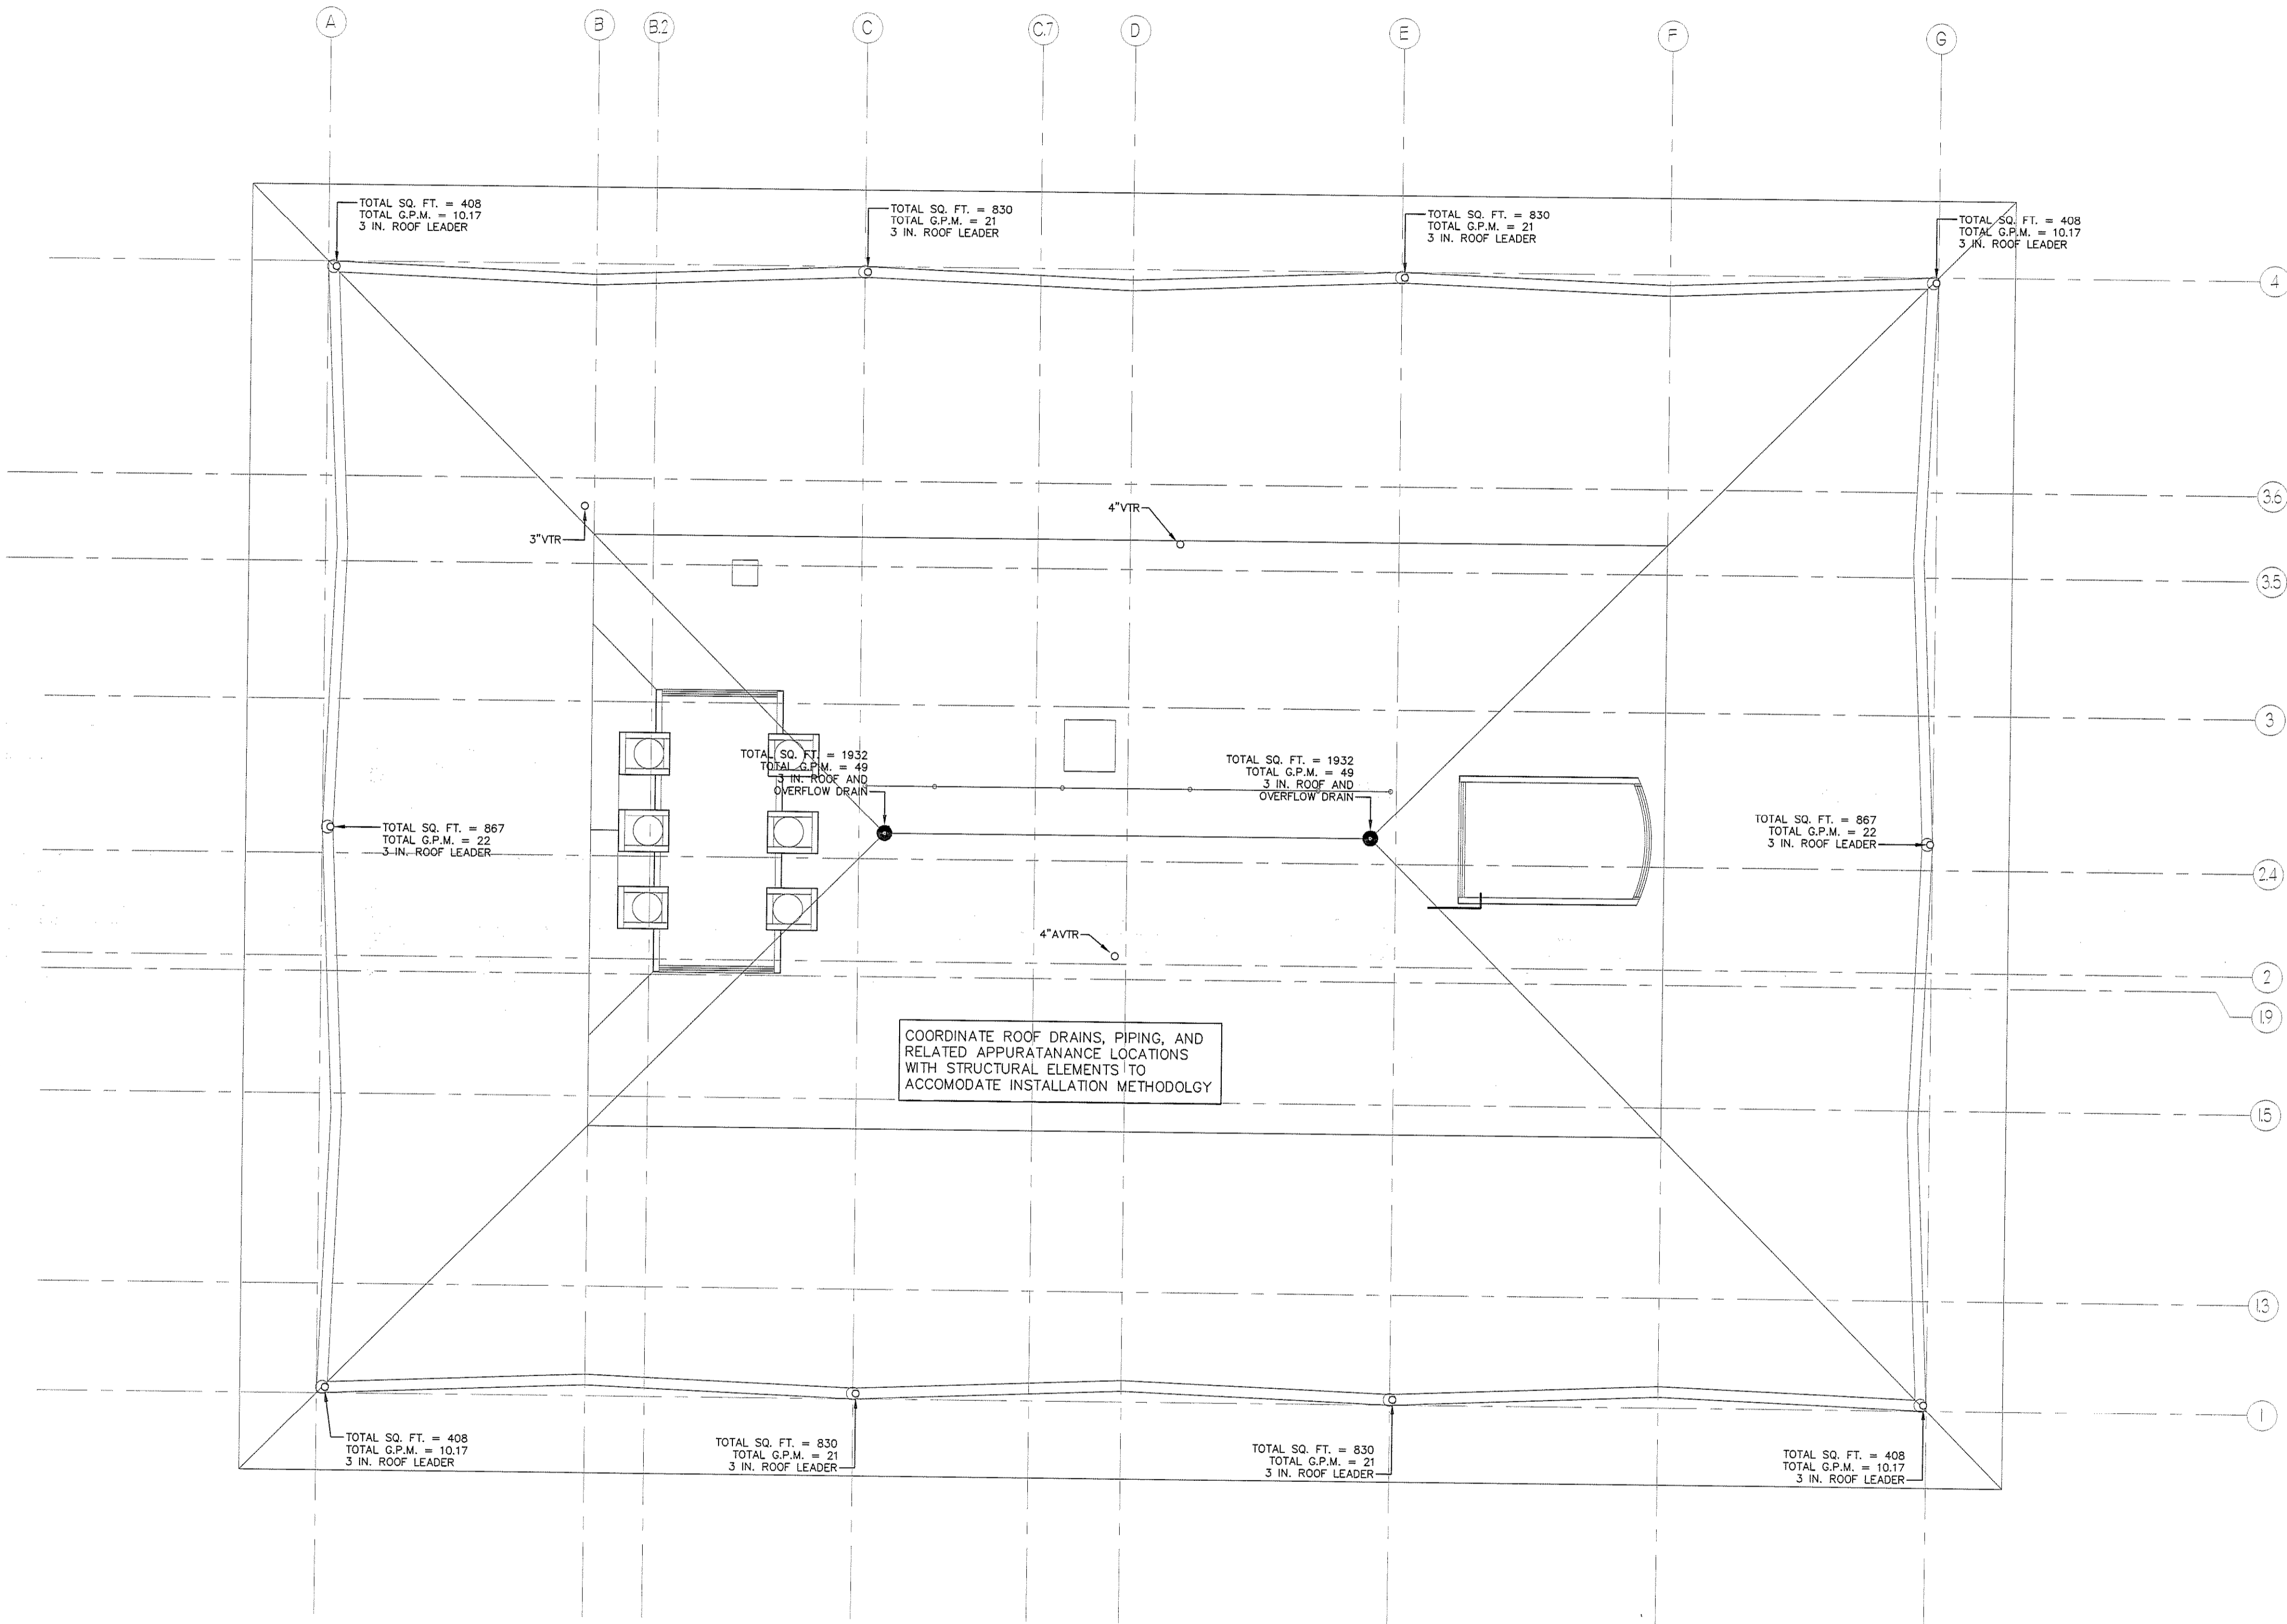

1 PLUMBING ROOF PLAN
Scale: 1/8"=1'-0"

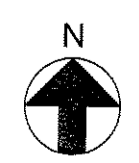

BID SET - NOT FOR CONSTRUCTION

IF THIS SHEET IS NOT 24 X 36 IT IS A REDUCED SCALE PRINT - SCALE ACCORDINGLY

0 1 2 3
SCALE 1"=1'

0 1 2 3 4
SCALE 3/4"=1'

0 1 2 3 4 5 6
SCALE 1/2"=1'

0 1 2 3 4 5 6 7 8 9 10 11 12
SCALE 1/4"=1'

0 2 4 6 8 10 12 14 16 18 20 22 24 26 28 30 32 34 36 38 40
SCALE 1/8"=1'