

IF THIS SHEET IS NOT 24 X 36 IT IS A REDUCED SCALE PRINT - SCALE ACCORDINGLY

0 1 2 3 4 5 6 7 8 9 10 11 12  
SCALE 1/4"=1'


0 1 2 3 4 5 6 7 8 9 10 11 12  
SCALE 1/8"=1'

0 1 2 3 4 5 6 7 8 9 10 11 12  
SCALE 1/16"=1'


0 1 2 3 4 5 6 7 8 9 10 11 12  
SCALE 3/4"=1'

0 1 2 3 4 5 6 7 8 9 10 11 12  
SCALE 1/2"=1'

0 1 2 3 4 5 6 7 8 9 10 11 12  
SCALE 1"=1'

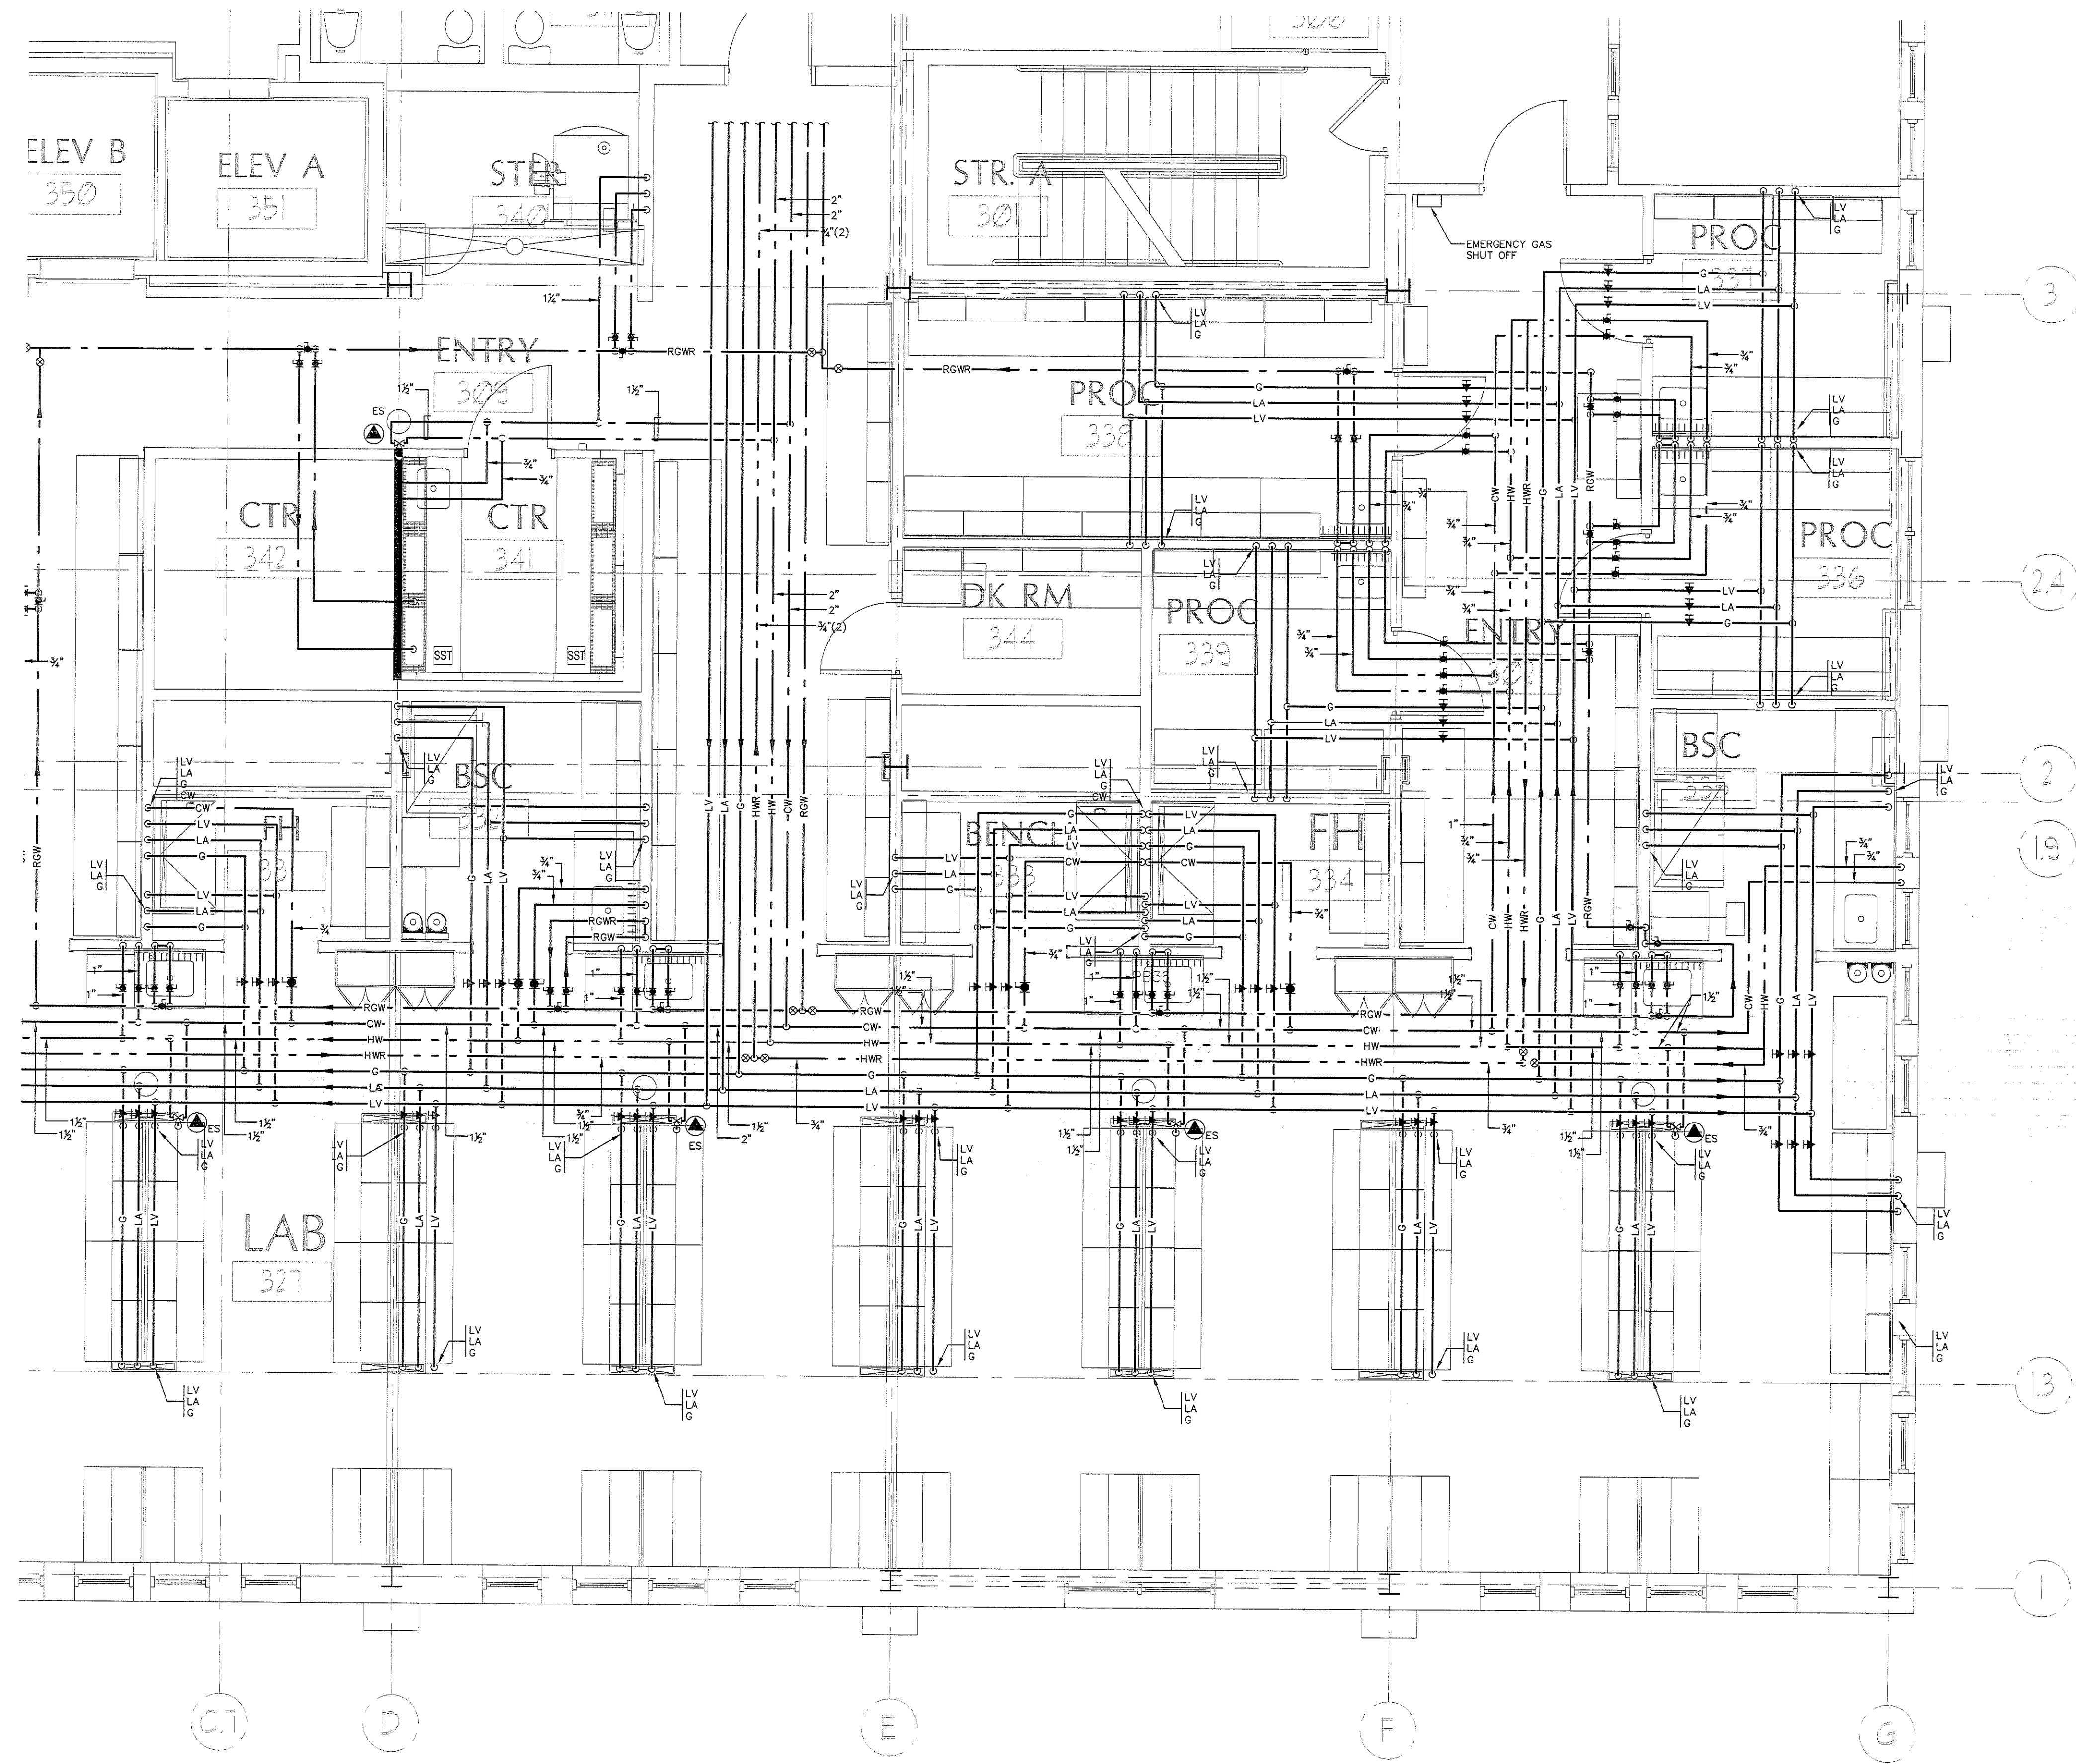

1 PLUMBING THIRD FLOOR PLAN ENLARGED - A  
Scale: 1/8"=1'-0"

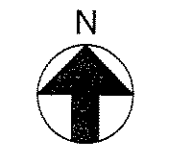

**PORT CITY ARCHITECTURE**  
65 NEWBURY STREET  
PORTLAND, ME 04101  
207.761.9000  
fax: 207.761.2010  
lita@portcityarch.com

**VANZELM ENGINEERS**  
VANZELM HEYWOOD & SHADFORD, INC.  
10 TALCOTT NOTCH FARMINGTON, CT 06032  
TEL: (860) 284-2064 FAX: (860) 284-2098  
PROJECT NO.: 2007120.00

**BECKER**  
Structural Engineers, Inc.

**SYTDesign CONSULTANTS**  
CIVIL ENGINEERING & LANDSCAPE ARCHITECTURE

**ALLIED/COOK CONSTRUCTION**

**Furman**

**Titan Mechanical, Inc.**  
Design-Build Engineering - Mechanical Contractors

**UNIVERSITY OF NEW ENGLAND**  
**COLLEGE OF PHARMACY**  
716 STEVENS AVENUE,  
PORTLAND, ME

#	DATE	DESCRIPTION
		BID SET
	02/08/08	Date Issued
	06306	Project Number

SHEET NAME  
**PLUMBING THIRD FLOOR PLAN ENLARGED - A**

Drawn By: SMS  
Checked By: DWM

**P2.0**

**BID SET - NOT FOR CONSTRUCTION**