


IF THIS SHEET IS NOT 24 X 36 IT IS A REDUCED SCALE PRINT - SCALE ACCORDINGLY

0 1 2 3 4 5 6 7 8 9 10 11 12 13 14 15 16 17 18 19 20 21 22 23 24  
SCALE 1/8"=1'


0 1 2 3 4 5 6 7 8 9 10 11 12 13 14 15 16 17 18 19 20 21 22 23 24  
SCALE 1/4"=1'

0 1 2 3 4 5 6 7 8 9 10 11 12 13 14 15 16 17 18 19 20 21 22 23 24  
SCALE 3/4"=1'

0 1 2 3 4 5 6 7 8 9 10 11 12 13 14 15 16 17 18 19 20 21 22 23 24  
SCALE 1"=1'

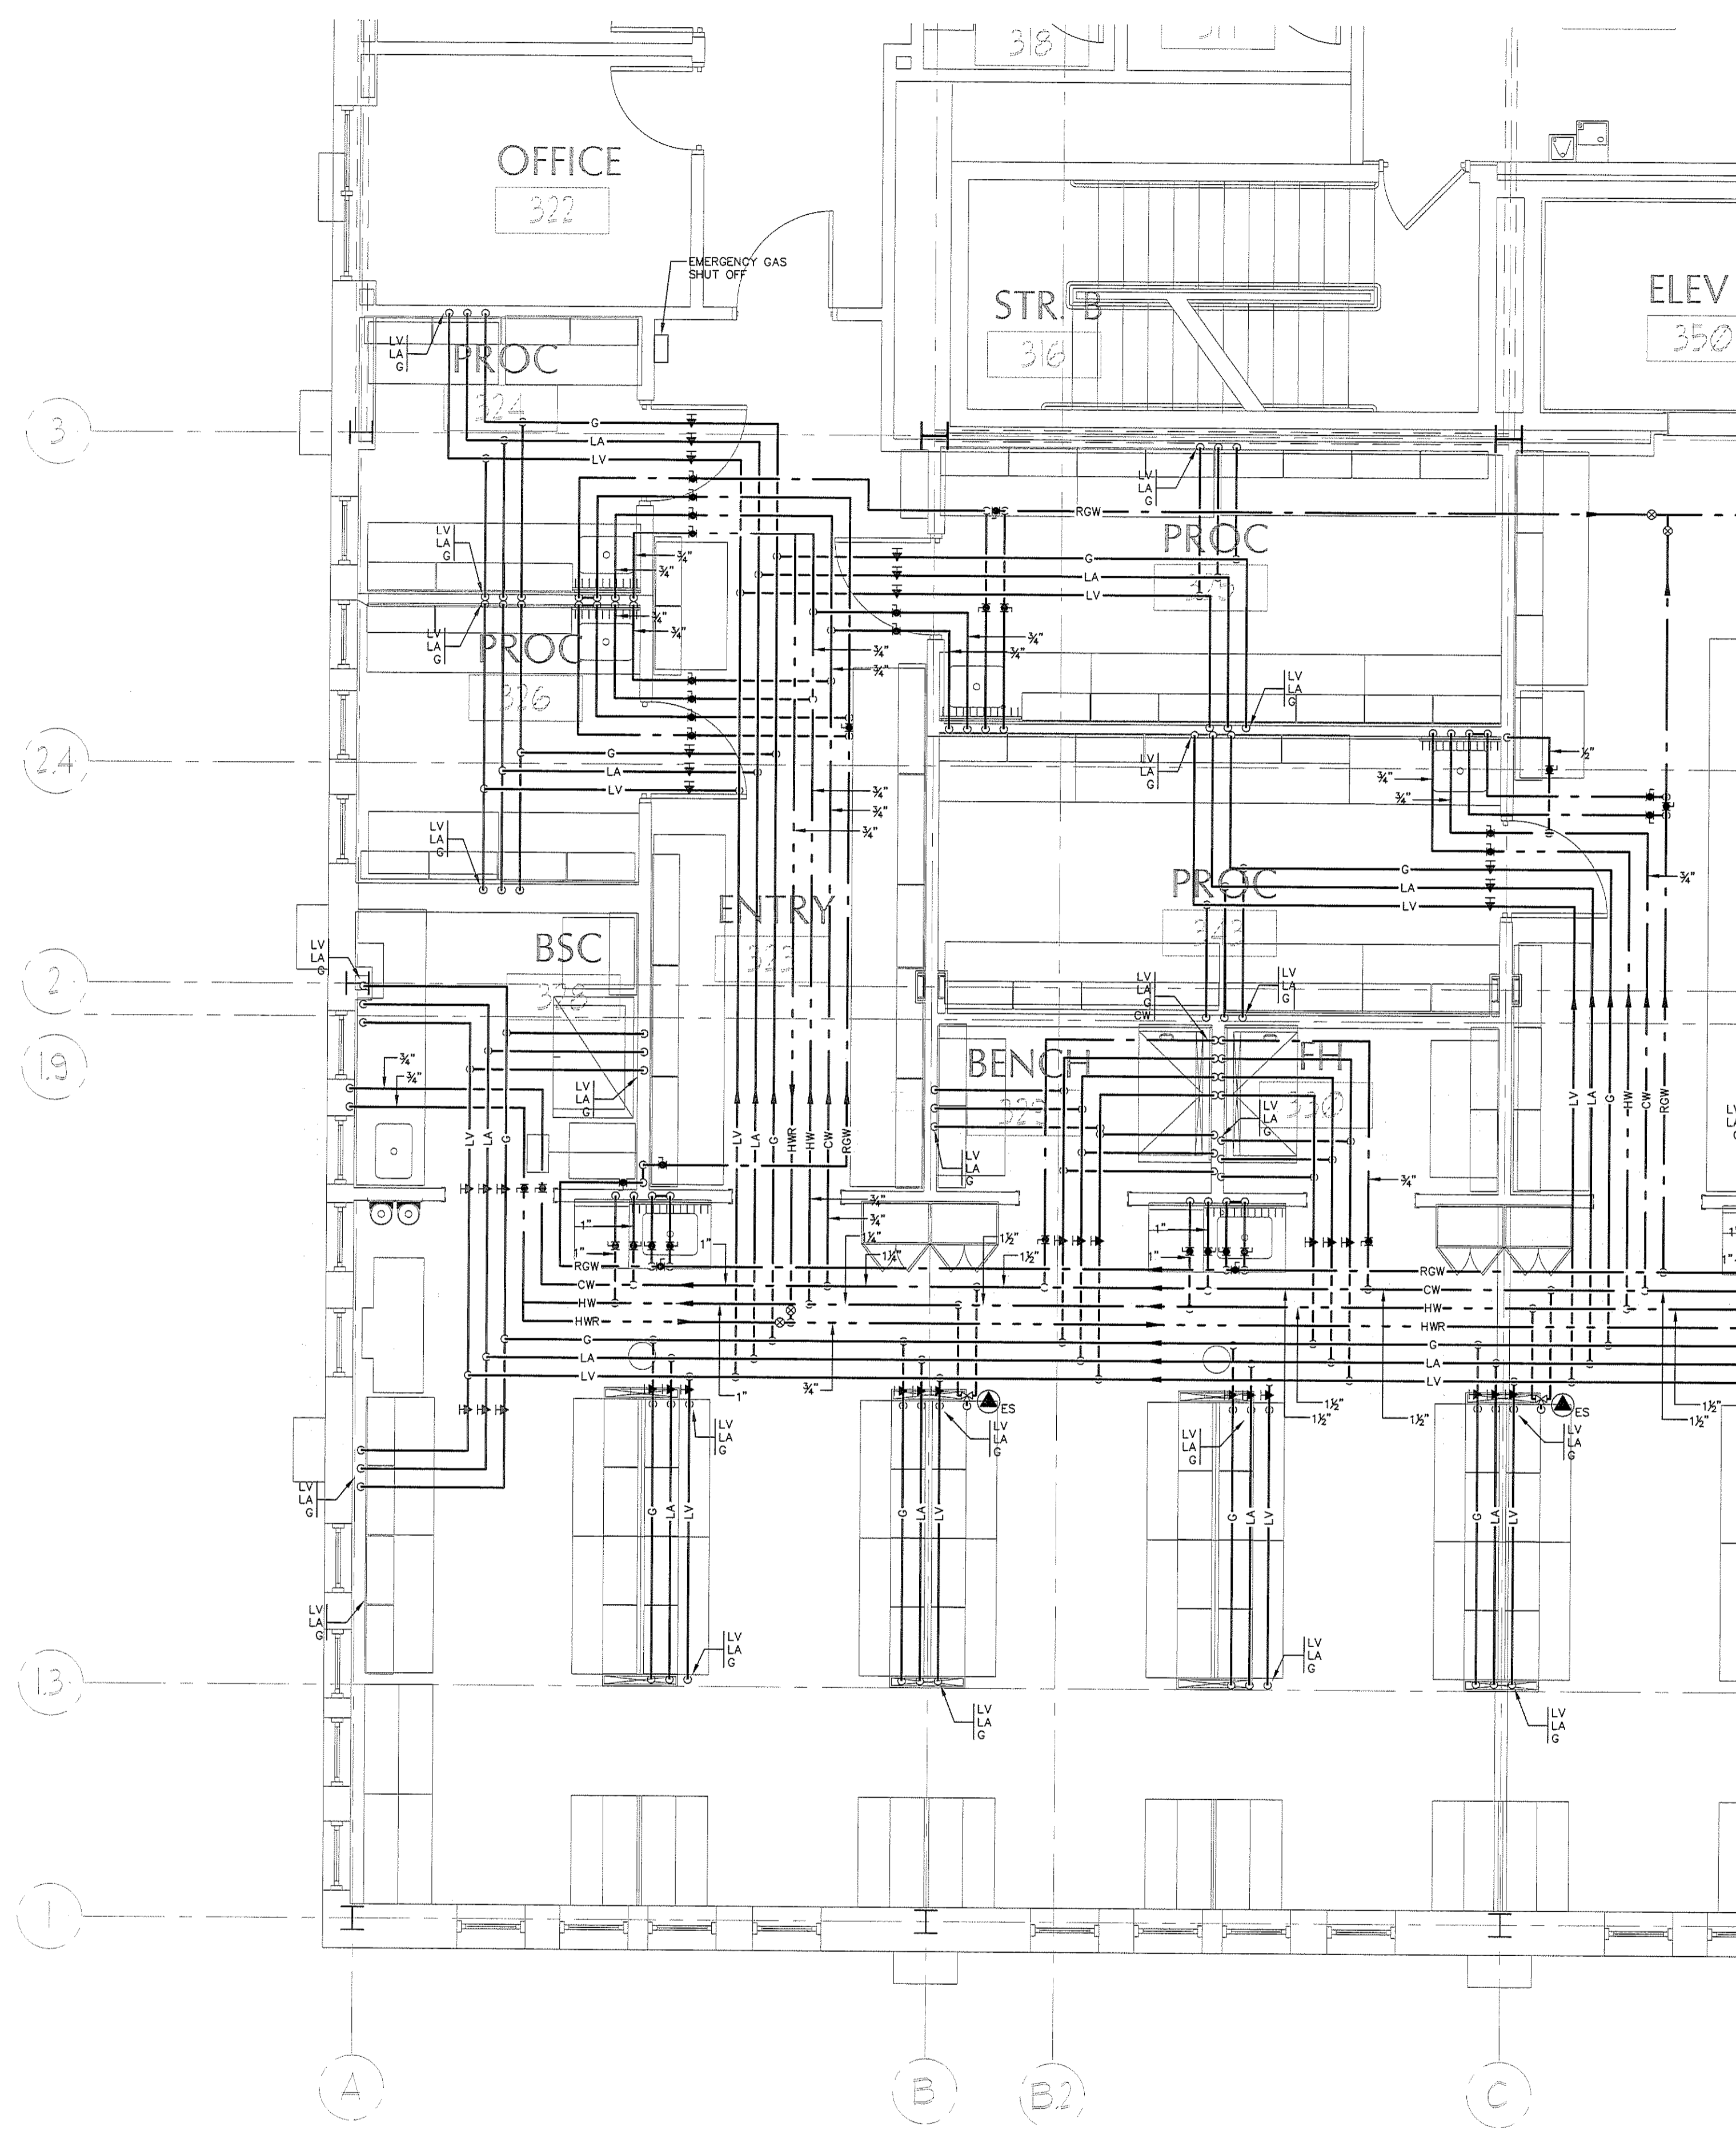

1 PLUMBING THIRD FLOOR PLAN ENLARGED - B  
Scale: 1/8"=1'-0"

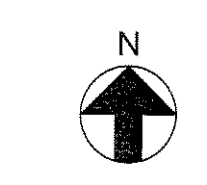

**PORT CITY ARCHITECTURE**

65 NEWBURY STREET  
PORTLAND, ME 04101  
207.761.9000  
fax: 207.761.2010  
lita@portcityarch.com

**VANZELM ENGINEERS**

VANZELM HEYWOOD & SHADFORD, INC.  
19 TALCOTT NOTCH FARMINGTON, CT 06032  
TEL: (860) 284-5084 FAX: (860) 284-5088

PROJECT NO.: 2007120.00

**BECKER structural engineers, inc.**

**SYTDDesign CONSULTANTS**  
CIVIL ENGINEERING & LANDSCAPE ARCHITECTURE

**ALLIED/COOK CONSTRUCTION**

**Favreau**

**Titan Mechanical, Inc.**  
Cognate Building Systems - Mechanical Contracting

**UNIVERSITY OF NEW ENGLAND**  
**COLLEGE OF PHARMACY**  
**716 STEVENS AVENUE,**  
**PORTLAND, ME**

#	DATE	DESCRIPTION
		BID SET
	02/08/08	Date Issued
	06506	Project Number

SHEET NAME  
**PLUMBING THIRD FLOOR PLAN ENLARGED - B**

Drawn By	SMS
Checked By	DWM

**P2.1**

**BID SET - NOT FOR CONSTRUCTION**