

IF THIS SHEET IS NOT 24 X 36 IT IS A REDUCED SCALE PRINT - SCALE ACCORDINGLY

3  
2  
1  
0  
SCALE 1"=1'


4  
3  
2  
1  
0  
SCALE 3/4"=1'

6'  
3'  
2'  
1'  
0  
SCALE 1/2"=1'


12  
8  
4  
0  
SCALE 1/4"=1'

20  
10  
5  
0  
SCALE 1/8"=1'

40  
20  
10  
0  
SCALE 1/16"=1'

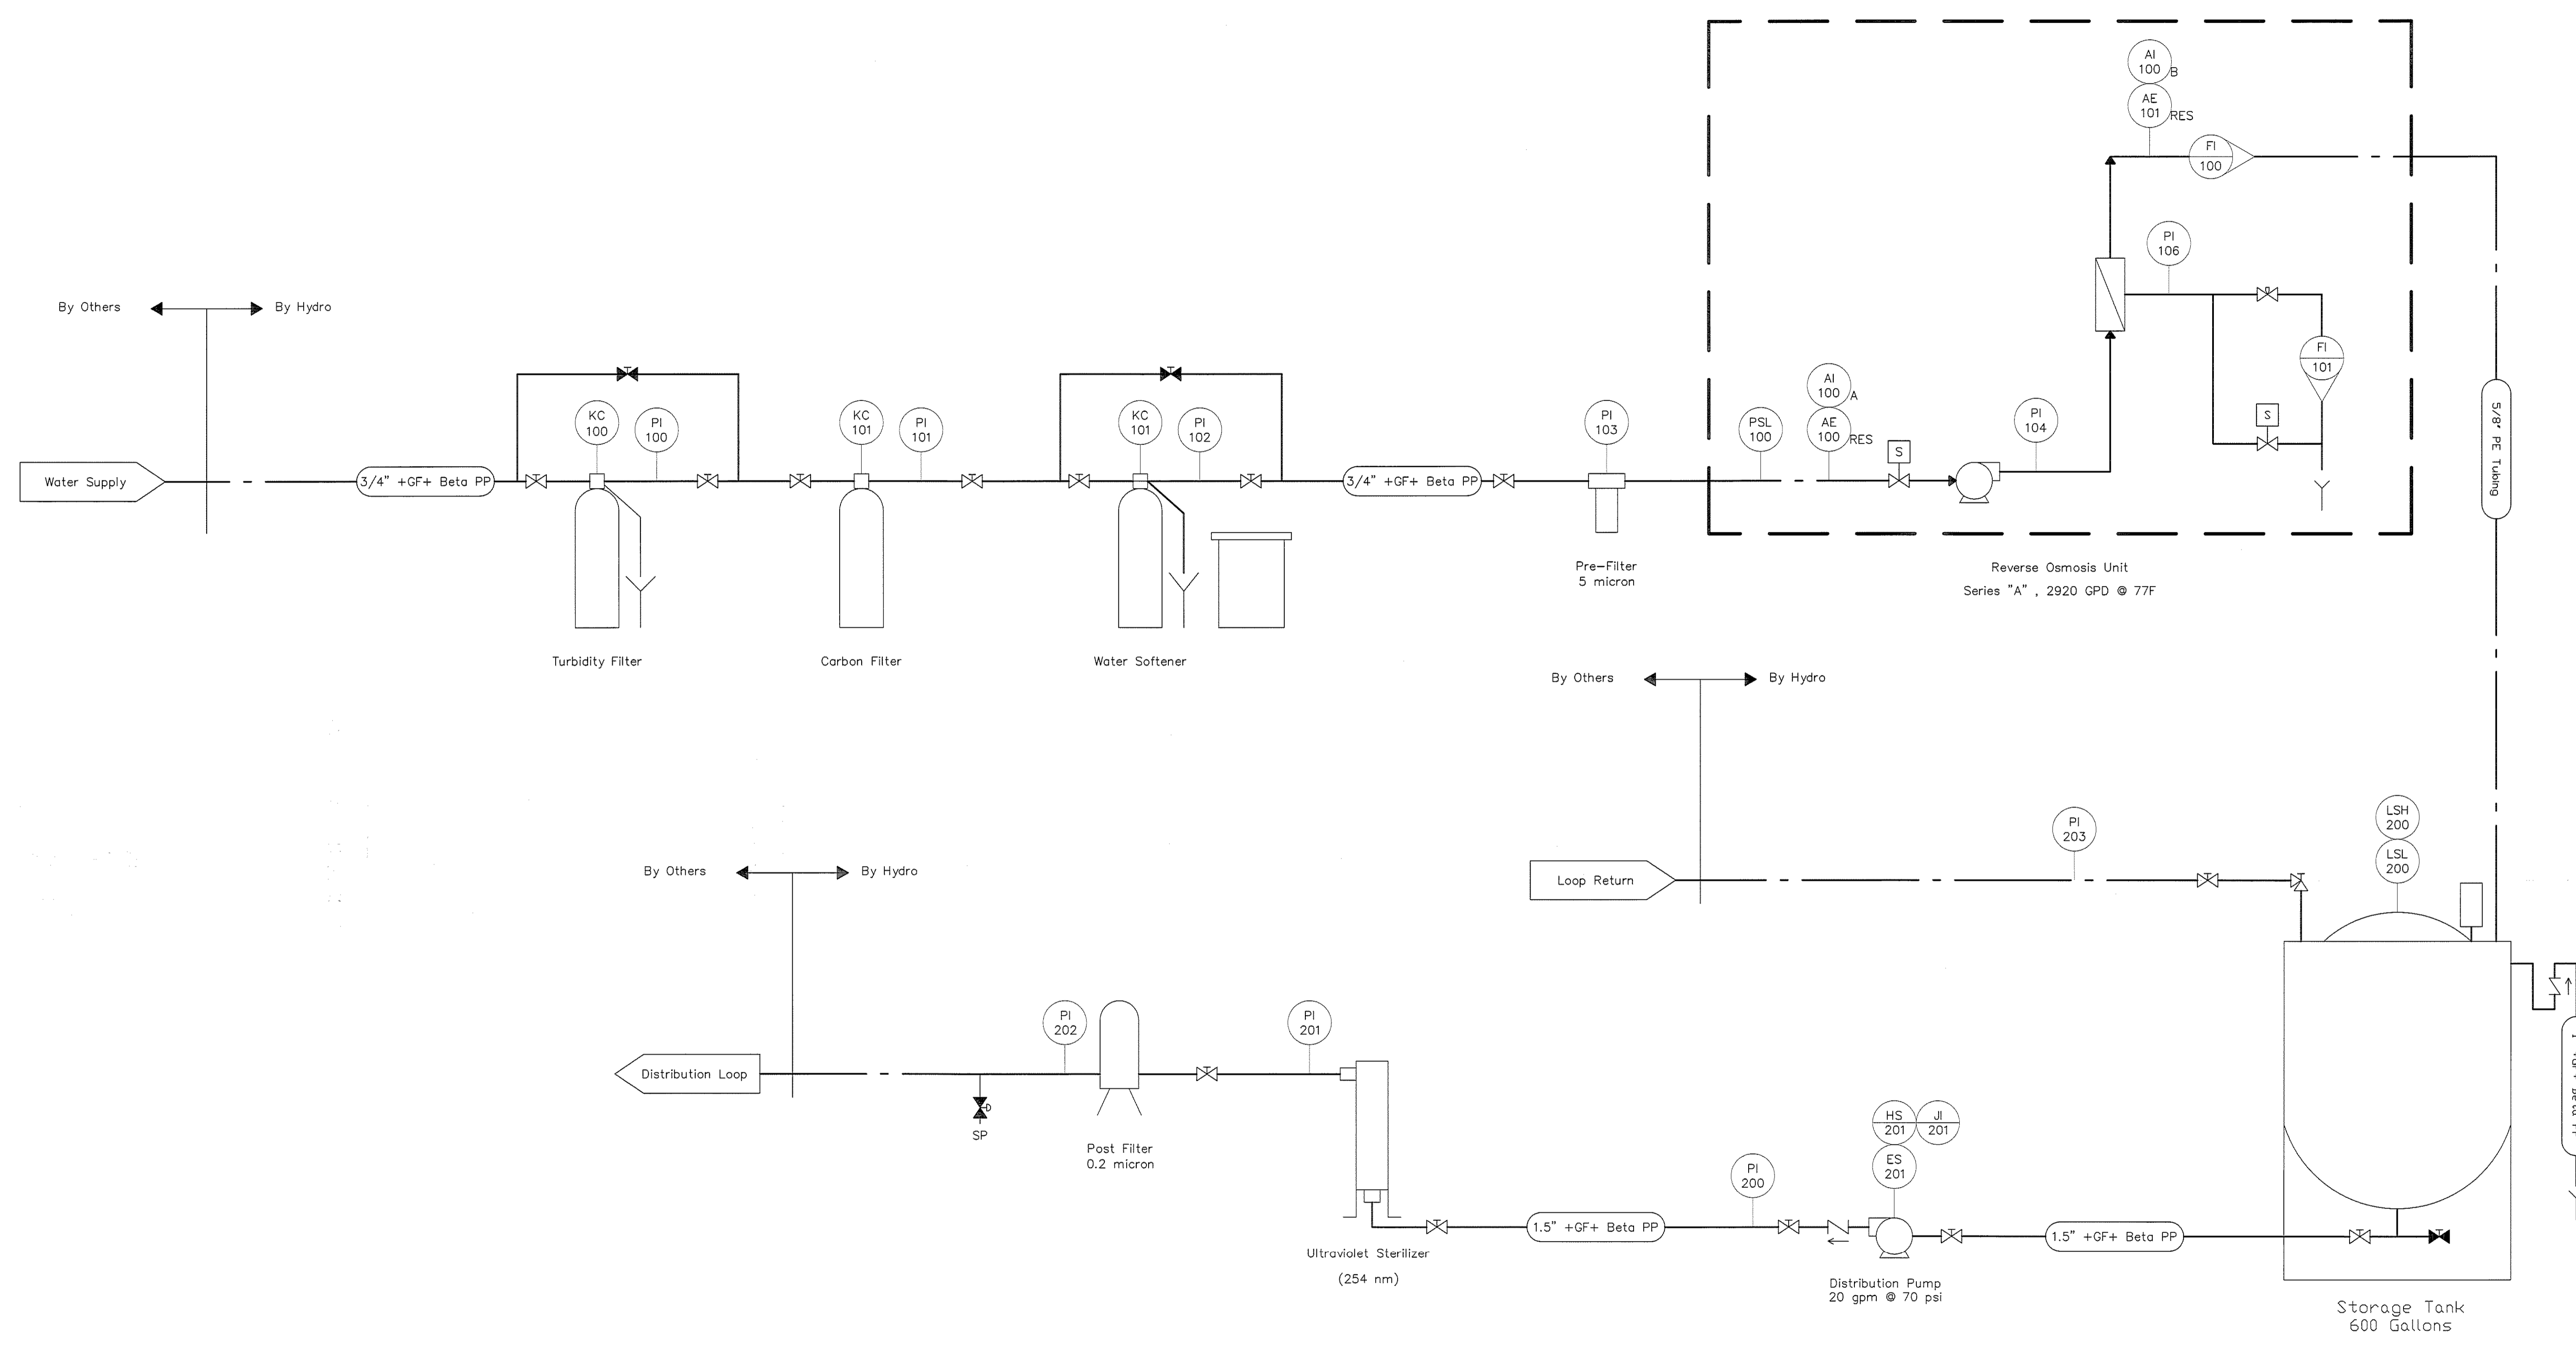

**REAGENT GRADE III WATER GENERATION DETAIL**  
NOT TO SCALE

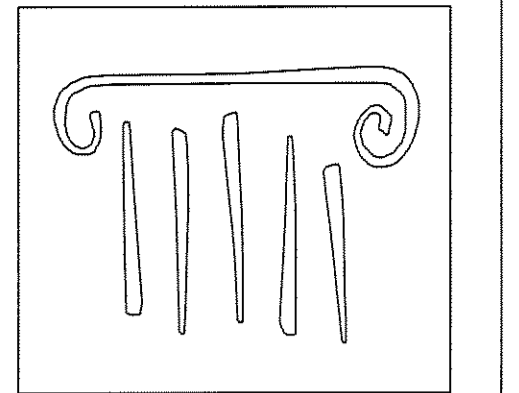

**PORT CITY ARCHITECTURE**

65 NEWBURY STREET  
PORTLAND, ME 04101  
207.761.9000  
fax: 207.761.2010  
lita@portcityarch.com

**VANZELM ENGINEERS**

VANZELM HEYWOOD & SHADFORD, INC.  
19 TALCOTT NOTCH FARMINGTON, CT 06032  
TEL: 860.384.2966 FAX: 860.384.2988

PROJECT NO.: 2007120.00

**BECKER**  
structural engineers, inc.

**SYTDesign**  
CONSULTANTS  
CIVIL ENGINEERING & LANDSCAPE ARCHITECTURE

**ALLIED/COOK**  
CONSTRUCTION

**Favreau**  
GROUP

**Titan Mechanical, Inc.**  
Design Build Engineering - Mechanical Contracting

**UNIVERSITY OF NEW ENGLAND**

**COLLEGE OF PHARMACY**

**716 STEVENS AVENUE,  
PORTLAND, ME**

#	DATE	DESCRIPTION
		BID SET
	02/08/08	Date Issued
	06506	Project Number

SHEET NAME  
**PLUMBING DETAILS**

Drawn By: SMS  
Checked By: DWM  
**P4.1**

**BID SET - NOT FOR CONSTRUCTION**