

PORT CITY ARCHITECTURE

65 NEWBURY STREET
PORTLAND, ME 04101
207.761.9000
fax: 207.761.2010
lita@portcityarch.com

VANZELM ENGINEERS

VANZELM HEYWOOD & SHADFORD, INC.
16 TALCOTT NOTCH FARMINGTON, CT 06032
TEL: 860.384.3064 FAX: 860.324.0088

PROJECT NO.: 2007120.00

BECKER

structural engineers, inc.

SYTDesign CONSULTANTS

CIVIL ENGINEERING & LANDSCAPE ARCHITECTURE

ALLIED/COOK CONSTRUCTION

Favreau GROUP

Titan Mechanical, Inc.
Design-Build Engineering - Mechanical Contracting

UNIVERSITY OF NEW ENGLAND

COLLEGE OF PHARMACY

716 STEVENS AVENUE,
PORTLAND, ME

#	DATE	DESCRIPTION
		BID SET
		Date Issued 02/08/08
		Project Number 06306


SHEET NAME

FIRE PROTECTION FLOOR PLANS


Drawn By	SMS
Checked By	DWM

FP1.1


BID SET - NOT FOR CONSTRUCTION

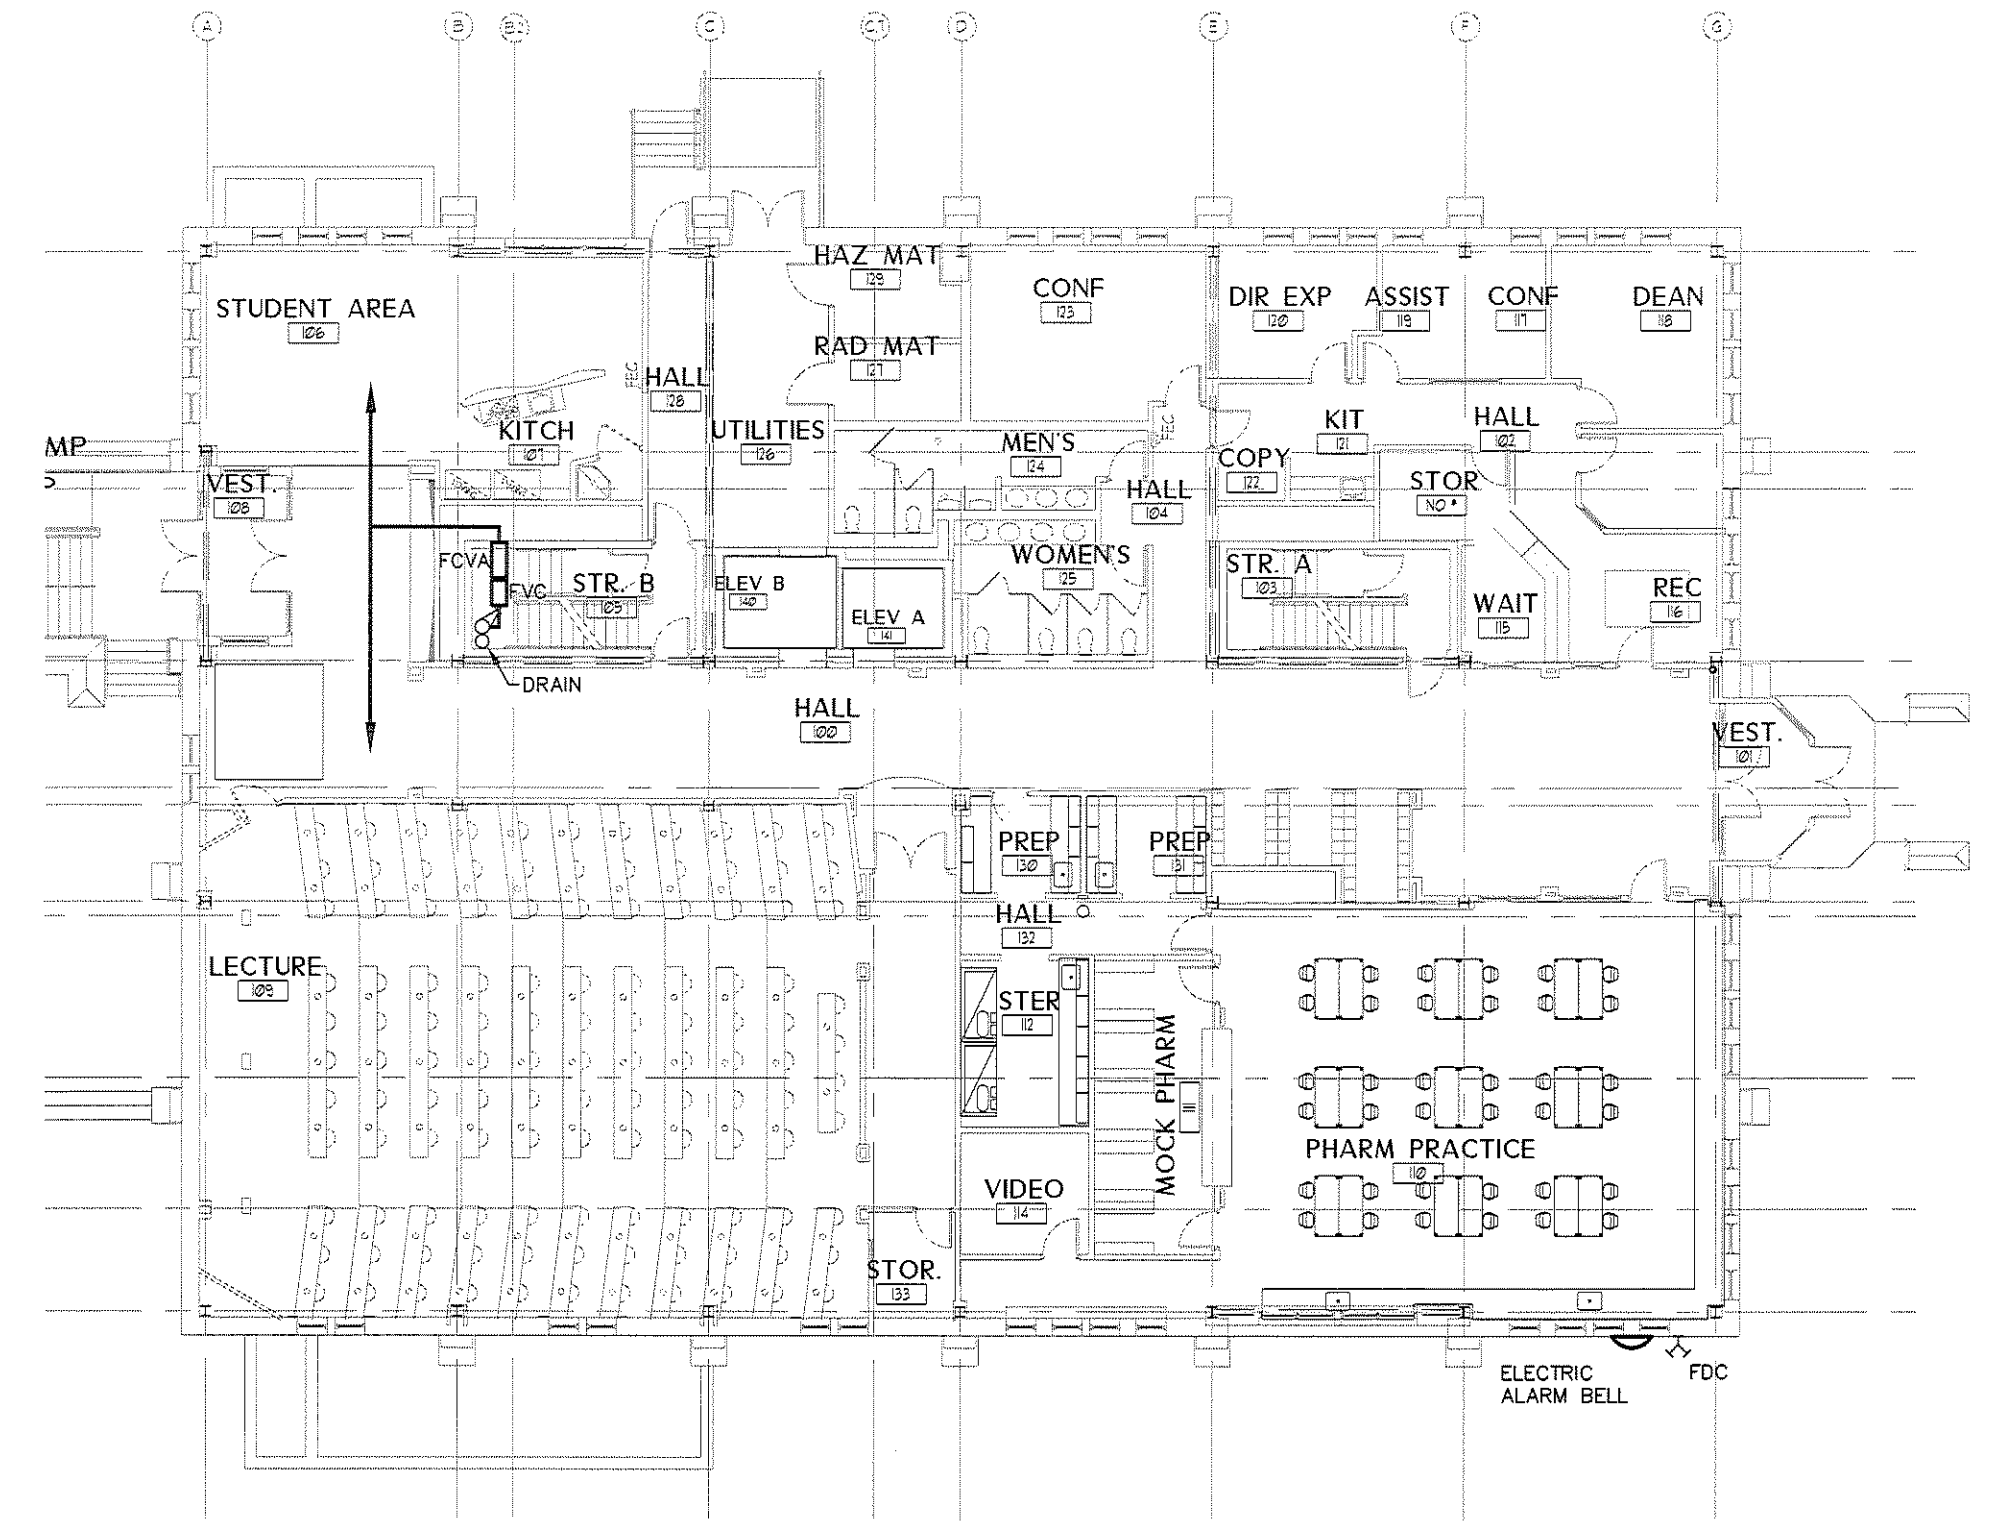


3 FIRE PROTECTION FIRST FLOOR PLAN
Scale: 1/16"=1'-0"

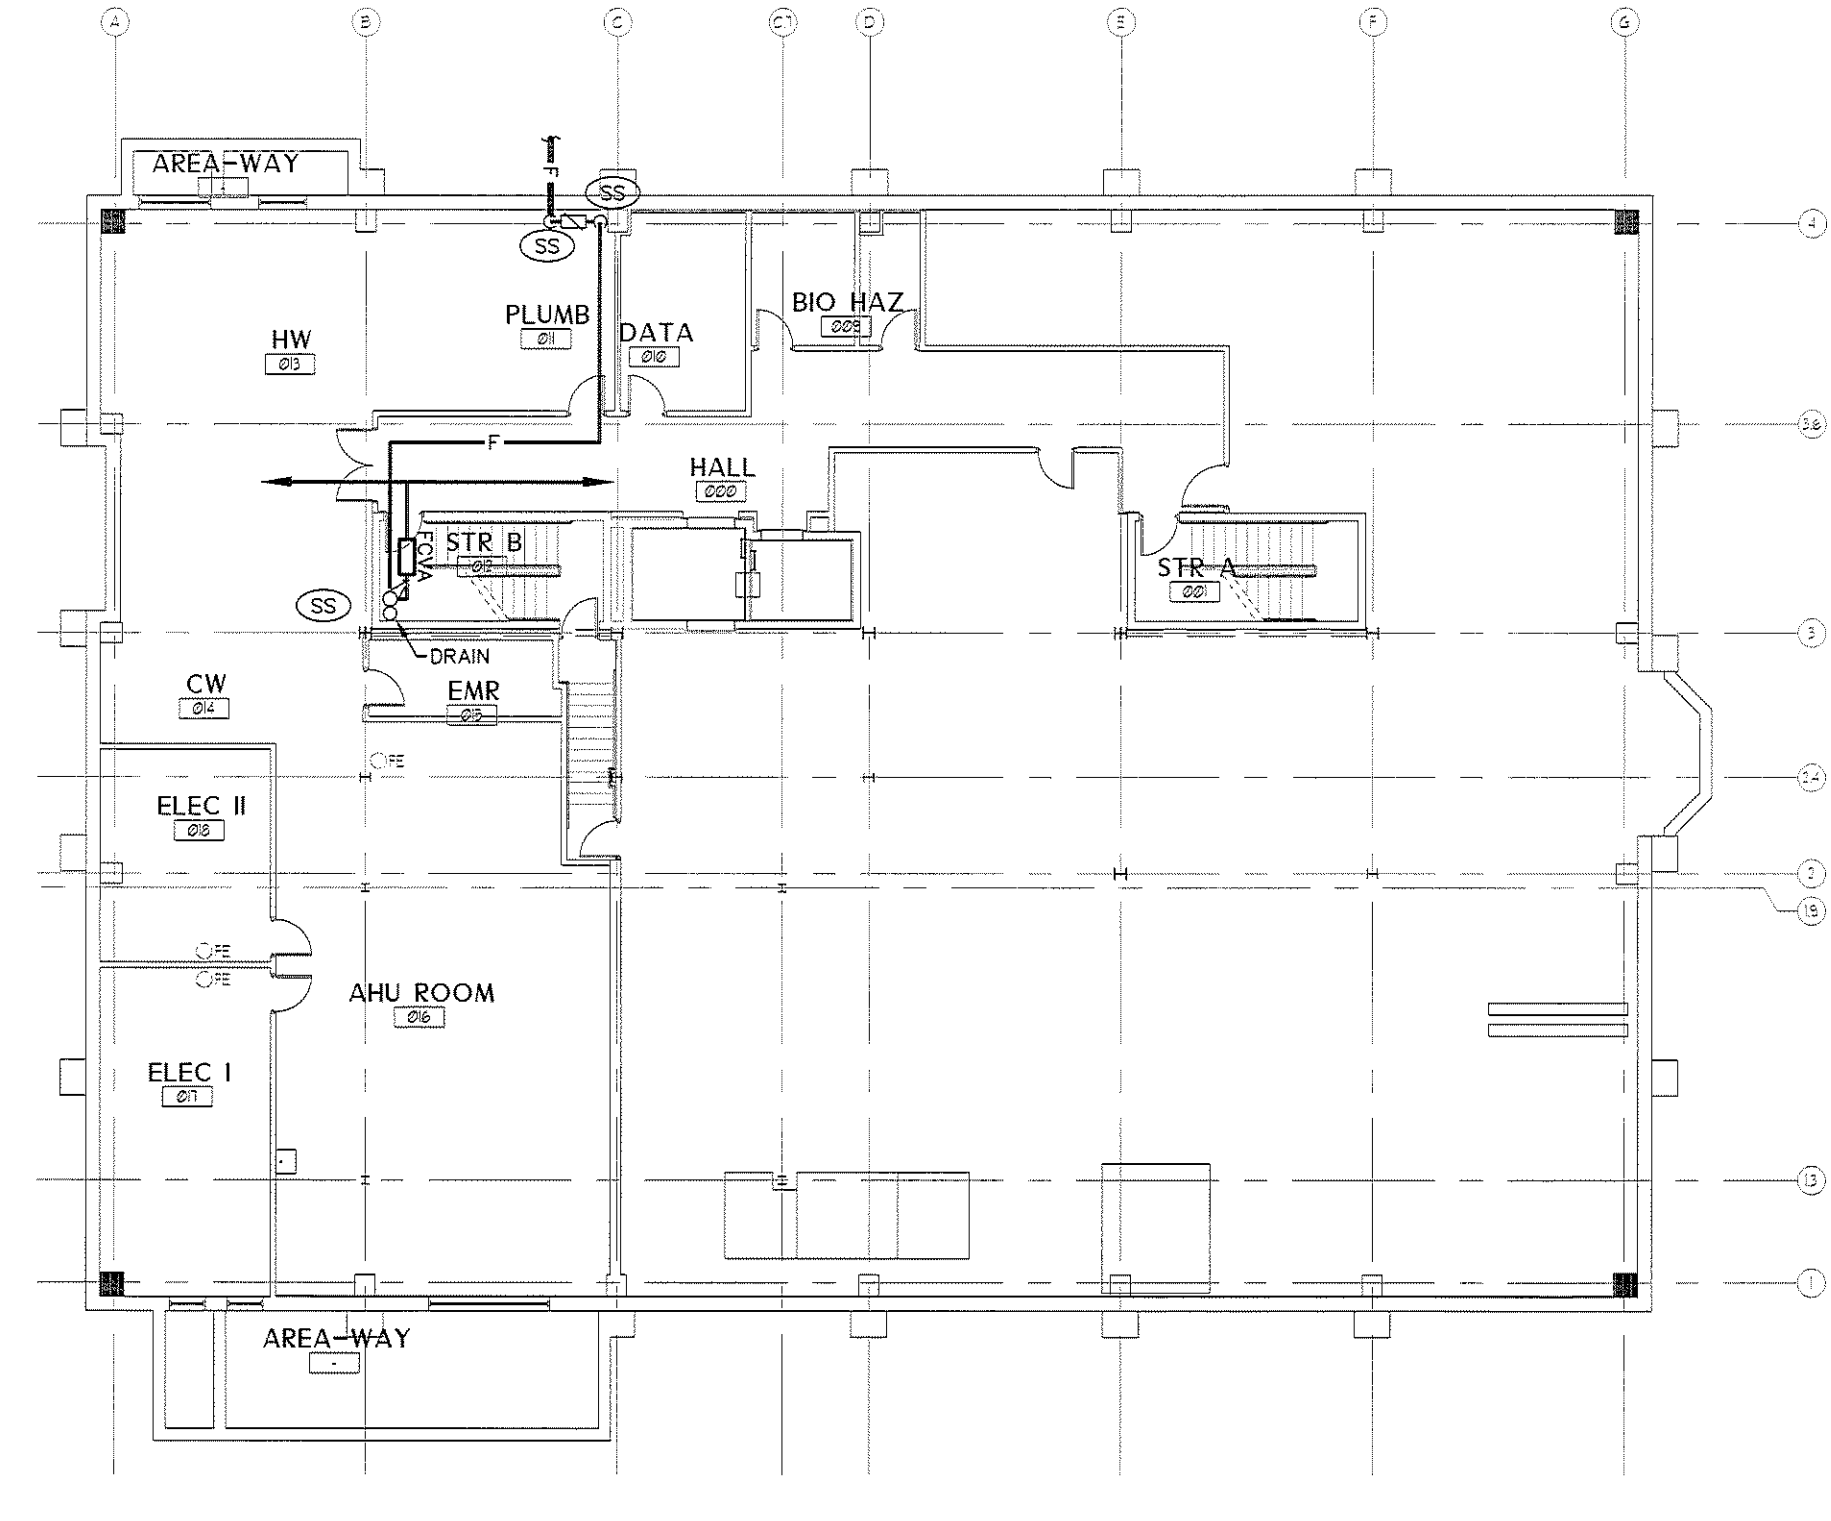


2 FIRE PROTECTION LOWER LEVEL PLAN
Scale: 1/16"=1'-0"

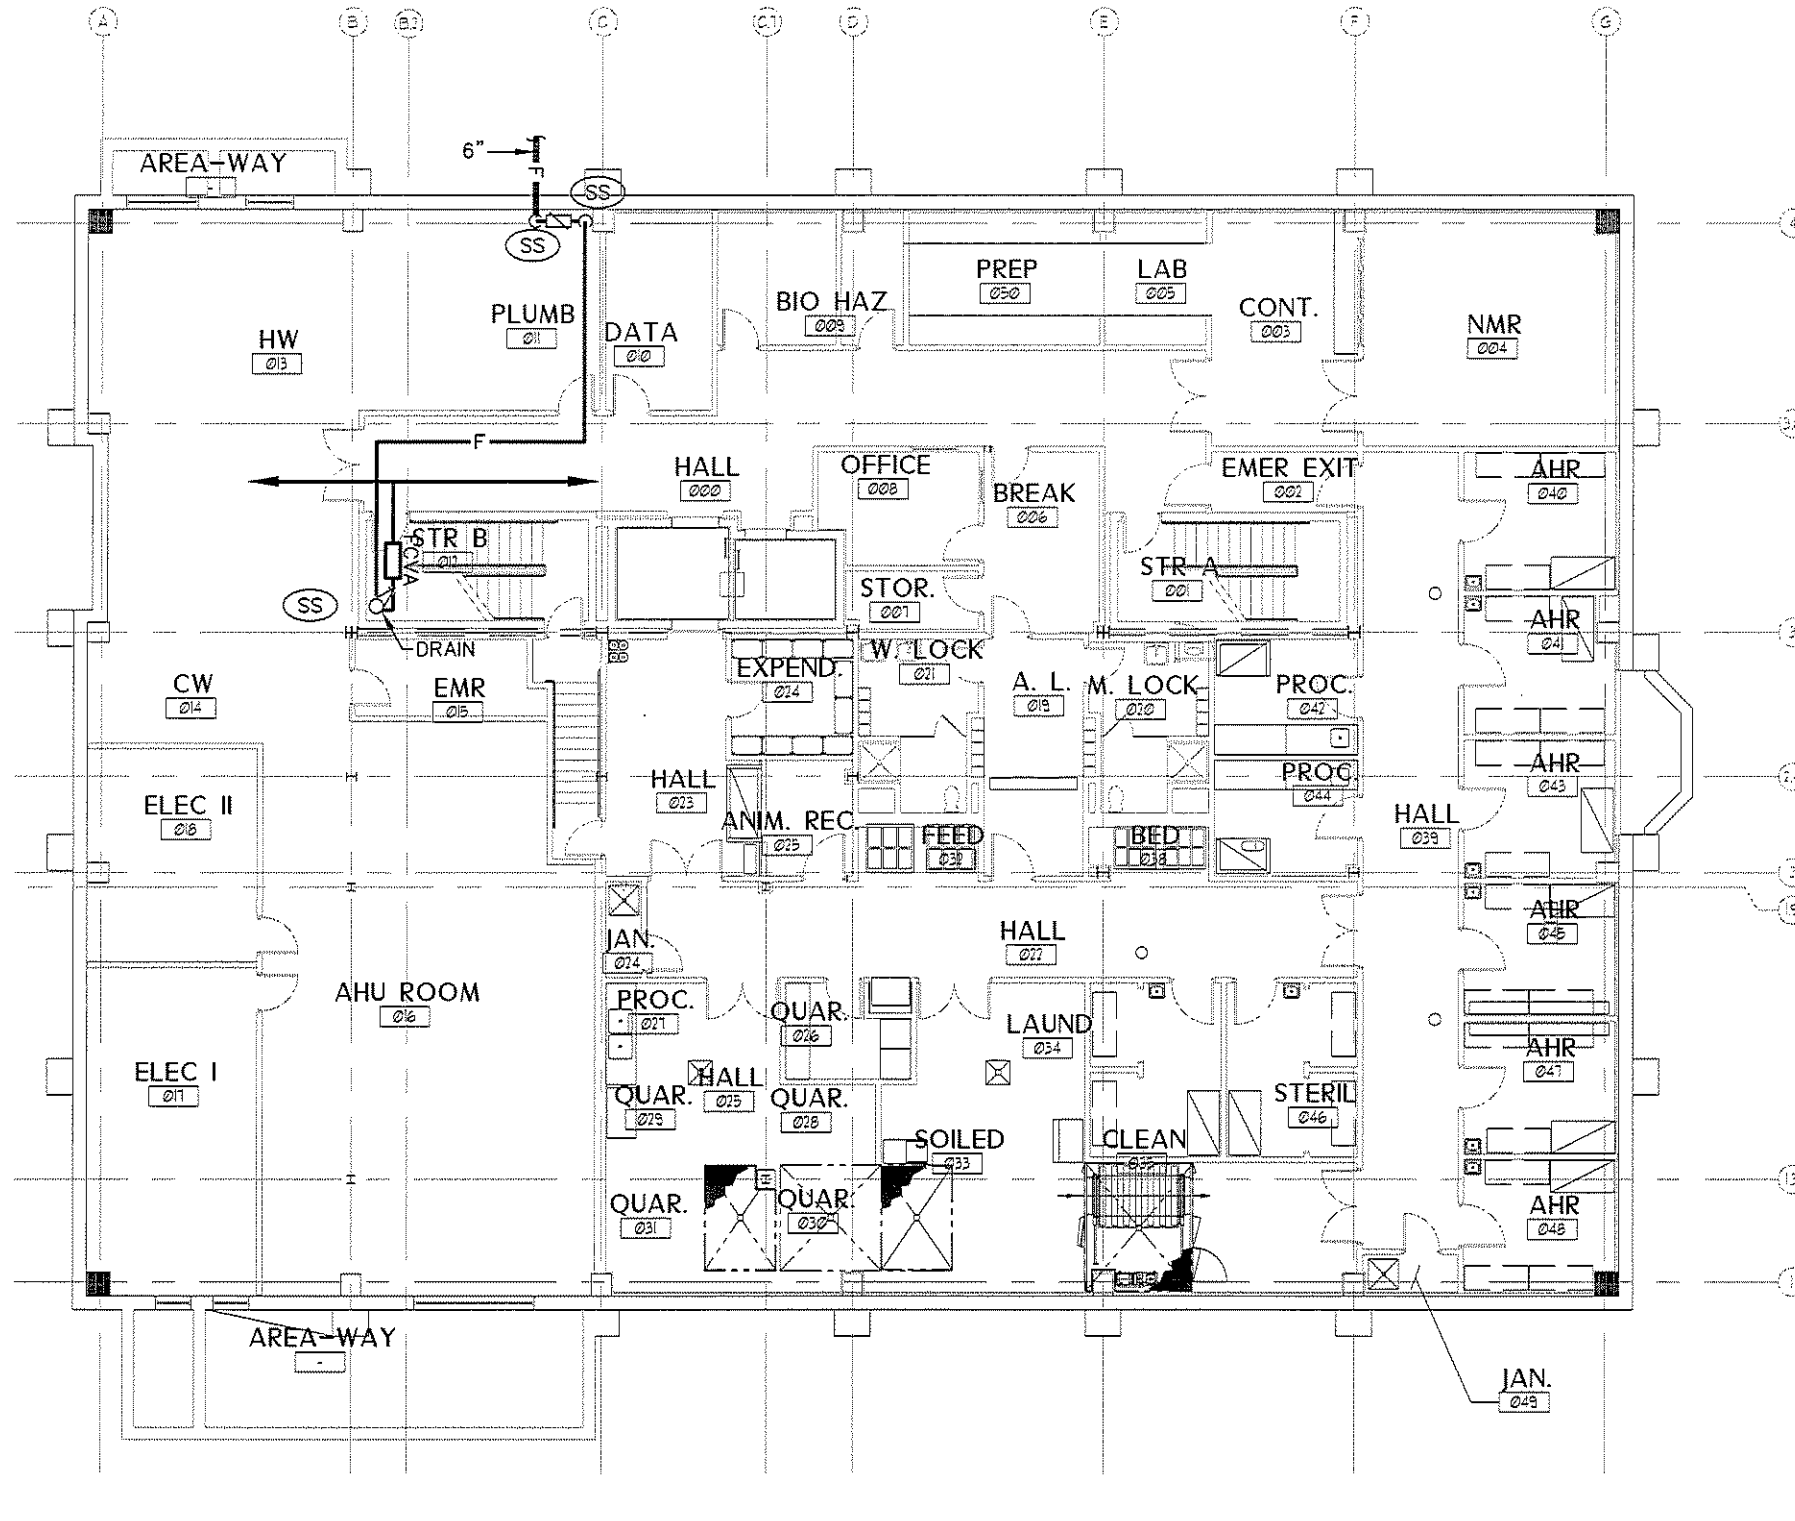


1 FIRE PROTECTION LOWER LEVEL PLAN - ALTERNATE
Scale: 1/16"=1'-0"

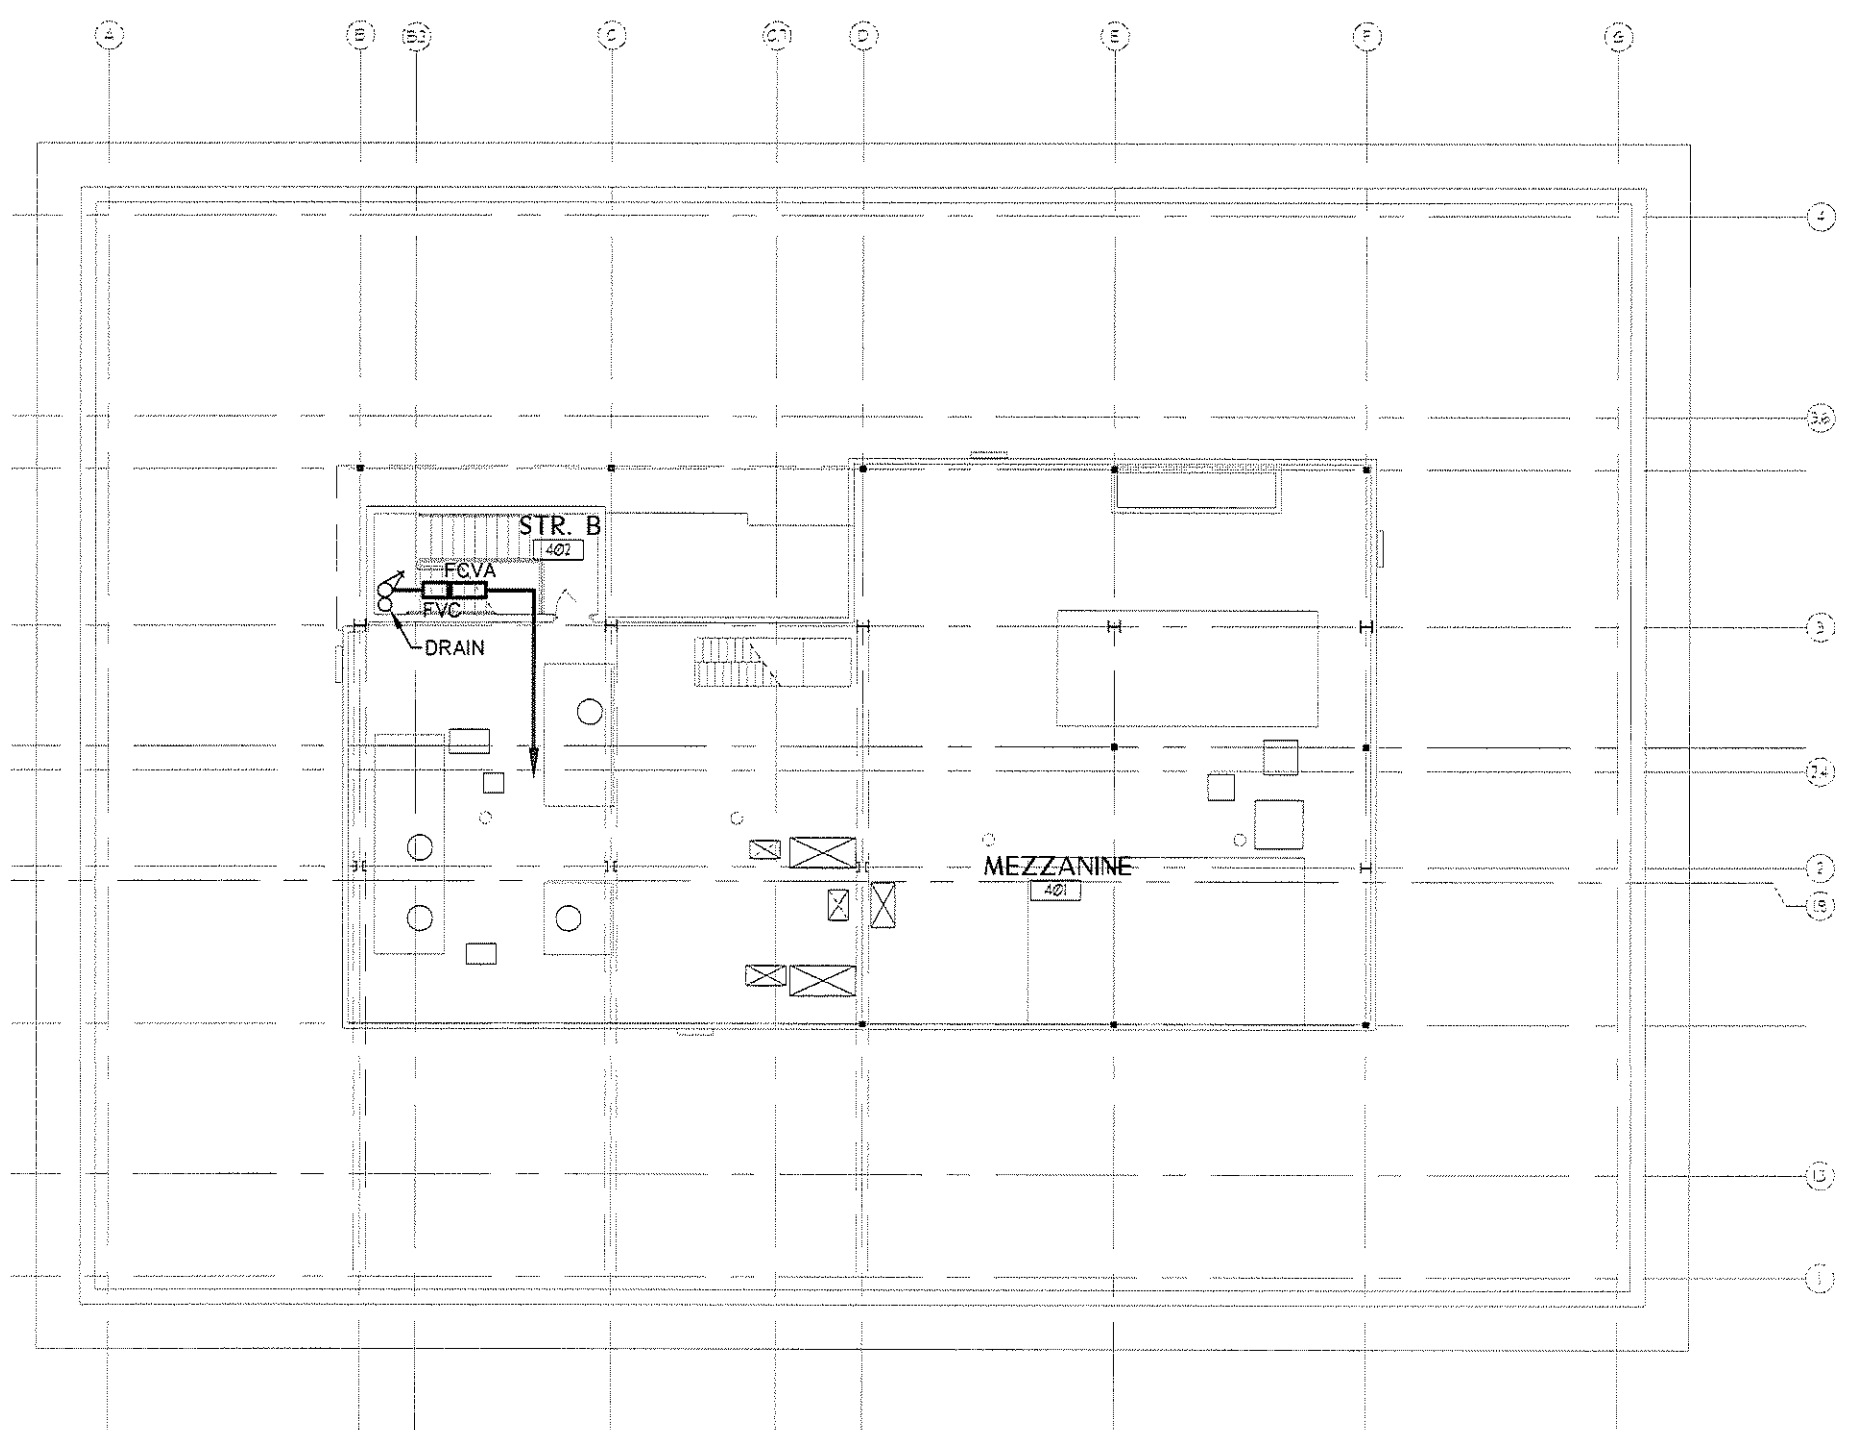

6 FIRE PROTECTION MEZZANINE PLAN
Scale: 1/16"=1'-0"

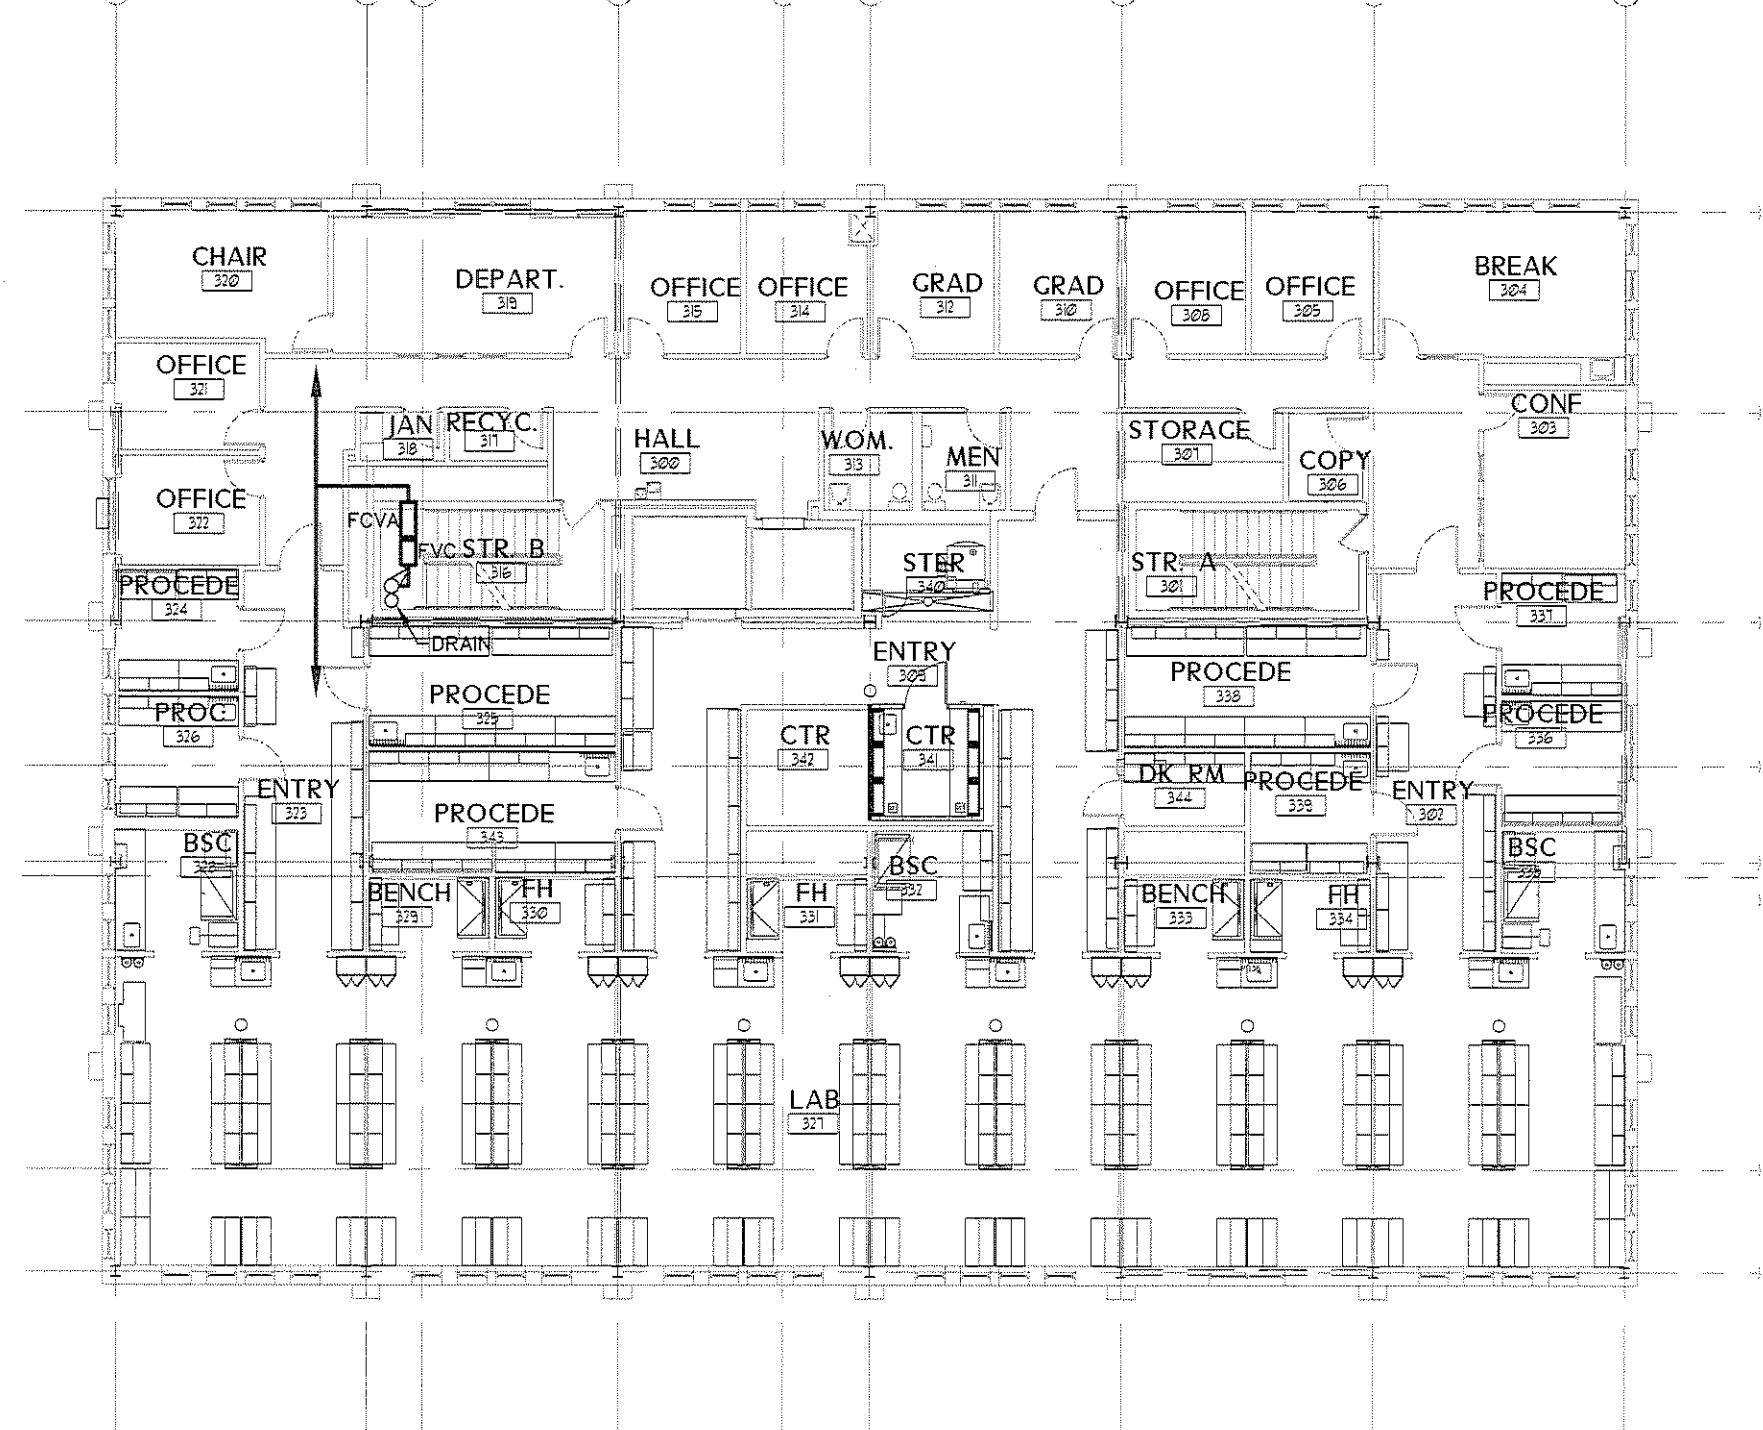


5 FIRE PROTECTION THIRD FLOOR PLAN
Scale: 1/16"=1'-0"

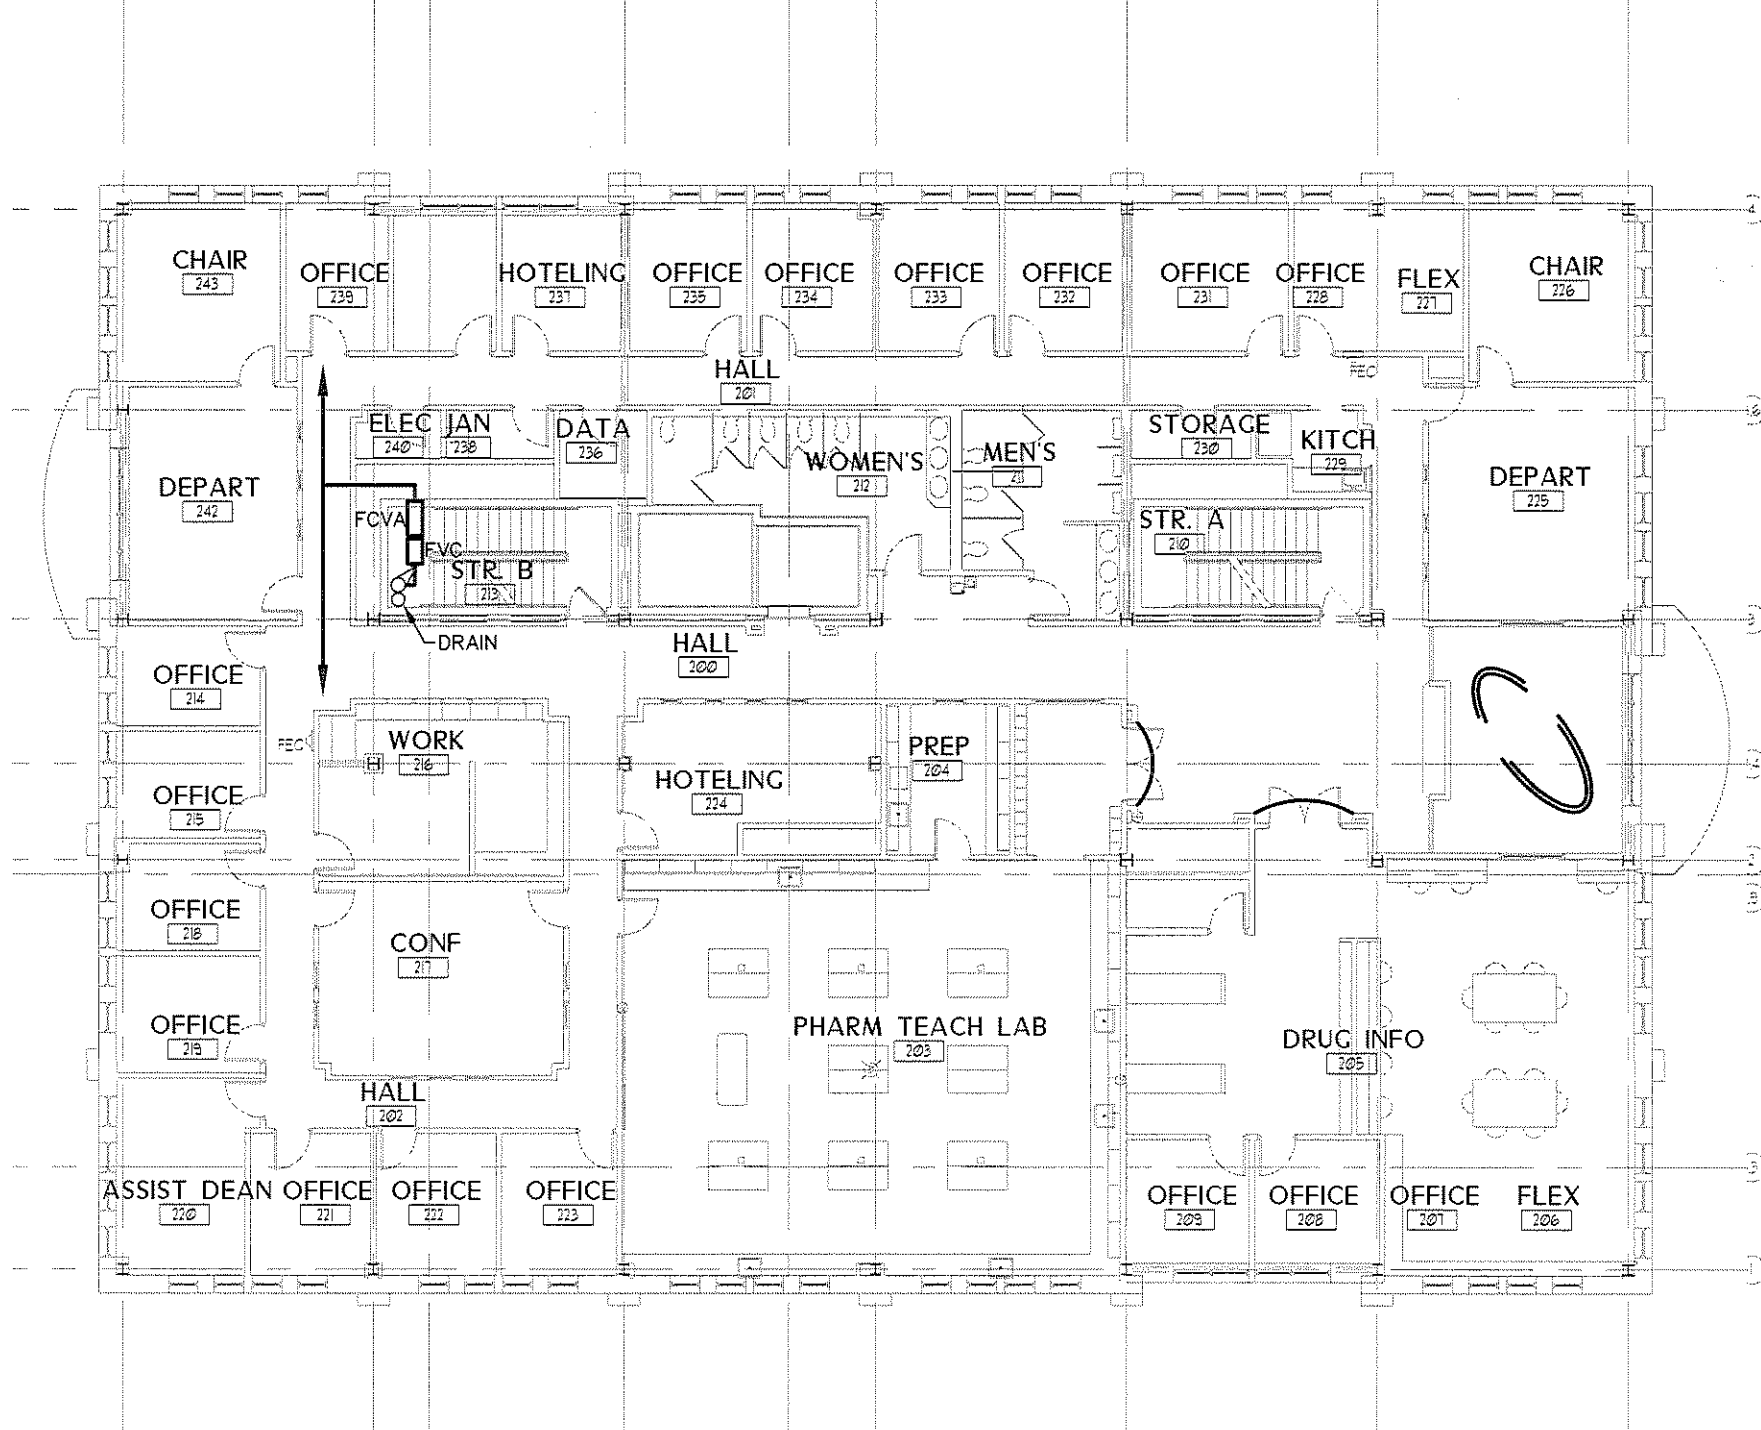

4 FIRE PROTECTION SECOND FLOOR PLAN
Scale: 1/16"=1'-0"

ELECTRICAL ROOMS ARE NOT BE PROVIDED WITH SPRINKLER COVER PER NFPA 8.15.10

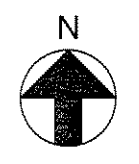

IF THIS SHEET IS NOT 24 X 36 IT IS A REDUCED SCALE PRINT - SCALE ACCORDINGLY