

PORT CITY ARCHITECTURE

65 NEWBURY STREET
 PORTLAND, ME 04101
 207.761.9000
 fax: 207.761.2010
 lita@portcityarch.com

JACOBS CONSULTANCY
 GPR Laboratory Planning Practice

VANZELM ENGINEERS
 VANZELM BETHWOOD & SEAFORD, INC.

BECKER
 Structural Engineers, Inc.

SYTDDesign CONSULTANTS
 CIVIL ENGINEERING & LANDSCAPE ARCHITECTURE

ALLIED/COOK CONSTRUCTION

Faureau
 ENGINEERING

Titan Mechanical, Inc.
 Design Build Engineering - Mechanical Contracting

UNIVERSITY OF NEW ENGLAND

COLLEGE OF PHARMACY

716 STEVENS AVENUE, PORTLAND, ME

IF THIS SHEET IS NOT 24 X 36 IT IS A REDUCED SCALE PRINT - SCALE ACCORDINGLY

SCALE 1"=1'-0"


SCALE 3/4"=1'-0"

SCALE 1/2"=1'-0"

SCALE 1/4"=1'-0"

SCALE 1/8"=1'-0"

SCALE 1/16"=1'-0"

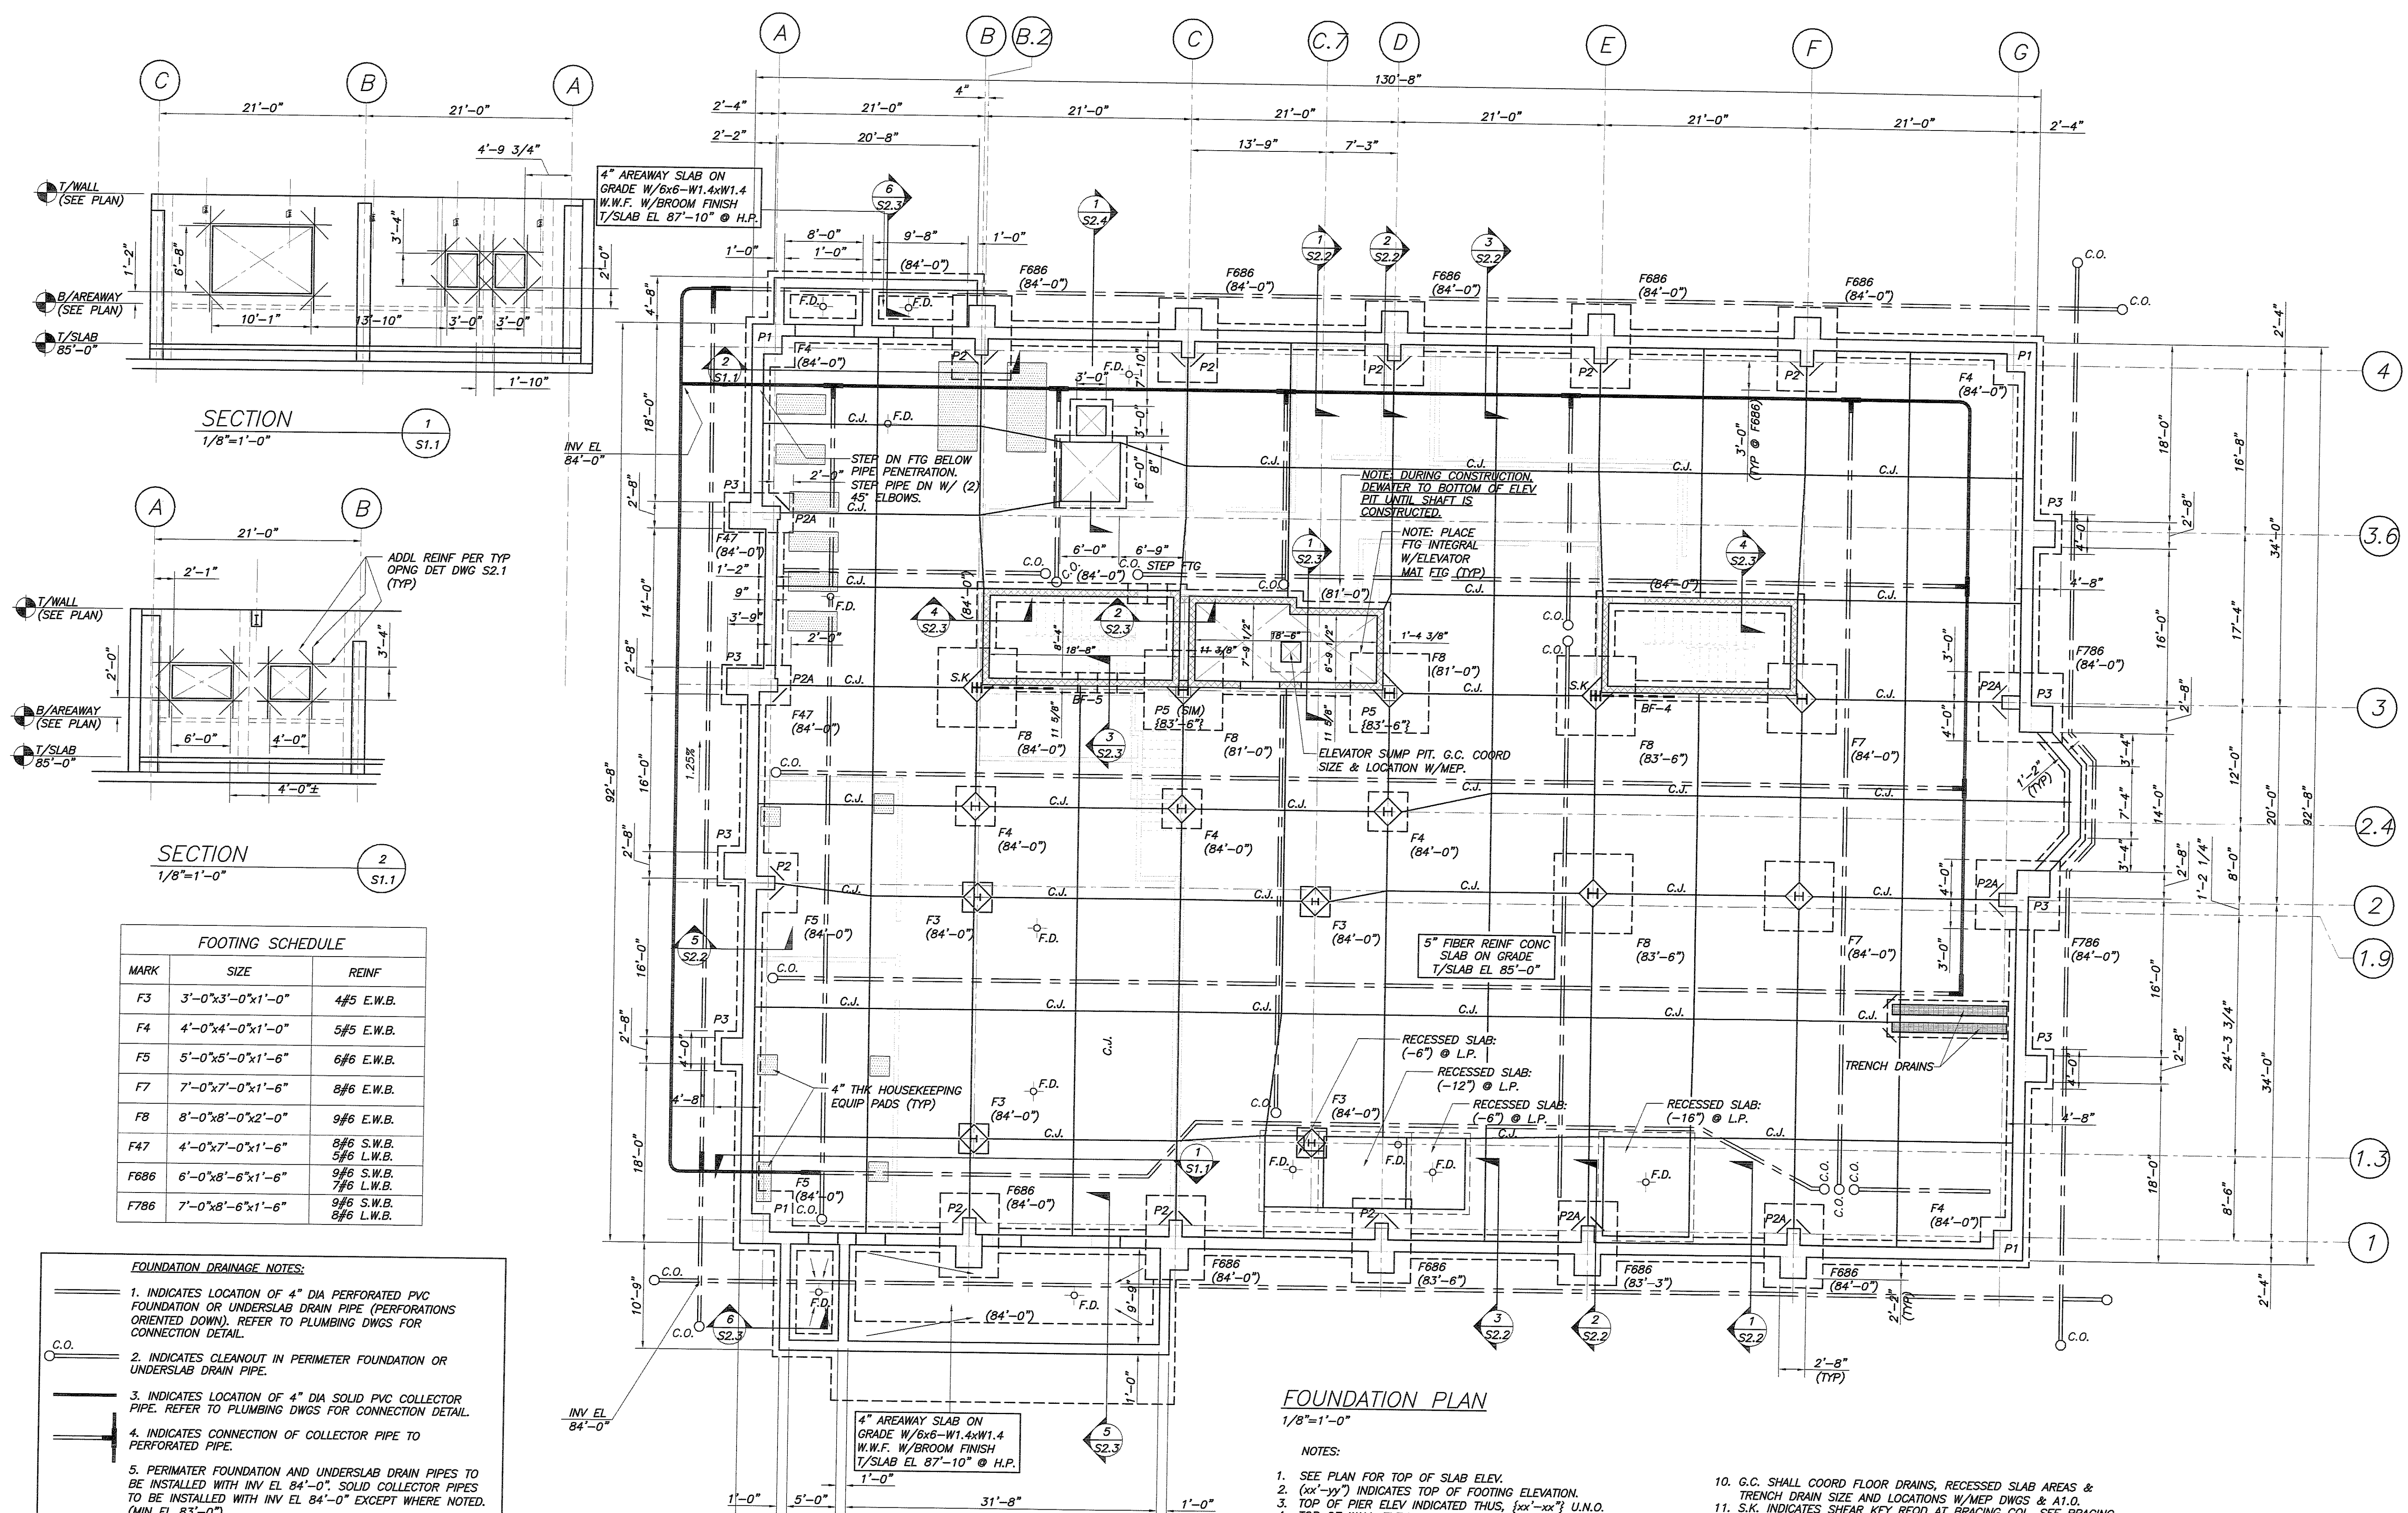

FOOTING SCHEDULE		
MARK	SIZE	REINF
F3	3'-0"x3'-0"x1'-0"	4#5 E.W.B.
F4	4'-0"x4'-0"x1'-0"	5#5 E.W.B.
F5	5'-0"x5'-0"x1'-6"	6#6 E.W.B.
F7	7'-0"x7'-0"x1'-6"	8#6 E.W.B.
F8	8'-0"x8'-0"x2'-0"	9#6 E.W.B.
F47	4'-0"x7'-0"x1'-6"	8#6 S.W.B. 5#6 L.W.B.
F686	6'-0"x8'-6"x1'-6"	9#6 S.W.B. 7#6 L.W.B.
F786	7'-0"x8'-6"x1'-6"	9#6 S.W.B. 8#6 L.W.B.

FOUNDATION DRAINAGE NOTES:

- INDICATES LOCATION OF 4" DIA PERFORATED PVC FOUNDATION OR UNDERSLAB DRAIN PIPE (PERFORATIONS ORIENTED DOWN). REFER TO PLUMBING DWGS FOR CONNECTION DETAIL.
- INDICATES CLEANOUT IN PERIMETER FOUNDATION OR UNDERSLAB DRAIN PIPE.
- INDICATES LOCATION OF 4" DIA SOLID PVC COLLECTOR PIPE. REFER TO PLUMBING DWGS FOR CONNECTION DETAIL.
- INDICATES CONNECTION OF COLLECTOR PIPE TO PERFORATED PIPE.
- PERIMETER FOUNDATION AND UNDERSLAB DRAIN PIPES TO BE INSTALLED WITH INV EL 84'-0". SOLID COLLECTOR PIPES TO BE INSTALLED WITH INV EL 84'-0" EXCEPT WHERE NOTED. (MIN EL 83'-0").
- PERIMETER FOUNDATION AND UNDERSLAB DRAIN SYSTEM DESIGNED BY HALEY & ALDRICH, INC.
- WATERPROOFING SYSTEM TO BE COORDINATED WITH CLEANOUTS AND PENETRATIONS THROUGH FOUNDATION WALLS. PROVIDE BOXOUTS THROUGH FOUNDATION WALLS AT PENETRATION LOCATIONS.

FOUNDATION PLAN
 1/8"=1'-0"

- NOTES:**
- SEE PLAN FOR TOP OF SLAB ELEV.
 - (xx'-yy') INDICATES TOP OF FOOTING ELEVATION.
 - TOP OF PIER ELEV INDICATED THUS, {xx'-yy'} U.N.O.
 - TOP OF WALL ELEV, SEE PLAN.
 - TOP OF SHELF ELEV, SEE PLAN.
 - C.J. INDICATES CONSTRUCTION/CONTRACTION JOINT. SEE DETAIL DWG S2.1.
 - CENTERLINES OF FOOTINGS SHALL BE CENTERED ON COLUMN CENTERLINES.
 - Fx INDICATES FOOTING DESIGNATION. SEE FOOTING SCHEDULE, THIS DWG.
 - Px INDICATES PIER DESIGNATION. SEE PIER DETAILS DWG S2.2.
 - G.C. SHALL COORD FLOOR DRAINS, RECESSED SLAB AREAS & TRENCH DRAIN SIZE AND LOCATIONS W/MEP DWGS & A1.0.
 - S.K. INDICATES SHEAR KEY REQ'D AT BRACING COL. SEE BRACING DETAILS & BASE PLATE DETAILS FOR ADDL INFO.
 - REFER TO MEP DWGS FOR HOUSEKEEPING PAD SIZES & LOCATIONS. SEE TIP DET DWG S2.1.

BID SET - NOT FOR CONSTRUCTION

COPYRIGHT: Reuse or reproduction of the contents of this document is not permitted without written permission of PORT CITY ARCHITECTURE PA

SHEET NAME
FOUNDATION PLAN

Drawn By
 APP
 Checked By
 DSB

S1.1