

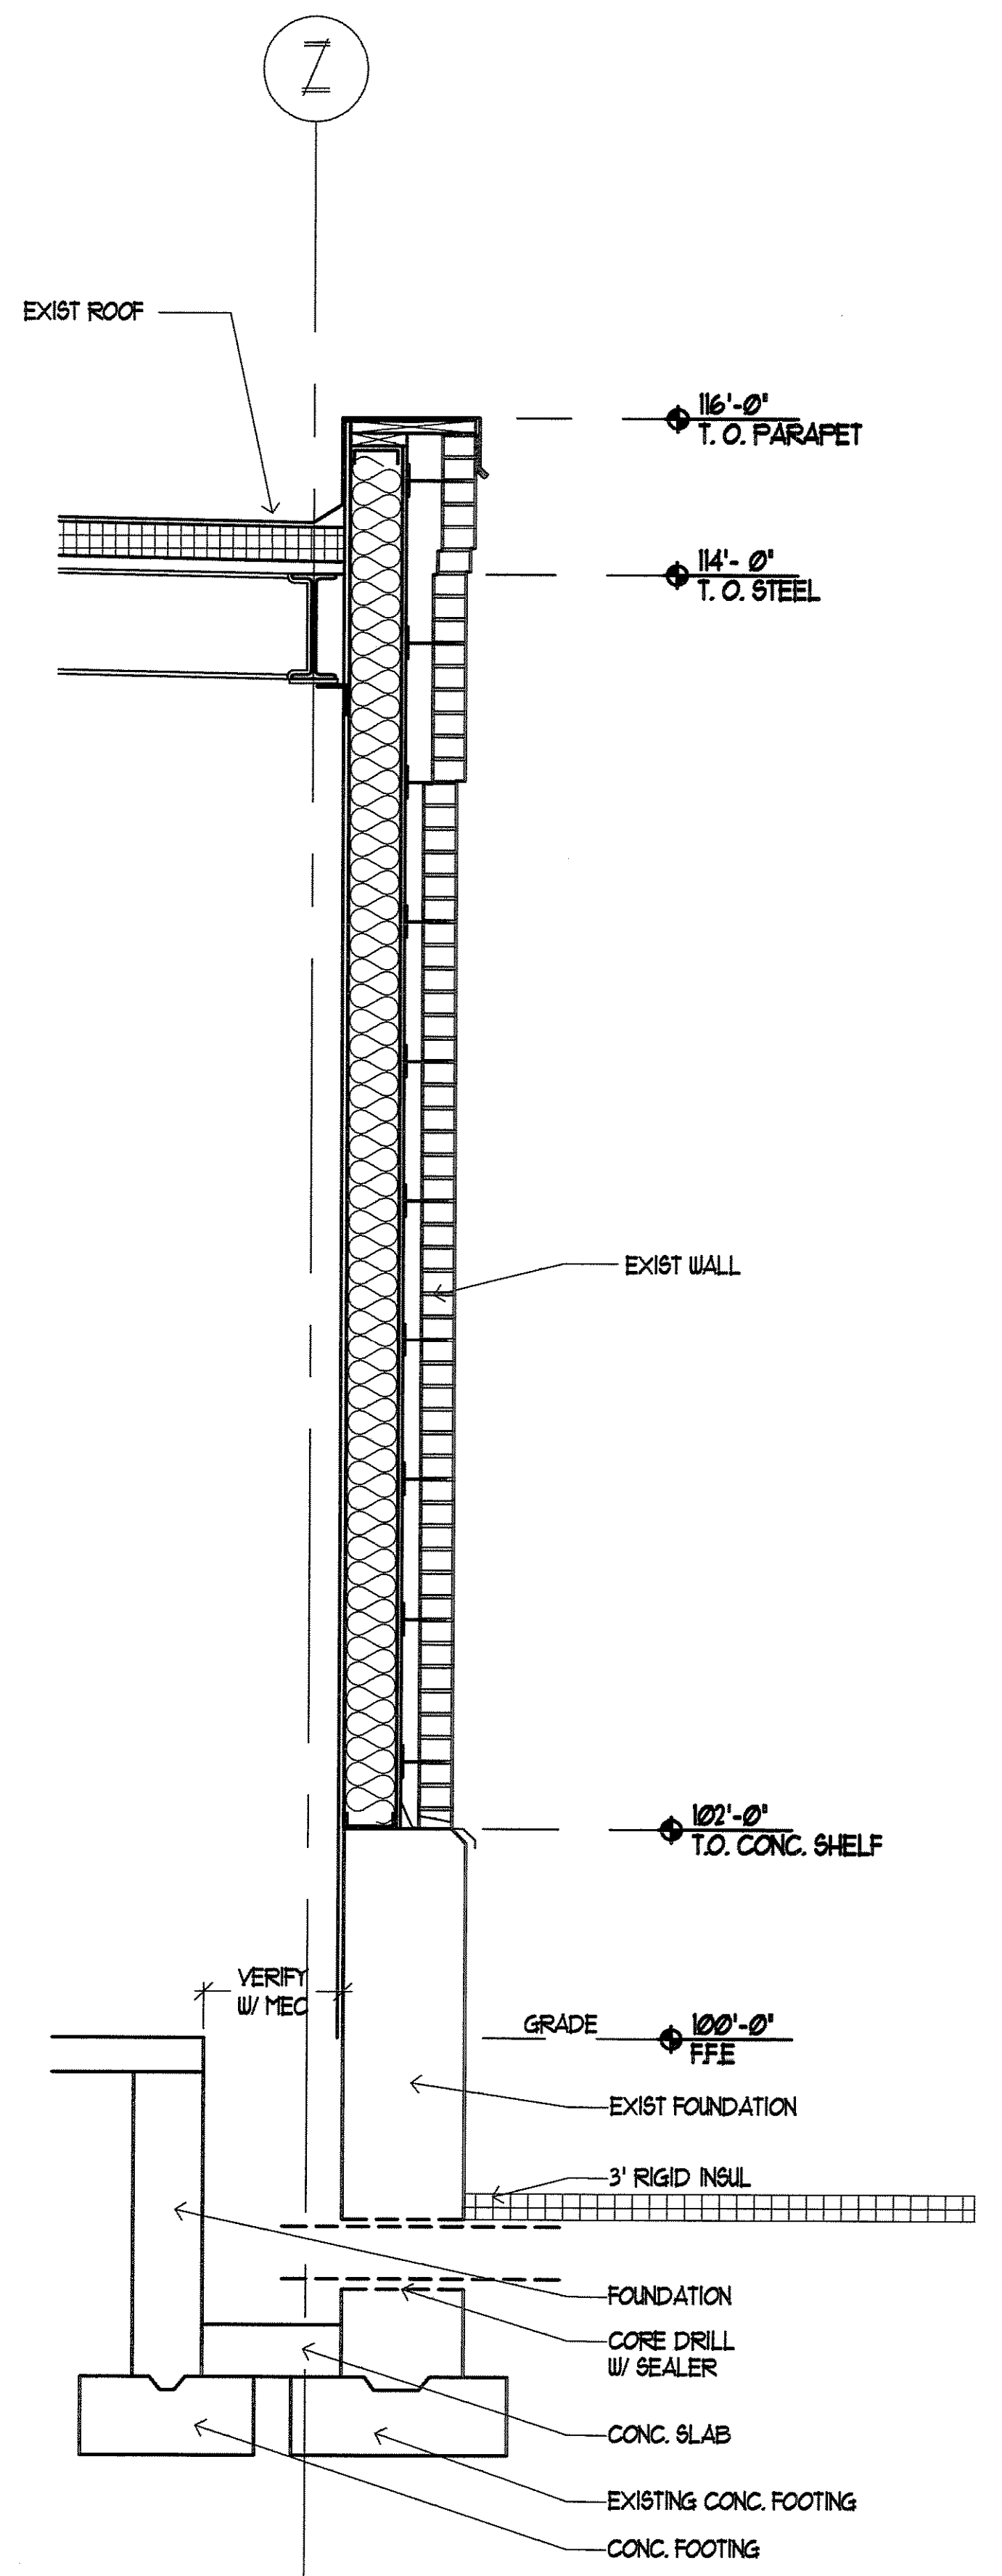


IF THIS SHEET IS NOT 24 X 36 IT IS A REDUCED SCALE PRINT - SCALE ACCORDINGLY

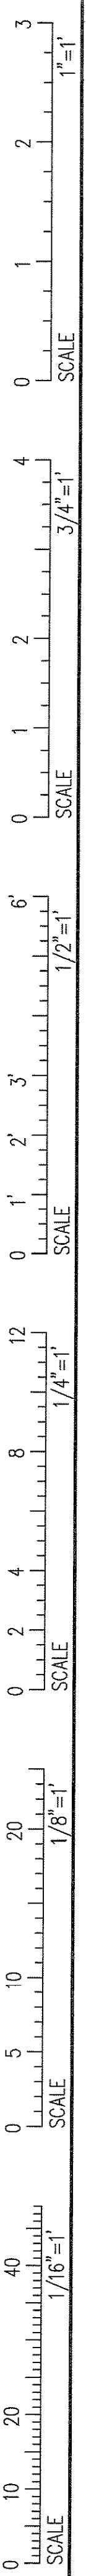

3 EXIST CHILLER ROOM WALL SECTION
SCALE: 1/4" = 1'-0"

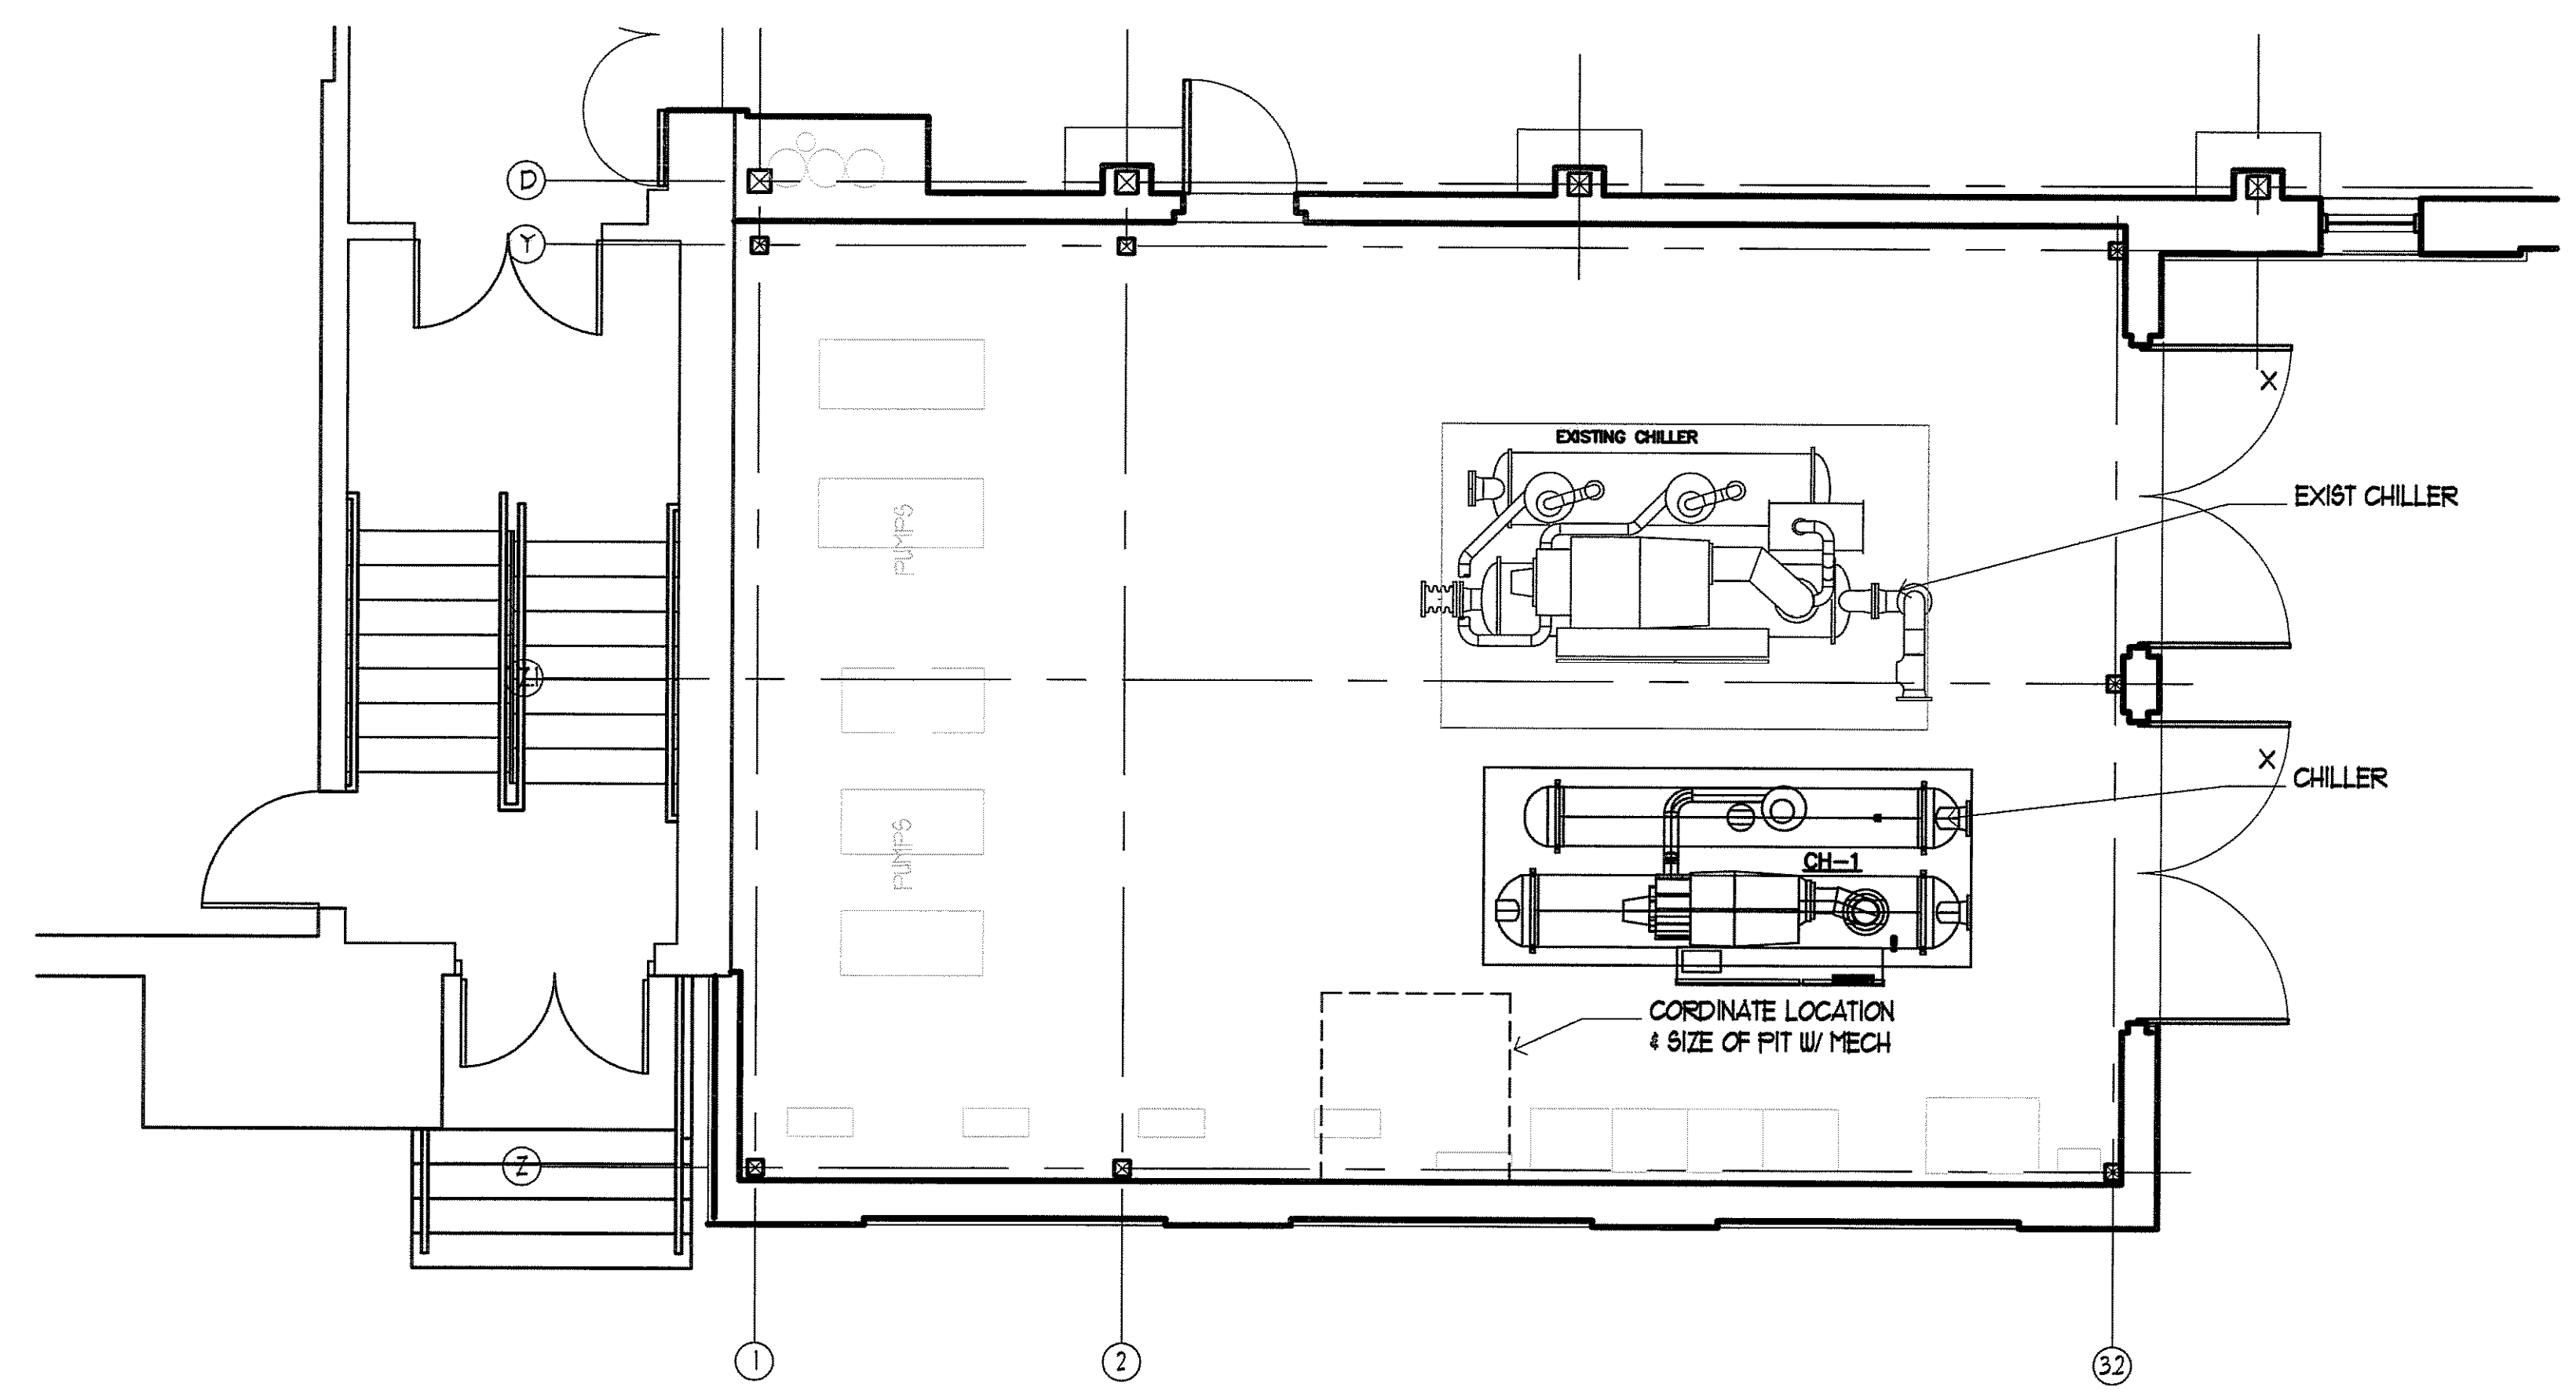

1 EXIST CHILLER ROOM PLAN
SCALE: 1/4" = 1'-0"

2 NOT USED
SCALE: 1/4" = 1'-0"



PORT CITY ARCHITECTURE
65 NEWBURY STREET
PORTLAND, ME 04101
207.761.9000
fax: 207.761.2010
lita@portcityarch.com

JACOBS CONSULTANCY
OPR Laboratory Planning Practice

VANZELM ENGINEERS
VANZELM HEYWOOD & SHADFORD, INC.

BECKER
structural engineers, inc.

SYTDDesign CONSULTANTS
CIVIL ENGINEERING & LANDSCAPE ARCHITECTURE

ALLIED/COOK CONSTRUCTION

Favreau
ELECTRIC

Titan Mechanical
Design Build Specialty - Mechanical Contractors

UNIVERSITY OF NEW ENGLAND
COLLEGE OF PHARMACY
716 STEVENS AVENUE, PORTLAND, ME

DATE	DESCRIPTION
	BID SET
Date Issued	02/08/08
Project Number	06506

SHEET NAME
CHILLER ROOM PLAN

Drawn By
EG, AM, EK

Checked By
LAS

A10.1

BID SET - NOT FOR CONSTRUCTION

COPYRIGHT: Reuse or reproduction of the contents of this document is not permitted without written permission of PORT CITY ARCHITECTURE PA