

3
2
1
0
SCALE
1"=1'


4
3
2
1
0
SCALE
3/4"=1'

6'
3'
2'
1'
0
SCALE
1/2"=1'


12
8
4
2
1
0
SCALE
1/4"=1'

20
10
5
0
SCALE
1/8"=1'


40
20
10
0
SCALE
1/16"=1'

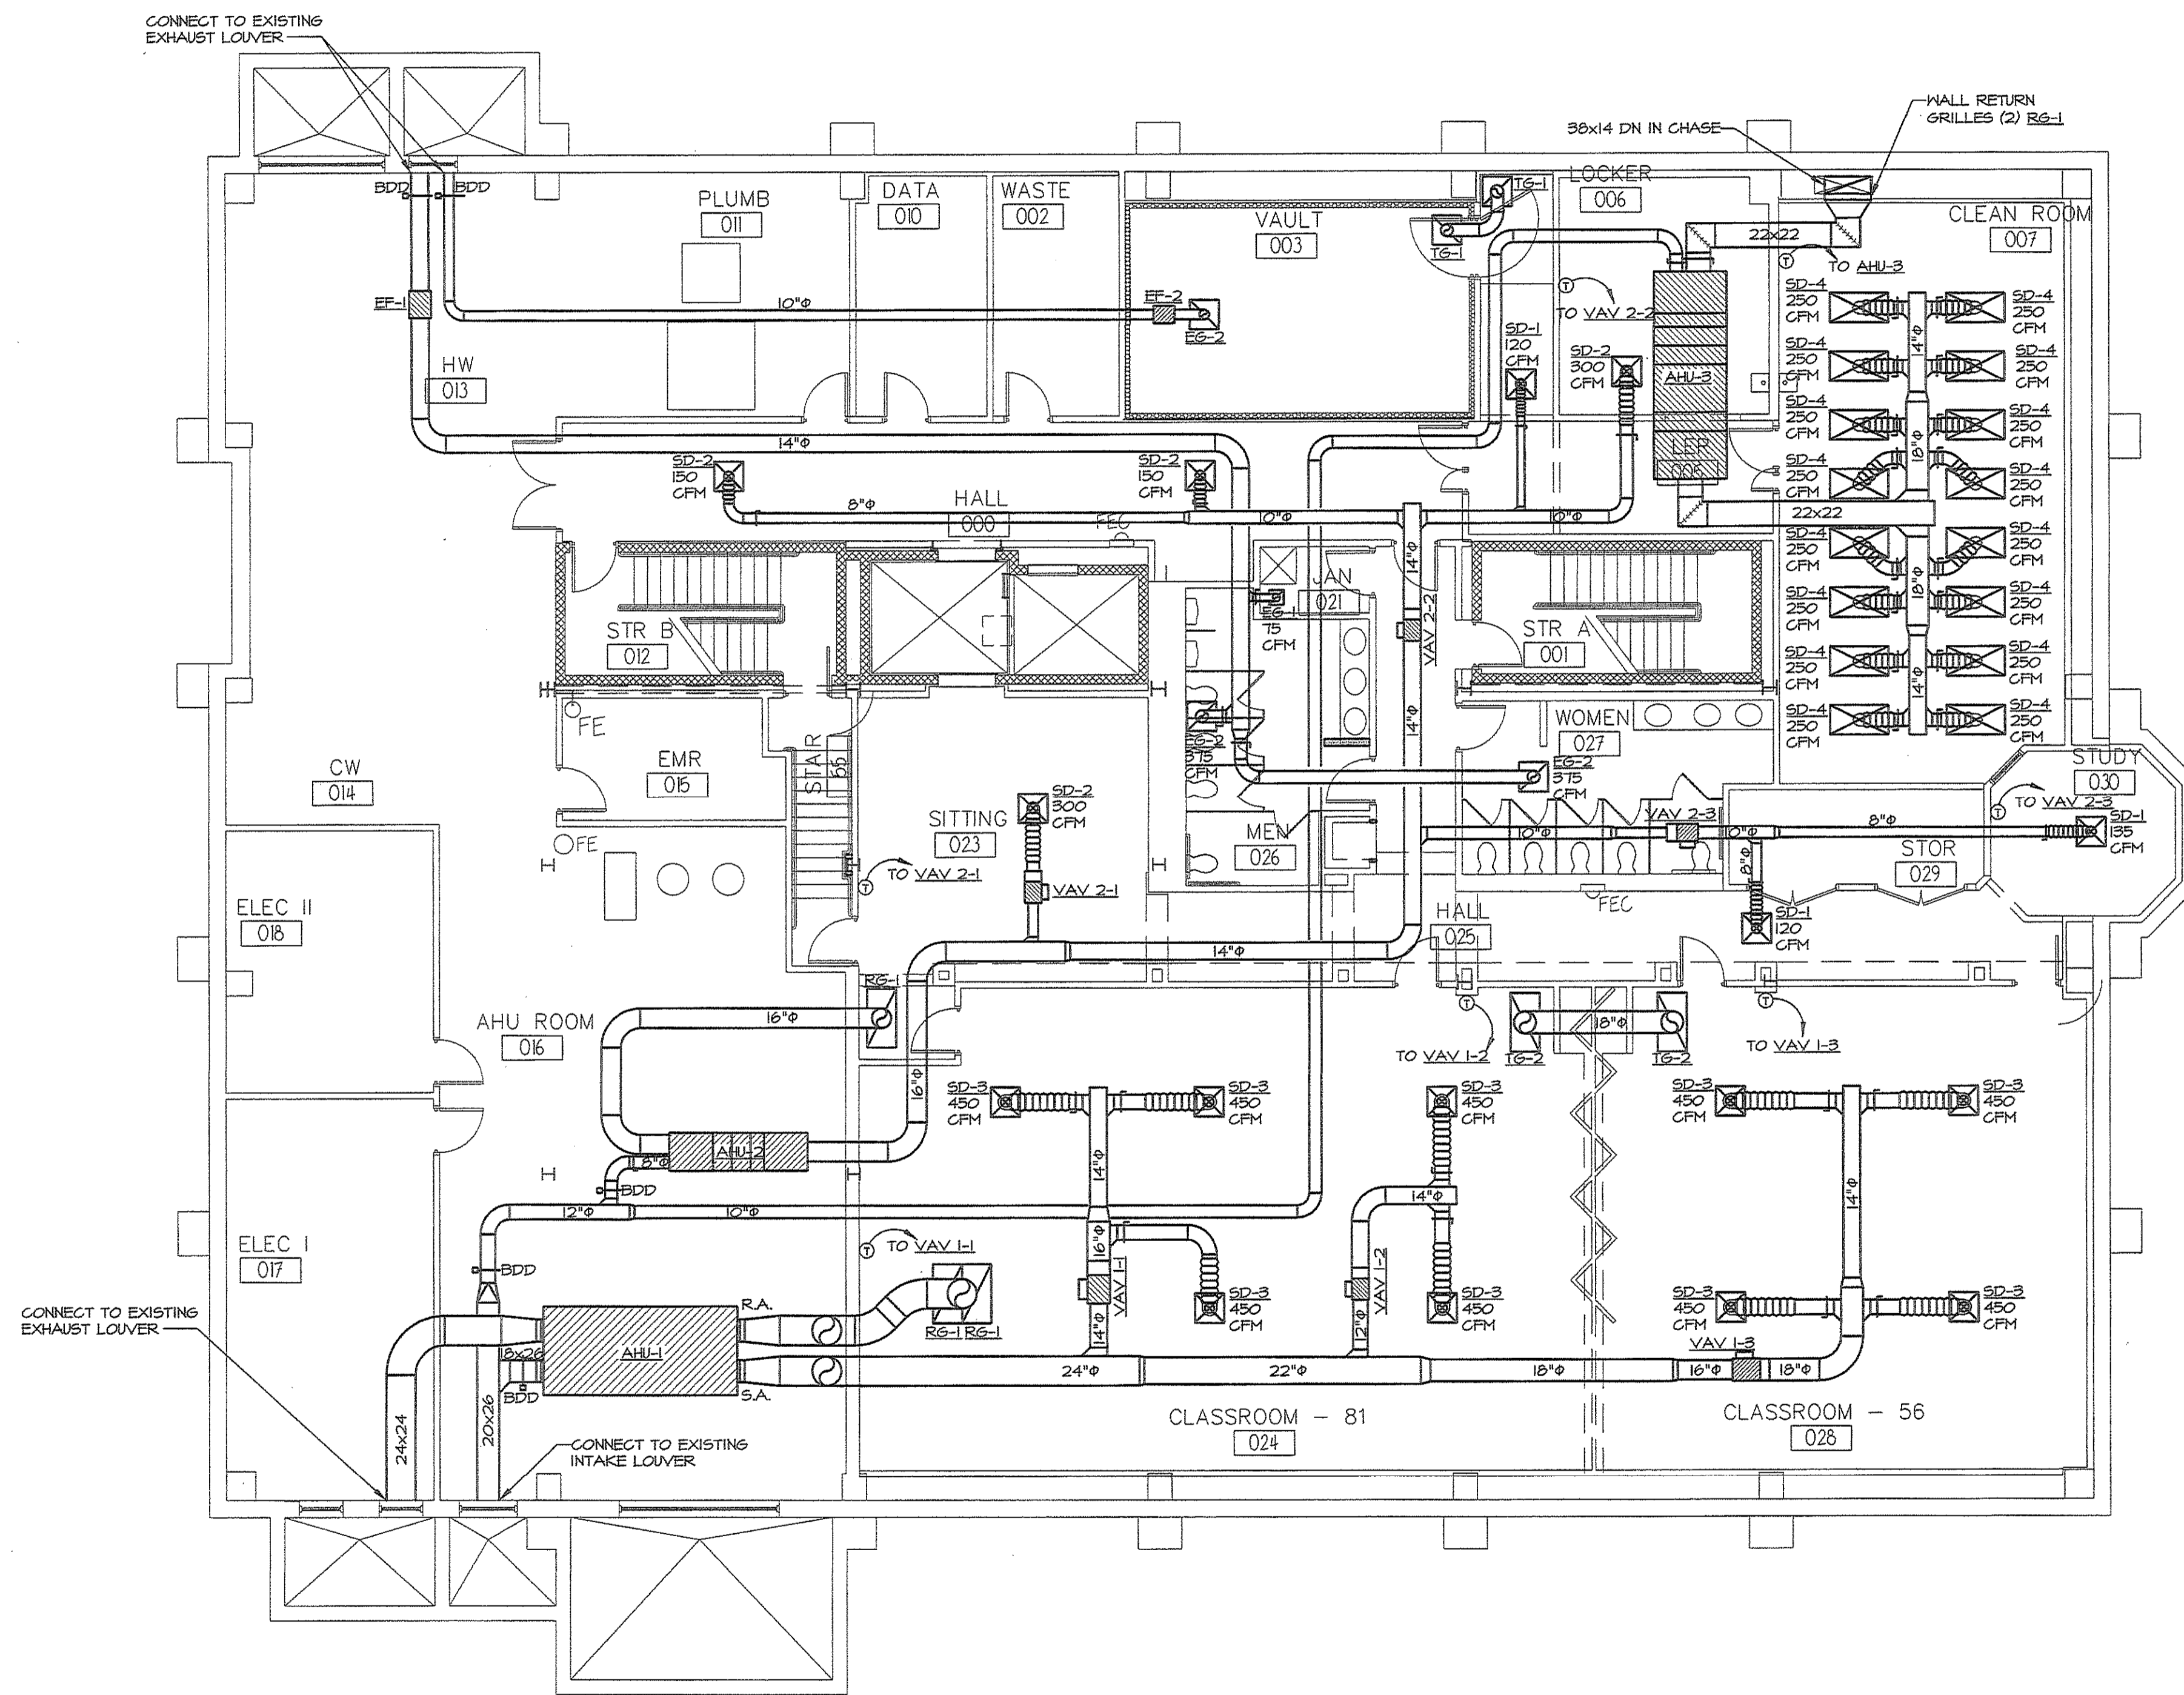

LOWER LEVEL HVAC PLAN
SCALE: 1/8" = 1'-0"

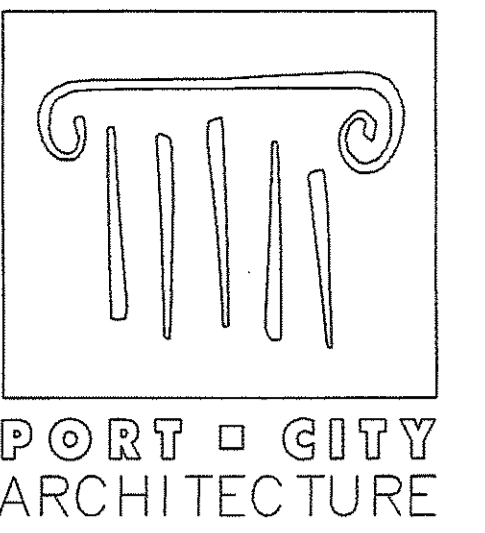

PORT CITY ARCHITECTURE
65 NEWBURY STREET
PORTLAND, ME 04101
207.761.9000
fax: 207.761.2010
lita@portcityarch.com

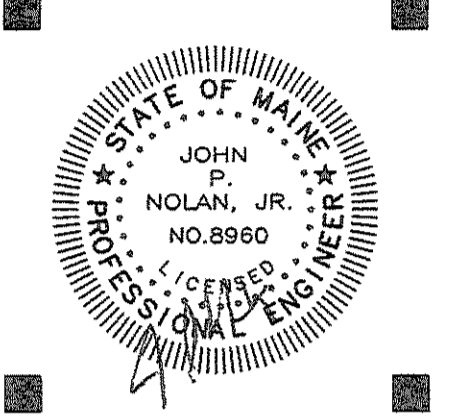

Titan Mechanical, Inc.
Design Build Engineering - Mechanical Contracting
P.O. Box 3927 / 232 Riverside Industrial Parkway
Portland, Maine 04104
Ph. (207) 878-5223 Fax. (207) 878-5235

**UNIVERSITY OF NEW ENGLAND
COLLEGE OF
PHARMACY
CLASSROOMS**

716 STEVENS AVENUE, PORTLAND, ME

#	DATE	DESCRIPTION

SHEET NAME
**LOWER LEVEL
HVAC PLAN**

DRAWN BY
CJM

CHECKED BY
JPN

M1.0

PERMIT SET - NOT FOR CONSTRUCTION