

MHL
 RSW
 DCL
 21502.10
 DESIGNED BY:
 DRAWN BY:
 CHECKED BY:
 PROJECT:

UNIVERSITY OF NEW ENGLAND
 PORTLAND CAMPUS
 STEVEN AVENUE ARMORY
 716 STEVENS AVE
 PORTLAND, MAINE 04103
 T (207)285-0171


RENOVATIONS TO THE
 STEVENS AVENUE ARMORY

FIRST FLOOR
 ELECTRICAL
 REMOVALS
 PLAN

SCALE: AS NOTED
 DATE: 05-24-16

DWG. ED101

SHEET: 147 OF 169

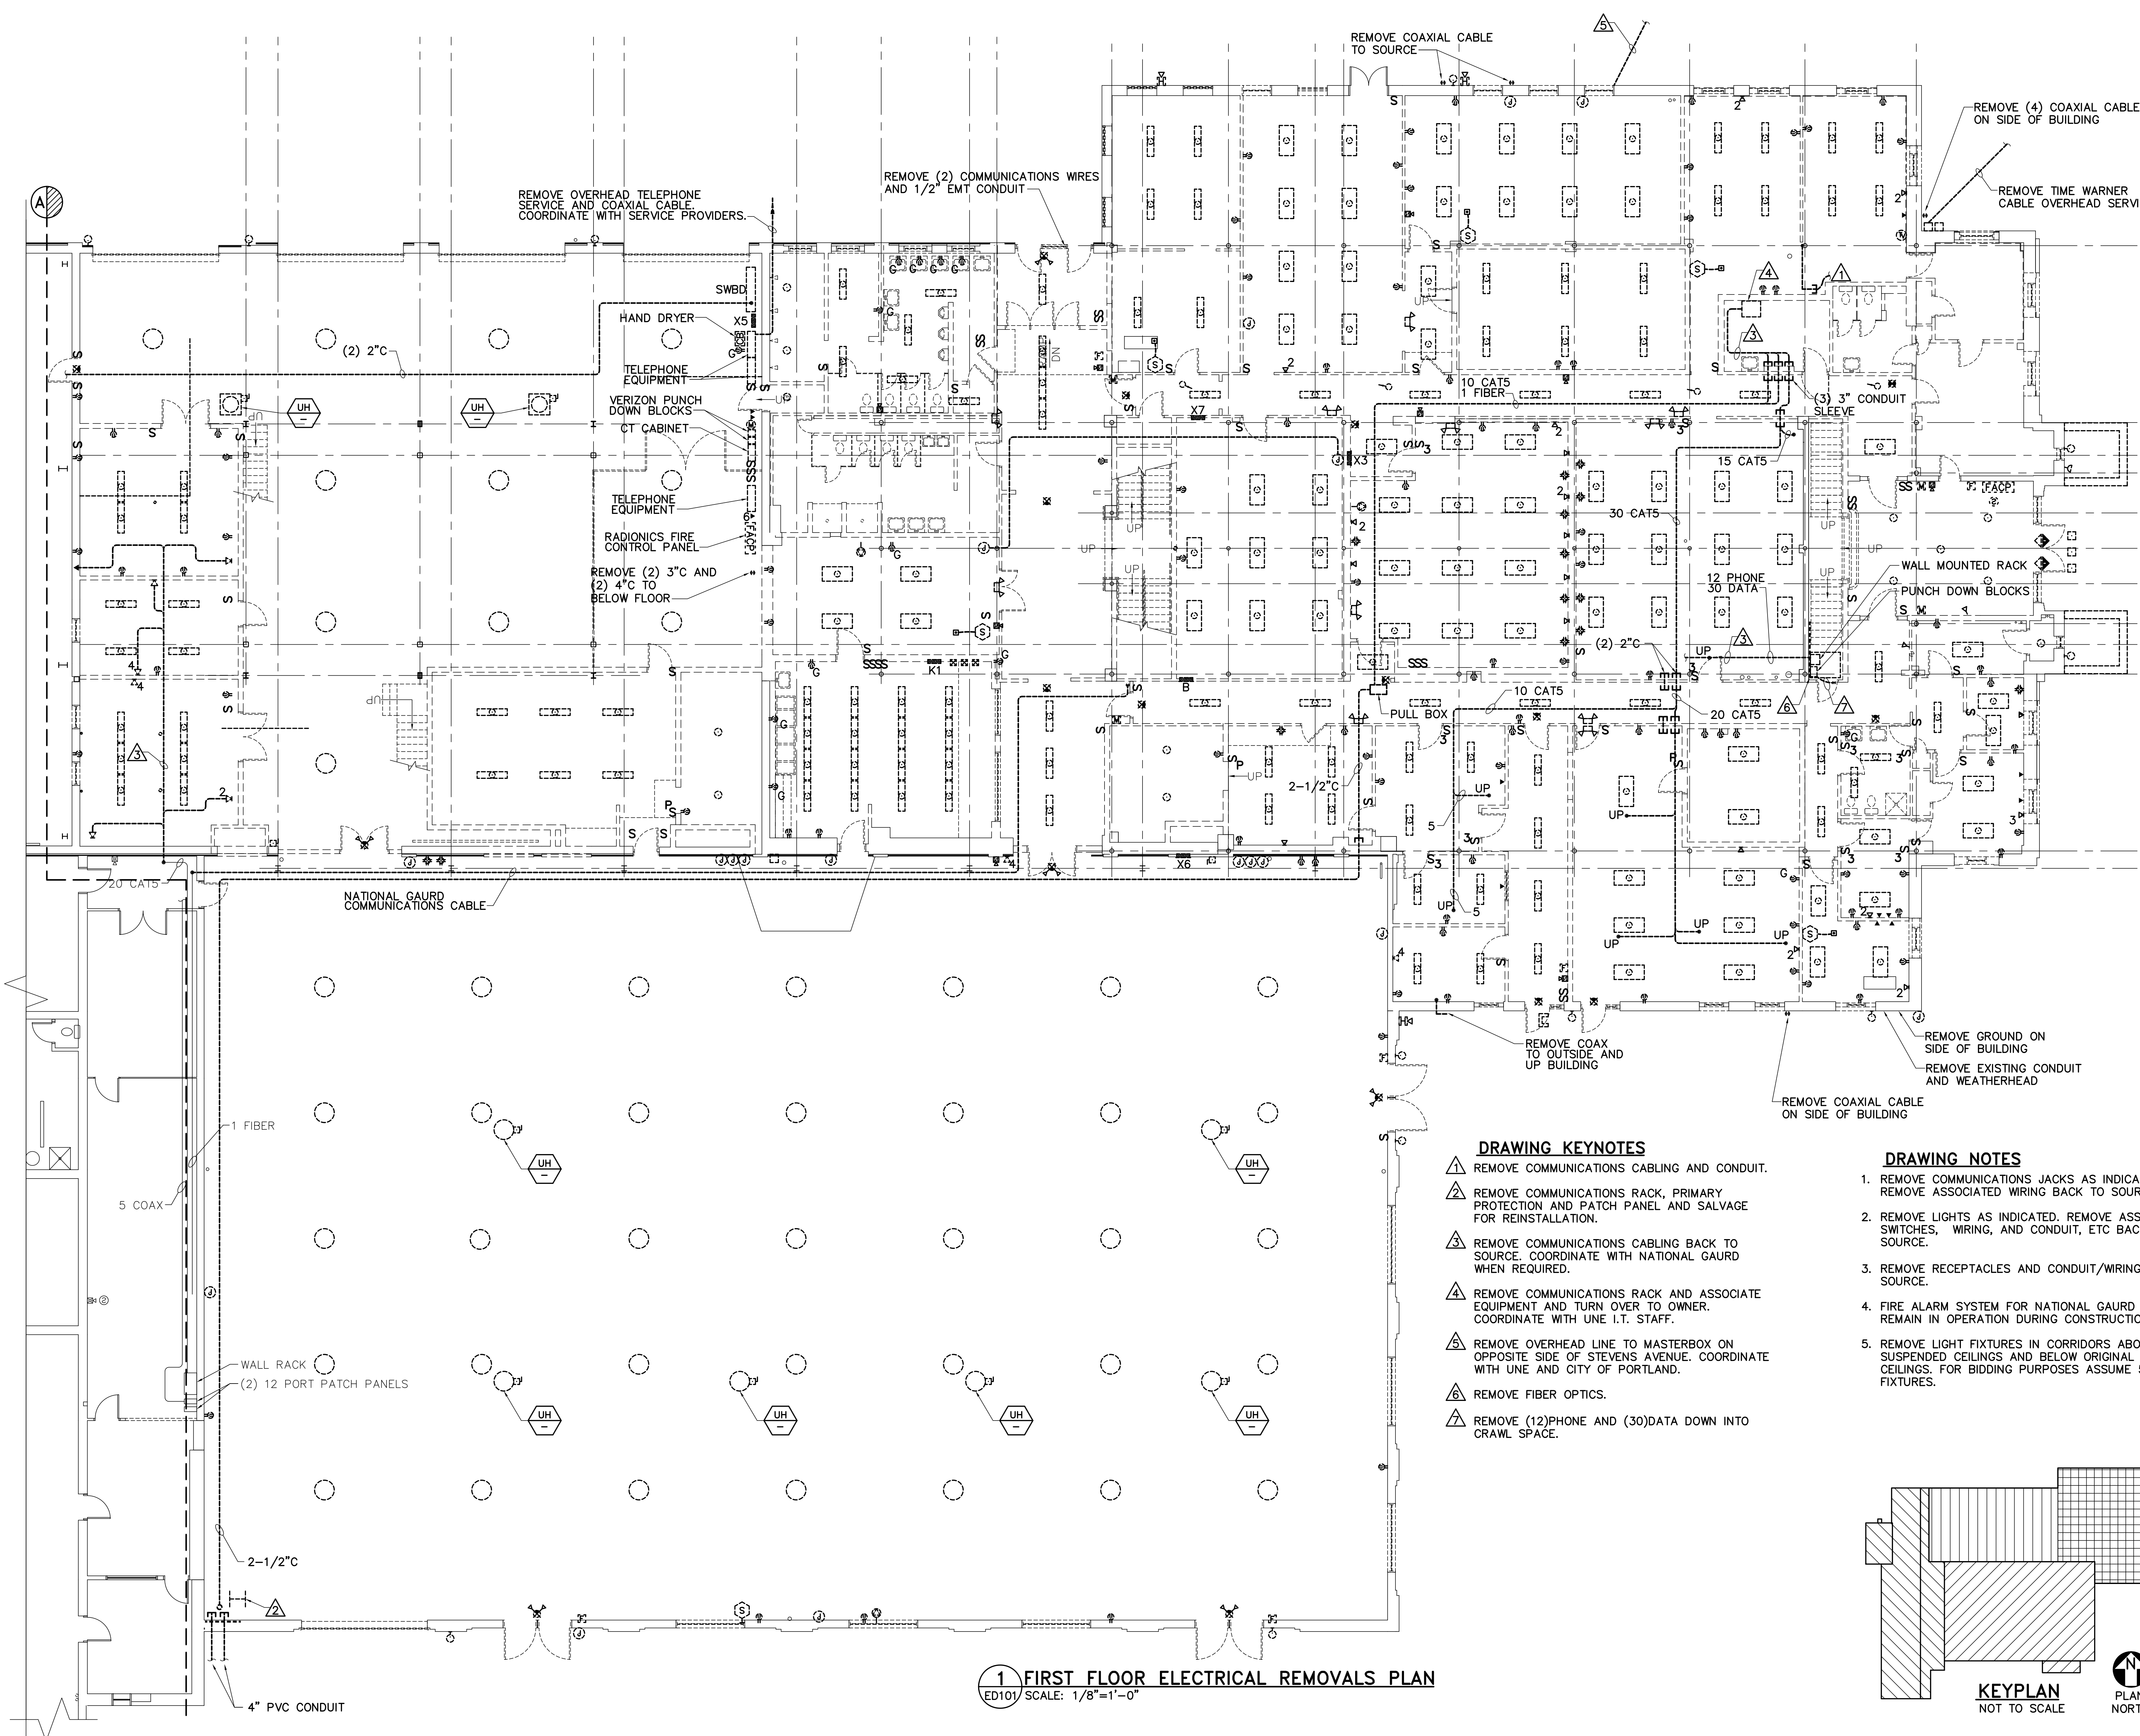

DRAWING KEYNOTES

- ⚠ REMOVE COMMUNICATIONS CABLING AND CONDUIT.
- ⚠ REMOVE COMMUNICATIONS RACK, PRIMARY PROTECTION AND PATCH PANEL AND SALVAGE FOR REINSTALLATION.
- ⚠ REMOVE COMMUNICATIONS CABLING BACK TO SOURCE. COORDINATE WITH NATIONAL GAIRD WHEN REQUIRED.
- ⚠ REMOVE COMMUNICATIONS RACK AND ASSOCIATE EQUIPMENT AND TURN OVER TO OWNER. COORDINATE WITH UNE I.T. STAFF.
- ⚠ REMOVE OVERHEAD LINE TO MASTERBOX ON OPPOSITE SIDE OF STEVENS AVENUE. COORDINATE WITH UNE AND CITY OF PORTLAND.
- ⚠ REMOVE FIBER OPTICS.
- ⚠ REMOVE (12)PHONE AND (30)DATA DOWN INTO CRAWL SPACE.

DRAWING NOTES

1. REMOVE COMMUNICATIONS JACKS AS INDICATED. REMOVE ASSOCIATED WIRING BACK TO SOURCE.
2. REMOVE LIGHTS AS INDICATED. REMOVE ASSOCIATED SWITCHES, WIRING, AND CONDUIT, ETC BACK TO THE SOURCE.
3. REMOVE RECEPTACLES AND CONDUIT/WIRING BACK TO SOURCE.
4. FIRE ALARM SYSTEM FOR NATIONAL GAIRD SHALL REMAIN IN OPERATION DURING CONSTRUCTION.
5. REMOVE LIGHT FIXTURES IN CORRIDORS ABOVE SUSPENDED CEILINGS AND BELOW ORIGINAL HARD CEILINGS. FOR BIDDING PURPOSES ASSUME 50 FIXTURES.

1 FIRST FLOOR ELECTRICAL REMOVALS PLAN
 ED101 SCALE: 1/8"=1'-0"

