

MHL BPD DCL
 21502.10
 DESIGNED BY:
 DRAWN BY:
 CHECKED BY:
 PROJECT:

**UNIVERSITY OF NEW ENGLAND
 PORTLAND CAMPUS**
 STEVEN AVENUE ARMORY
 716 STEVENS AVE
 PORTLAND, MAINE 04103
 T (207)285-0171


**RENOVATIONS TO THE
 STEVENS AVENUE ARMORY**

ROOF ELECTRICAL PLAN

SCALE: AS NOTED
 DATE: 05-24-16

DWG. **EP104**

SHEET: 154 OF 169

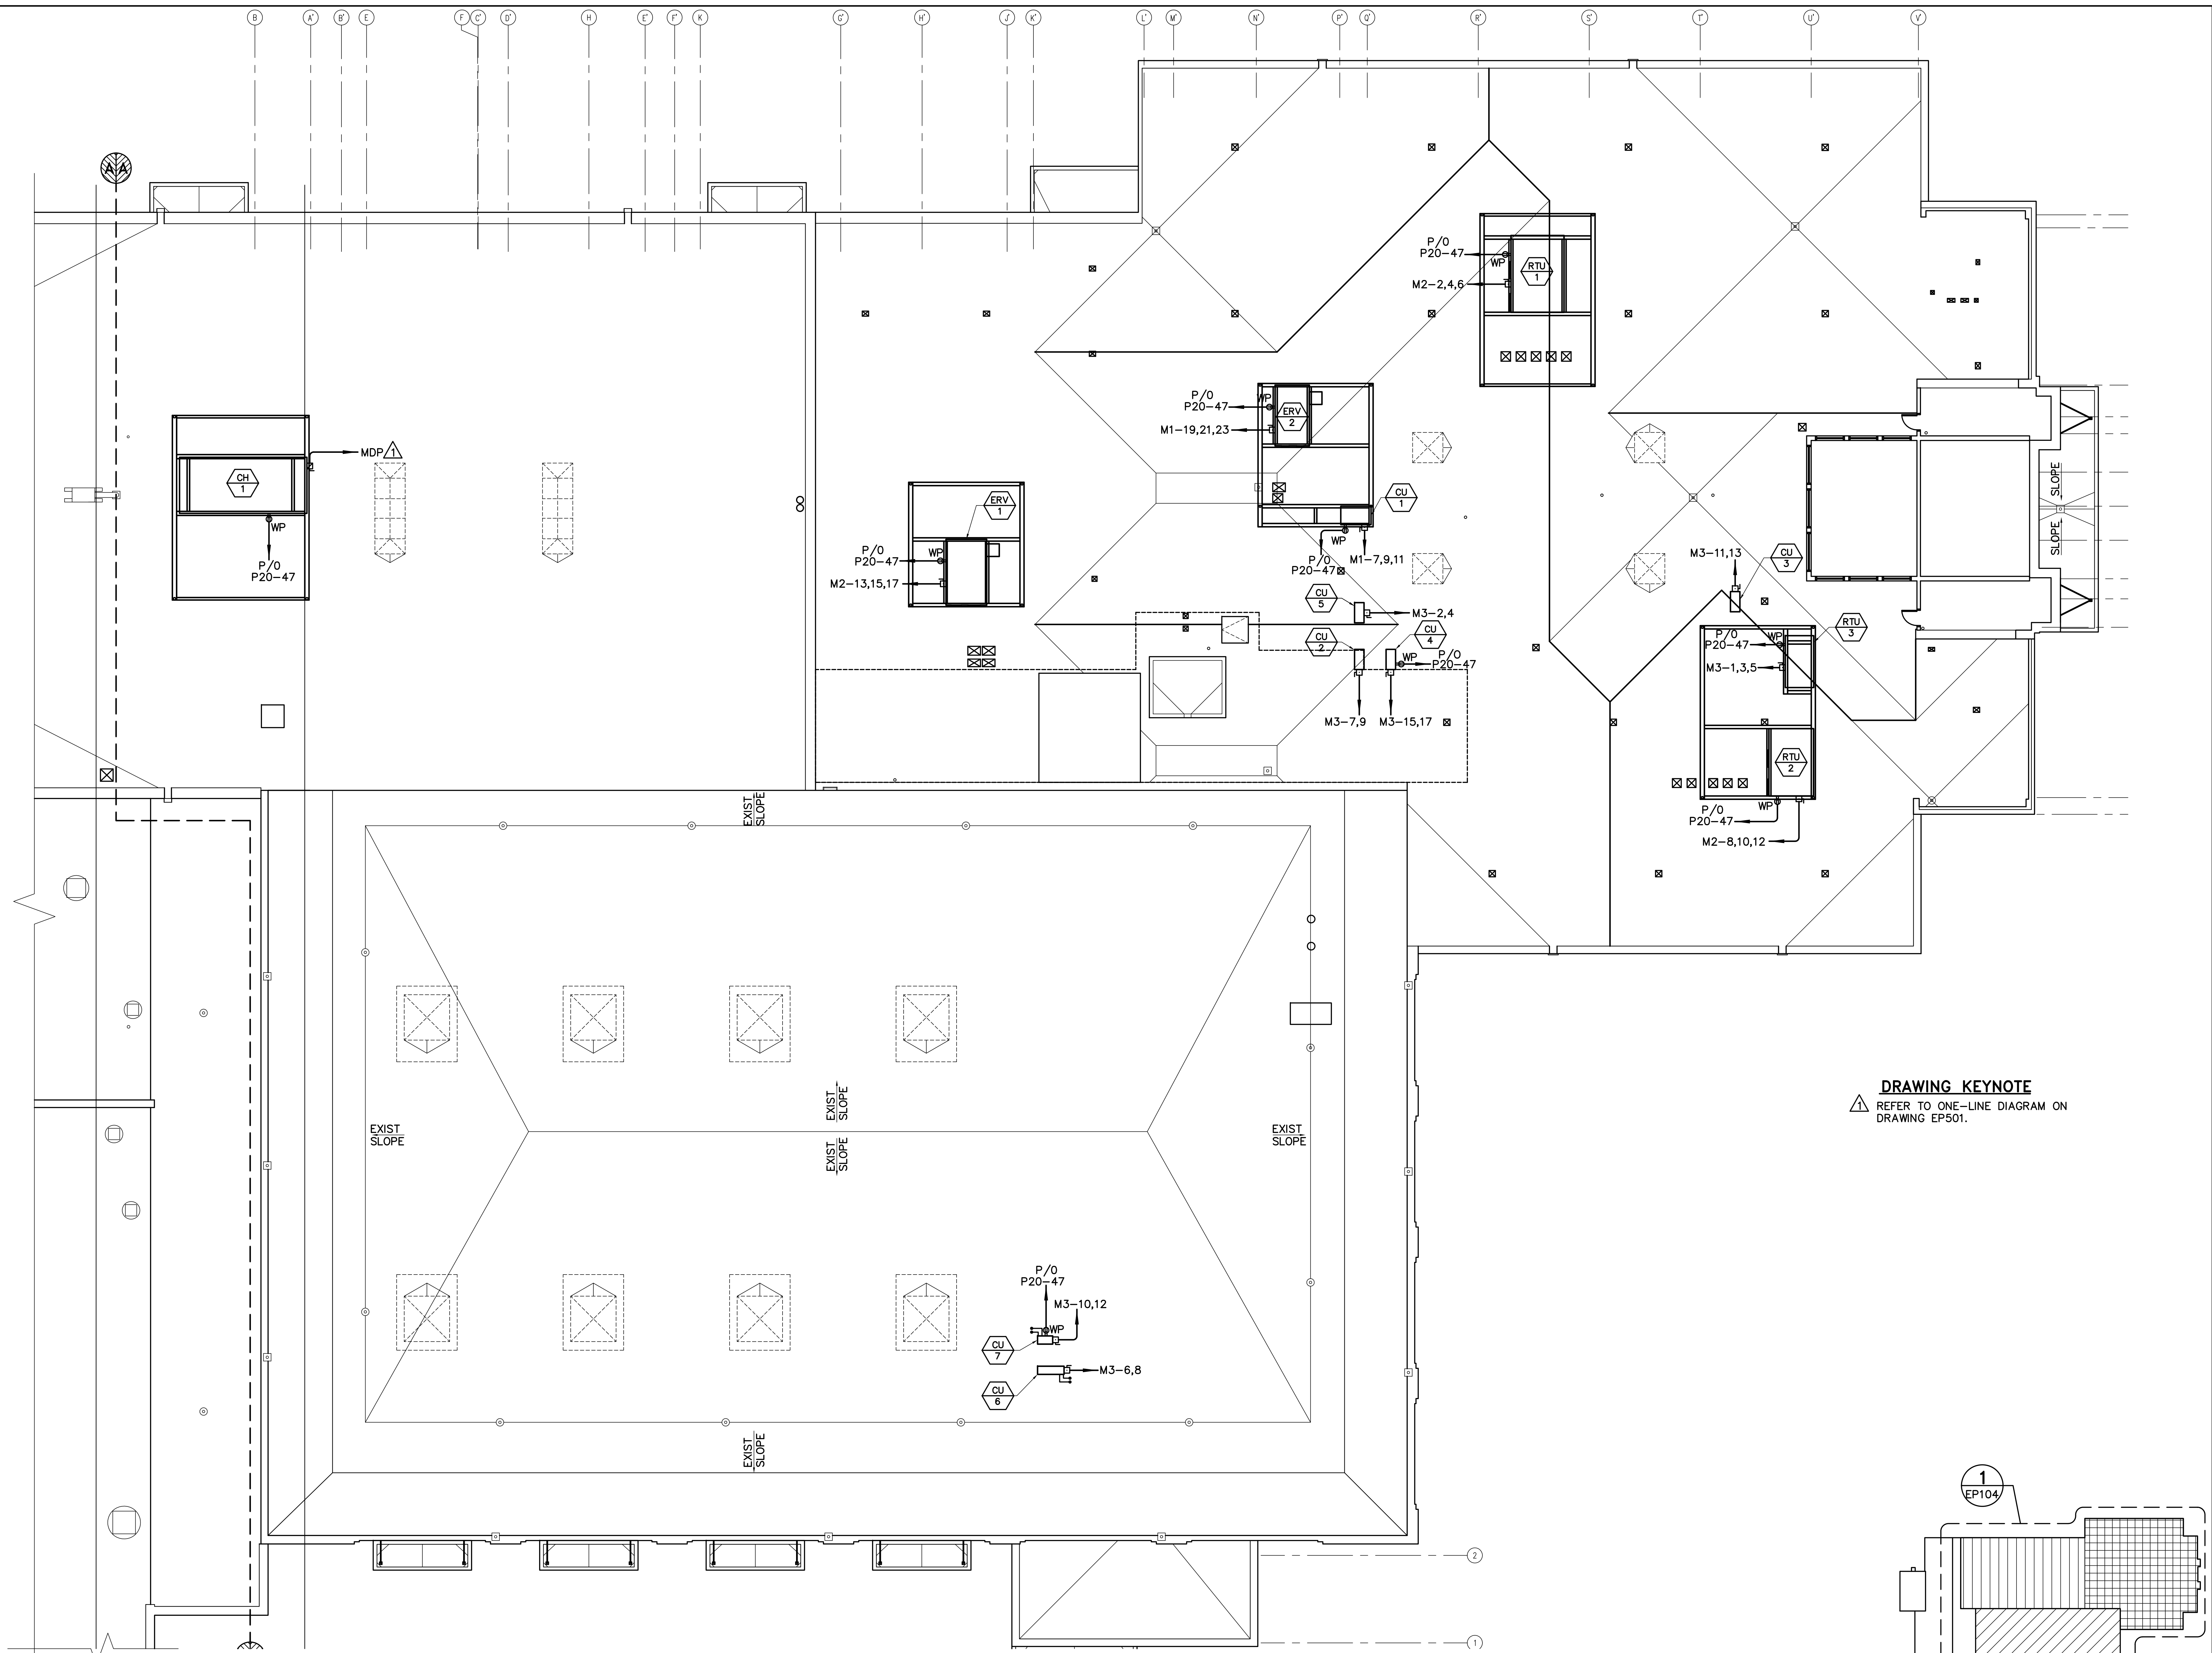

DRAWING KEYNOTE
 REFER TO ONE-LINE DIAGRAM ON DRAWING EP501.

1 ROOF ELECTRICAL PLAN
 EP104 SCALE: 1/8"=1'-0"

