



1 EXISTING COMMUNICATIONS ONE-LINE DIAGRAM
ET501 NOT TO SCALE

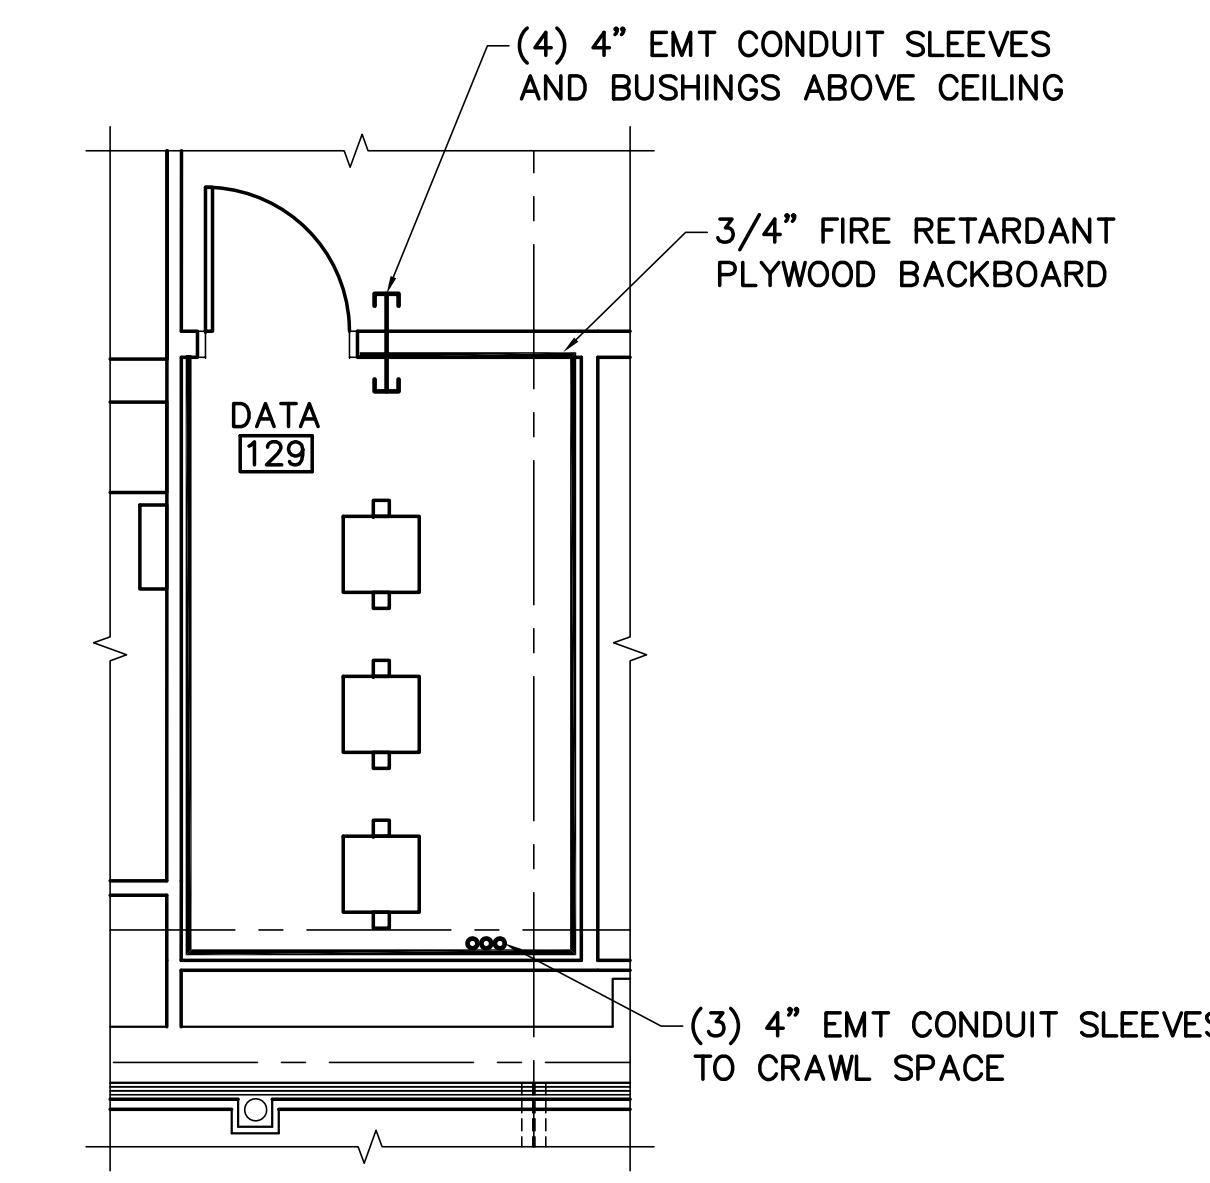


3 DATA ROOM 129 DETAIL
ET501 1/4"=1'-0"

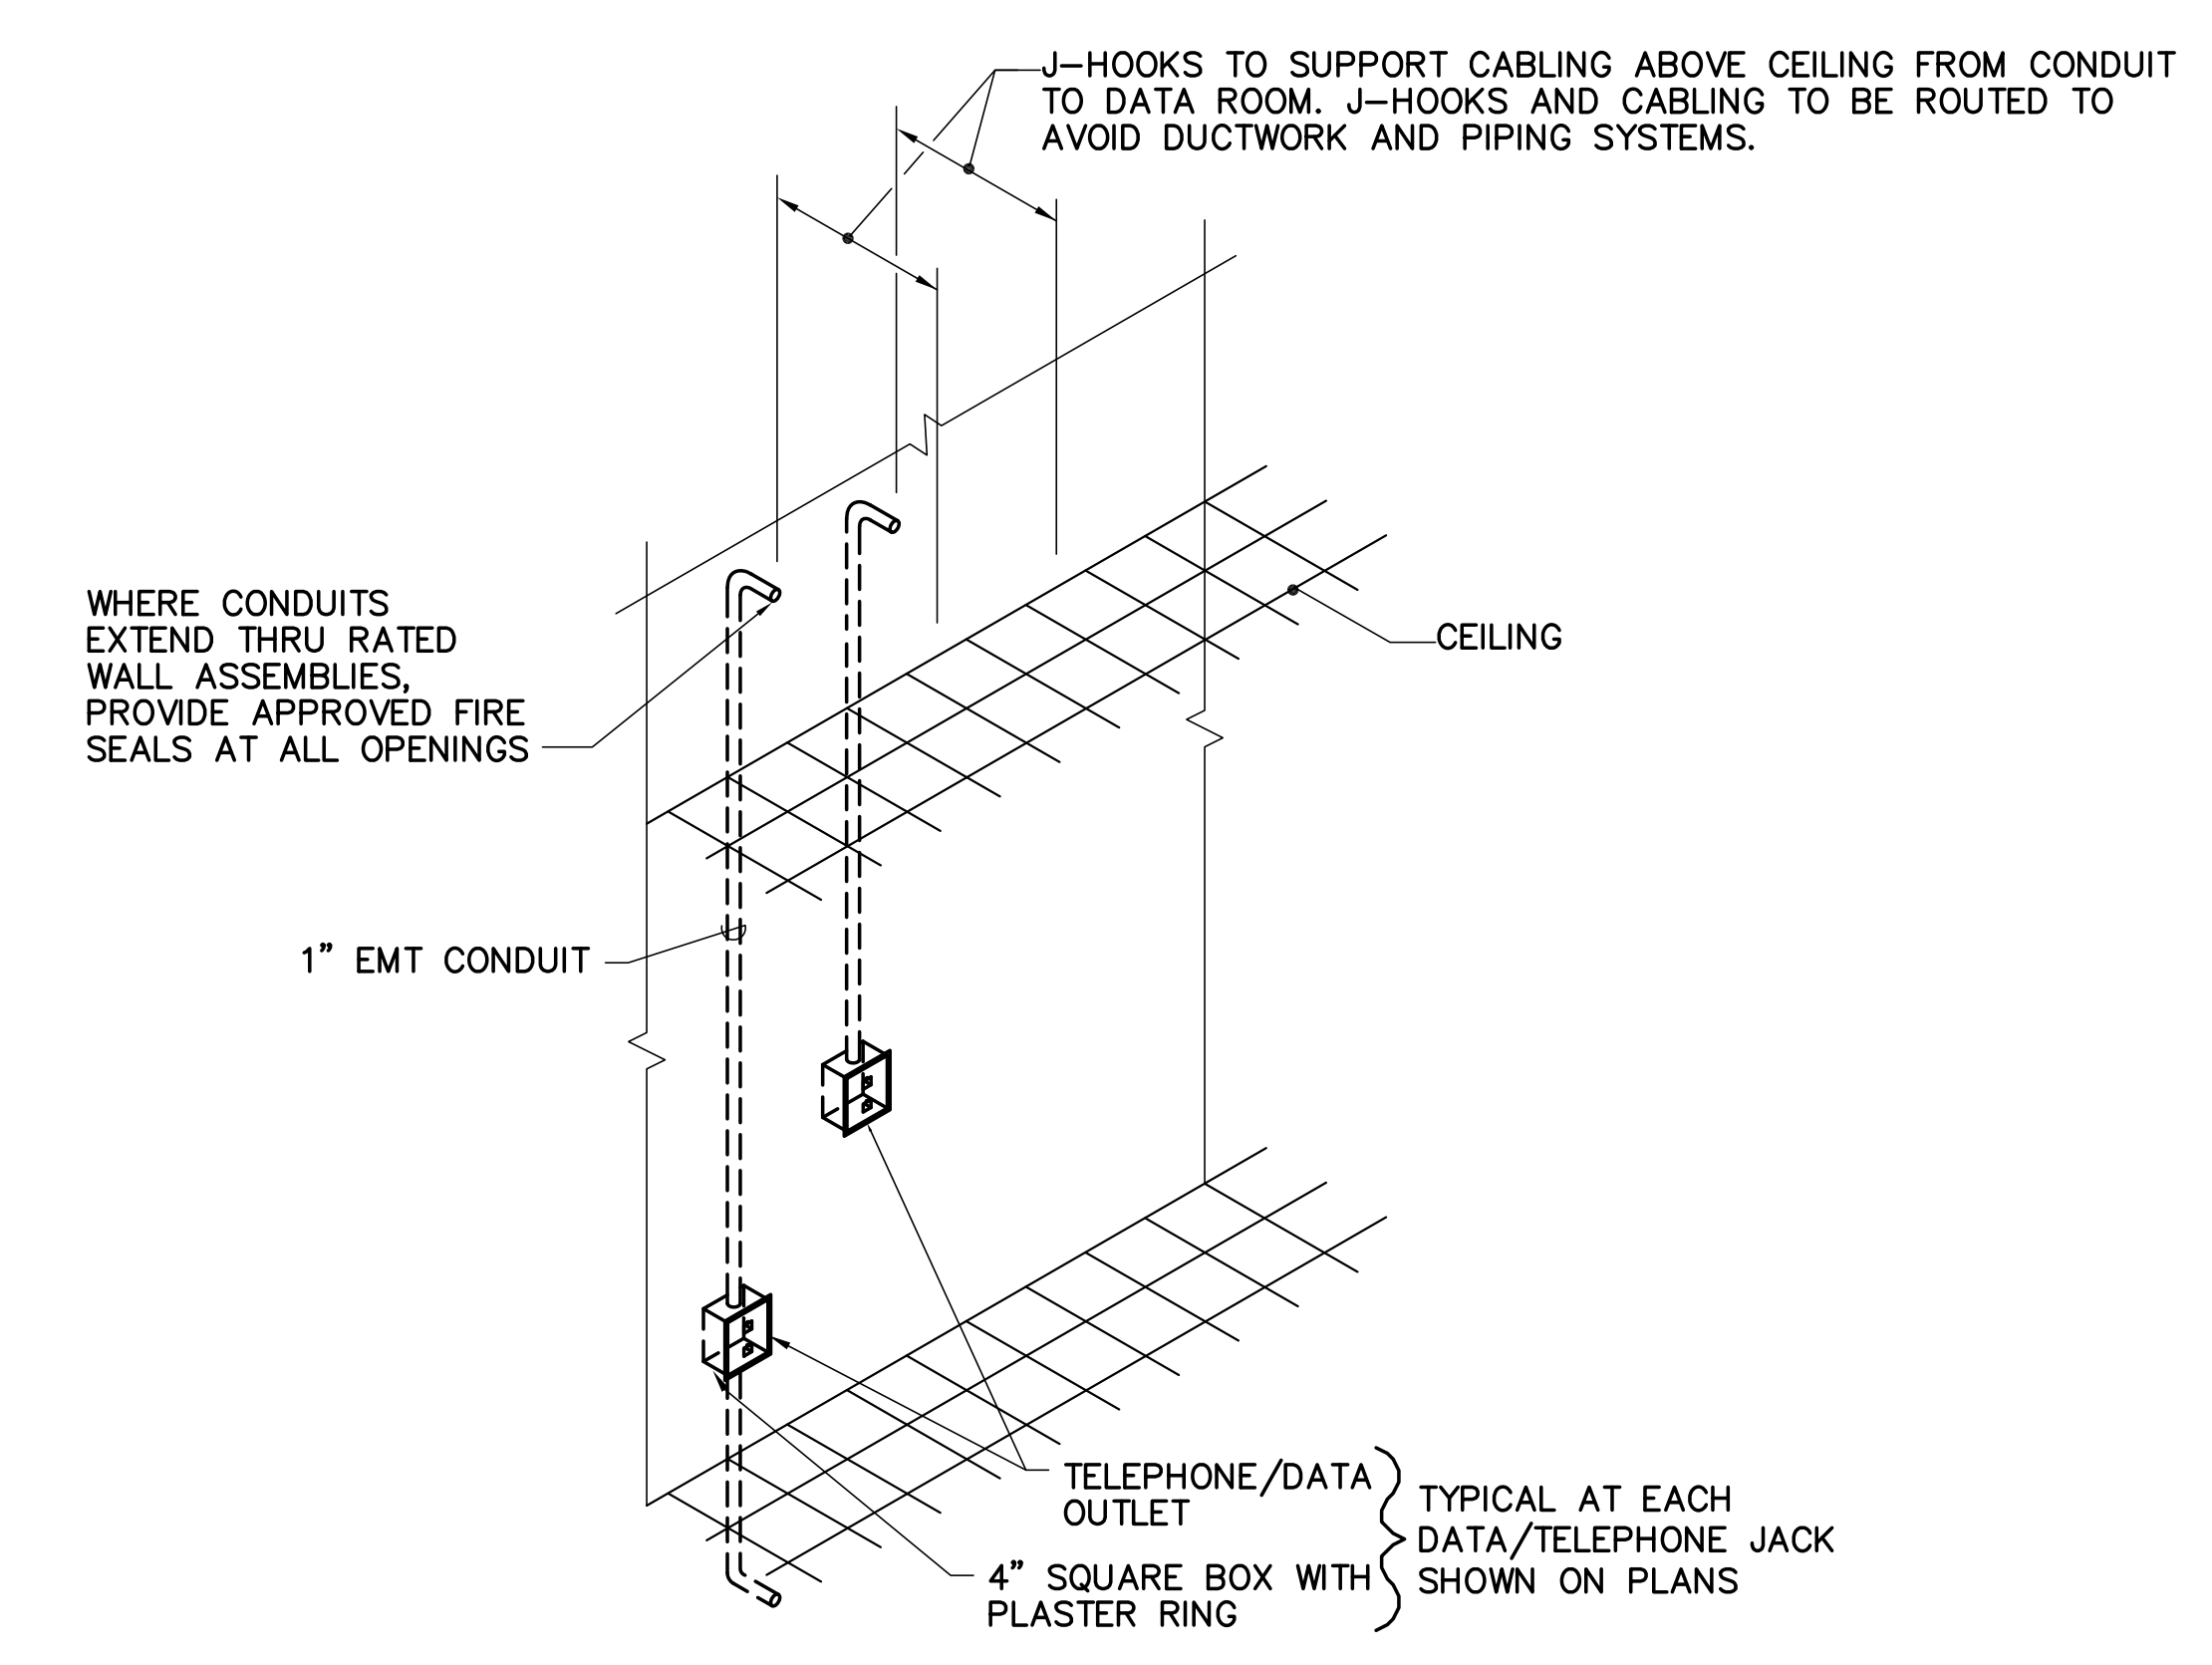

4 TYPICAL DETAIL OF BOXES AND TRAY
ET501 NOT TO SCALE

- REMOVALS KEYNOTES**
- △ REMOVE RACK AND SALVAGE FOR REINSTALLATION.
 - △ REMOVE FIBER PATCH PANEL AND SALVAGE FOR REINSTALLATION.
 - △ REMOVE PRIMARY PROTECTION AND SALVAGE FOR REINSTALLATION.
 - △ REMOVE 6-STRAND FIBER AND SALVAGE FOR REINSTALLATION.

- DRAWING KEYNOTES**
- △ INSTALL SALVAGED RACK.
 - △ INSTALL SALVAGED FIBER PATCH PANEL.
 - △ INSTALL SALVAGED PRIMARY PROTECTION.
 - △ INSTALL SALVAGED 6-STRAND FIBER.
 - △ PROVIDE CONCEALED BOX FOR ACCESS POINT MOUNTING. PROVIDE RJ45 MODULAR END FOR TERMINATION OF CAT6 CABLING TO ACCESS POINT.

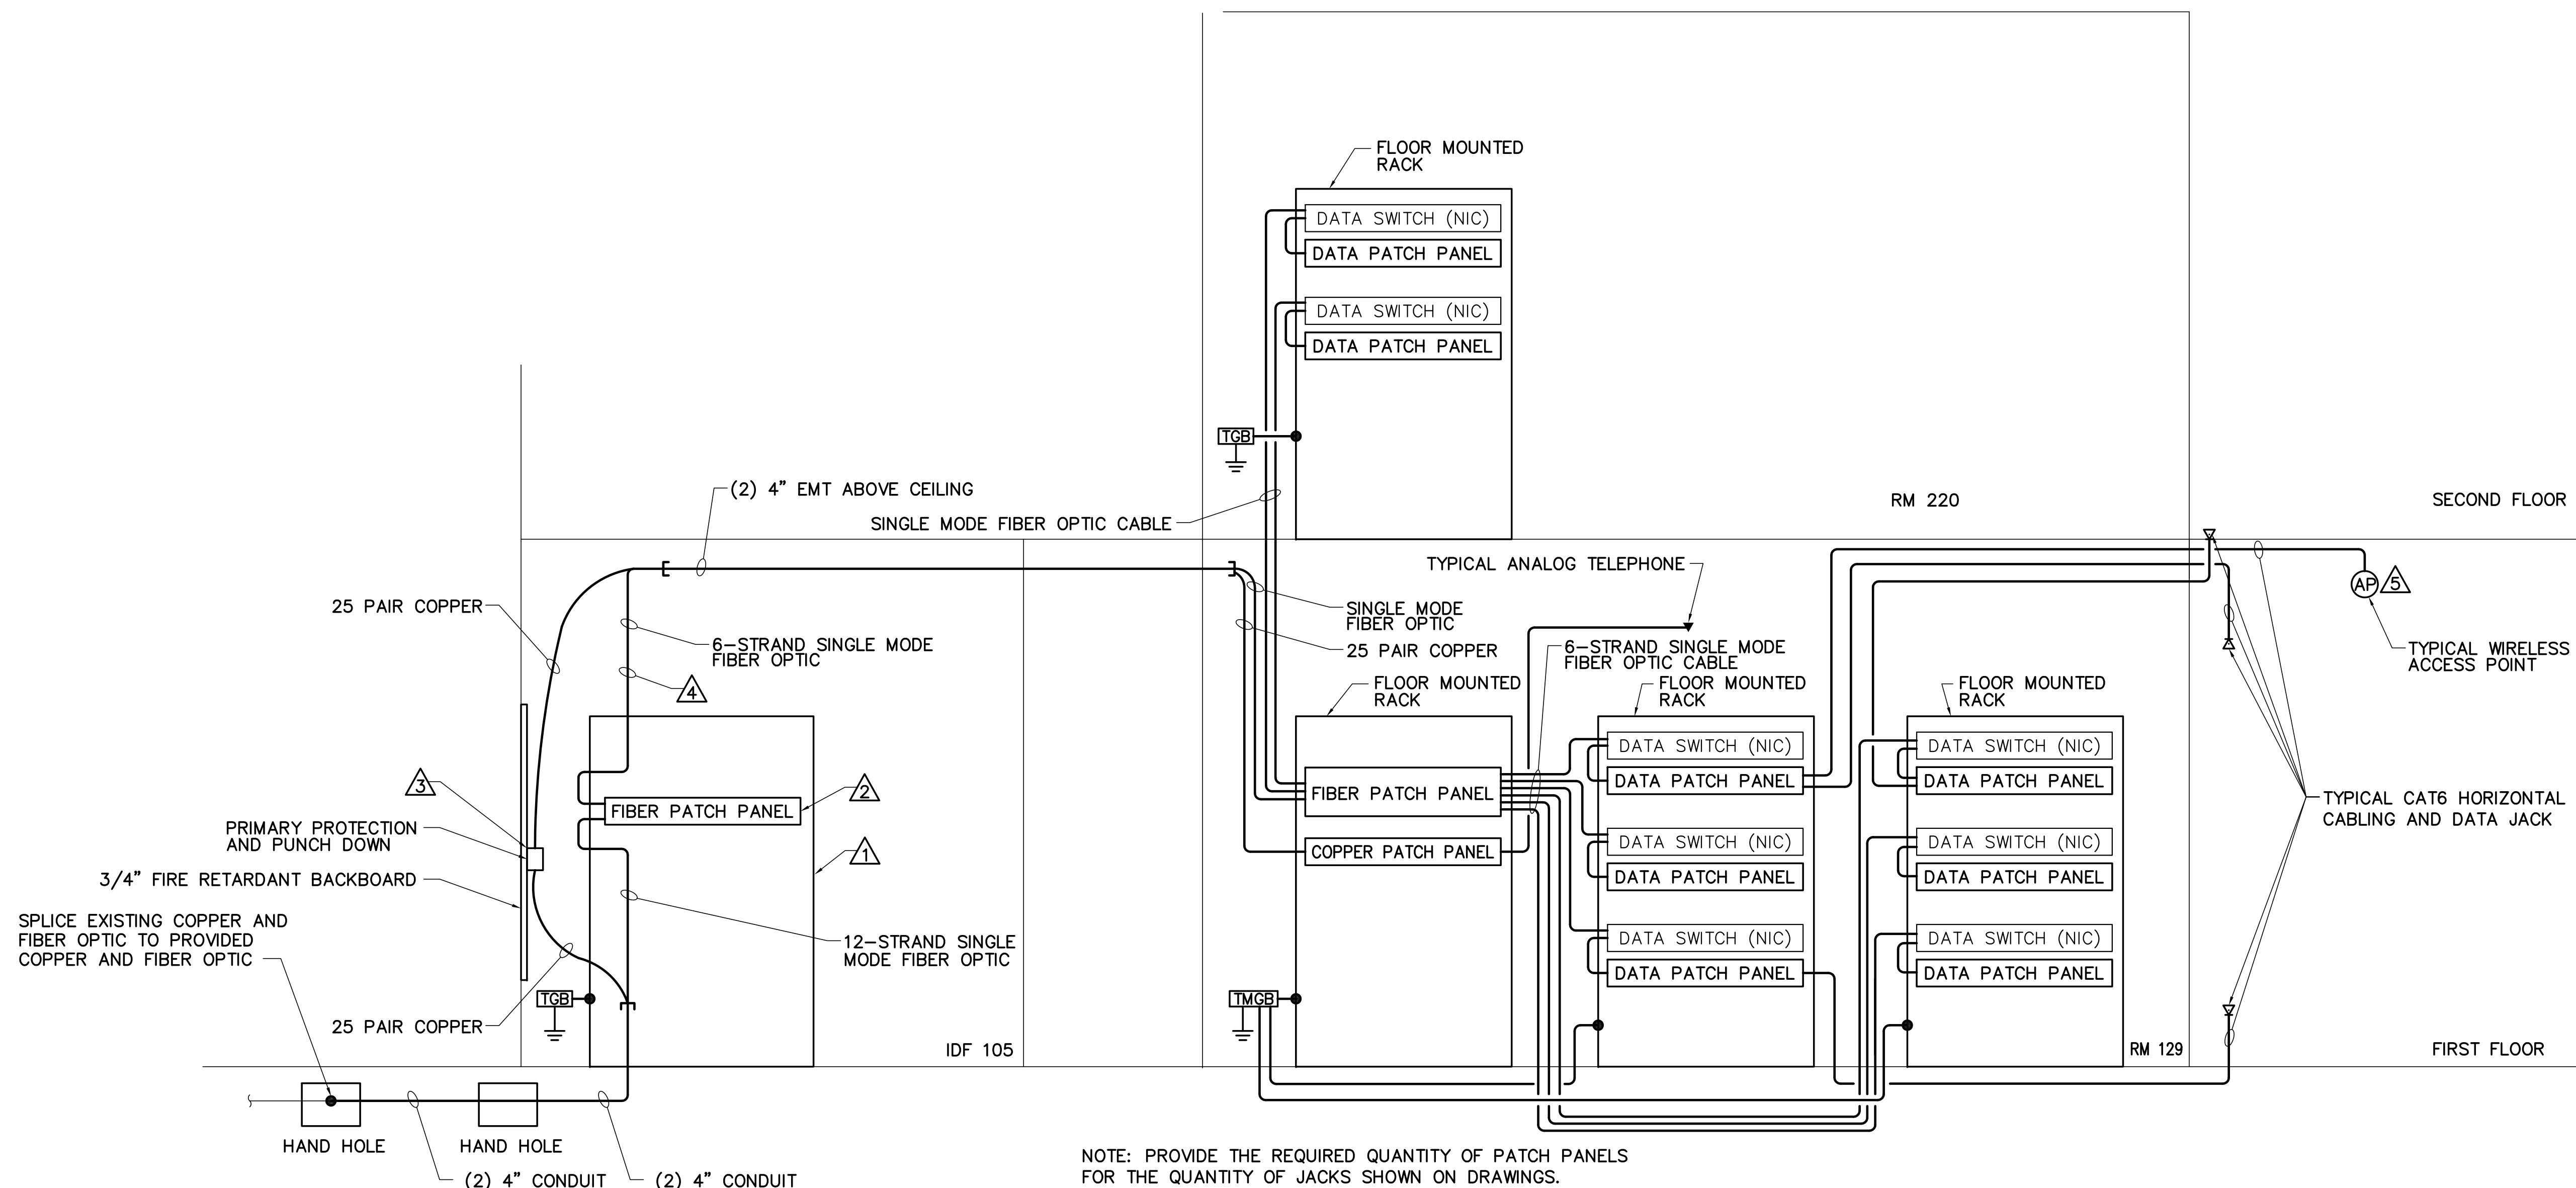

2 COMMUNICATIONS ONE-LINE DIAGRAM
ET501 NOT TO SCALE

