
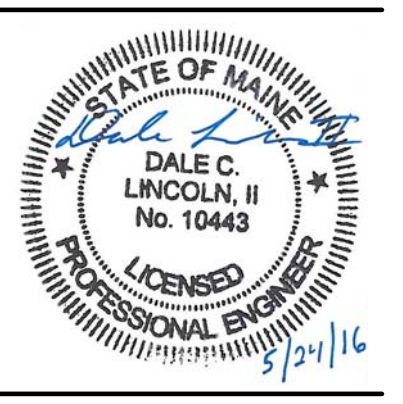
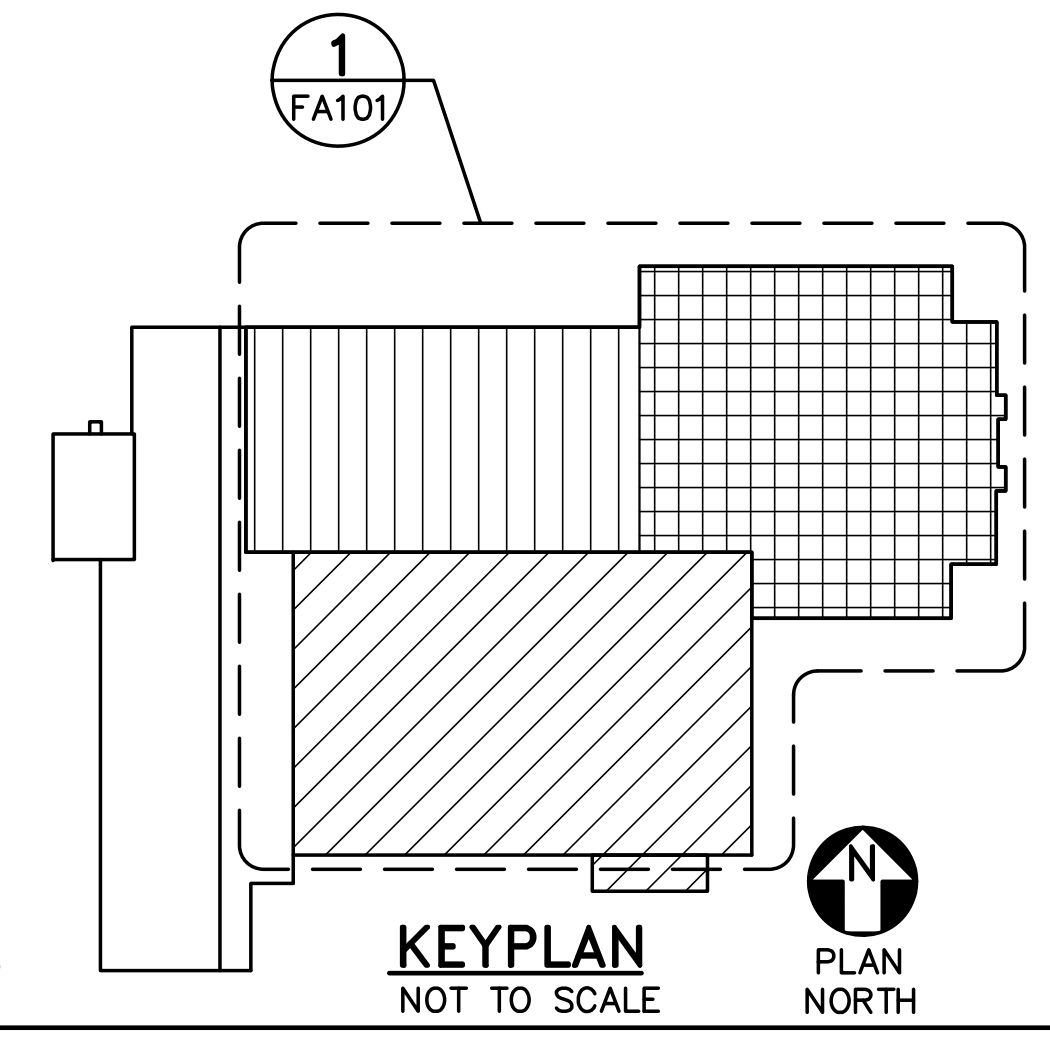


1 FIRST FLOOR FIRE ALARM PLAN
 FA101 SCALE: 1/8"=1'-0"

DRAWING KEYNOTE
 ▲ FOR ELEVATOR RECALL.

DRAWING NOTE
 1. REFER TO SHEET E-001 FOR SYMBOLS, GENERAL NOTES AND ABBREVIATIONS.

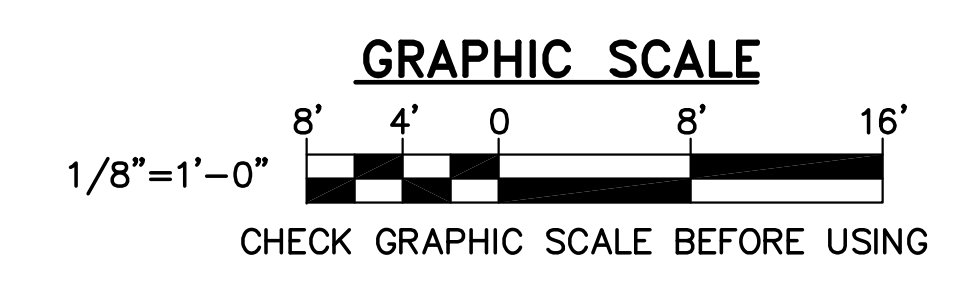

DESIGNED BY: KAO
 DRAWN BY: BPD
 CHECKED BY: DCL
 PROJECT: 21602.10

**UNIVERSITY OF NEW ENGLAND
 PORTLAND CAMPUS**
 STEVEN AVENUE ARMORY
 716 STEVEN AVENUE
 PORTLAND, MAINE 04103
 (1207)285-0171

**RENOVATIONS TO THE
 STEVEN AVENUE ARMORY**

**FIRST FLOOR
 FIRE ALARM
 PLAN**

SCALE: AS NOTED
 DATE: 05-24-16

DWG. **FA101**

SHEET: 166 OF 169