

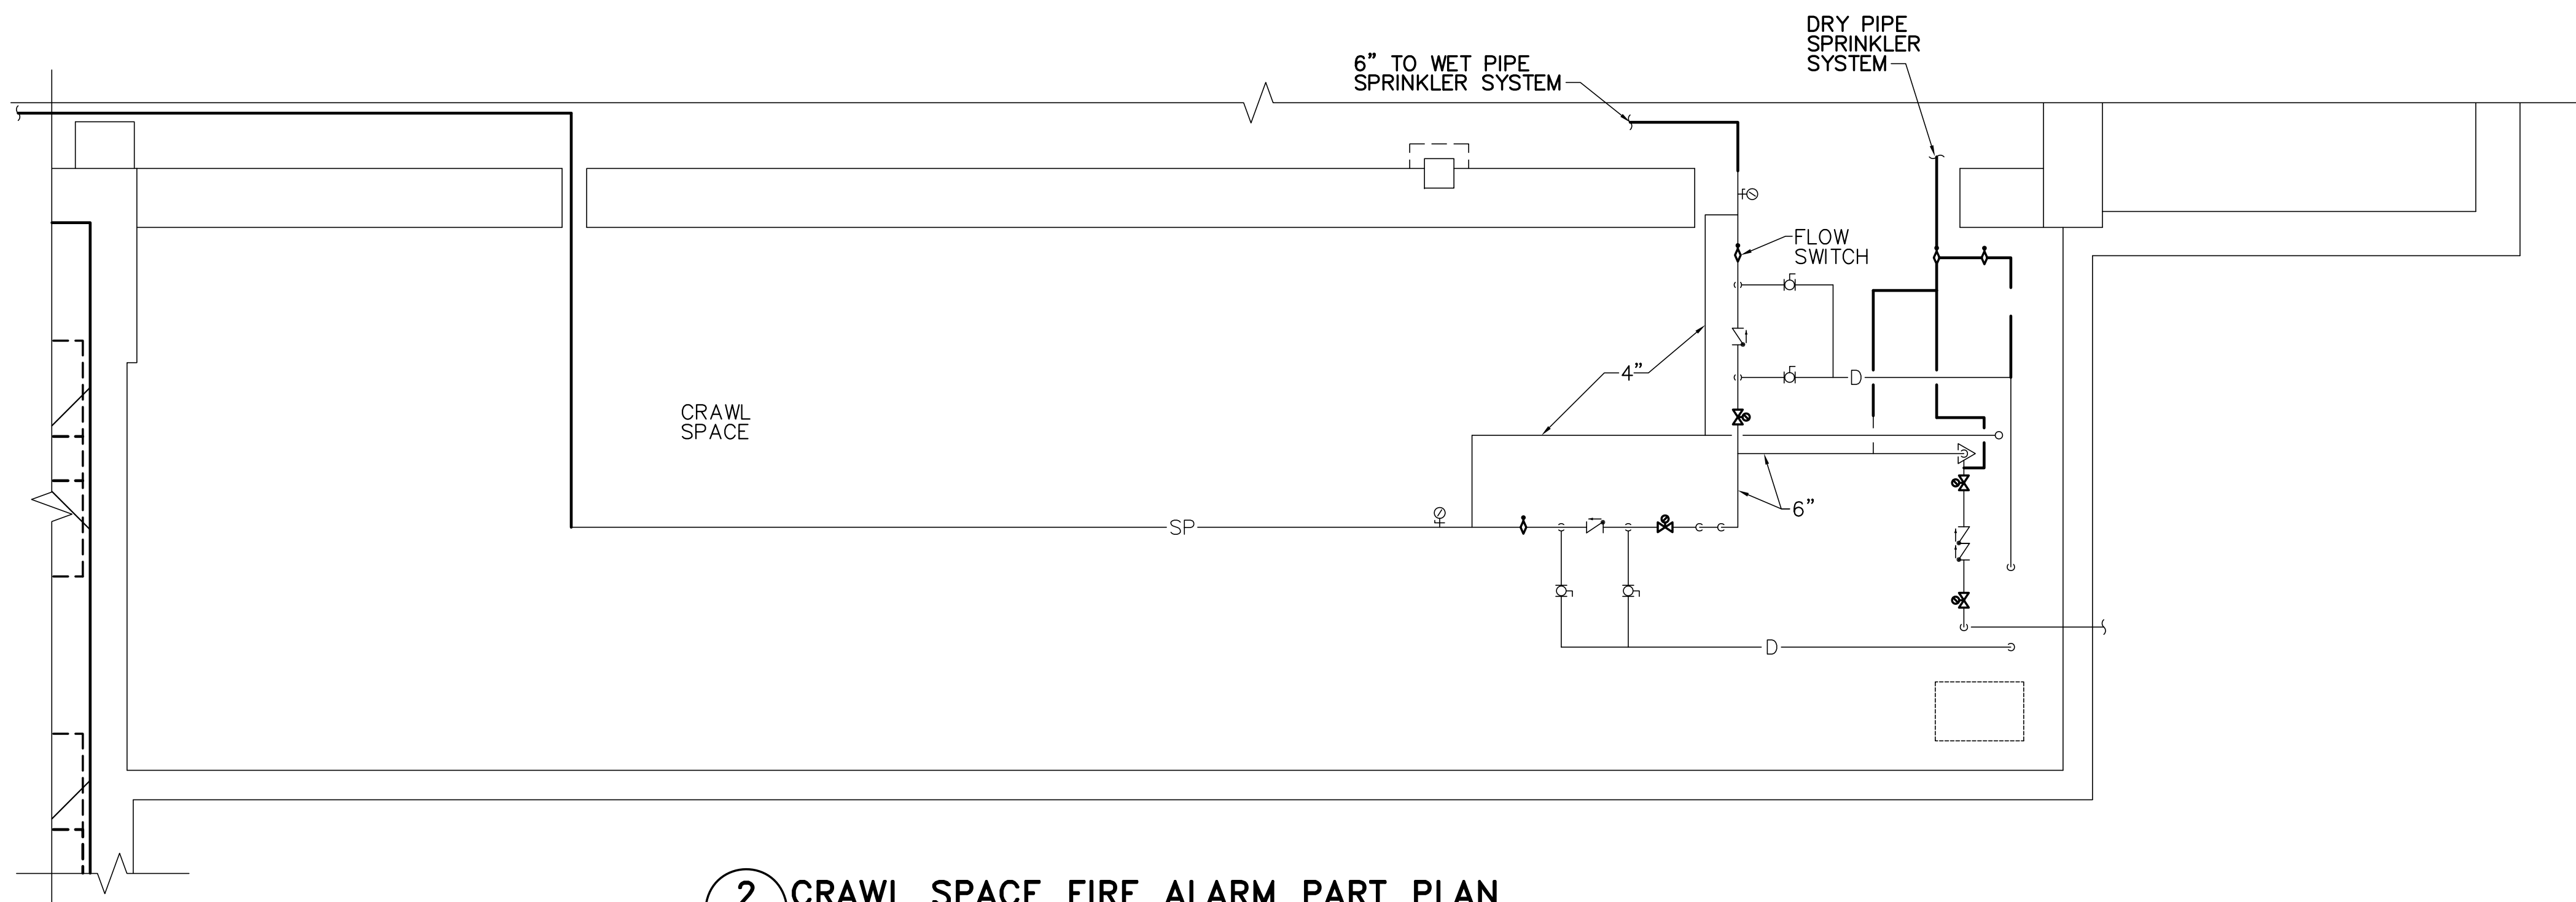


**1 FIRST FLOOR FIRE ALARM PLAN**  
FA102 SCALE: 1/8"=1'-0"

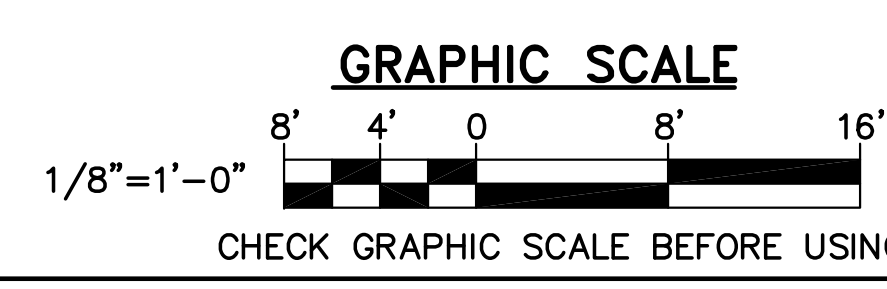

**2 CRAWL SPACE FIRE ALARM PART PLAN**  
FA102 SCALE: 1/8"=1'-0"

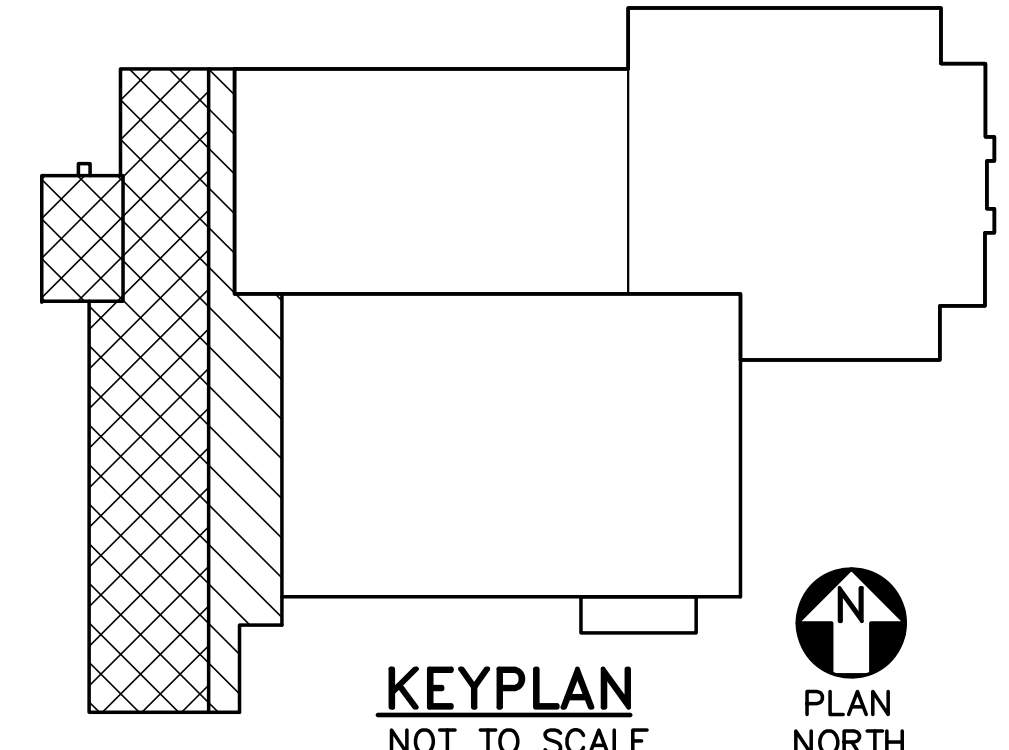


**DRAWING NOTES**

1. FIRE ALARM SYSTEM WITHIN THE NATIONAL GUARD SPACE SHALL REMAIN OPERATIONAL DURING CONSTRUCTION. EXISTING DEVICES SHALL BE TIED INTO THE PROPOSED FIRE ALARM SYSTEM.
2. REFER TO SHEET E-001 FOR SYMBOLS, GENERAL NOTES, AND ABBREVIATIONS.

**DRAWING KEYNOTE**

CONNECT TO FACP IN ROOM 128.

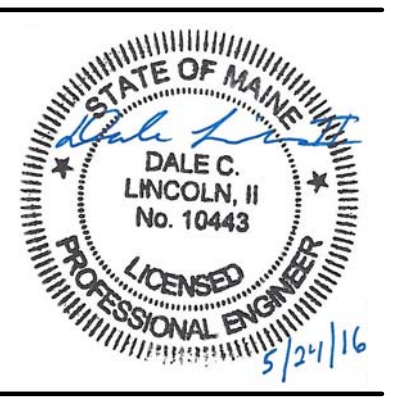

DESIGNED BY: KAO  
DRAWN BY: RSW  
CHECKED BY: DCL  
PROJECT: 21502.10

**UNIVERSITY OF NEW ENGLAND  
PORTLAND CAMPUS**  
STEVEN AVENUE ARMORY  
718 STEVENS AVE  
PORTLAND, MAINE 04103  
(1) 207 283-0171

**RENOVATIONS TO THE  
STEVEN AVENUE ARMORY**

**FIRST FLOOR  
AND CRAWL  
SPACE FIRE  
ALARM PLANS**

SCALE: AS NOTED  
DATE: 05-24-16

DWG. **FA102**

SHEET: 167 OF 169