

DESIGNED BY: MSA
 DRAWN BY: KLG
 CHECKED BY: CAL
 PROJECT: 21502.10

UNIVERSITY OF NEW ENGLAND
 PORTLAND CAMPUS
 STEVEN AVENUE ARMORY
 716 STEVENS AVE
 PORTLAND, MAINE 04103
 T (207)283-0171

RENOVATIONS TO THE
 STEVENS AVENUE ARMORY

SECOND FLOOR
 FIRE
 SUPPRESSION
 REMOVALS
 PART PLAN

SCALE: AS NOTED
 DATE: 05-24-16

DWG. **FD103**


SHEET: 107 of 169

DRAWING NOTES

- REFER TO GENERAL NOTES ON FX001 FOR SYSTEM REQUIREMENTS.
- SPRINKLER SYSTEM LAYOUT IS TAKEN FROM RECORD DRAWINGS, 2010. PIPING WAS NOT FIELD VERIFIED.
- REMOVALS TO INCLUDE PIPE, HEADS, HANGERS AND SUPPORTS.

DRAWING KEYNOTE

REMOVE SPRINKLER PIPING, HANGERS AND ACCESSORIES IN THIS AREA. VERIFY IN FIELD PINNING ARRANGEMENT. SPACE WAS INACCESSIBLE AT TIME OF FIELD VERIFICATION.

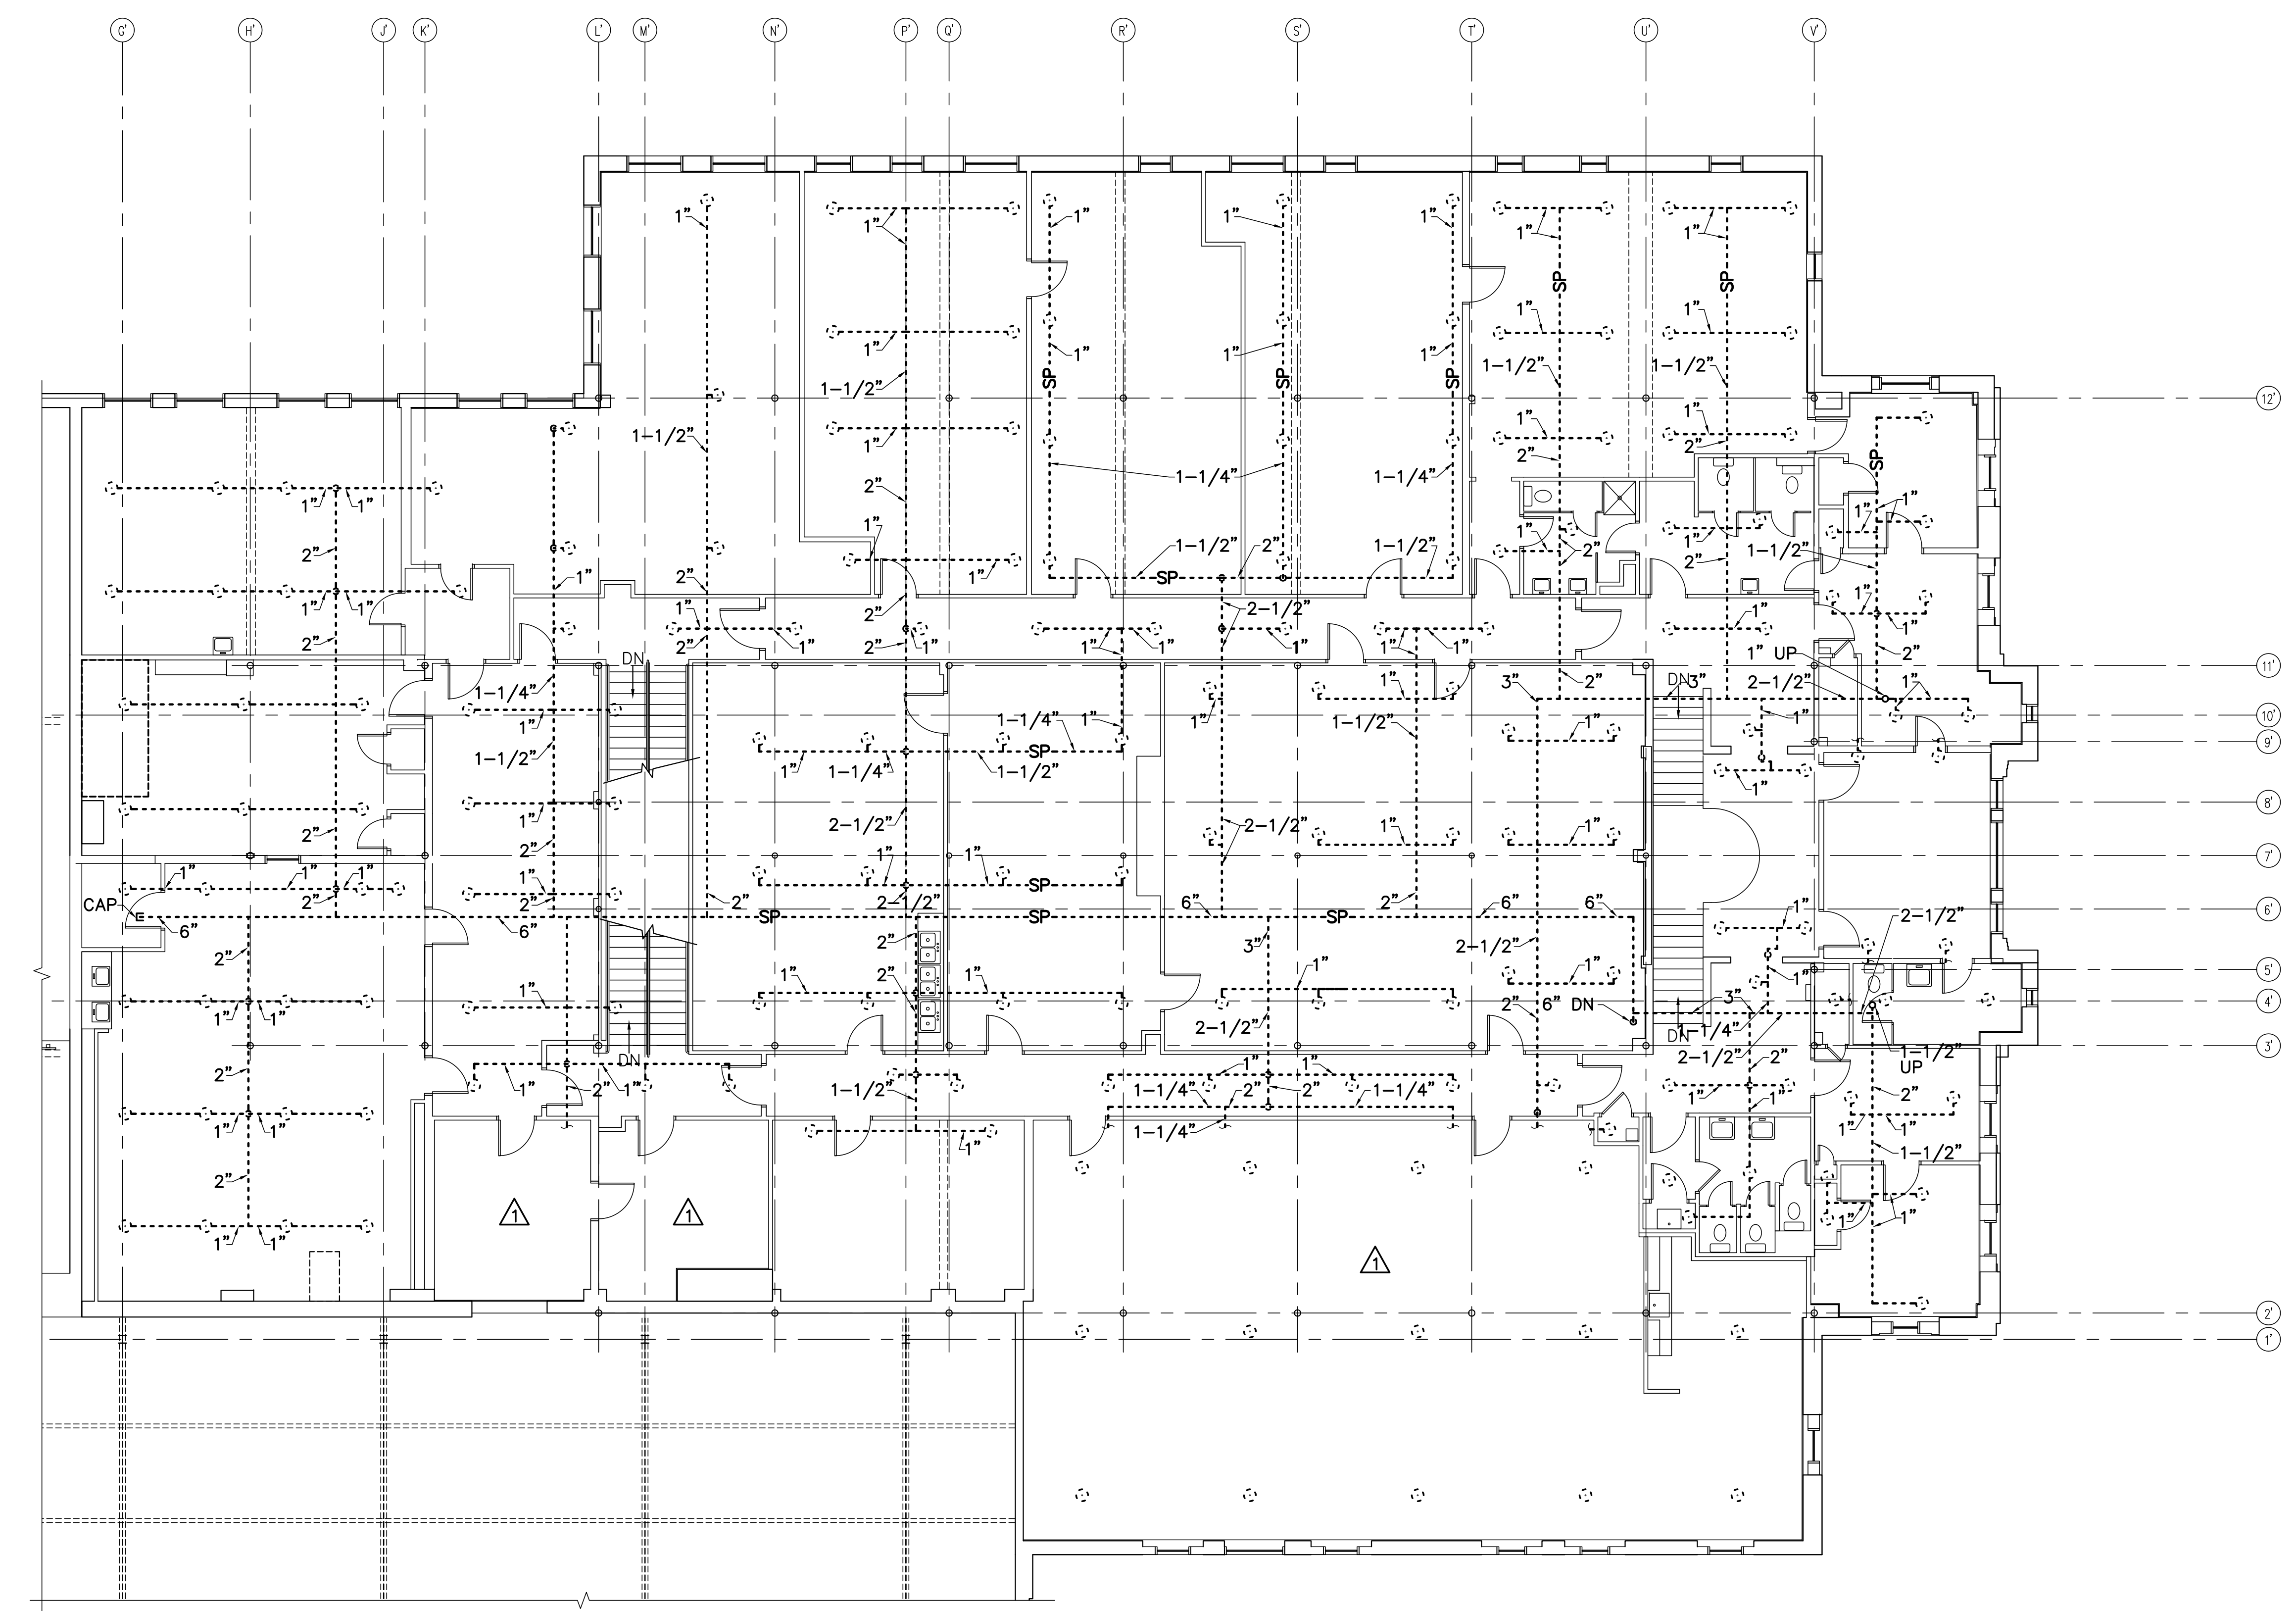

1 SECOND FLOOR FIRE SUPPRESSION REMOVALS PART PLAN
 FD103 SCALE: 1/8"=1'-0" PLAN NORTH

