

DESIGNED BY: SMC  
 DRAWN BY: KLG  
 CHECKED BY: MSA  
 PROJECT: 21502.10

UNIVERSITY OF NEW ENGLAND  
 PORTLAND CAMPUS  
 STEVEN AVENUE ARMORY  
 716 STEVENS AVE  
 PORTLAND, MAINE 04103  
 T (207) 263-0171


RENOVATIONS TO THE  
 STEVENS AVENUE ARMORY

SANITARY RISER DIAGRAM

SCALE: AS NOTED  
 DATE: 05-24-16

DWG. P-701

SHEET: 120 OF 169

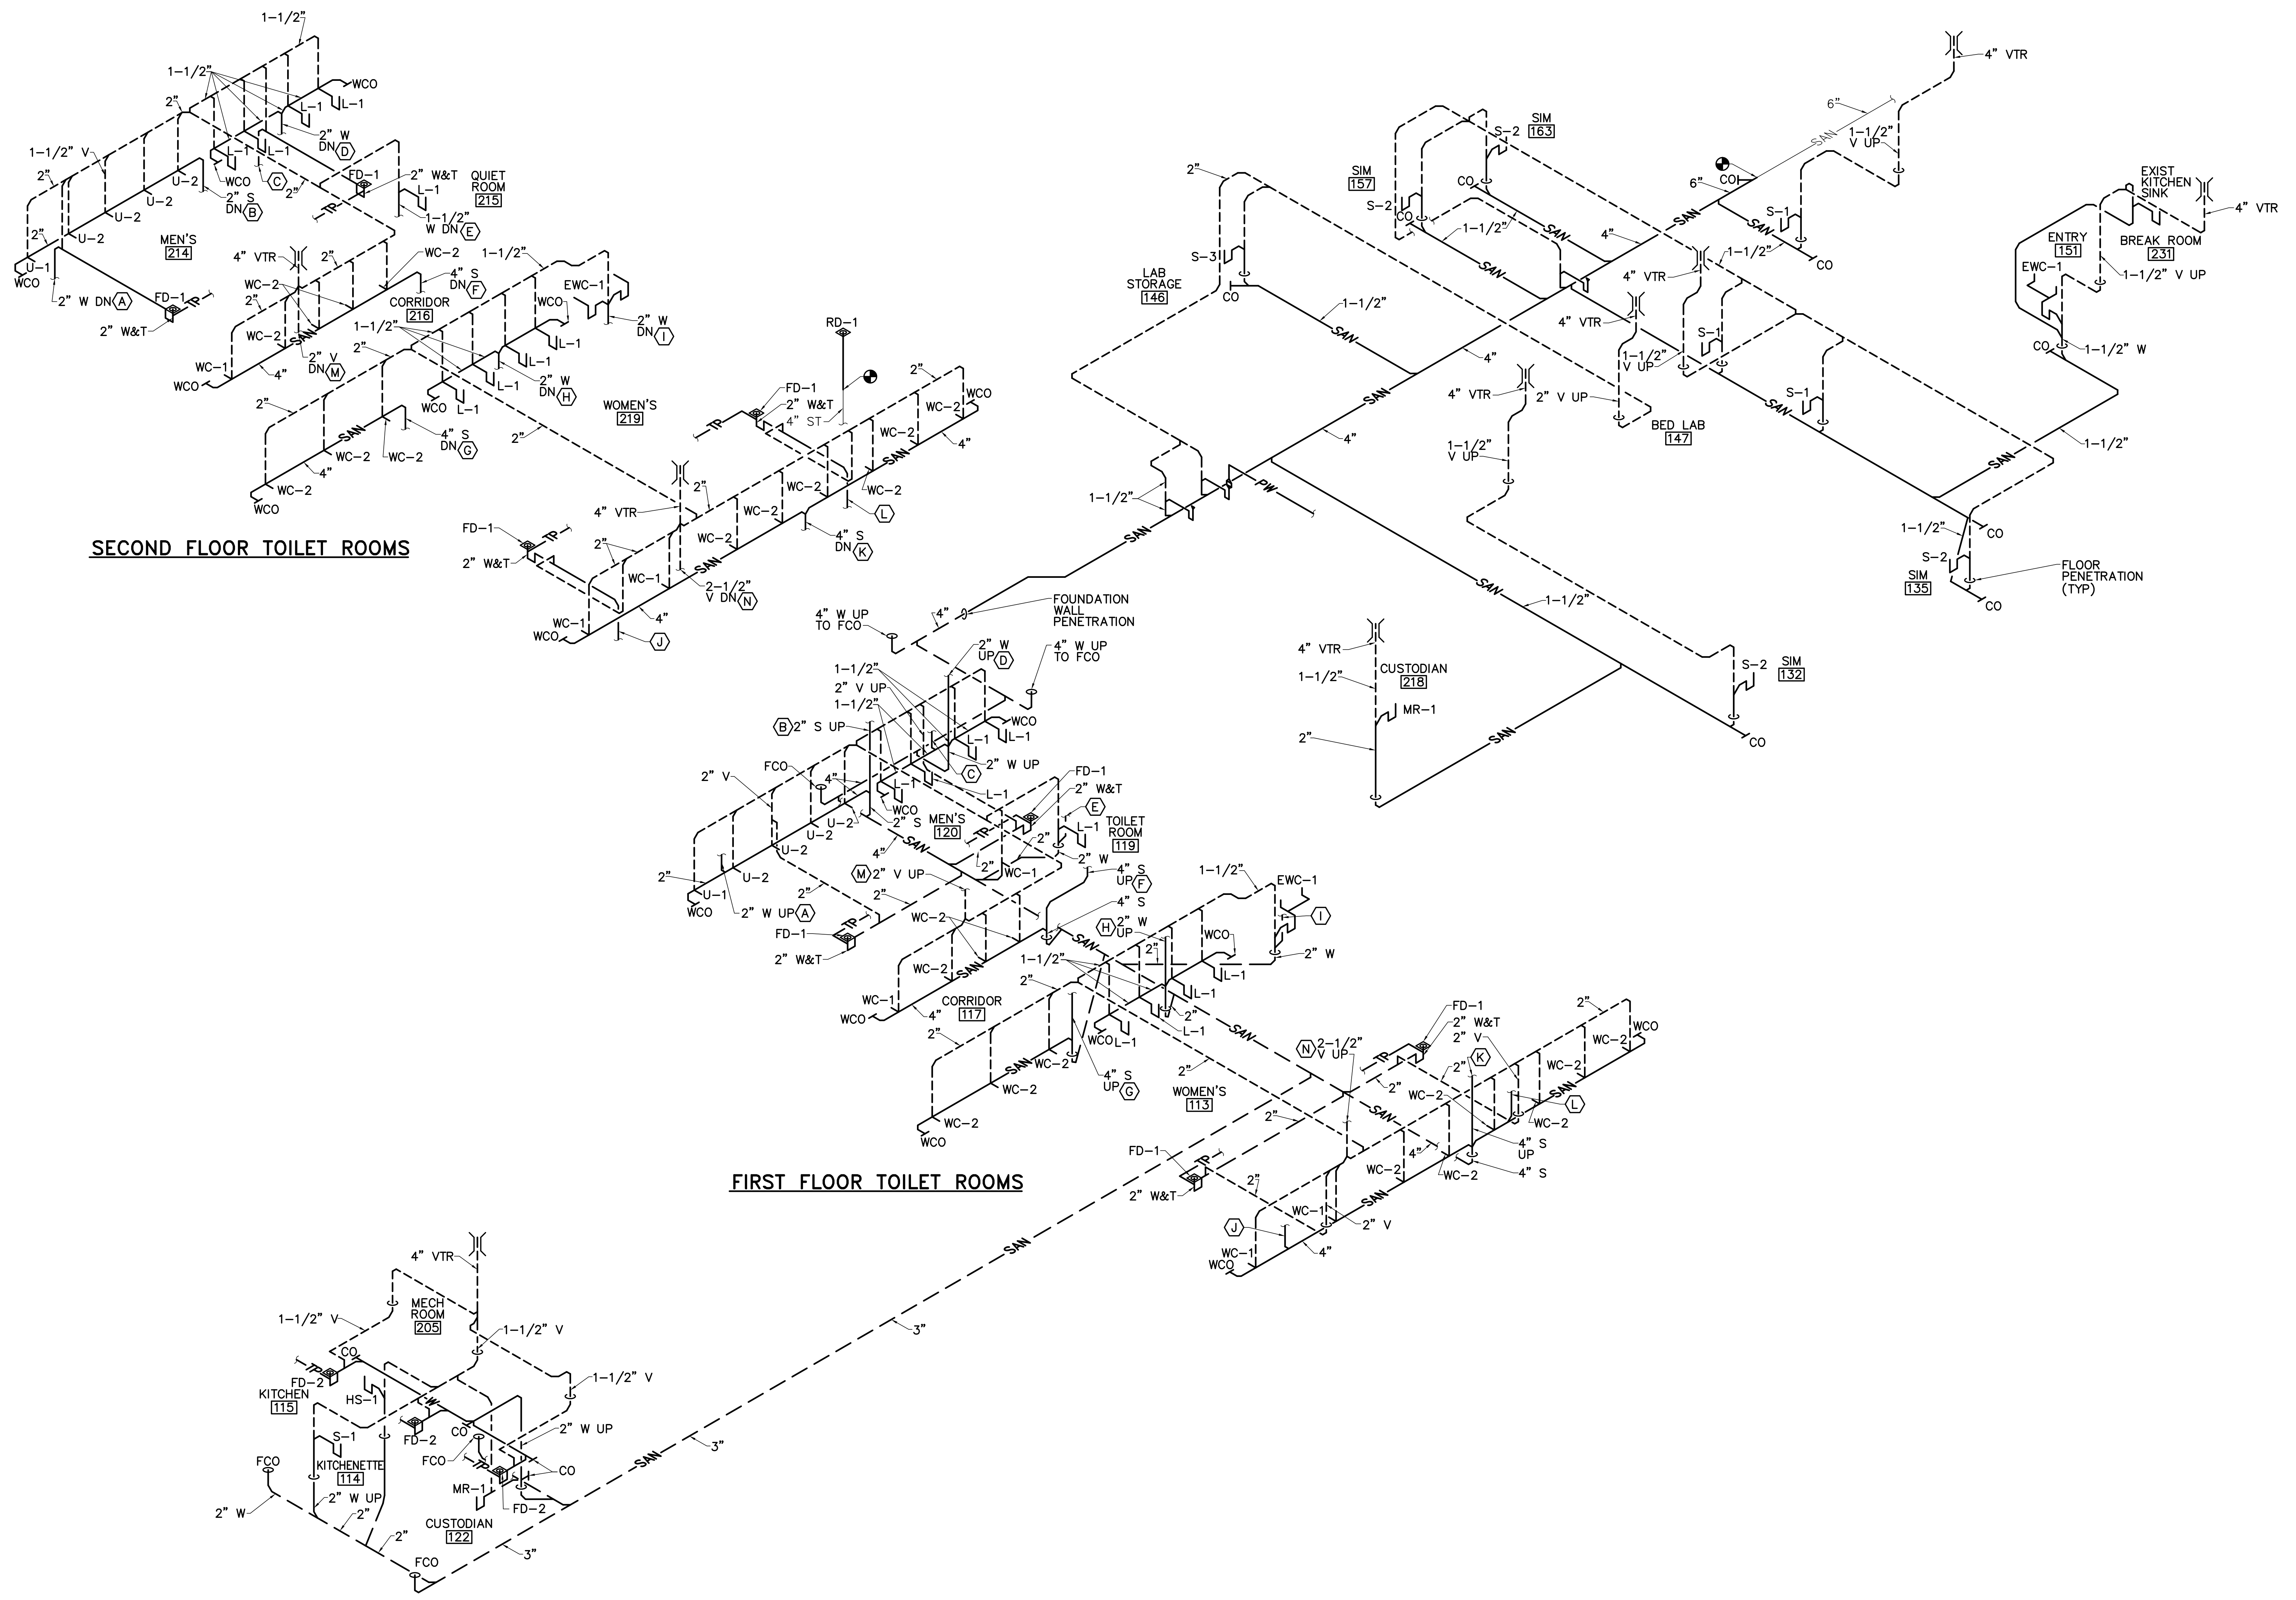

1 SANITARY RISER DIAGRAM  
 P-701 NOT TO SCALE