


FIN. FLOOR ELEVATIONS		
FLOOR LEVEL	ARCHITECT	CIVIL
BASEMENT	89'-0"	119'-0"
FIRST	100'-0"	130'-0"
SECOND	115'-6"	145'-6"
ROOF	130'-0"	160'-0"

\*ALL INVERTS BASED ON ARCHITECT ELEVATIONS.

IF THIS SHEET IS NOT 24 X 36 IT IS A REDUCED SCALE PRINT - SCALE ACCORDINGLY

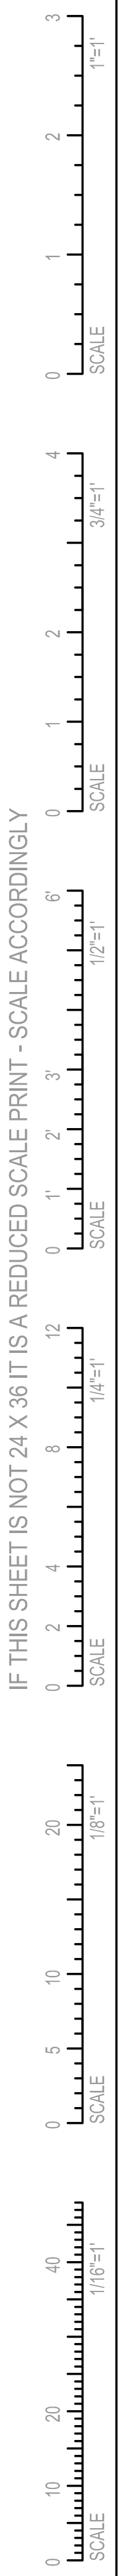

② PLUMBING FIRST FLOOR "B" PLAN  
3/16" = 1'-0"


- NOTES:**
- 1) 1/2" CW&HW, 2" BOW VENT AND 2" WASTE STUB UP, CAP 2'-0" ABOVE FINISHED FLOOR FOR FUTURE ADD ALTERNATE. REFER TO DRAWING P102C FOR CONTINUATION.
  - 2) 2" BOW VENT STUB UP, CAP 2'-0" ABOVE FINISHED FLOOR FOR FUTURE ADD ALTERNATE. REFER TO DRAWING P102C FOR CONTINUATION.
  - 3) 1/2" CW&HW AND 2" BOW VENT STUB UP, CAP PIPING ABOVE CEILING FOR FUTURE ADD ALTERNATE. REFER TO DRAWING P102C FOR CONTINUATION.
  - 4) 1/2" CW&HW STUB UP, CAP PIPING ABOVE CEILING FOR FUTURE ADD ALTERNATE. REFER TO DRAWING P102C FOR CONTINUATION.



**PORT CITY ARCHITECTURE**  
65 NEWBURY STREET  
PORTLAND, ME 04101  
207.761.9000  
info@portcityarch.com  
WWW.PORTCITYARCH.COM

CONSULTANTS

- BECKER**
- Vincent A. Dilorio Inc.**
- ED HE**
- Site Design Associates**  
23 Whitney Way  
Topsham, Maine 04086  
207-449-4275

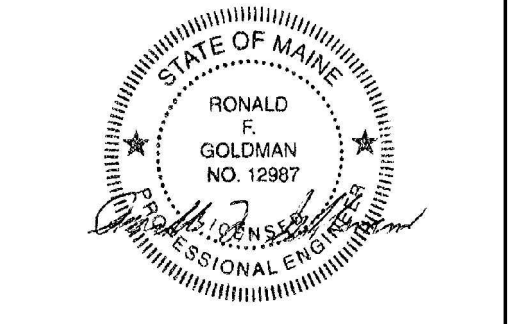

REVISIONS

No.	Description	Date
▲	Add Alternate #1	2/08/13
▲	First Floor Redesign	1/09/13
▲	Addendum #9	8/16/12
▲	Addendum #8	7/30/12

PERMIT DOCUMENTS

**UNIVERSITY OF NEW ENGLAND**  
PORTLAND, MAINE

**PATIENT CARE CENTER**  
COMP CARE FIT-OUT  
PLUMBING  
FIRST FLOOR PLAN "B"  
PLAN

Project Number	12533.00
Date	April 26, 2013
Drawn by	SCW
Checked by	SPQ

**P1.02B**  
Scale AS NOTED