




IF THIS SHEET IS NOT 24 X 36 IT IS A REDUCED SCALE PRINT - SCALE ACCORDINGLY

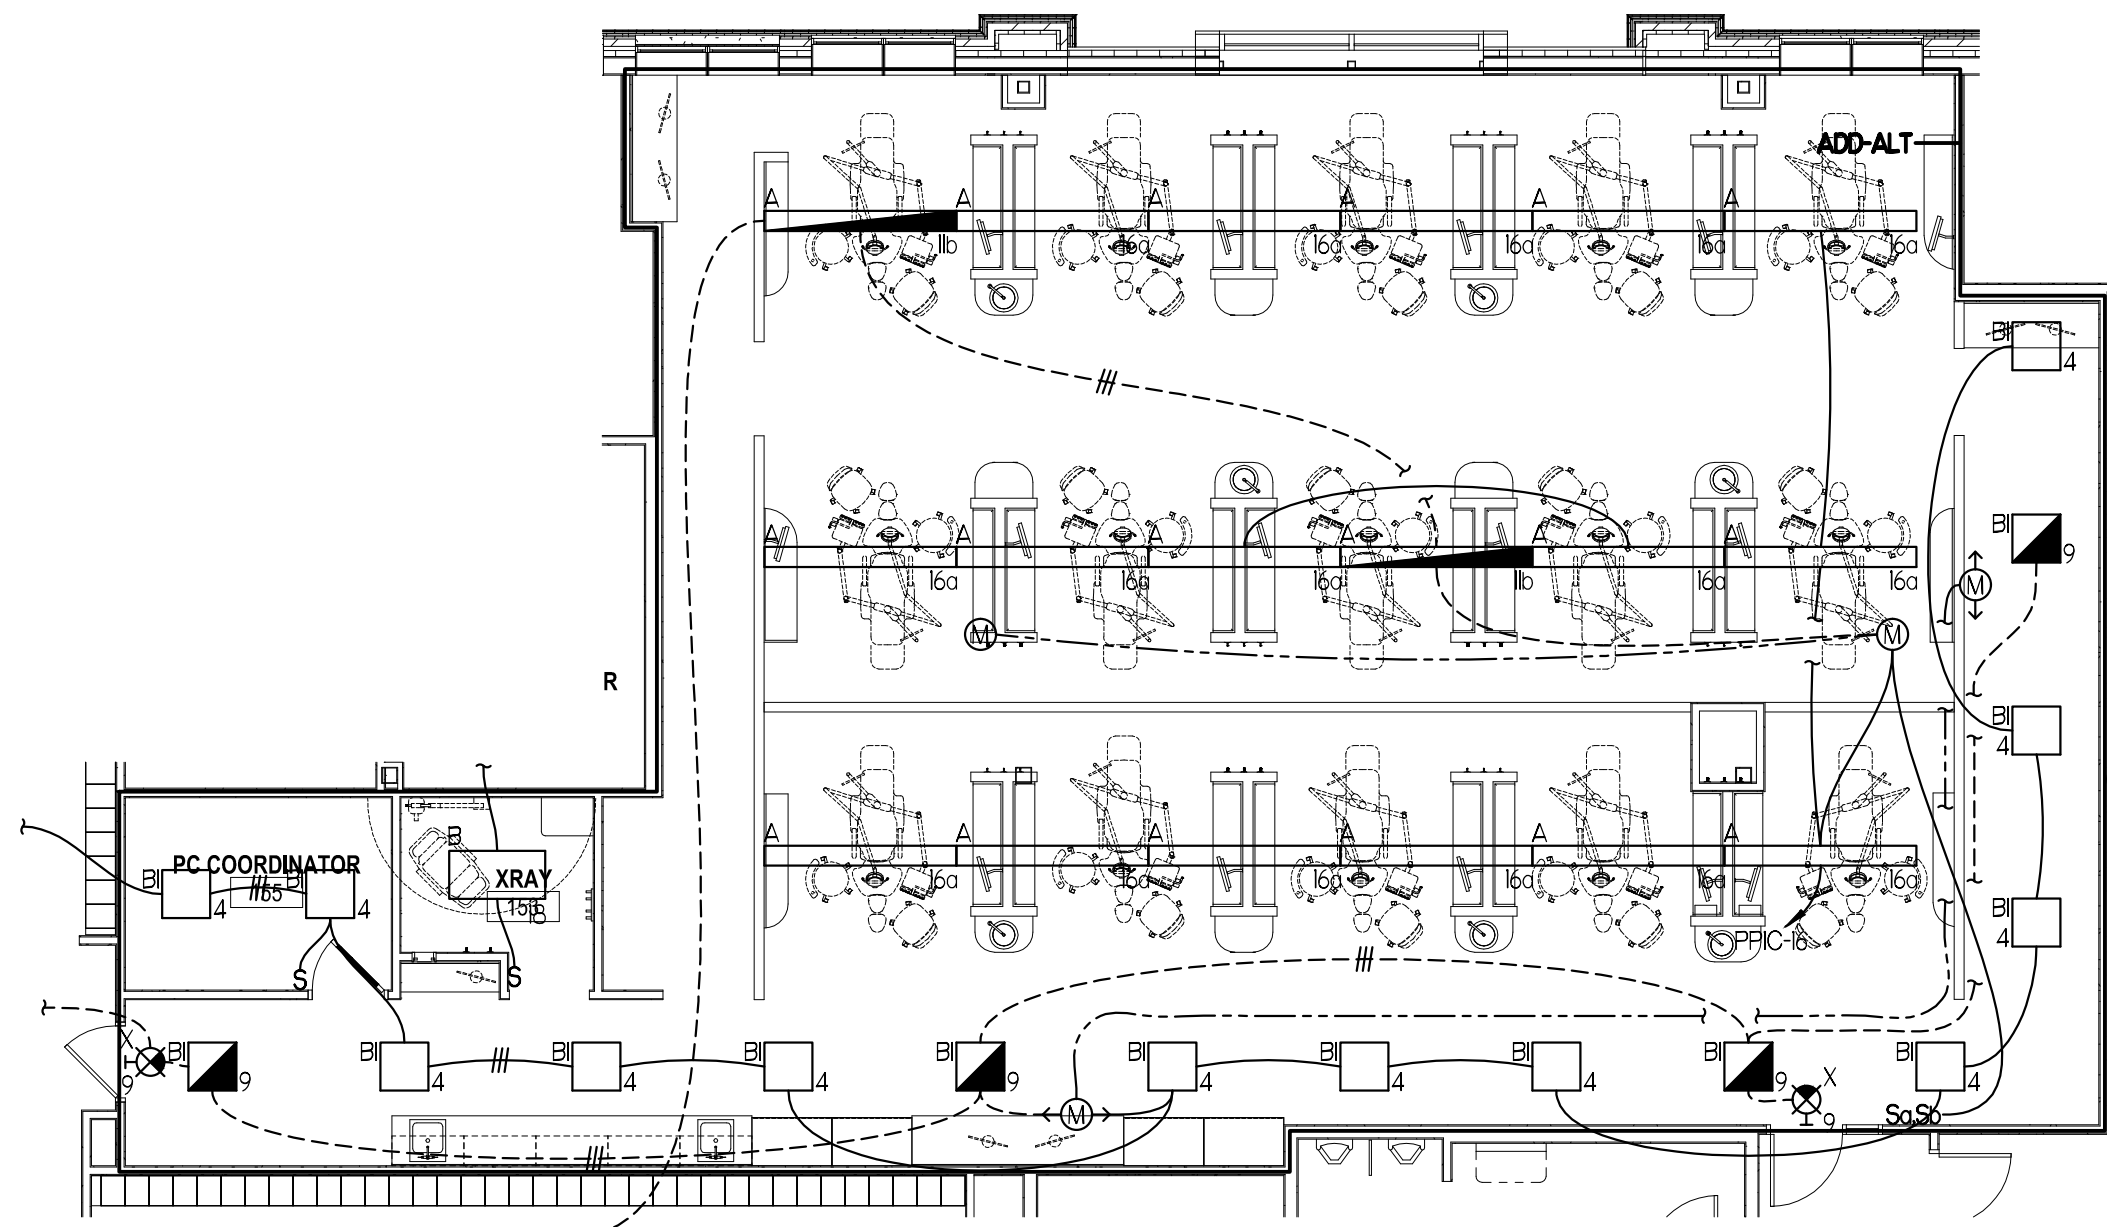

ADD ALTERNATE
COMP CARE I PART PLAN
SCALE: 1/8"=1'-0"

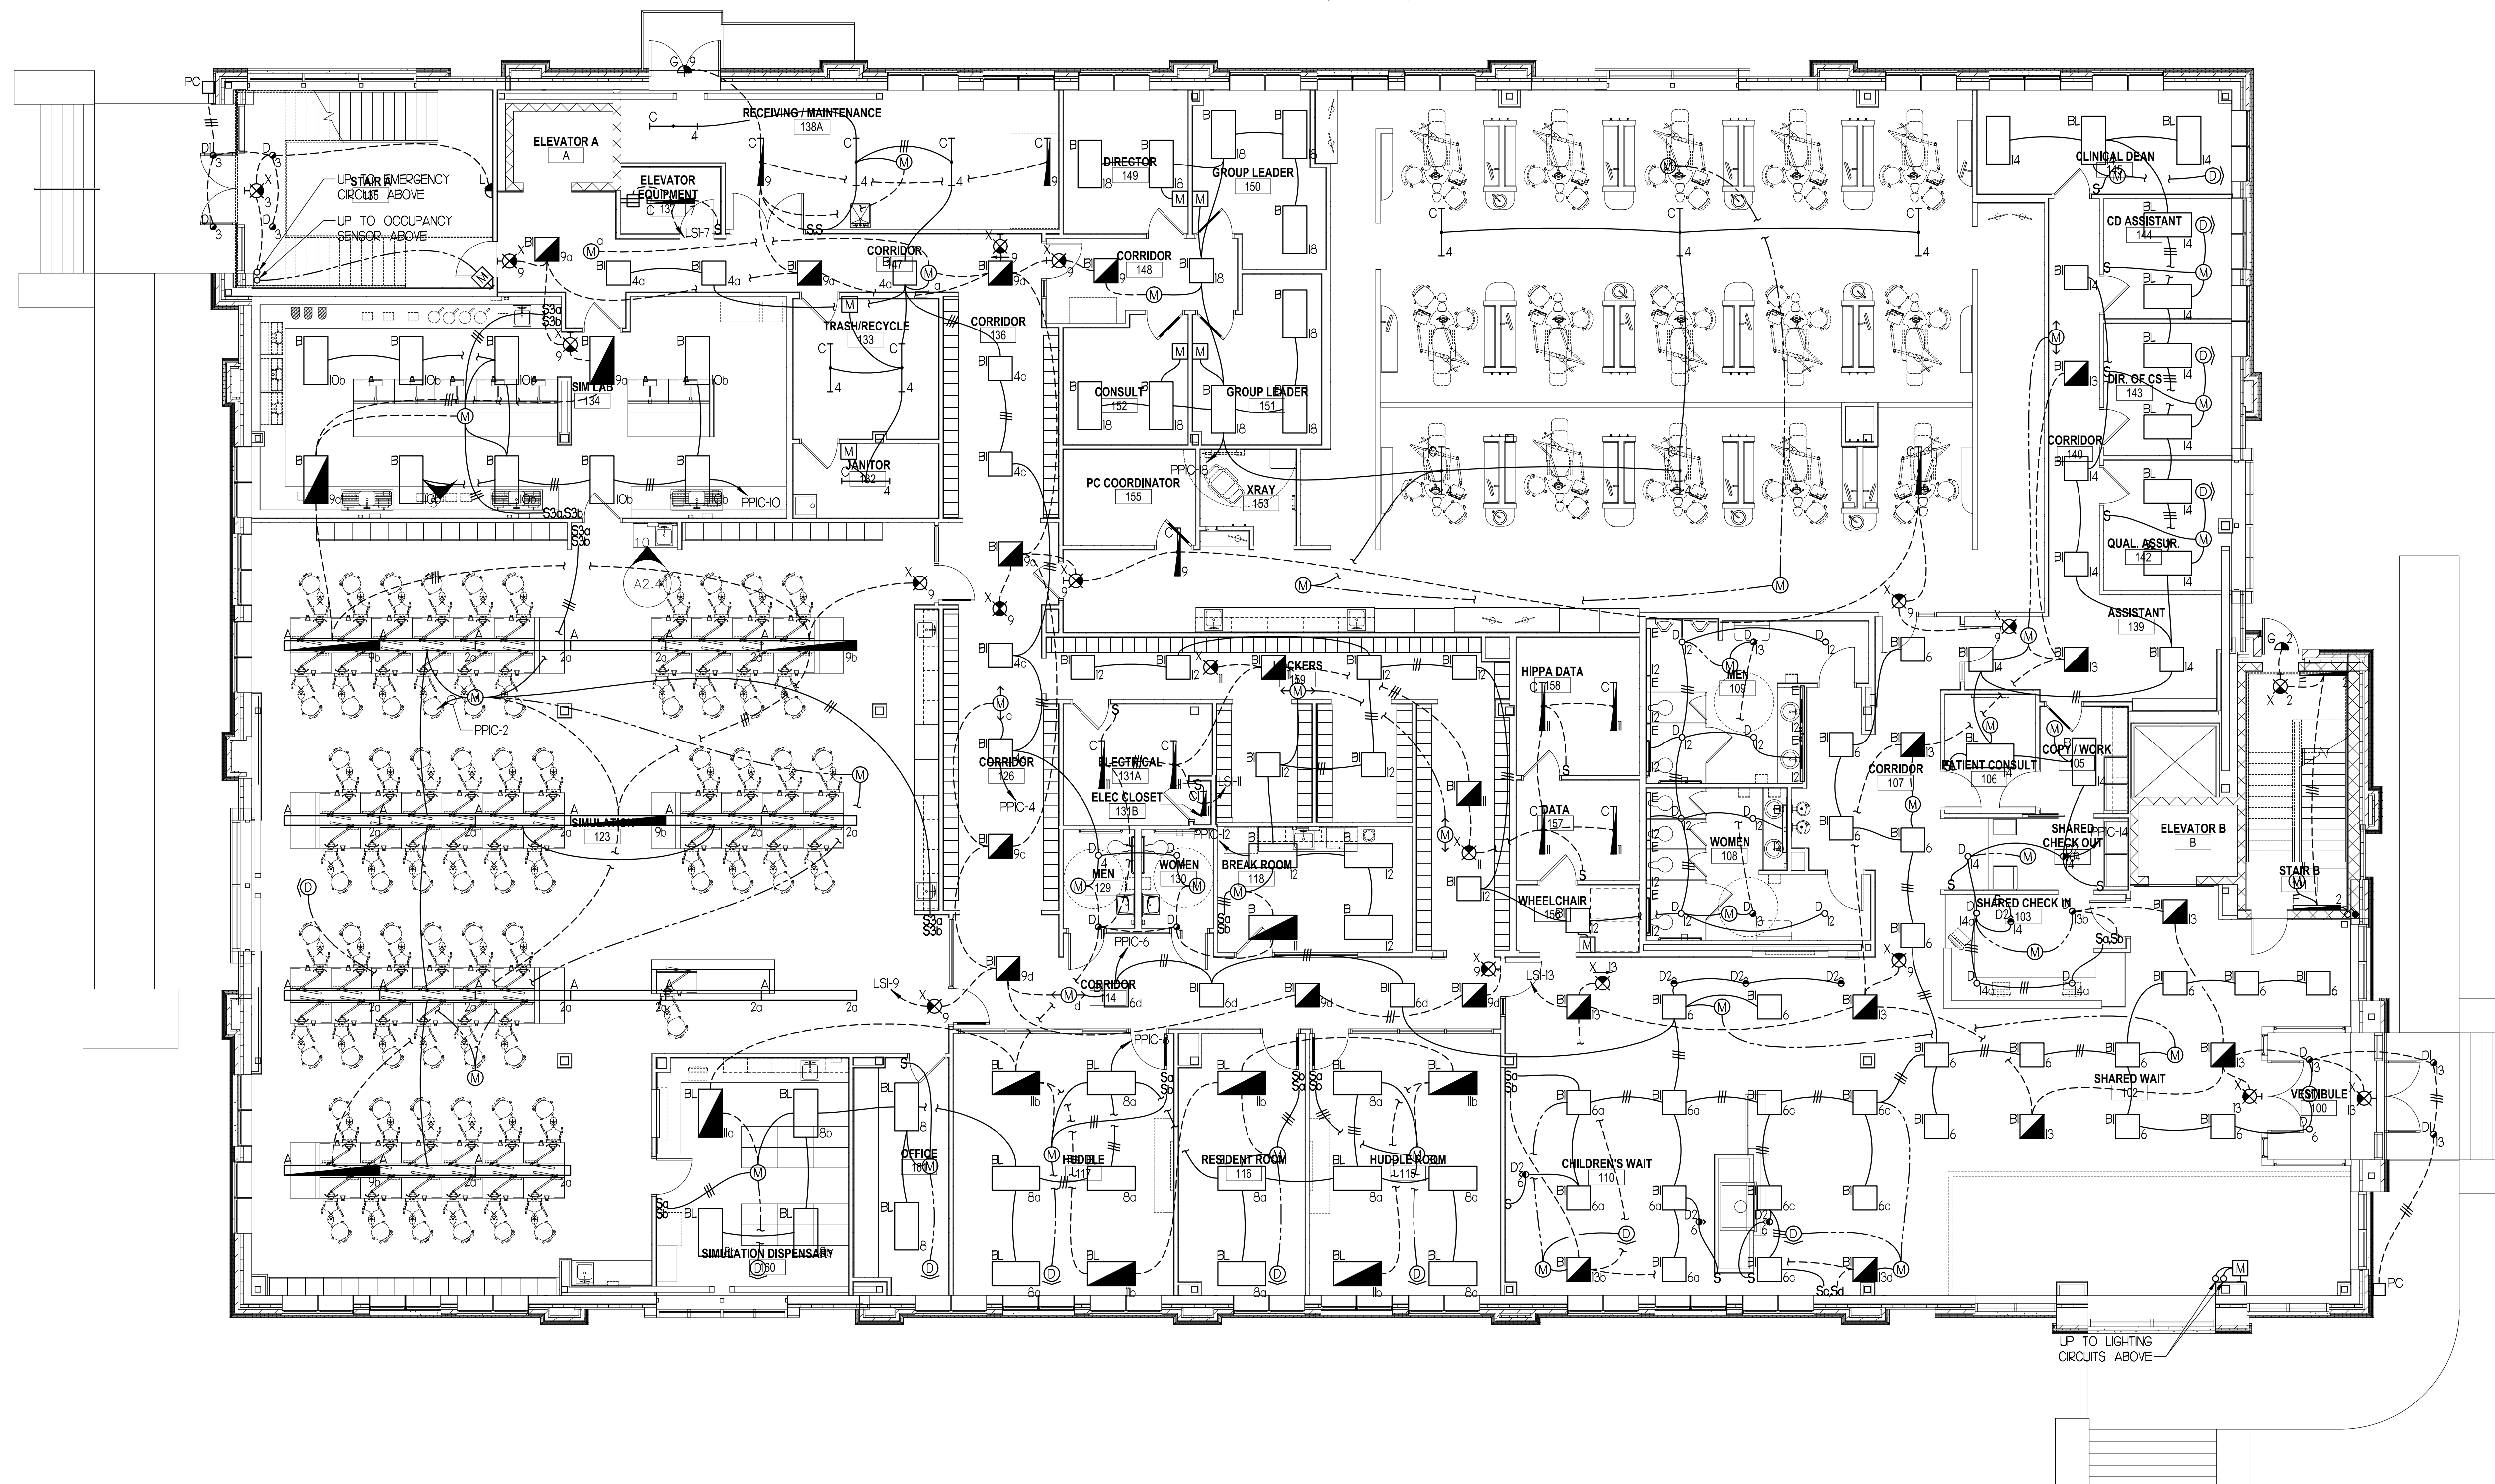

PORT CITY ARCHITECTURE
65 NEWBURY STREET
PORTLAND, ME 04101
207.761.9000
info@portcityarch.com
WWW.PORTCITYARCH.COM

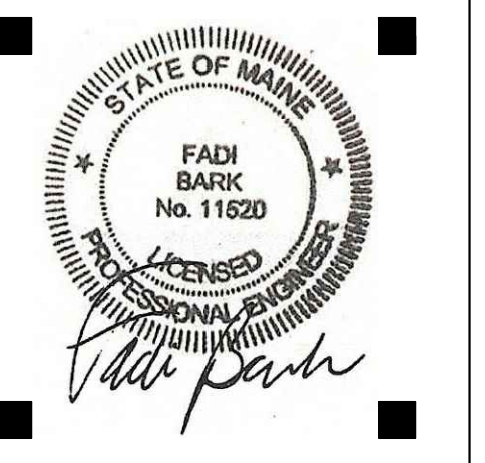

CONSULTANTS
Kahler Slater
experience design



Site Design Associates
23 Whitney Way
Topsham, Maine 04086
207-449-4275

No.	Description	Date
▲	Add Alternate #1	2/08/13
▲	First Floor Redesign	1/09/13
▲	Addendum #9	8/16/12
▲	Addendum #8	7/30/12

PERMIT DOCUMENTS

UNIVERSITY OF
NEW ENGLAND
PORTLAND, MAINE

PATIENT CARE
CENTER
COMP CARE FIT-OUT

FIRST FLOOR
LIGHTING PLAN

Project Number 12533.00
Date April 26, 2013
Drawn by CDO
Checked by VADjr

E1.02
Scale 1/8"=1'-0"