

8/23/2017 12:14:51 PM P:\Restaurant\Starbucks\NICH17-0130 - Starbucks - Portland - 1080 Forest Ave - Permit set.rvt

| SITE SCHEDULE - "Y" | | | | | |
|---------------------|-------|--|---------|---------|--|
| DESIGN ID | COUNT | DESCRIPTION | FURNISH | INSTALL | COMMENTS |
| EXTERIOR MENU | | | | | |
| 14087 | 1 | MENU BOARD - DT DIGITAL ORDER SCREEN WALL MOUNT HARDWARE - FLAT BLACK MT0028 | VD | VD | DSA PHOTOTECH. PROVIDED & INSTALLED BY SIGNAGE VENDOR. |
| 14114 | 1 | MENU BOARD - DT 3 PANEL WALL MOUNTED - 72X48IN 1830X1220MM - FLAT BLACK MT0028 | VD | VD | DSA PHOTOTECH. PROVIDED & INSTALLED BY SIGNAGE VENDOR. |
| 14116 | 1 | MENU BOARD - DT DIGITAL ORDER SCREEN - FLAT BLACK MT0028 | VD | VD | DSA PHOTOTECH. PROVIDED & INSTALLED BY SIGNAGE VENDOR. |
| UMBRELLA | | | | | |
| 12147 | 3 | UMBRELLA - BASE FOR CANOPY - BLACK MT0028 | VD | GC | TUUCI LLC |
| 16629 | 3 | UMBRELLA - WITHOUT VALANCE - 6FT 183CM - BLACK CANVAS F0061 | VD | GC | TUUCI LLC |

| EXTERIOR SIGNAGE SCHEDULE - "S" | | | | | |
|---------------------------------|-------|---|---------|---------|---|
| DESIGN ID | COUNT | DESCRIPTION | FURNISH | INSTALL | COMMENTS |
| SIGNAGE - DRIVE THRU | | | | | |
| 14091 | 1 | SIGN - DT DIRECTIONAL EXIT SIGN ILLUMINATED ARROW SERIES - 46IN 1170MM | VD | VD | HME. GC TO COORDINATE FINAL SET UP WITH STARBUCKS VENDOR. INSTALL OVER EXISTING FOOTING. |
| 14106 | 1 | SIGN - DT CLEARANCE BAR ARROW SERIES FREESTANDING | VD | VD | HME. GC TO COORDINATE FINAL SET UP WITH STARBUCKS VENDOR. INSTALL OVER EXISTING FOOTING. |
| 14327 | 1 | SIGN - DT DIRECTIONAL ILLUMINATED ARROW SERIES - 46IN 1170MM | VD | VD | HME. GC TO COORDINATE FINAL SET UP WITH STARBUCKS VENDOR. INSTALL OVER EXISTING FOOTING. |
| 14533 | 1 | SIGN - DRIVE THRU ILLUMINATED ARROW SERIES FLUSH MOUNTED - RH - 62IN 1575MM | VD | VD | HME. GC TO COORDINATE FINAL SET UP WITH STARBUCKS VENDOR. PROVIDE BLOCKING/ ELECTRICAL. |
| SIGNAGE - PYLON DISK | | | | | |
| X0001 | 2 | SIGN - PYLON DISK DRIVE THRU ILLUMINATED ARROW SERIES - 48IN 1220MM | VD | VD | HILTON. GC TO COORDINATE FINAL SET UP WITH STARBUCKS VENDOR. VENDOR TO MEASURE PANEL SIZE PRIOR TO FABRICATION AND INSTALLATION. BOTH SIDES |
| SIGNAGE - WORDMARK | | | | | |
| 13292 | 2 | SIGN - STACKED ILLUMINATED FLUSH MOUNTED - 20IN 510MM | VD | VD | HILTON. GC TO COORDINATE FINAL SET UP WITH STARBUCKS VENDOR |

| RESPONSIBILITY LEGEND | |
|-----------------------|--------------------|
| GC | GENERAL CONTRACTOR |
| LL | LANDLORD |
| VD | VENDOR |
| WH | WAREHOUSE |


ARCHITECTURAL SITE PLAN NOTES

- REFER TO EXTERIOR ELEVATIONS ON SHEET A-2001 FOR BUILDING SIGNAGE LOCATION AND DESIGN ID. REFER TO ELECTRICAL PLANS FOR ELECTRICAL REQUIREMENTS.
- LANDSCAPING TO BE PROVIDED PER ZONING CODE AND LEED REQUIREMENTS.
- DRIVE-THRU EQUIPMENT INCLUDING VEHICLE DETECTION LOOP, WIRELESS COMMUNICATION AND MONITORS COORDINATED BY STARBUCKS CONSTRUCTION MANAGER. REFER TO ELECTRICAL SPECIFICATIONS FOR ELECTRICAL REQUIREMENTS.
- LANDLORD TO PROVIDE 6" (150MM) THICK CONCRETE PAVING THE LENGTH OF THE DRIVE-THRU LANE. EXTENT TO INCLUDE DRIVE-THRU WINDOW STANDING PAD.
- GENERAL CONTRACTOR TO APPLY CONCRETE SEALER TO ALL EXTERIOR CONCRETE PATIO AND WALKWAY SURFACES.
- SEE SHEET A-5001 FOR ARCHITECTURAL SITE DETAILS.

SHEET NOTES


- STARBUCKS SIGNAGE VENDOR TO COORDINATE APPROVALS AND PERMITS FOR EXTERIOR SIGNAGE SEPARATELY AS REQUIRED. **NOT INCLUDED IN TENANT BUILD-OUT APPLICATION.**
- SIGNAGE VENDOR TO PROVIDE & INSTALL FREESTANDING ILLUMINATED DRIVE THRU DIRECTIONAL SIGNAGE. MOUNT OVER EXISTING FOOTING FROM PREVIOUS SIGNAGE.
- SIGNAGE VENDOR TO PROVIDE & INSTALL FREESTANDING ILLUMINATED DRIVE THRU 'EXIT ONLY/THANK YOU' SIGN. MOUNT OVER EXISTING FOOTING FROM PREVIOUS SIGNAGE.
- SIGNAGE VENDOR TO PROVIDE & INSTALL WALL MOUNTED MENU BOARD.
- SIGNAGE VENDOR TO PROVIDE & INSTALL WALL MOUNTED DIGITAL ORDER SCREEN. REFER TO DOS CONTROL BOX DETAILS FOR MORE INFORMATION.
- SIGNAGE VENDOR TO PROVIDE & INSTALL FREESTANDING CLEARANCE BAR AS INDICATED. MOUNT OVER EXISTING FOOTING FROM PREVIOUS SIGNAGE.
- EXISTING PYLON SIGN, NEW PANELS ON BOTH SIDES. PROVIDED AND INSTALLED BY SIGNAGE VENDOR

NOTE: SIGNAGE UNDER SEPARATE PERMIT SHOWN FOR REFERENCE ONLY

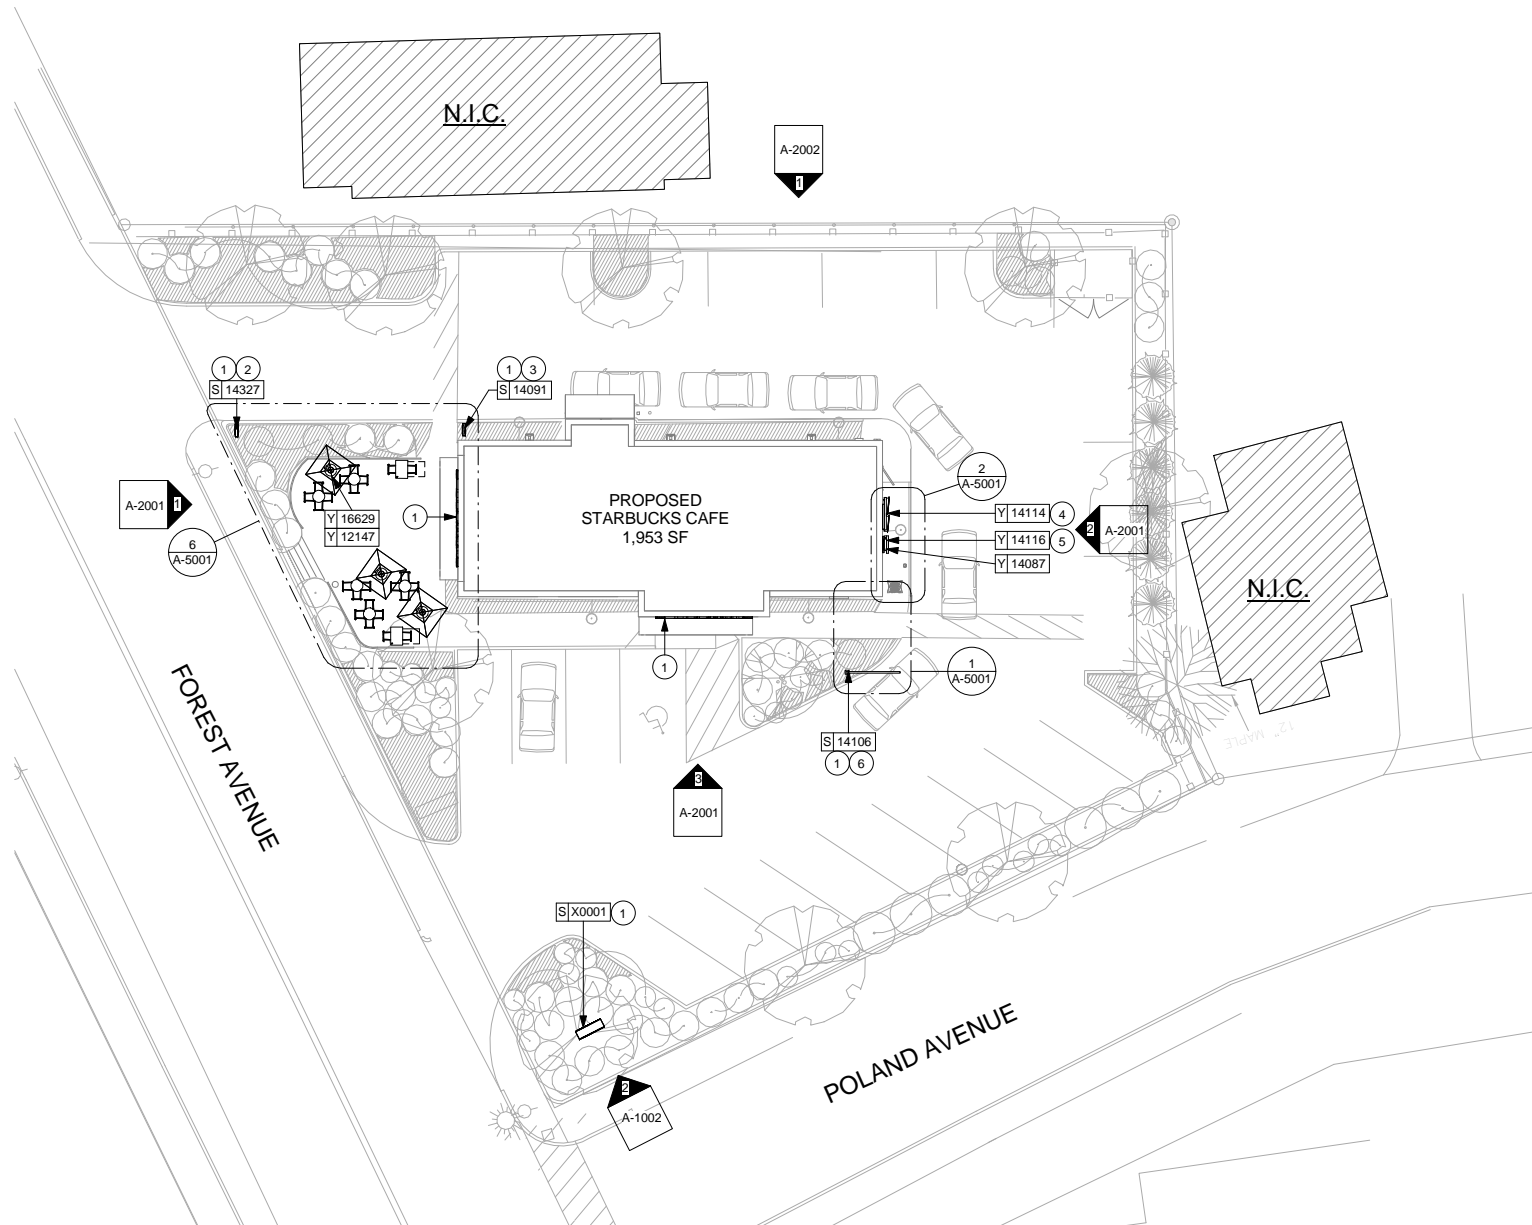

SITE PLAN

Scale: 1/16" = 1'-0"

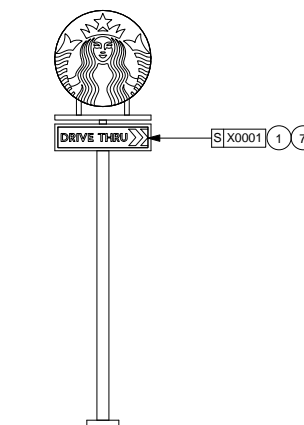

2 PYLON SIGN ELEVATION

Scale: 1/4" = 1'-0"



0 8' 16' 32'
Scale: 1/16" = 1'-0"

ISSUE FOR CONSTRUCTION 08/23/2017



STARBUCKS COFFEE COMPANY
2401 UTAH AVENUE SOUTH
SEATTLE, WASHINGTON 98134
(206) 319-1575

THESE DRAWINGS AND SPECIFICATIONS ARE CONFIDENTIAL AND SHALL REMAIN THE SOLE PROPERTY OF STARBUCKS CORPORATION, WHICH IS THE OWNER OF THE COPYRIGHT IN THIS WORK. THEY SHALL NOT BE REPRODUCED (IN WHOLE OR IN PART), SHARED WITH THIRD PARTIES OR USED IN ANY MANNER ON OTHER PROJECTS OR EXTENSIONS TO THIS PROJECT WITHOUT THE PRIOR WRITTEN CONSENT OF STARBUCKS CORPORATION. THESE DRAWINGS AND SPECIFICATIONS ARE INTENDED TO EXPRESS DESIGN INTENT FOR A PROTOTYPICAL STARBUCKS STORE (WHICH IS SUBJECT TO CHANGE AT ANYTIME) AND DO NOT REFLECT ACTUAL SITE CONDITIONS. NEITHER PARTY SHALL HAVE ANY OBLIGATION NOR LIABILITY TO THE OTHER (EXCEPT STATED ABOVE) UNTIL A WRITTEN AGREEMENT IS FULLY EXECUTED BY BOTH PARTIES.

STARBUCKS TEMPLATE VERSION I2016.12.23

NORR
ARCHITECTS PLANNERS
325 N. LaSalle St., Suite 500 | Chicago, IL 60604
1.312.424.2400 | www.norr.com

ENGINEER OF RECORD
William J. Abeney, P.E.
303 Marshall Avenue
St. Louis, Missouri 63119
Phone (314) 772-1782
Fax (314) 772-0208
Engineering Consultant

LICENSED ARCHITECT
PETER A. DURBIN
No. 257.3
STATE OF MICHIGAN

PROJECT NAME:
RENOVATION OF STARBUCKS COFFEE PORTLAND, 1080 FOREST AVE.
PROJECT ADDRESS:
1080 FOREST AVENUE
PORTLAND, ME 04103
CUMBERLAND COUNTY

STORE #: 11917
PROJECT #: 37548-037
ISSUE DATE: 08/23/2017
PROGRAM MANAGER: J. BOND
DESIGNER: A. LEE
LEED® AP: N/A
PRODUCTION DESIGNER: E. VEGA
CHECKED BY: P. BENVENUTO

| Revision Schedule | | | |
|-------------------|------|----|-------------|
| Rev | Date | By | Description |
| | | | |

SHEET TITLE:
ARCHITECTURAL SITE PLAN
SCALE: AS SHOWN

SHEET NUMBER:
A-1002