




F-1 Original Drawings Fire Suppression System

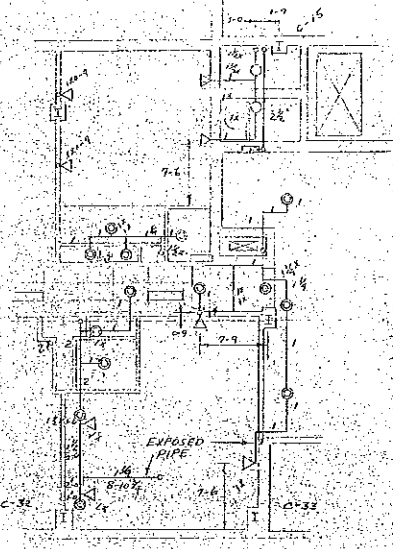


BEAUTY SHOP AND LAUNDRY ROOMS  
2<sup>ND</sup> FLOOR ONLY

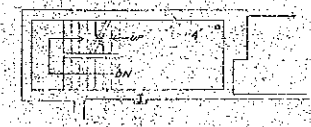

ROOF LEVEL

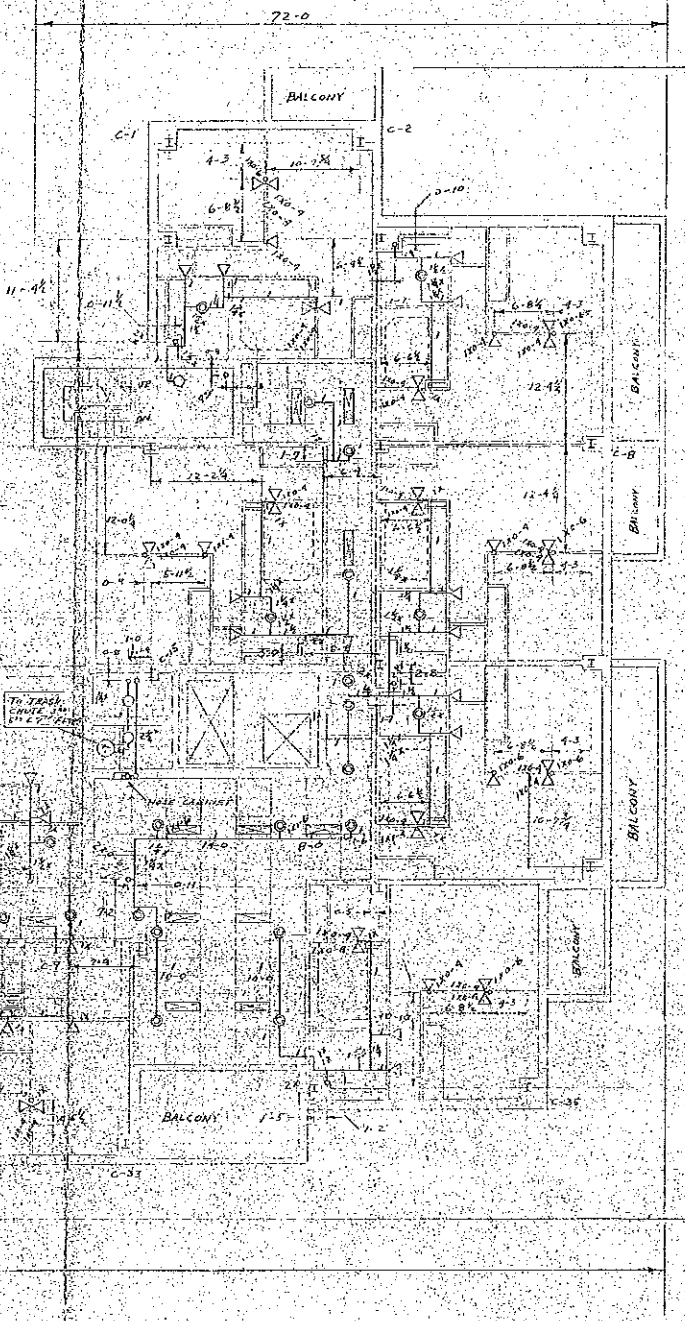

TYPICAL FLOOR PLAN 1/8" = 1'-0"

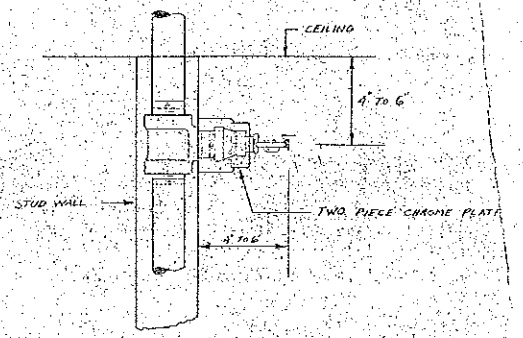

SIDEWALL SPRINKLER LOCATION  
3" = 1'-0"

SEE FINISH PLAN (ON THIS FLOOR)  
FOR 2<sup>ND</sup> FLOOR ONLY

DATE REVISIONS  
 slater JOB NO: 02001  
**WILLIAM DORSKY ASSOCIATES, INC.**  
 ARCHITECTS  
 Review is only for conformance with the contract documents of the  
 Project and general conditions with the District Department of  
 Building here's authority additional field. The Contractor is  
 solely responsible for:  
 - Verifications and conformance to field conditions.  
 - Installation process, scheduling, sequencing and construction  
 - Methods, materials, equipment, sequence, construction  
 - Coordination of the work.  
 CONFORMS AS NOTED  DOES NOT CONFORM  
 CONFORMS AS NOTED  DOES NOT CONFORM  
 DATE: slater BY: [Signature]

FOR SMOKE  
 SPRINKLER SYSTEMS  
 P.O. Box 2763  
 617 N. U.S. Route 1  
 Springfield, Illinois 62774  
 (309) 863-2521

SCALE	DATE	BY
APPROVAL		
DRAWING NO.		
OF		