


REISSUE ENTIRE SHEET

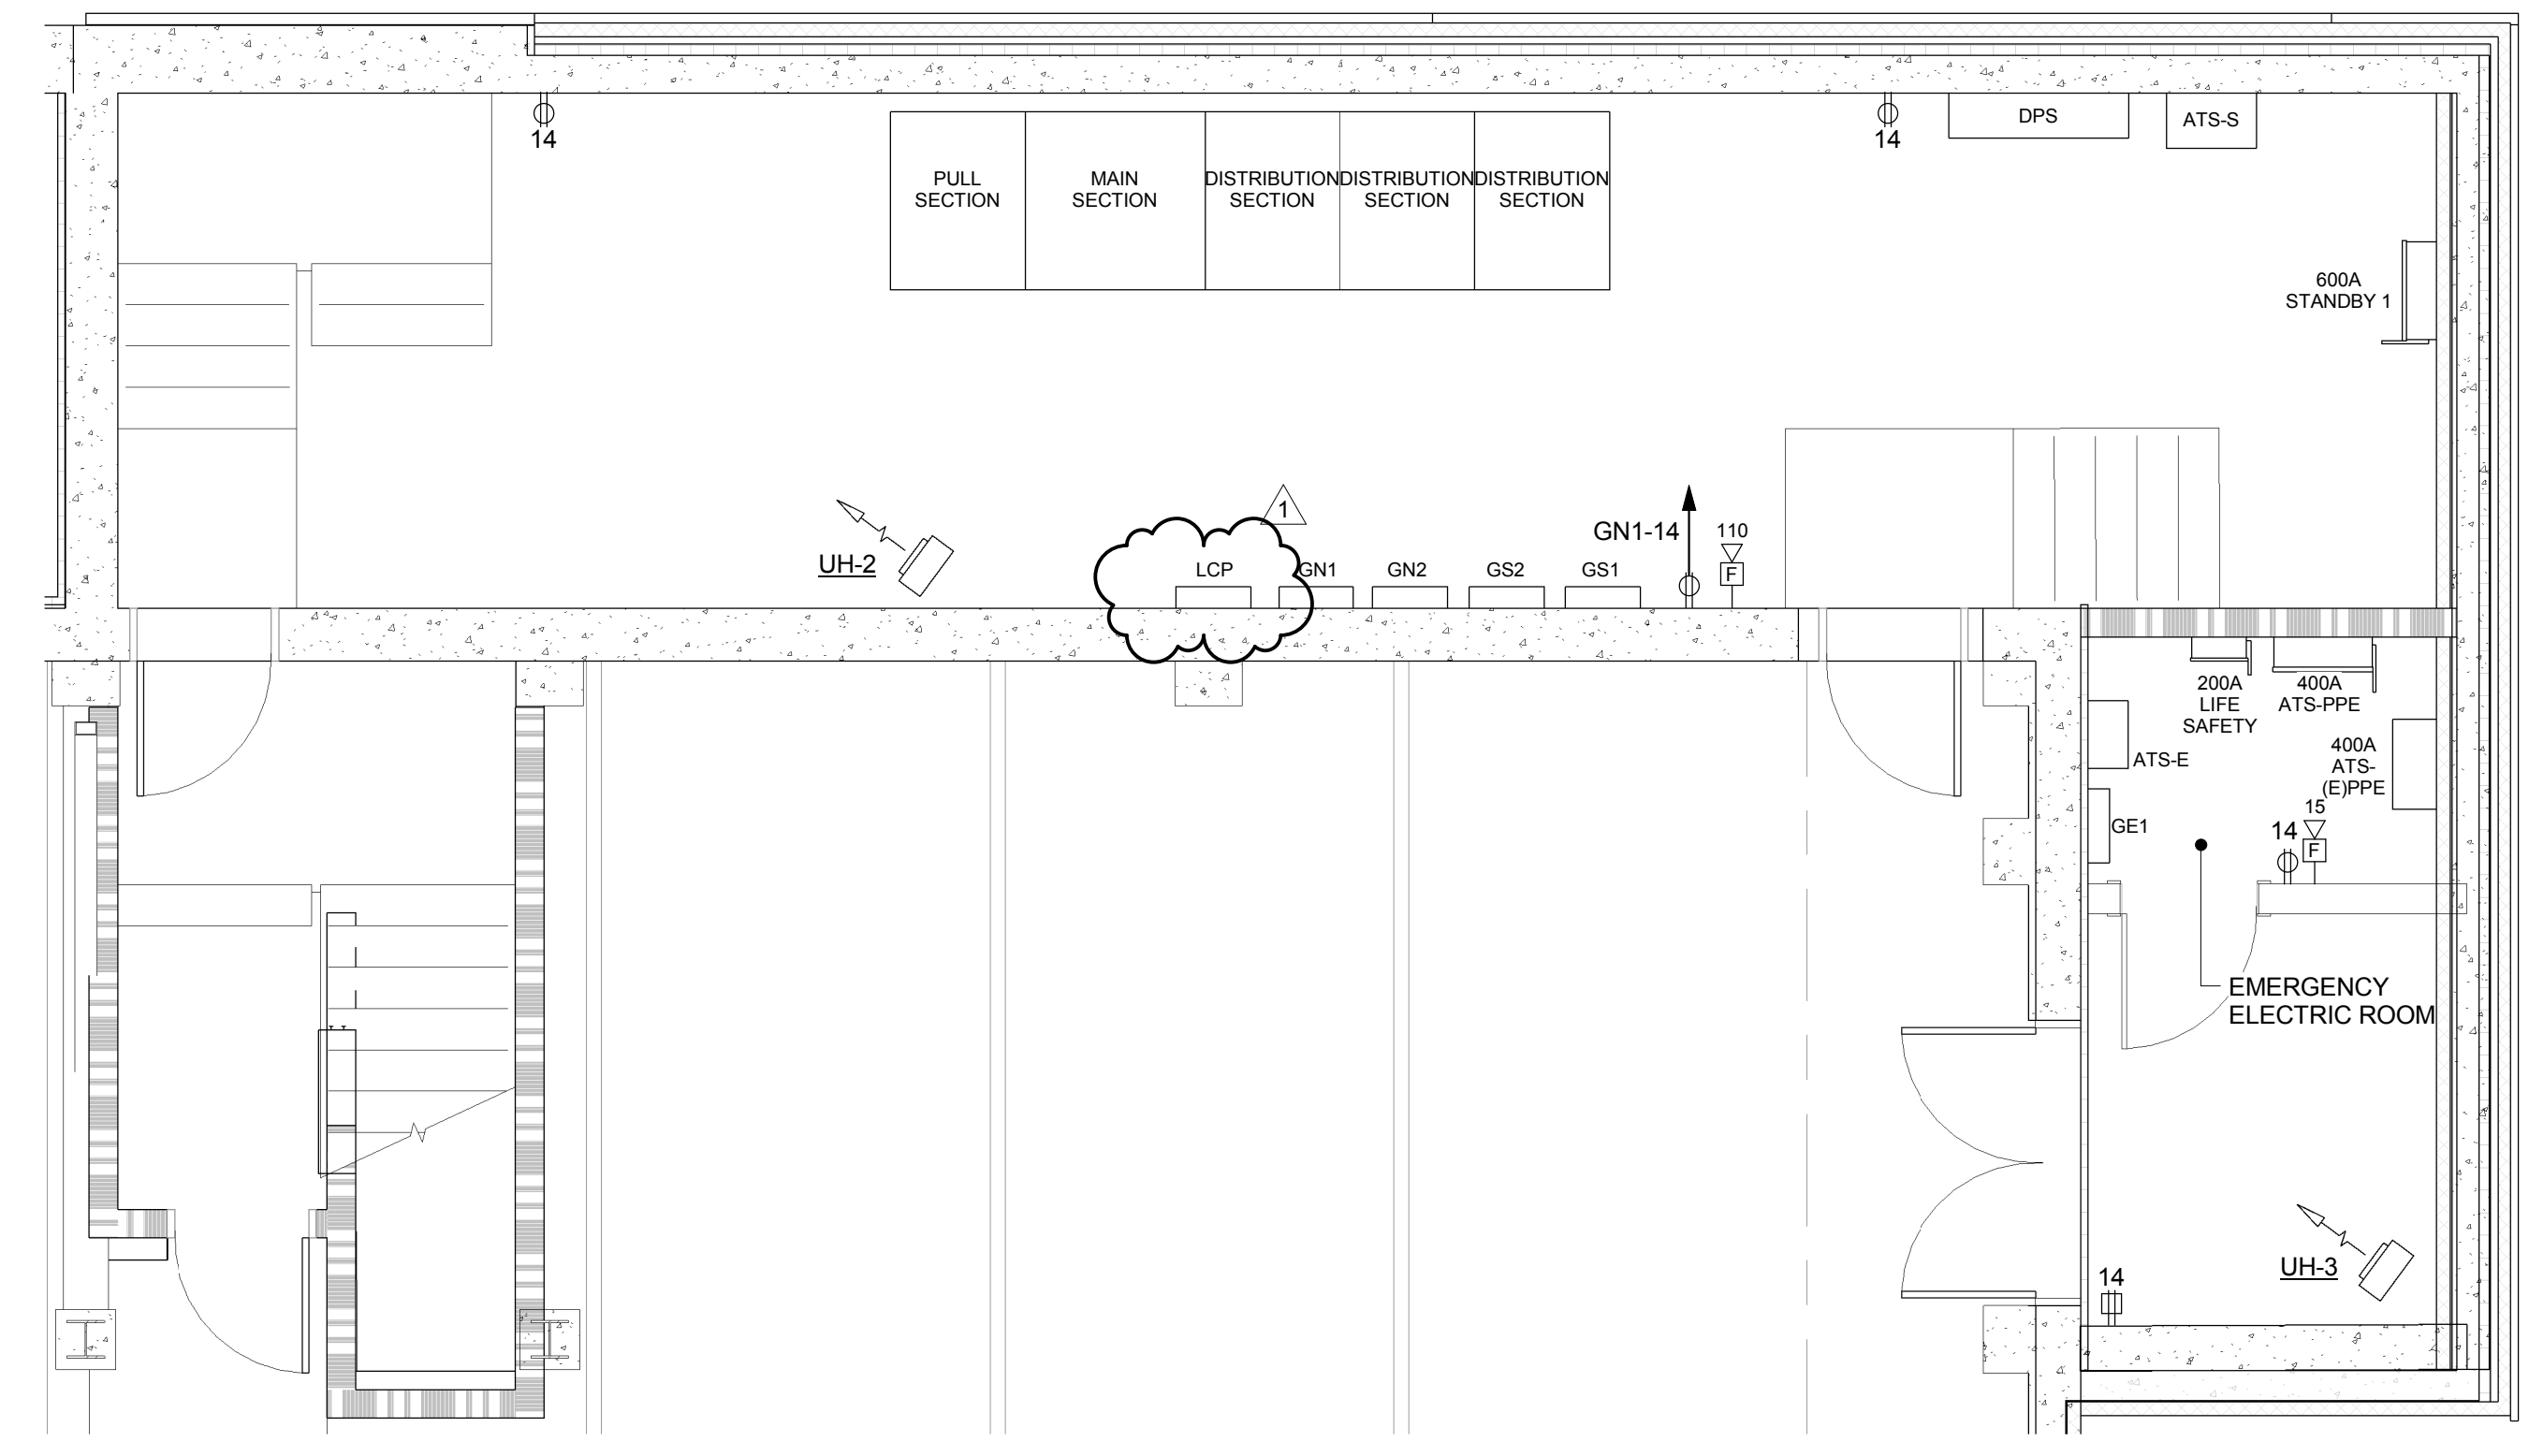


**F6 ENLARGED MAIN ELECTRIC ROOM**  
 1/4" = 1'-0"


**ELECTRICAL SCHEDULE OF BISTRO AND BAR EQUIPMENT**

TAG	DESCRIPTION	VOLTS	PH	LOAD	RECEPT OR J-BOX	PANEL	WIRING IN CONDUIT (2#12, 1#12G, UNO)	NOTES
3	SODA SYSTEM	120	1		NEMA 5-20R	MN1		
8	REACH-IN REFRIGERATOR	120	1	11.6A	NEMA 5-20R	MN1		
9	FIRE SUPPRESSION SYSTEM	120	1		J-BOX	MN1		1
10	EXHAUST HOOD LIGHTS	120	1	0.2KW	J-BOX	MN1		
13	FRYER WITH OIL FILTRATION SYSTEM	120	1	6.1A, 0.7A	(2) NEMA 5-20R	MN1		
20	REFRIGERATED PREP TABLE	120	1	4.9A	NEMA 5-20R	MN1		
21	WORK COUNTER WITH SINK	120	1		NEMA 5-20R GFI	MN1		
24	WORK COUNTER	120	1		NEMA 5-20R GFI	MN1		
25	SOFT-SERVE ICE CREAM DISPENSER	208	1	12A	NEMA 6-15R	MN1		
27	SODA AND ICE DISPENSER	120	1		NEMA 5-20R	MN1		
30	REFRIGERATED DISPLAY CASE	120	1	9A	NEMA 5-20R	MN1		
31	POS	120	1		NEMA 5-20R	MN1		3
32	SOUP WELLS (2)	120	1	7.5A	(2) NEMA 5-20R	MN1		
34	SERVER COUNTER	120	1		NEMA 5-20R GFI	MN1		
37	INSTANT COFFEE BREWER	120	1		NEMA 5-20R	MN1		
38	UNDERCOUNTER REFRIGERATOR	120	1	2.3A	NEMA 5-20R	MN1		
39	WATER AND ICE DISPENSER	120	1	5A	NEMA 5-20R	MN1		
42	UNDERCOUNTER ICE MAKER	120	1		NEMA 5-20R	MN1		
43	UNDERCOUNTER REFRIGERATOR	120	1	3.2A	NEMA 5-20R	MN1		
44	UNDERCOUNTER GLASS WASHER WITH BOOSTER HEATER	208	1		J-BOX	MN1	2#6, 1#10G-1" C	


**NOTES:**  
 1 WIRE AND CONNECT TO FACP AND POWER SHUTDOWN  
 2 PROVIDE CORD AND PLUG  
 3 PROVIDE DATA OUTLET

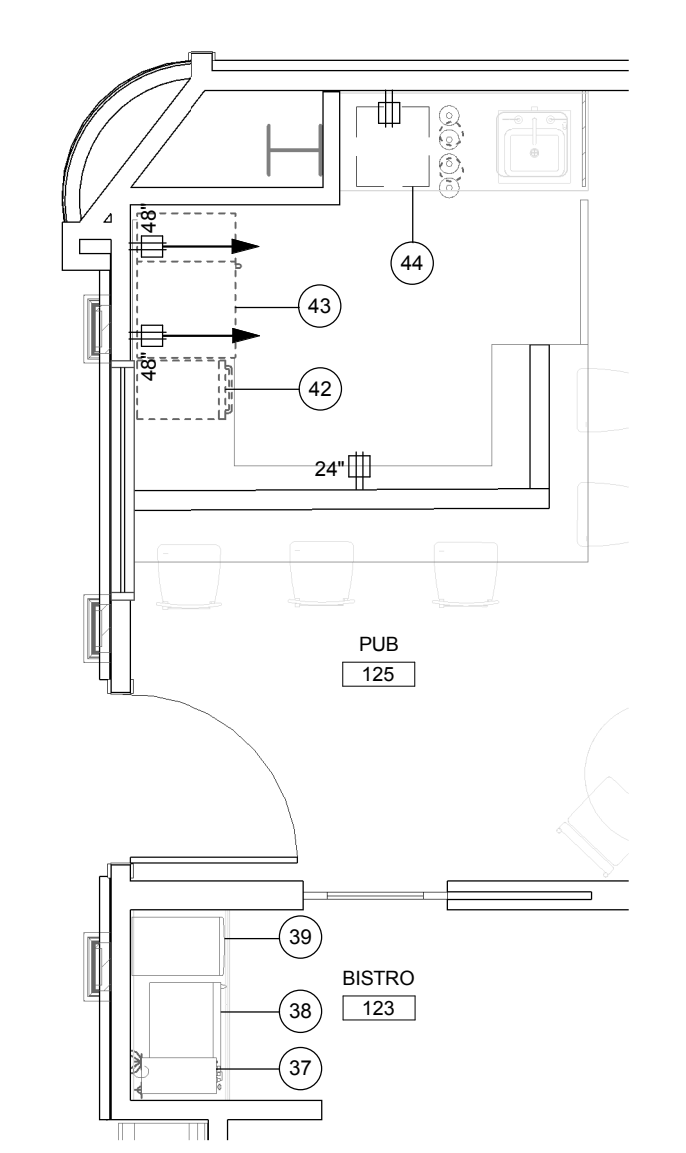


**A6 ENLARGED BAR/BISTRO PLAN**  
 1/4" = 1'-0"

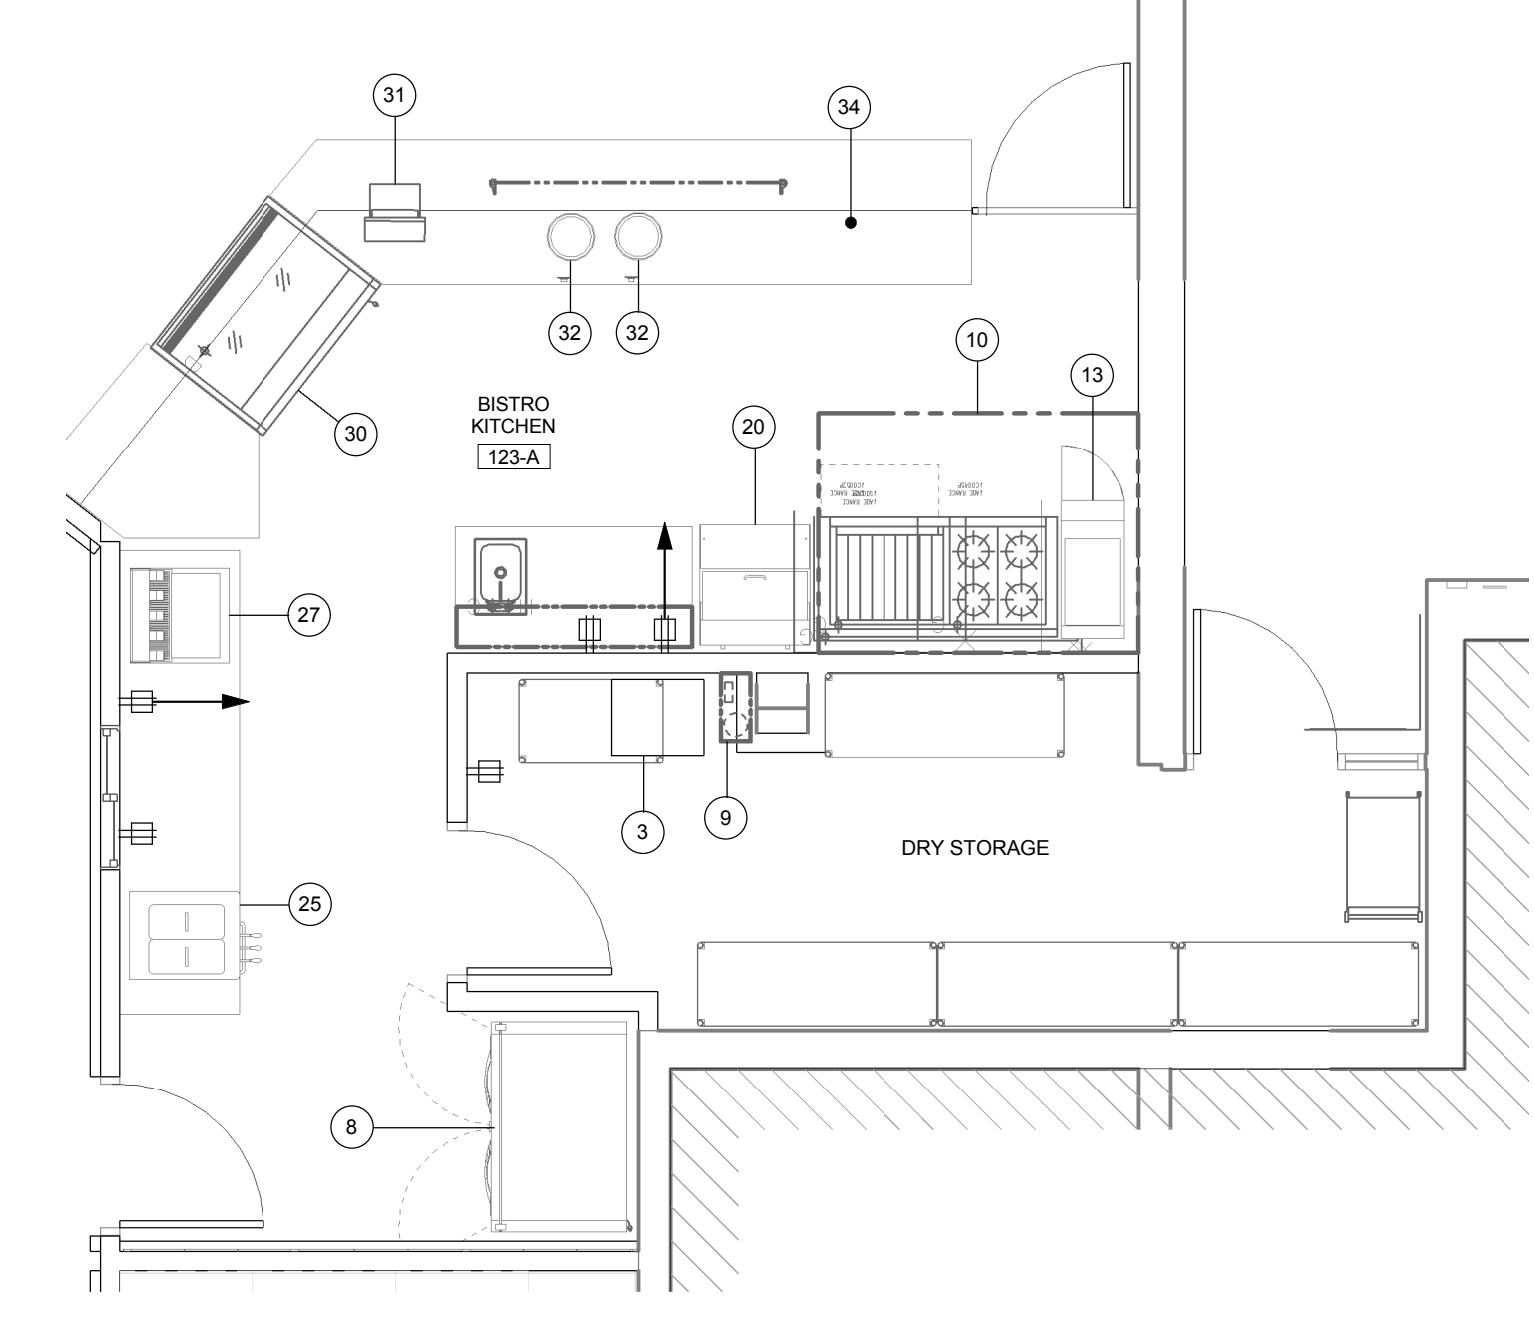


**A8 ENLARGED BISTRO KITCHEN PLAN**  
 1/4" = 1'-0"

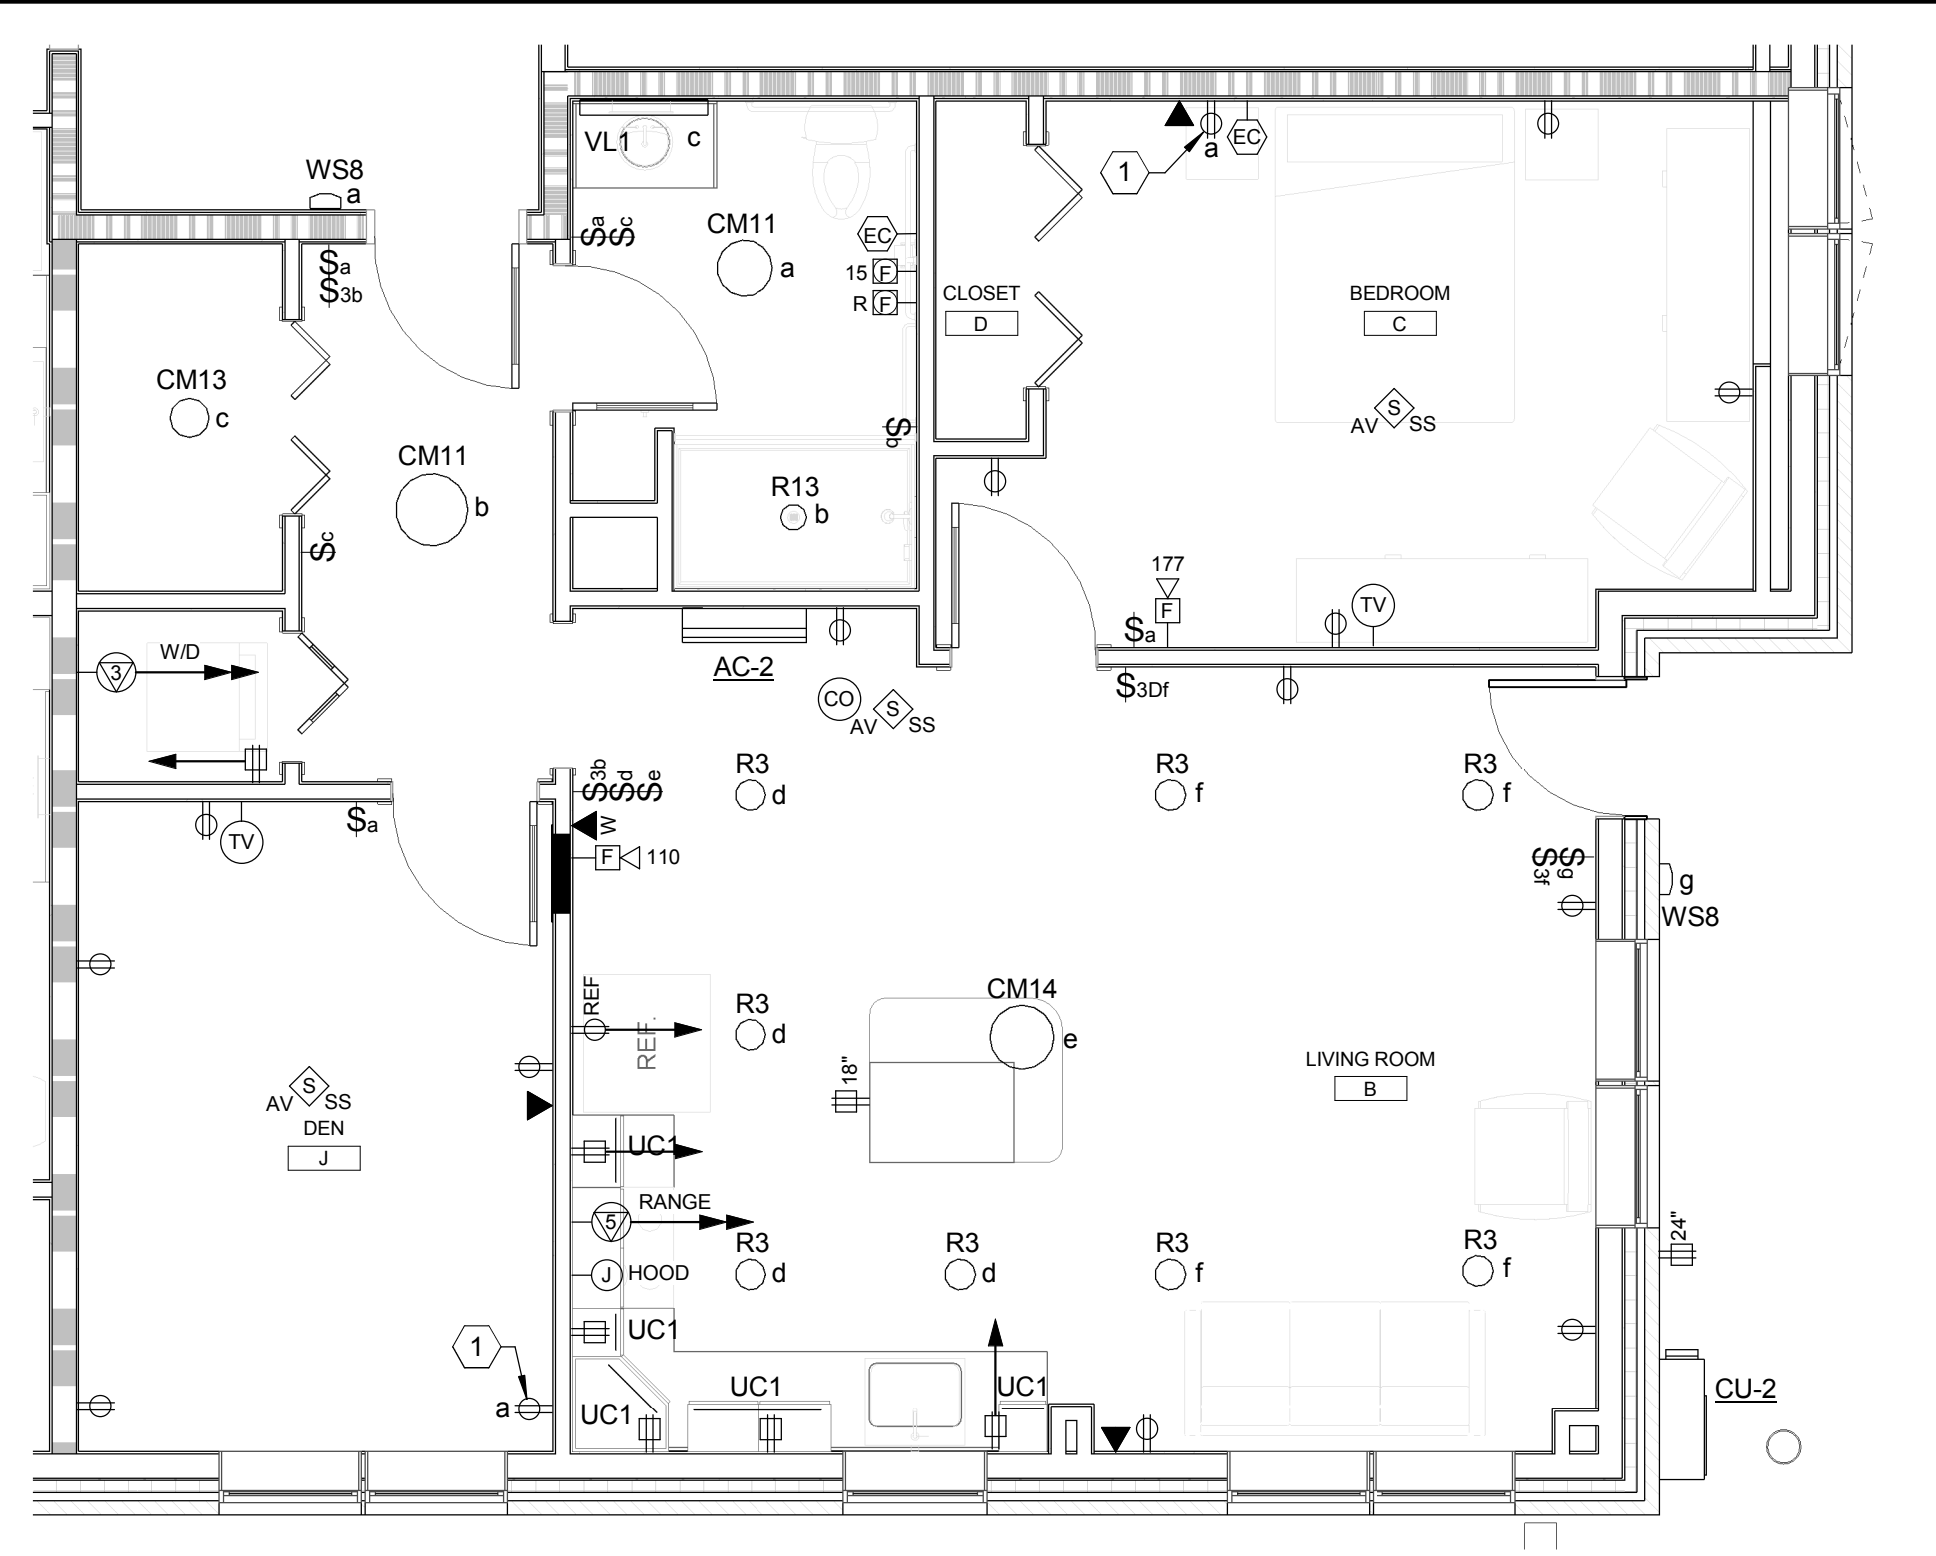


**E1 TYPICAL UNIT TYPE K**  
 1/4" = 1'-0"

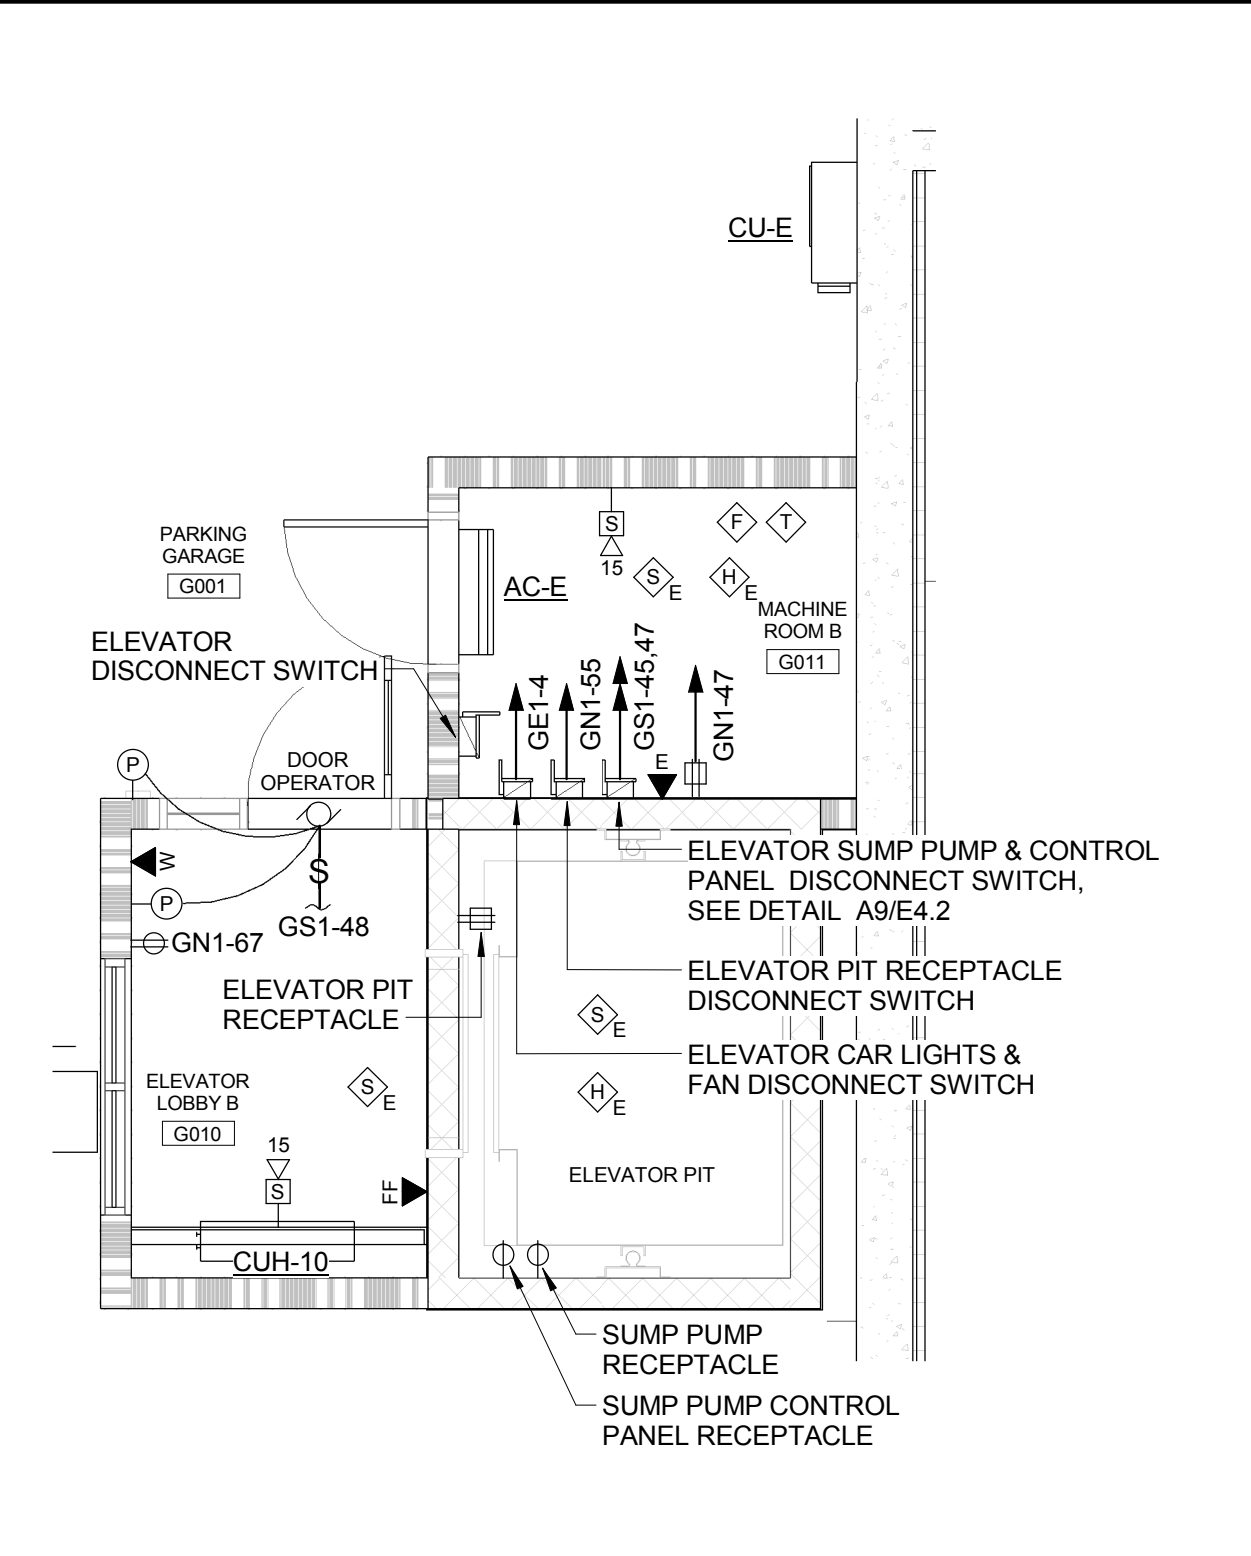


**C4 ELEVATOR B PLAN**  
 1/4" = 1'-0"

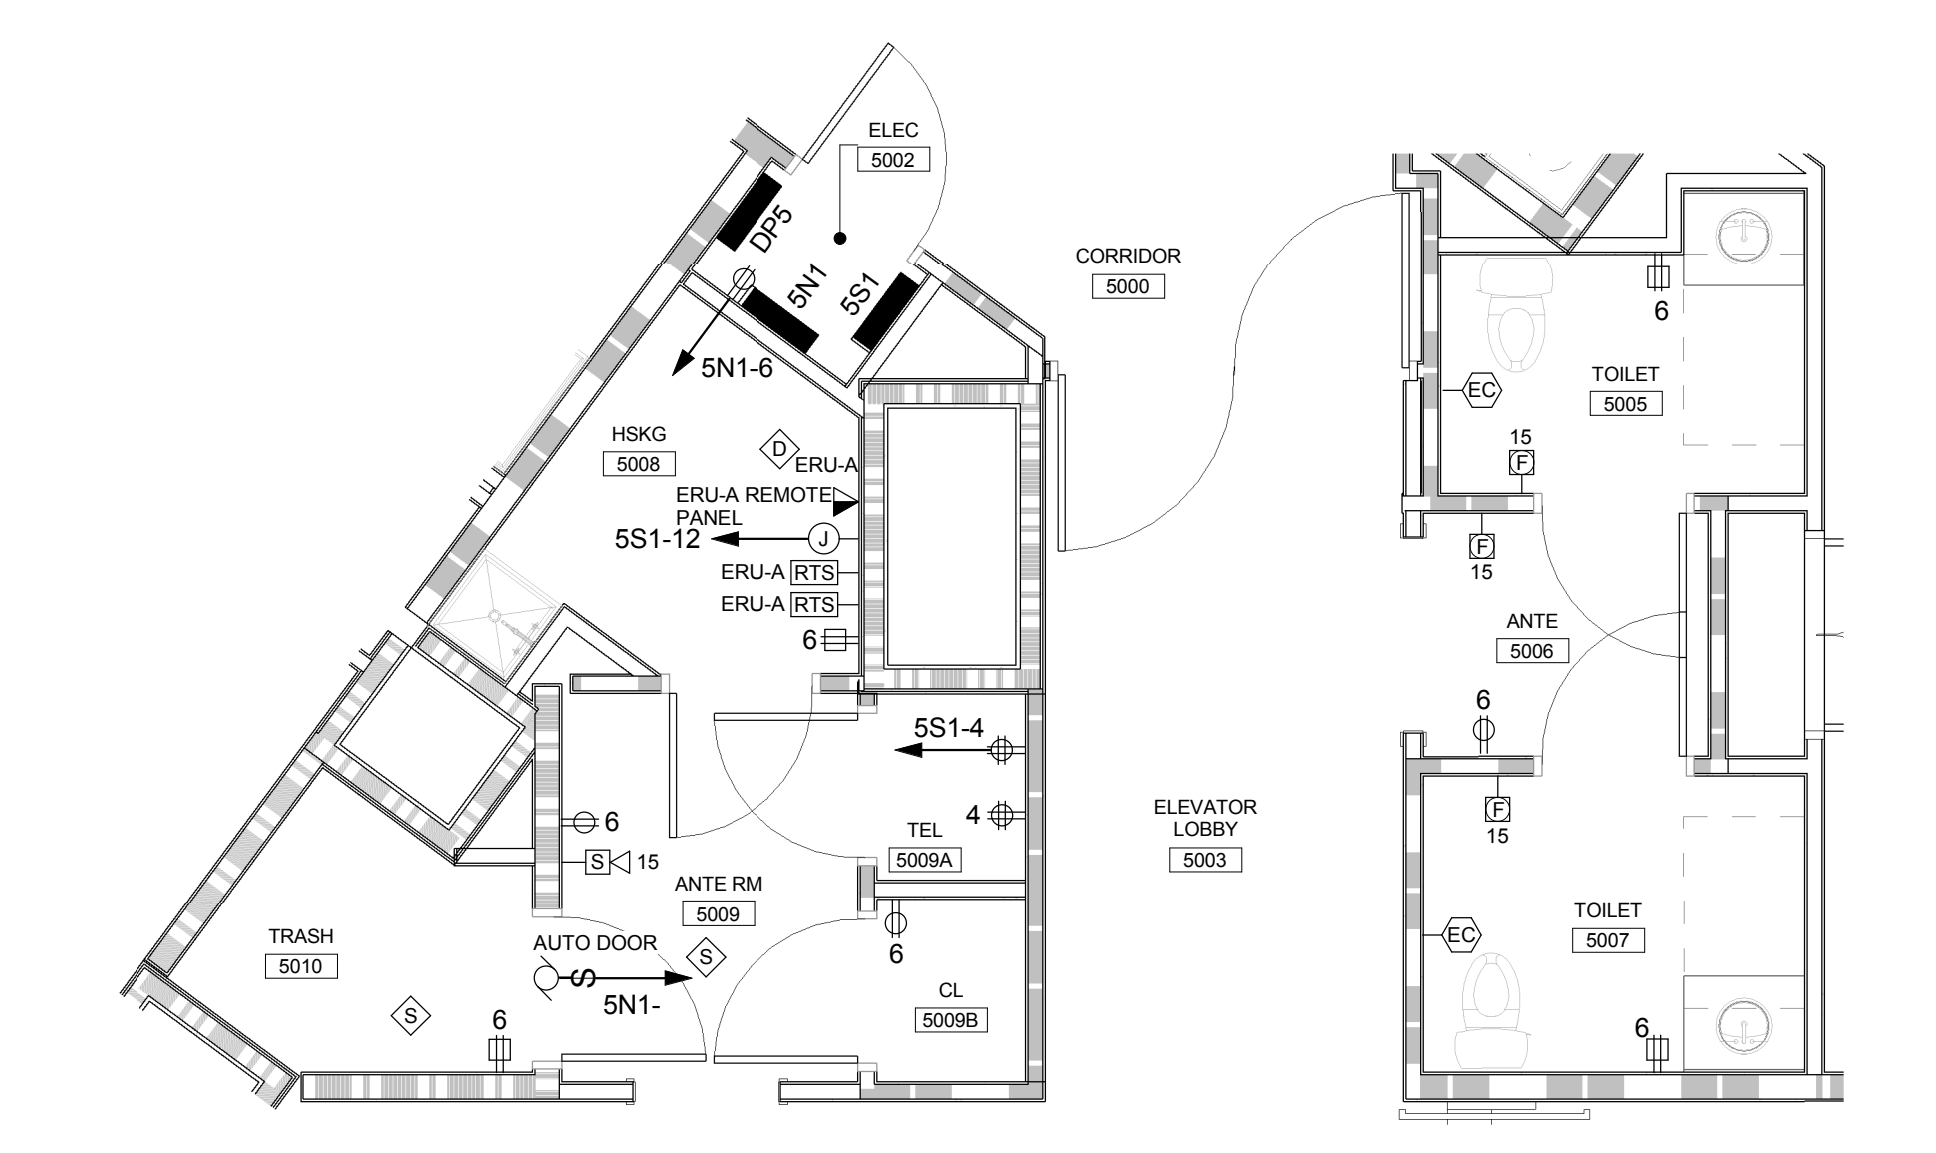


**C1 ENLARGED LEVEL 5 PART PLAN**  
 1/4" = 1'-0"

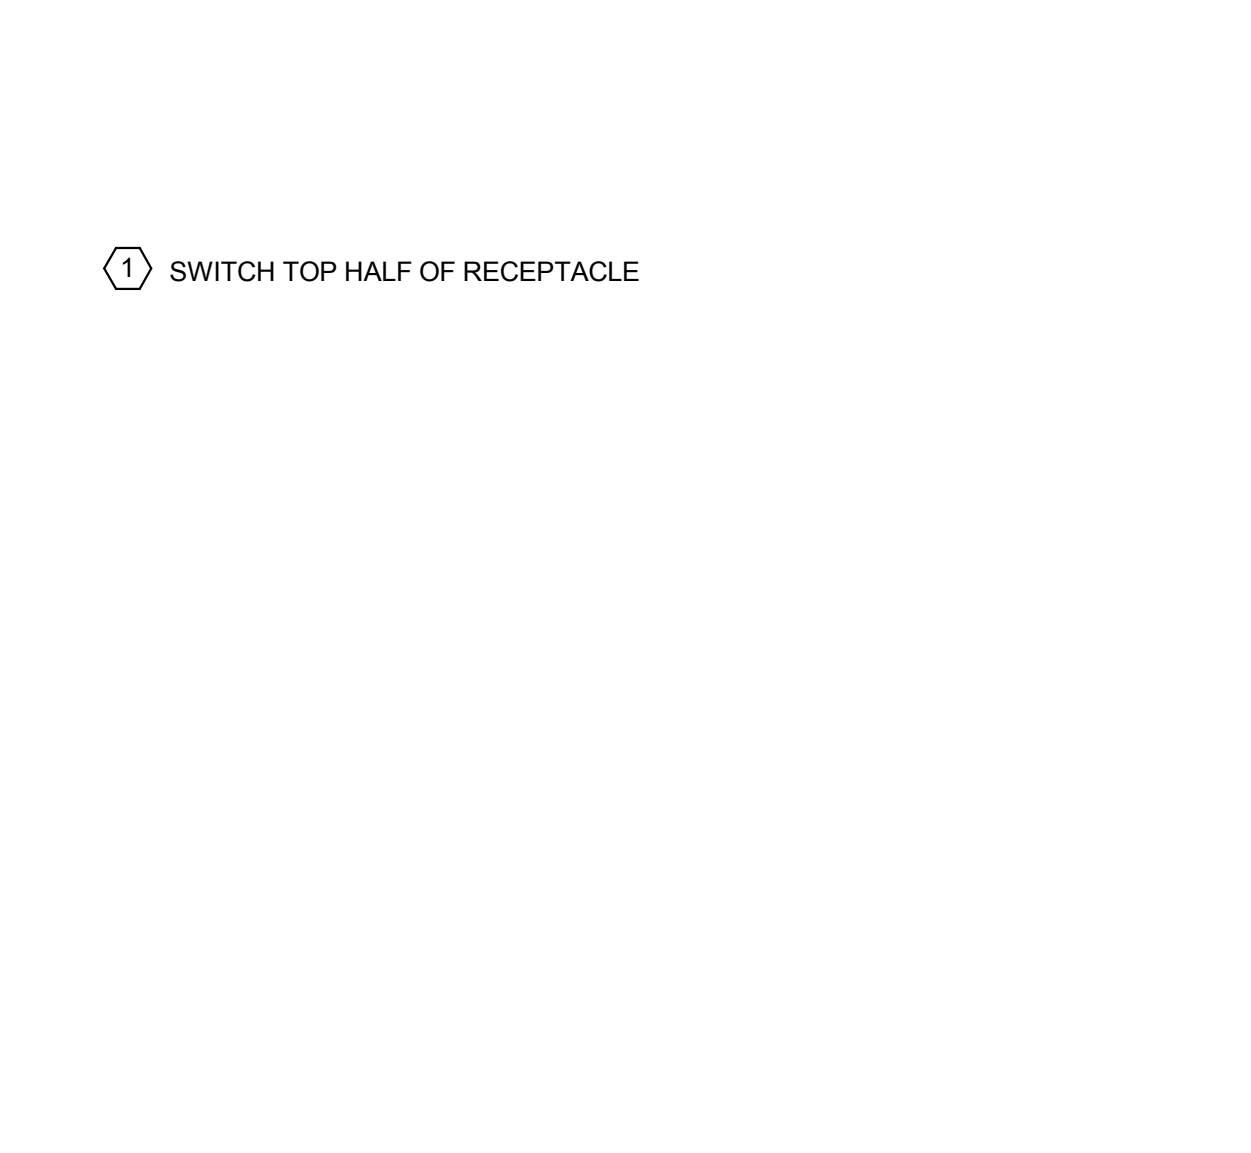

**C4 KEY NOTES**

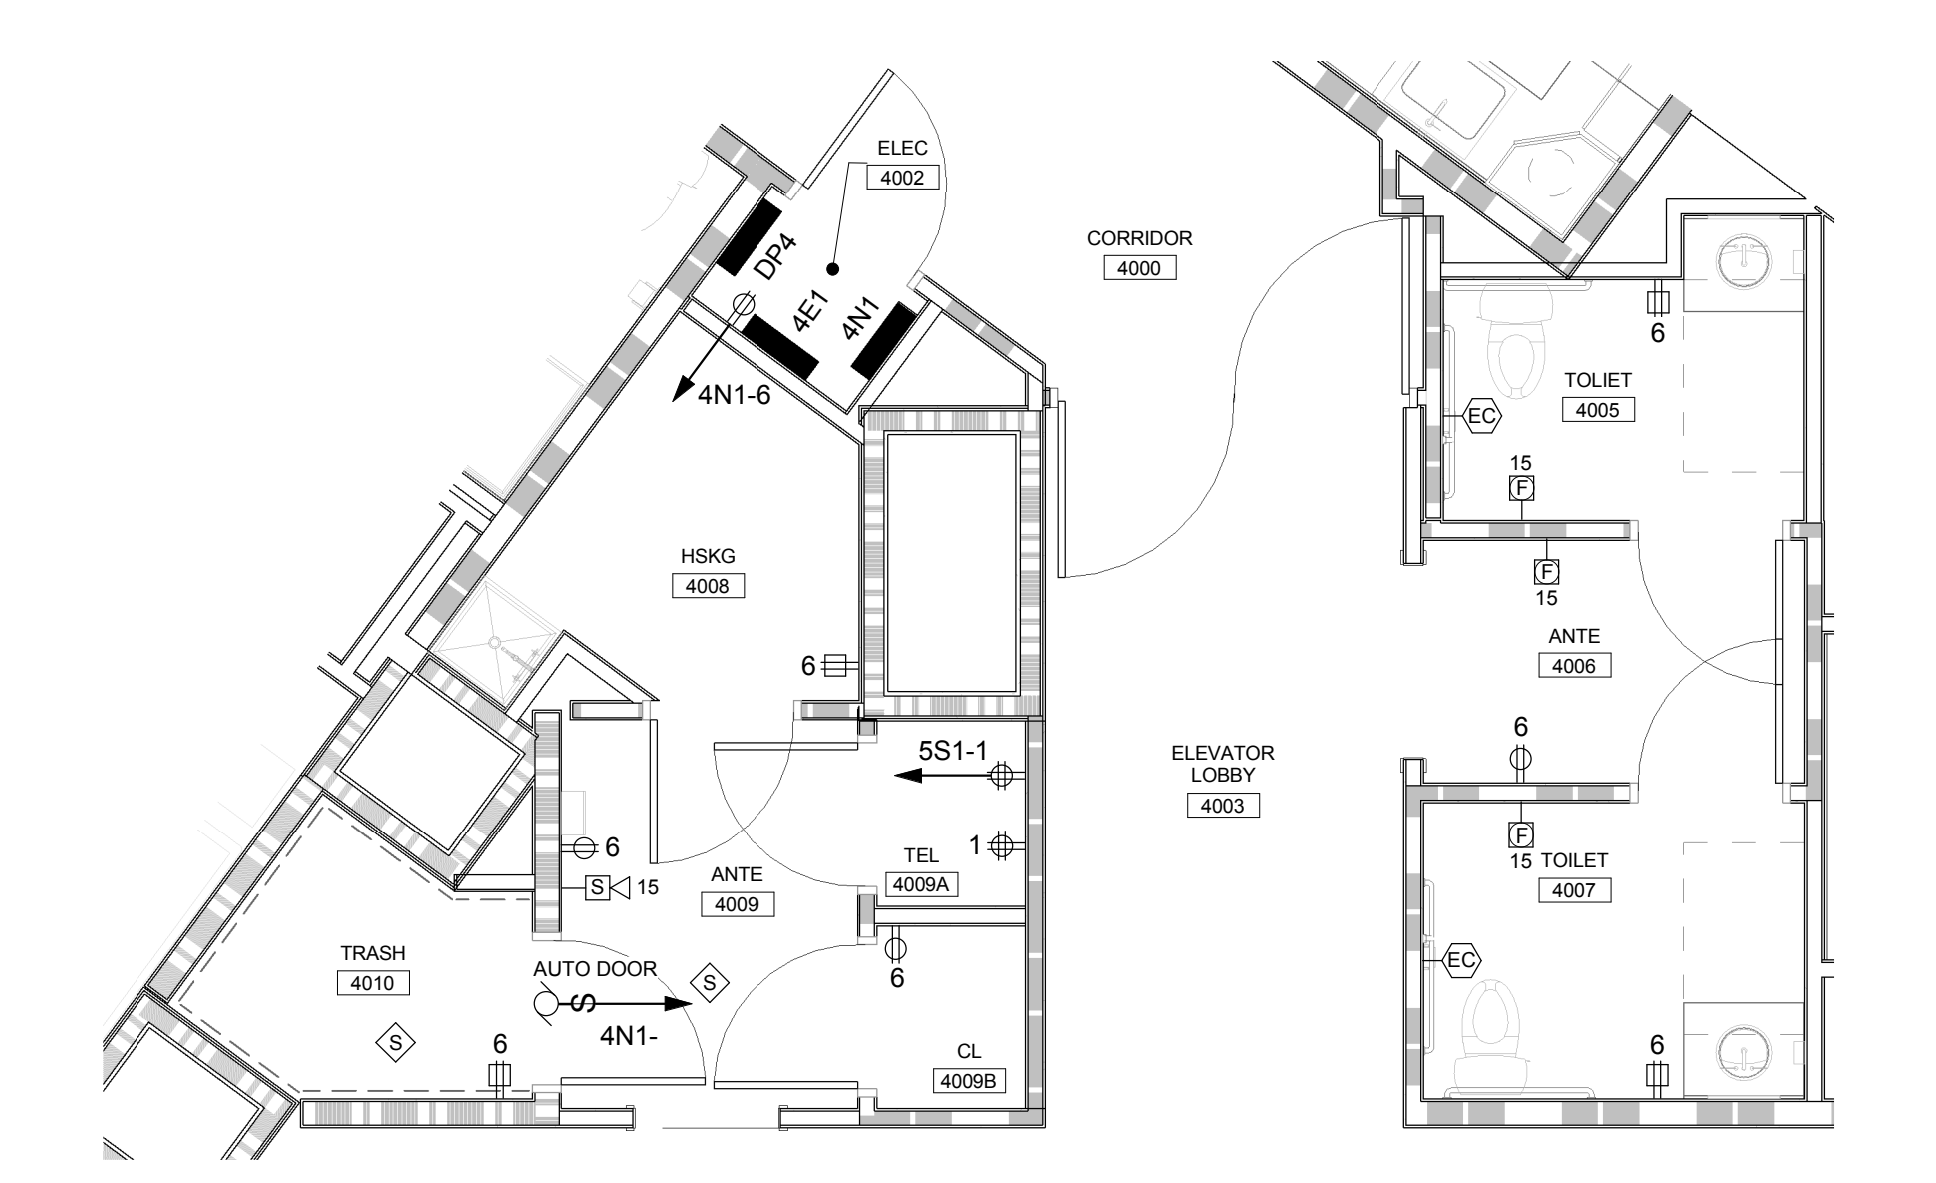

**A1 ENLARGED LEVEL 4 PART PLAN**  
 1/4" = 1'-0"

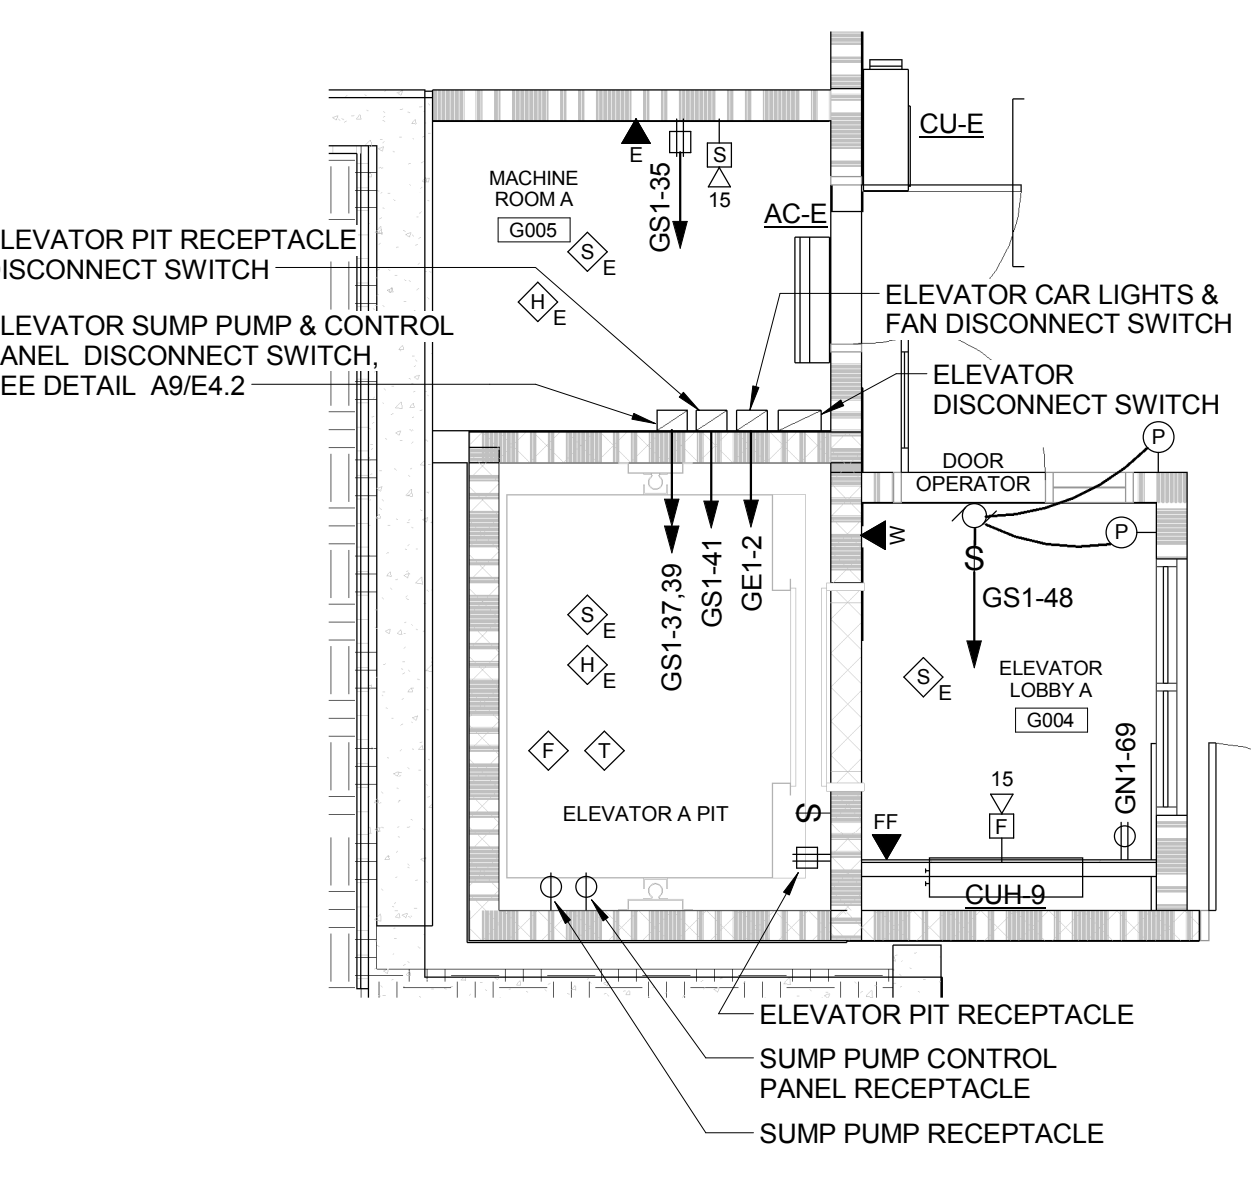

**A4 ELEVATOR A PLAN**  
 1/4" = 1'-0"

The Park Danforth

777 Stevens Ave, Portland, ME, 04103

NO.	DESCRIPTION	DATE
1	Addendum No 2	2015-06-25

**CONTENT:**  
 ENLARGED PLANS

DRAWN BY: \_\_\_\_\_ Author

PROJECT NO: \_\_\_\_\_

DATE: 06/05/2015

REVISED: \_\_\_\_\_

SCALE: AS NOTED

**E4.3**

Project Phase  
 100% CONSTRUCTION DOCUMENTS

COPYRIGHT © 2014 BY LAVALLEE BRENSINGER PROFESSIONAL ASSOCIATION. ALL RIGHTS RESERVED. NO REPRODUCTION WITHOUT PERMISSION.

6/29/2015 10:07:19 AM N:\Projects\2014\14018 - Park Danforth\00 Drawing Files - REV\IT 2015\14018E.dwg