


160 Veranda Street  
 Portland, Maine 04103  
 T: 207.221.2240  
 F: 207.221.2246  
 Web: www.allied-eng.com

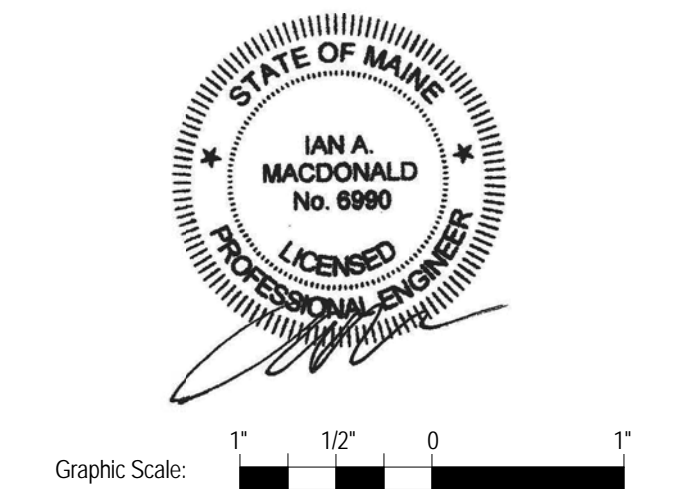


Graphic Scale: 1" = 10' 0"


The Park Danforth

777 Stevens Ave, Portland, ME, 04103

NO.	DESCRIPTION	DATE
1	Addendum No. 2	2015-06-25

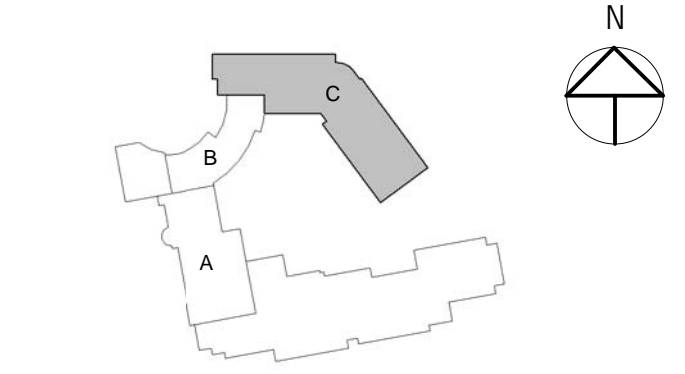

CONTENT:	
MECHANICAL PLAN - GARAGE LEVEL	
DRAWN BY:	REW
PROJECT NO.:	-
DATE:	06/05/2015
REVISED:	-
SCALE:	AS NOTED
<b>MH1.0C</b>	
Project Phase	
100% CONSTRUCTION DOCUMENTS	
<small>COPYRIGHT © 2014 BY LAVALLEE BRENSINGER PROFESSIONAL ASSOCIATION. ALL RIGHTS RESERVED. NO REPRODUCTION WITHOUT PERMISSION.</small>	

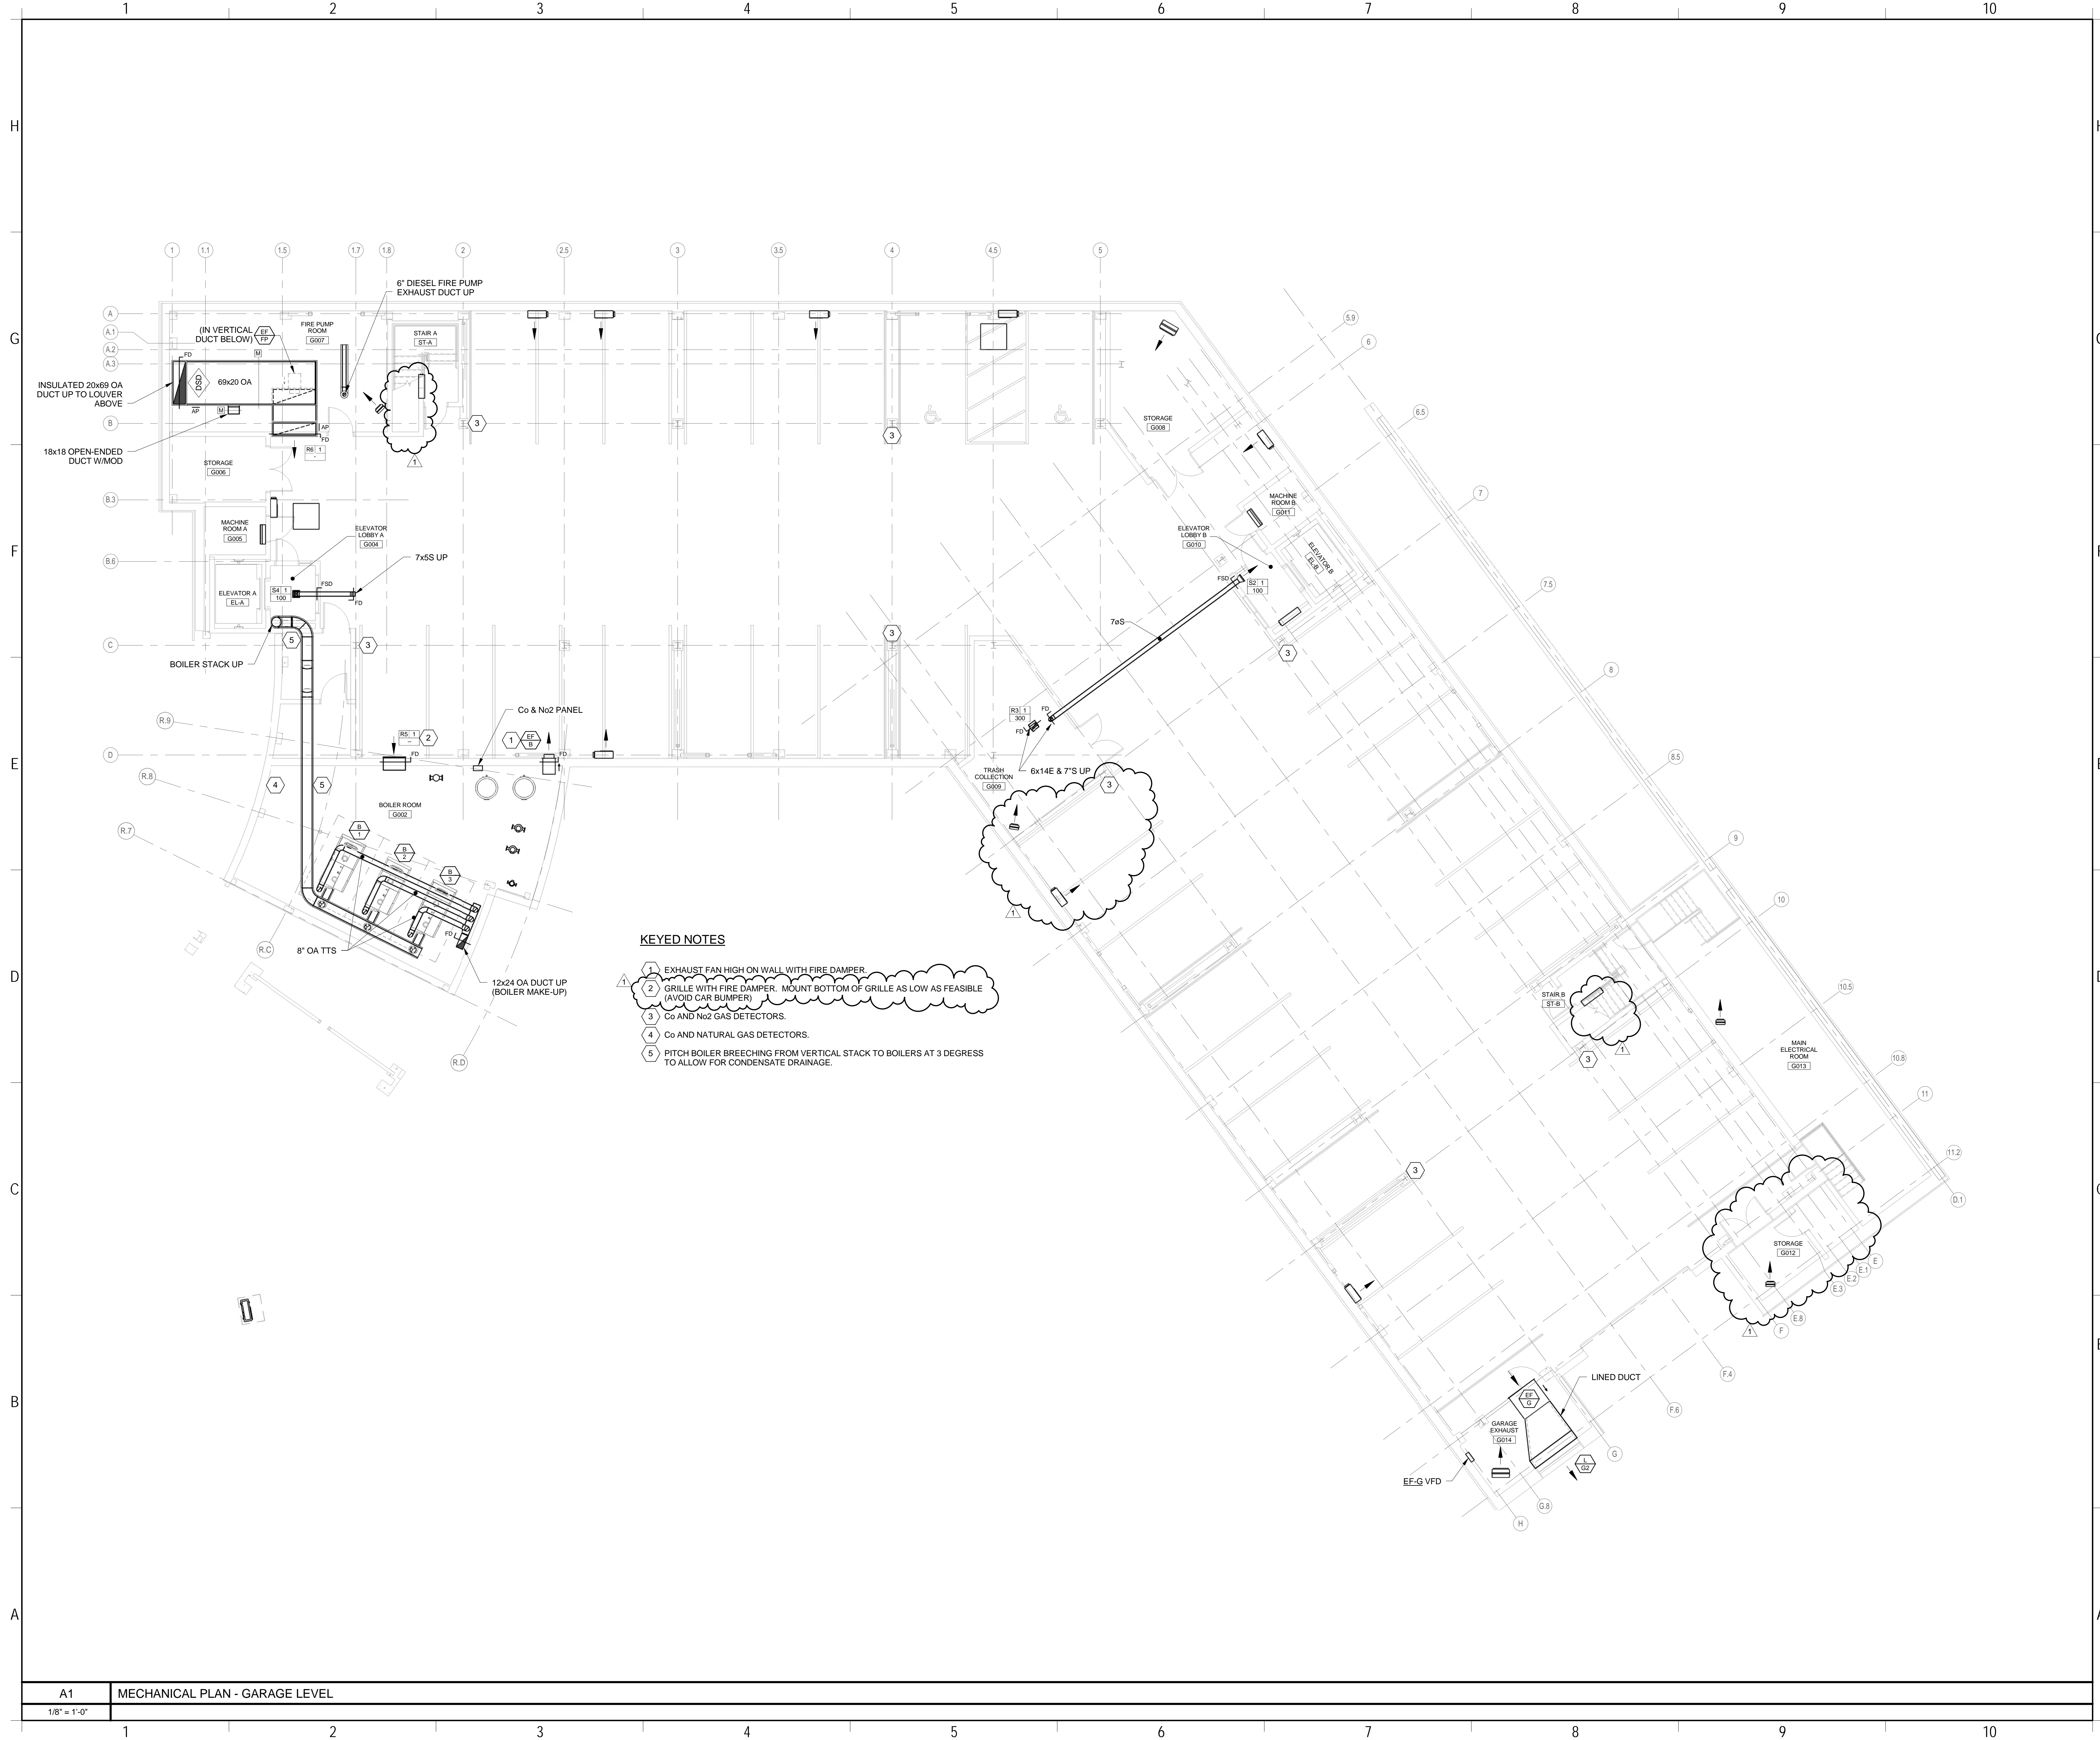

- KEYED NOTES**
- 1 EXHAUST FAN HIGH ON WALL WITH FIRE DAMPER.
  - 2 GRILLE WITH FIRE DAMPER. MOUNT BOTTOM OF GRILLE AS LOW AS FEASIBLE (AVOID CAR BUMPER).
  - 3 Co AND No2 GAS DETECTORS.
  - 4 Co AND NATURAL GAS DETECTORS.
  - 5 PITCH BOILER BREECHING FROM VERTICAL STACK TO BOILERS AT 3 DEGREE TO ALLOW FOR CONDENSATE DRAINAGE.

A1 MECHANICAL PLAN - GARAGE LEVEL

1/8" = 1'-0"

6/29/2015 8:42:55 AM N:\Projects\2015\101018 - Park Danforth\100 Drawing files - REV\17 2015\101018.rvt