


160 Veranda Street
 Portland, Maine 04103
 T: 207.221.2340
 F: 207.221.2346
 Web: www.allied-eng.com

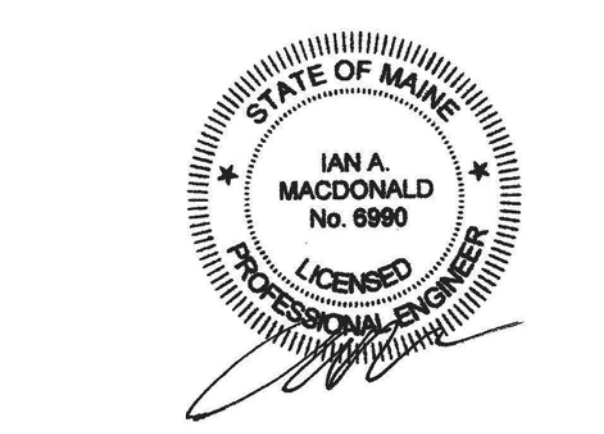


Graphic Scale: 1" = 10' 0"


The Park Danforth

777 Stevens Ave, Portland, ME, 04103

NO.	DESCRIPTION	DATE
1	Addendum No. 2	2015-06-25

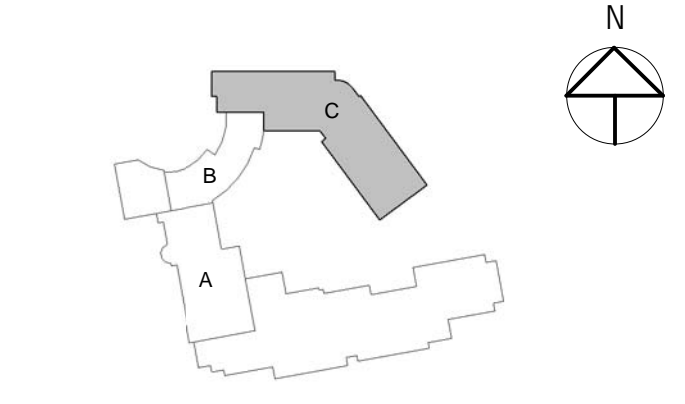

CONTENT: MECHANICAL PLAN - LEVEL 3 - NEW BUILDING	
DRAWN BY:	REW
PROJECT NO.:	-
DATE:	06/05/2015
REVISED:	-
SCALE:	AS NOTED
MH1.3C	
Project Phase 100% CONSTRUCTION DOCUMENTS	
<small>COPYRIGHT © 2014 BY LAVALLEE BRENSINGER PROFESSIONAL ASSOCIATION. ALL RIGHTS RESERVED. NO REPRODUCTION WITHOUT PERMISSION.</small>	

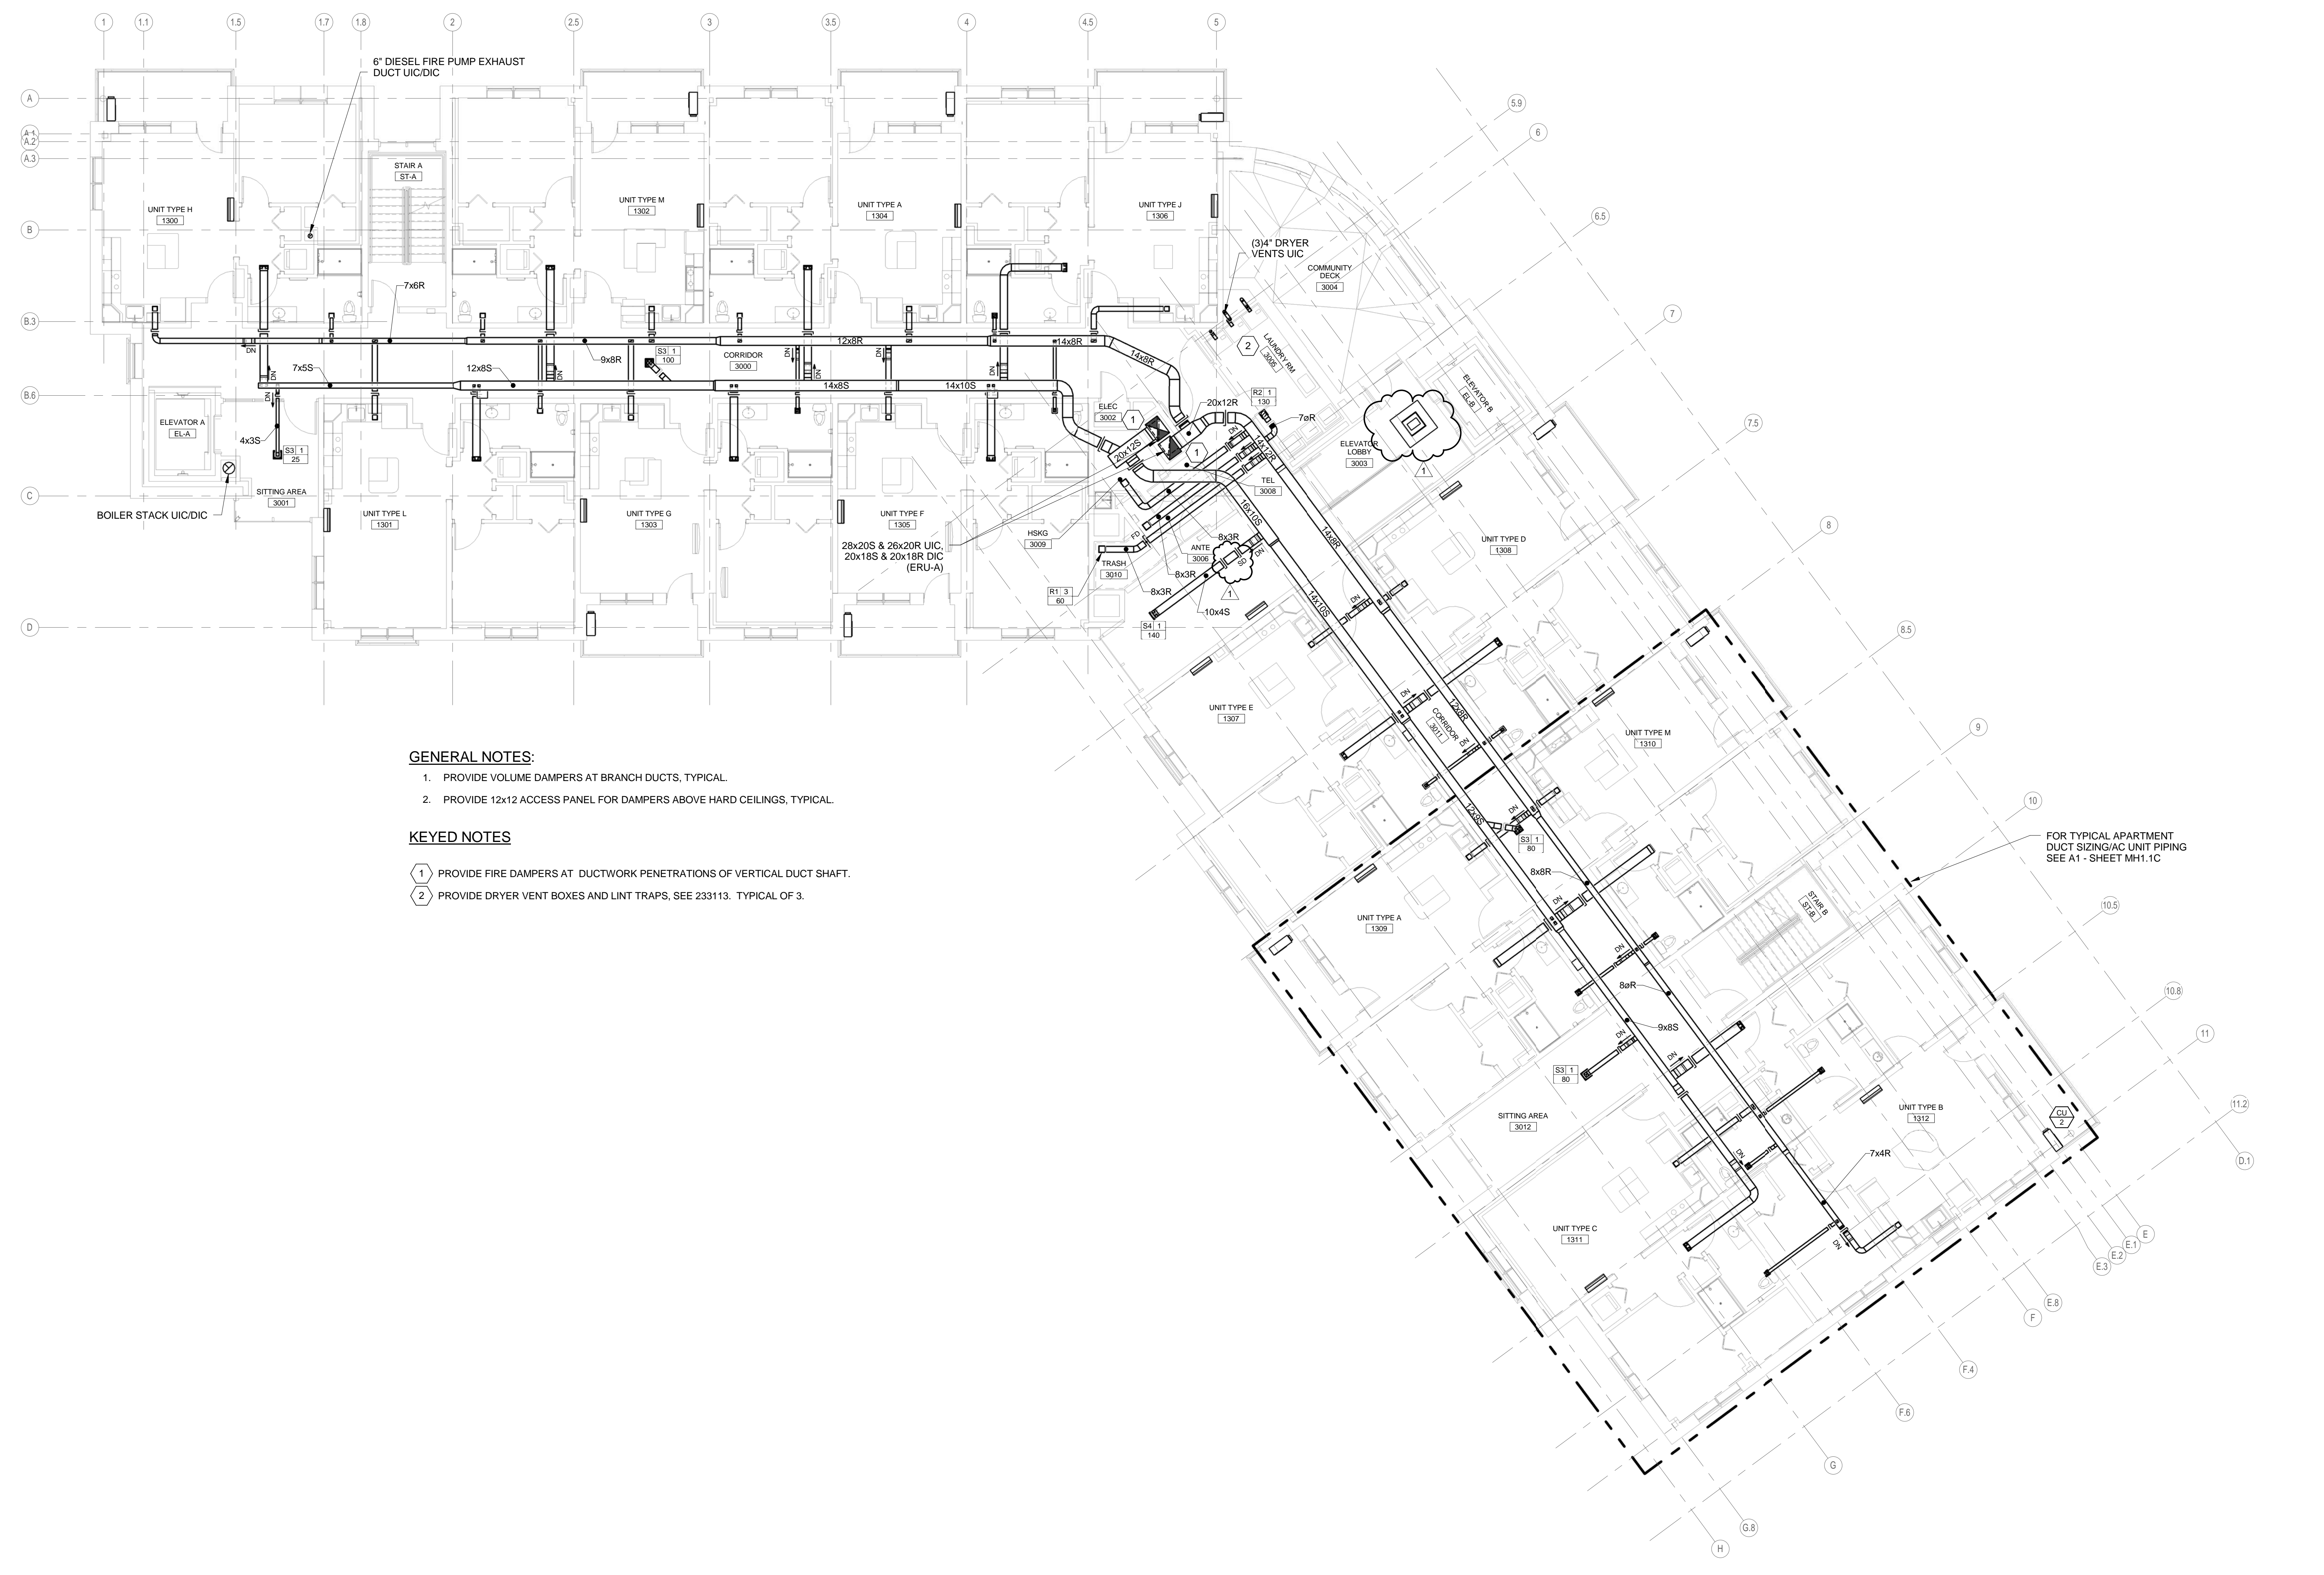

- GENERAL NOTES:**
1. PROVIDE VOLUME DAMPERS AT BRANCH DUCTS, TYPICAL.
 2. PROVIDE 12x12 ACCESS PANEL FOR DAMPERS ABOVE HARD CEILINGS, TYPICAL.
- KEYED NOTES**
- (1) PROVIDE FIRE DAMPERS AT DUCTWORK PENETRATIONS OF VERTICAL DUCT SHAFT.
 - (2) PROVIDE DRYER VENT BOXES AND LINT TRAPS, SEE 233113, TYPICAL OF 3.

6/29/2015 9:15:51 AM N:\Projects\2015\161018 - Park Danforth\161018.dwg REV: 20151008\Rev