


160 Veranda Street
 Portland, Maine 04103
 T: 207.221.2340
 F: 207.221.2346
 Web: www.allied-eng.com

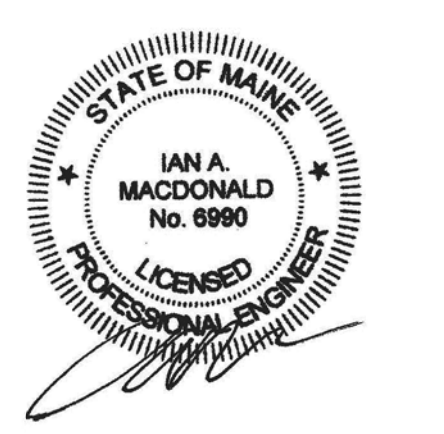


Graphic Scale: 1" = 10' 0" 1"


The Park Danforth

777 Stevens Ave, Portland, ME, 04103

NO.	DESCRIPTION	DATE
1	Addendum No. 2	2015-06-25

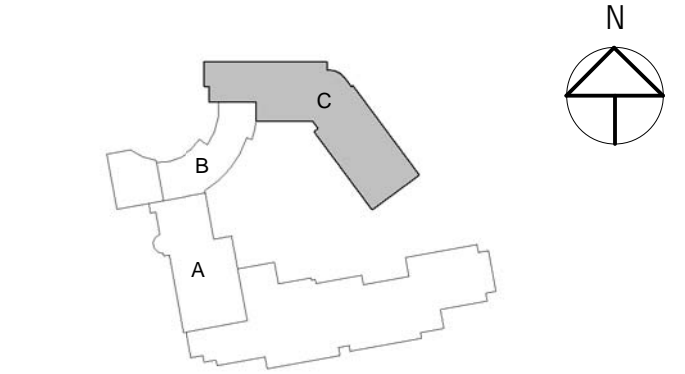

CONTENT: MECHANICAL PLAN - LEVEL 4 - NEW BUILDING	
DRAWN BY:	REW
PROJECT NO.:	-
DATE:	06/05/2015
REVISED:	-
SCALE:	AS NOTED
<h1>MH1.4C</h1>	
Project Phase: 100% CONSTRUCTION DOCUMENTS	
<small>COPYRIGHT © 2014 BY LAVALLEE BRENSINGER PROFESSIONAL ASSOCIATION. ALL RIGHTS RESERVED. NO REPRODUCTION WITHOUT PERMISSION.</small>	

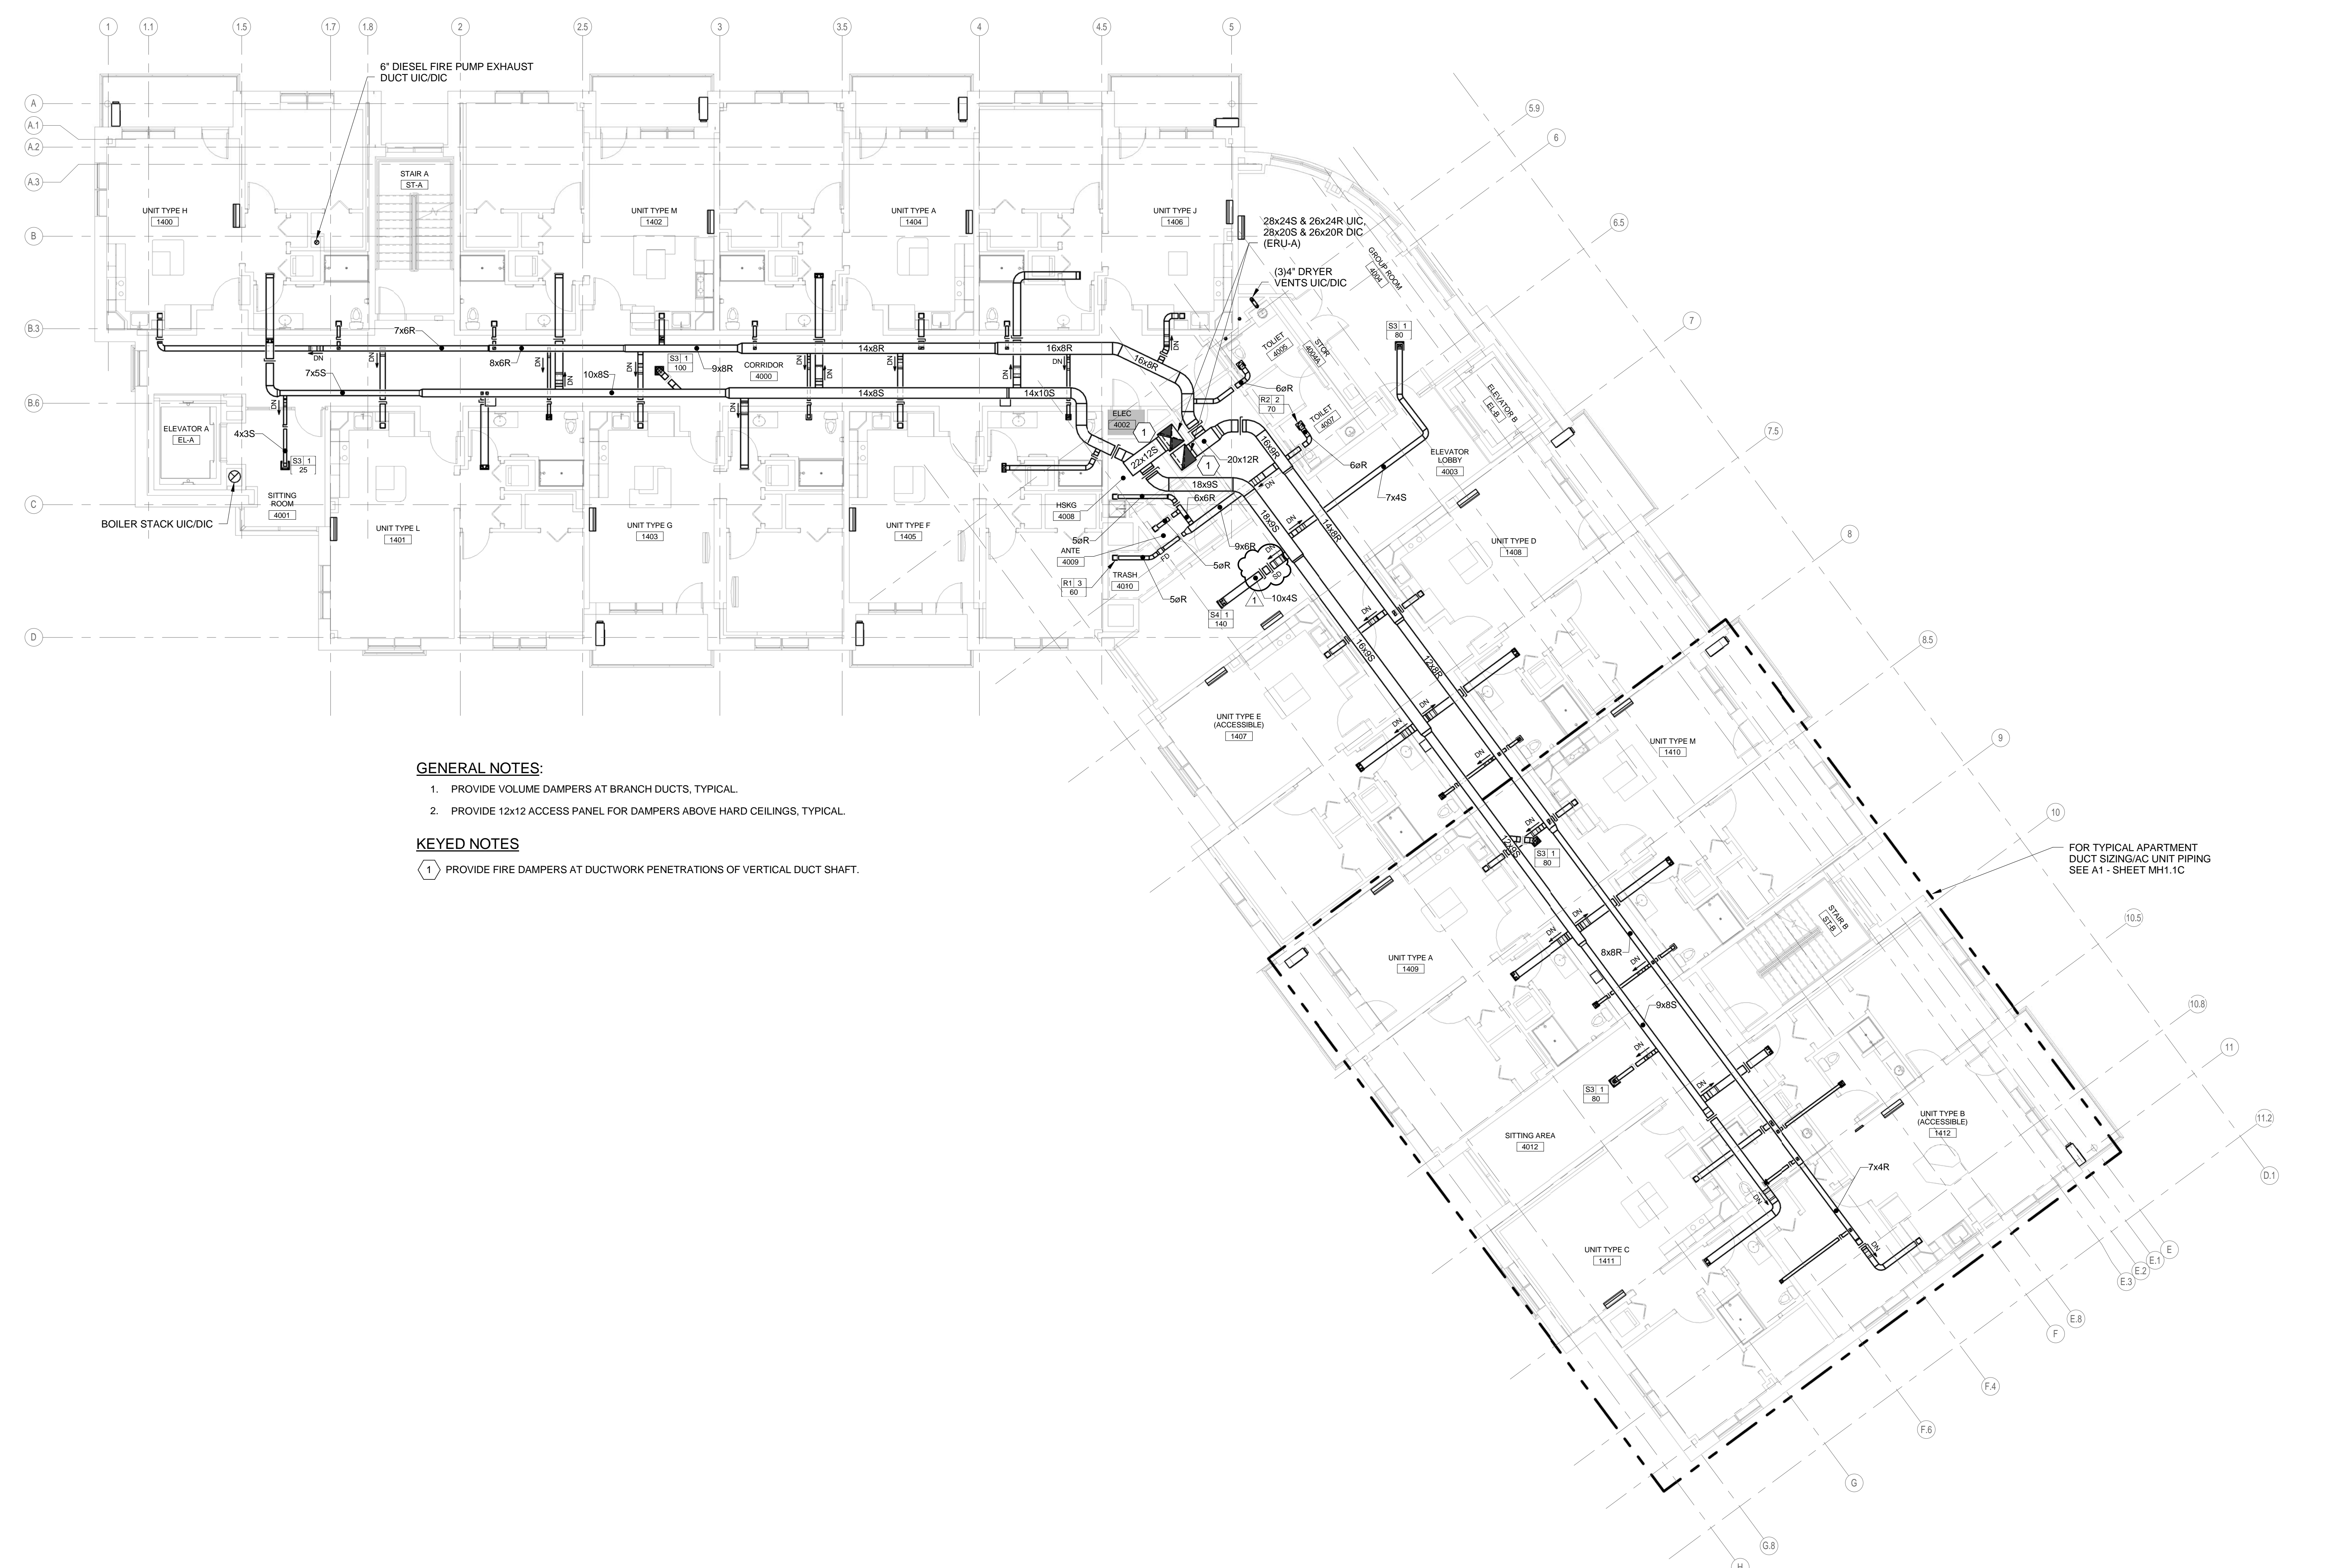

- GENERAL NOTES:**
1. PROVIDE VOLUME DAMPERS AT BRANCH DUCTS, TYPICAL.
 2. PROVIDE 12x12 ACCESS PANEL FOR DAMPERS ABOVE HARD CEILINGS, TYPICAL.
- KEYED NOTES**
- 1 PROVIDE FIRE DAMPERS AT DUCTWORK PENETRATIONS OF VERTICAL DUCT SHAFT.

6/29/2015 9:20:39 AM N:\Projects\2015\141018 - Park Danforth\00 Drawing files - REV\17 2015\141018.dwg