


160 Veranda Street
 Portland, Maine 04103
 T: 207.221.2240
 F: 207.221.2246
 Web: www.allied-eng.com

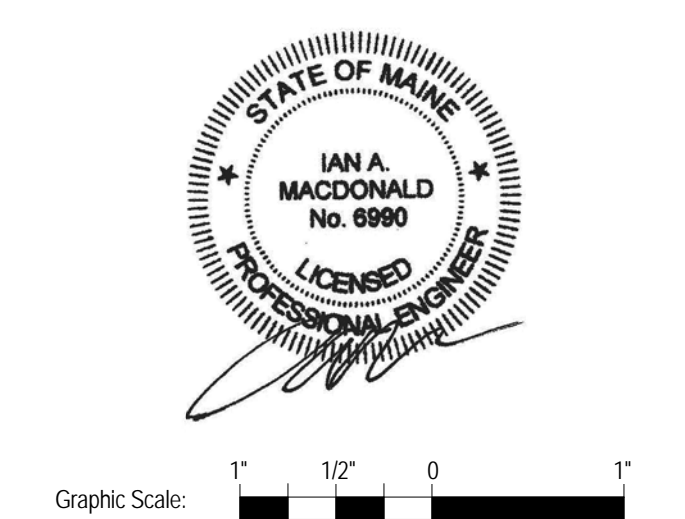


Graphic Scale: 1" = 10' 0"


The Park Danforth

777 Stevens Ave, Portland, ME, 04103

NO.	DESCRIPTION	DATE

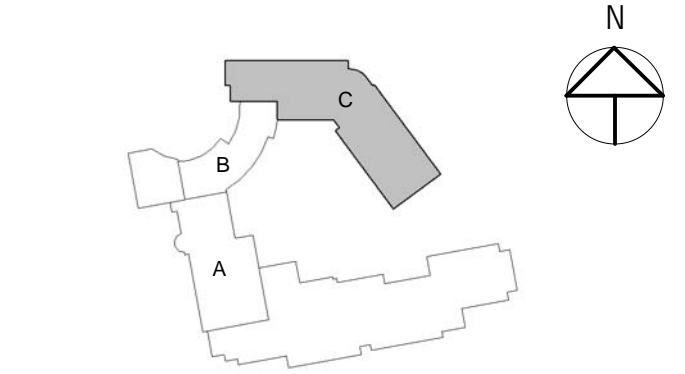

CONTENT: MECHANICAL PLAN - ROOF - NEW BUILDING	
DRAWN BY:	REW
PROJECT NO.:	-
DATE:	06/05/2015
REVISED:	-
SCALE:	AS NOTED
MH1.6C	
Project Phase 100% CONSTRUCTION DOCUMENTS	
<small>COPYRIGHT © 2014 BY LAVALLEE BRENSINGER PROFESSIONAL ASSOCIATION. ALL RIGHTS RESERVED. NO REPRODUCTION WITHOUT PERMISSION.</small>	

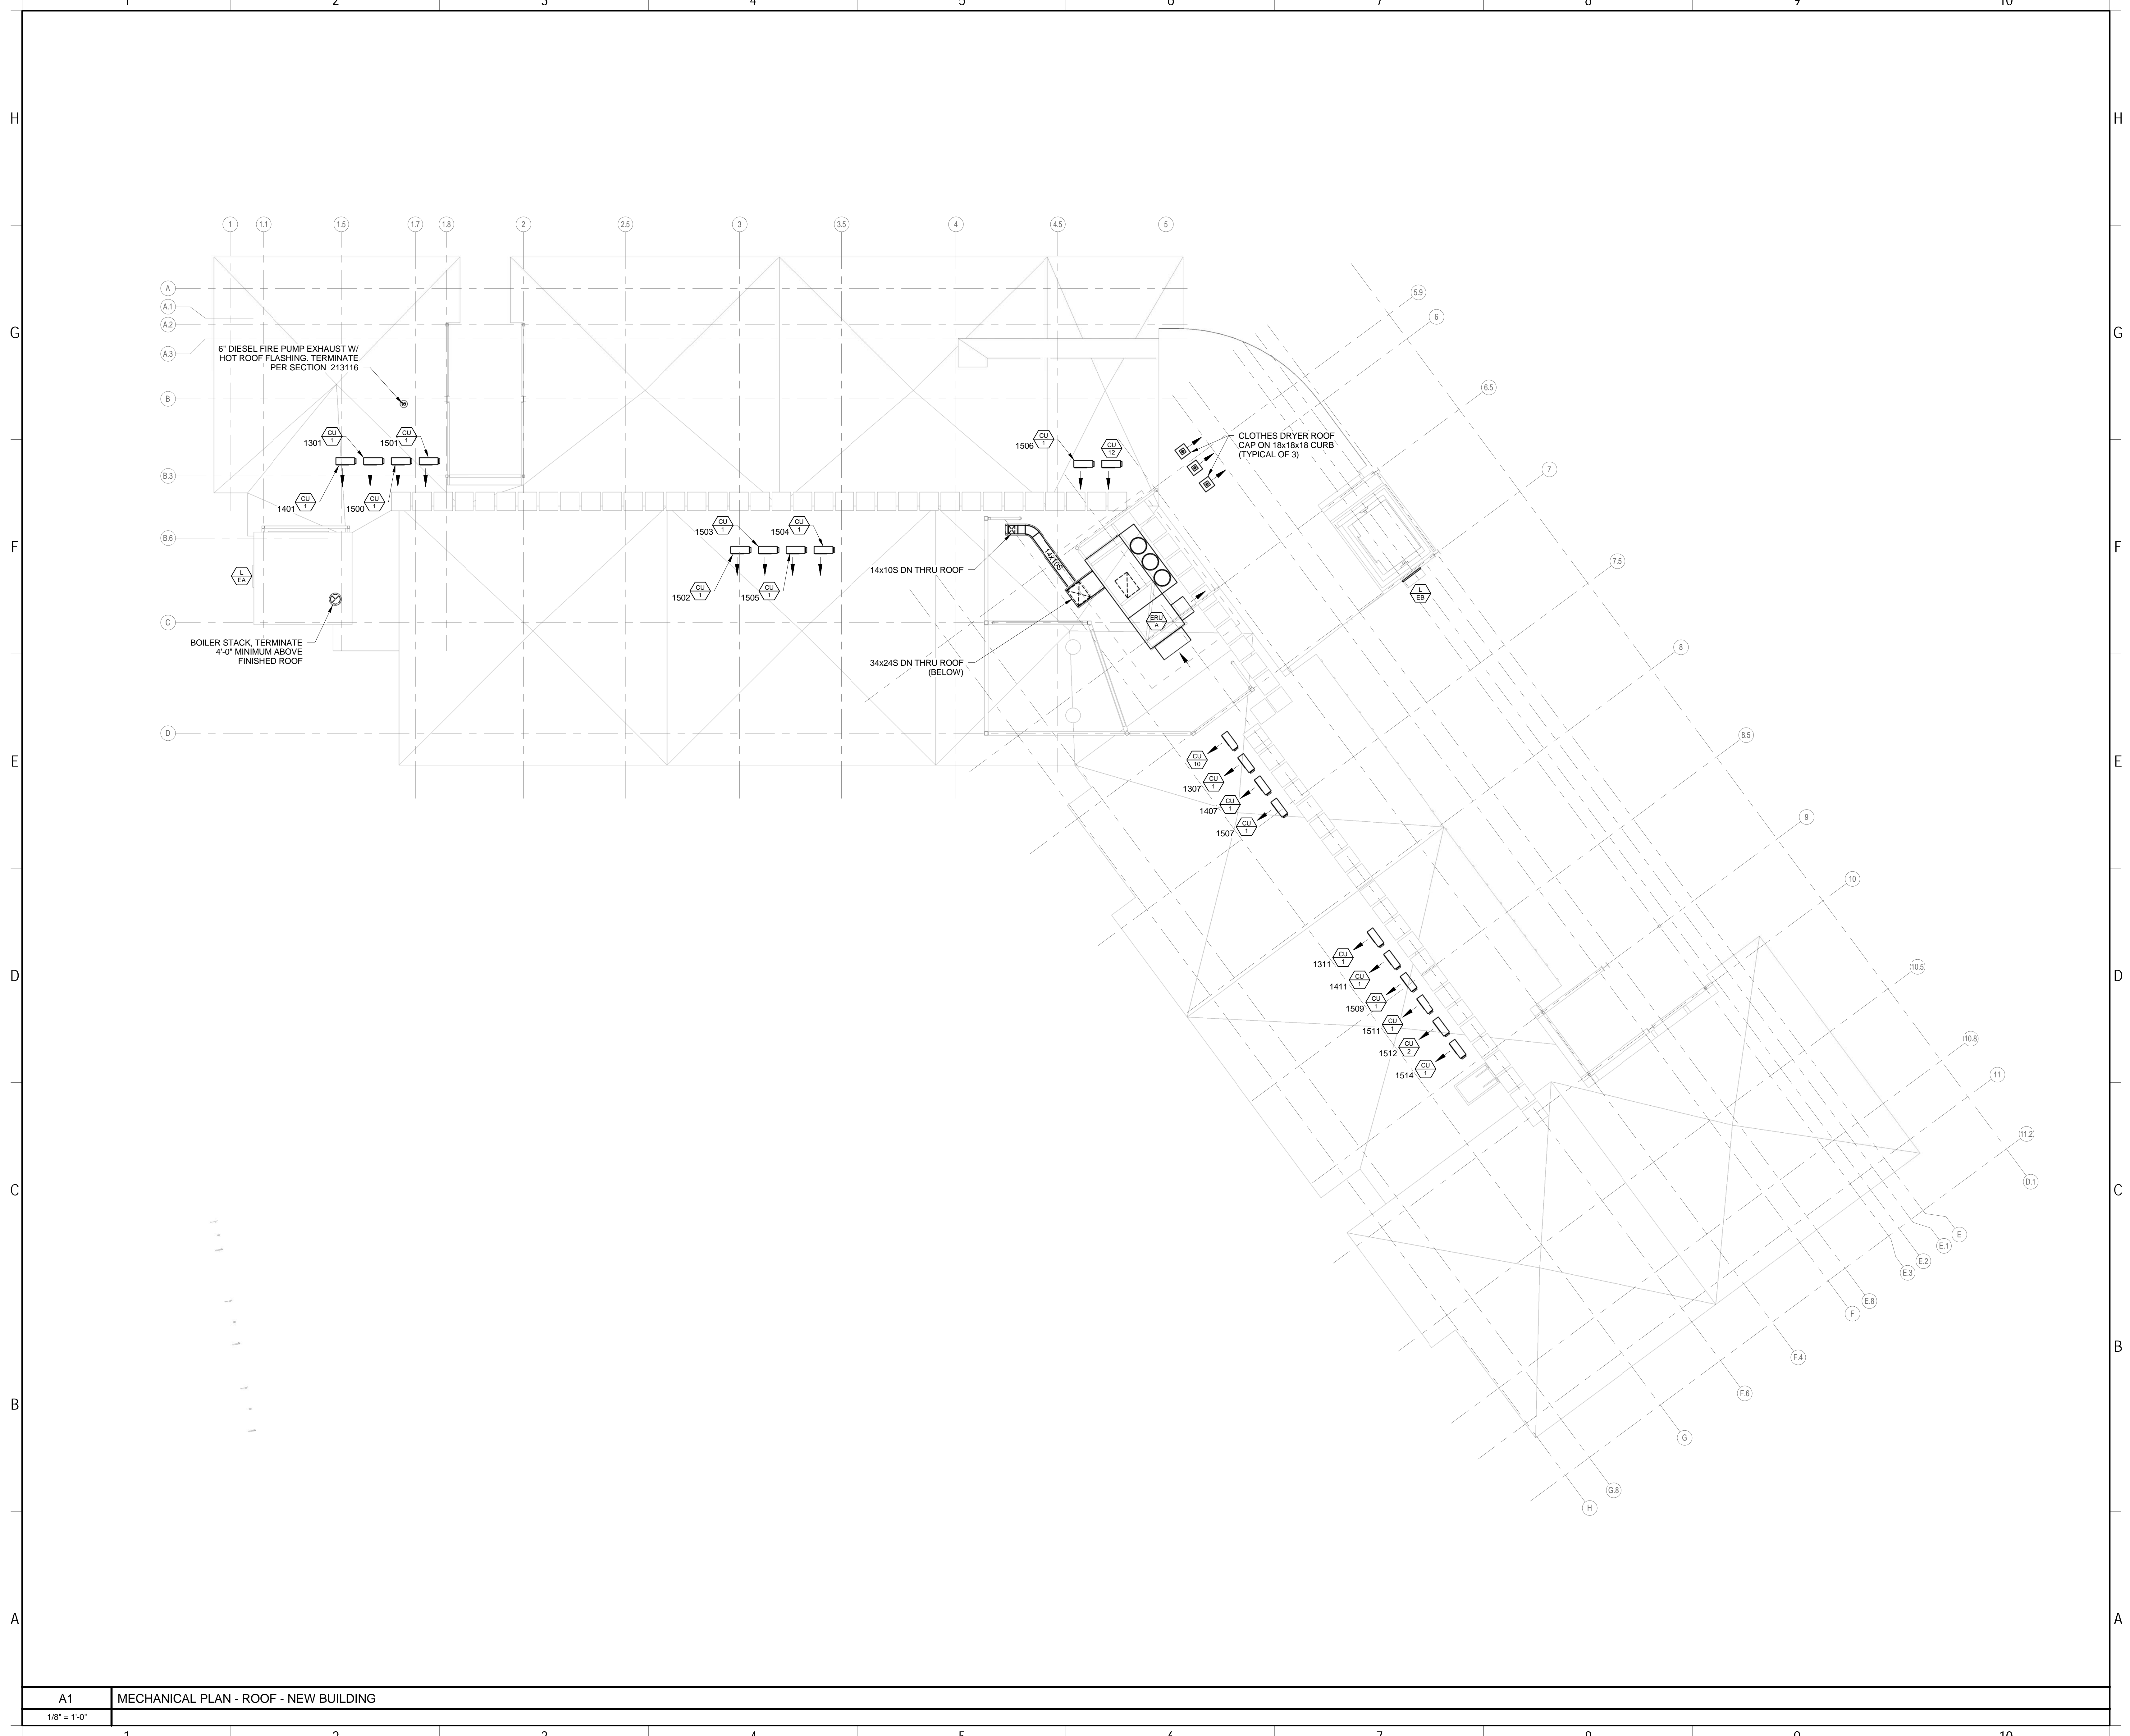

6/29/2015 9:25:42 AM N:\Projects\2015\101018 - Park Danforth\100 Drawing Files - REV\101018\101018.dwg

A1 MECHANICAL PLAN - ROOF - NEW BUILDING
 1/8" = 1'-0"