

160 Veranda Street  
 Portland, Maine 04103  
 T: 207.221.2240  
 F: 207.221.2246  
 Web: www.allied-eng.com



Graphic Scale: 1" = 0' 10" 0 1'


The Park Danforth

777 Stevens Ave, Portland, ME, 04103

NO.	DESCRIPTION	DATE




CONTENT:	
MECHANICAL DETAILS	
DRAWN BY:	REW
PROJECT NO:	
DATE:	06/05/2015
REVISED:	
SCALE:	AS NOTED
<b>MH5.0</b>	
Project Phase	
100% CONSTRUCTION DOCUMENTS	
<small>COPYRIGHT © 2014 BY LAVALLEE BRENSINGER PROFESSIONAL ASSOCIATION. ALL RIGHTS RESERVED. NO REPRODUCTION WITHOUT PERMISSION.</small>	

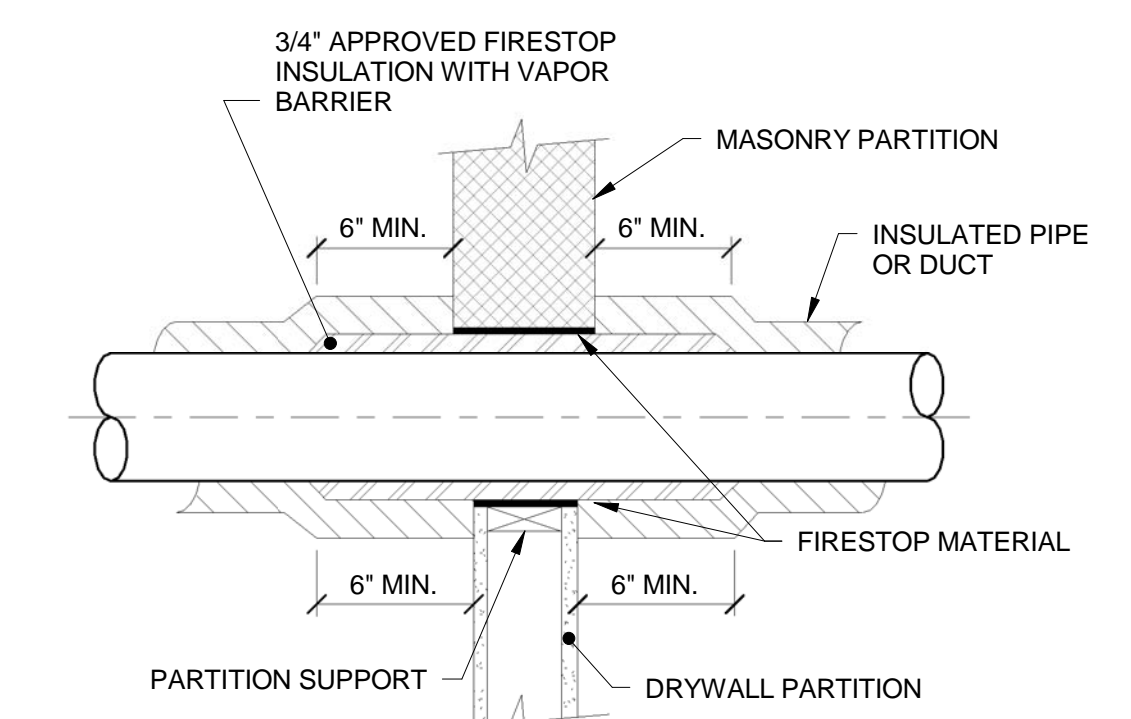


**PARTITION OR CHASE PENETRATION**

**NOTE:**  
 APPLICABLE TO PENETRATIONS OF ALL FIRE RATED MEMBRANES. REFER TO SPECIFICATION DIVISION 7, FIRE STOPPING SYSTEM.

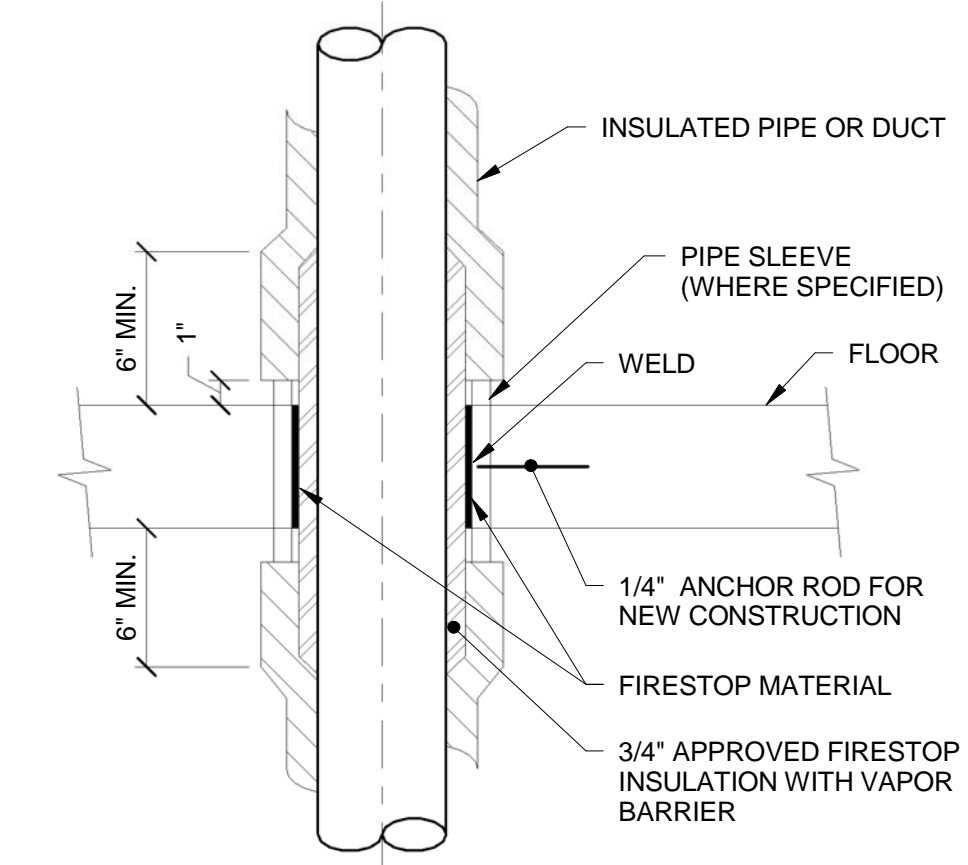


**FLOOR OR DECK PENETRATION**


**E9 DETAIL - PIPE - DUCT PENETRATIONS**  
 NOT TO SCALE

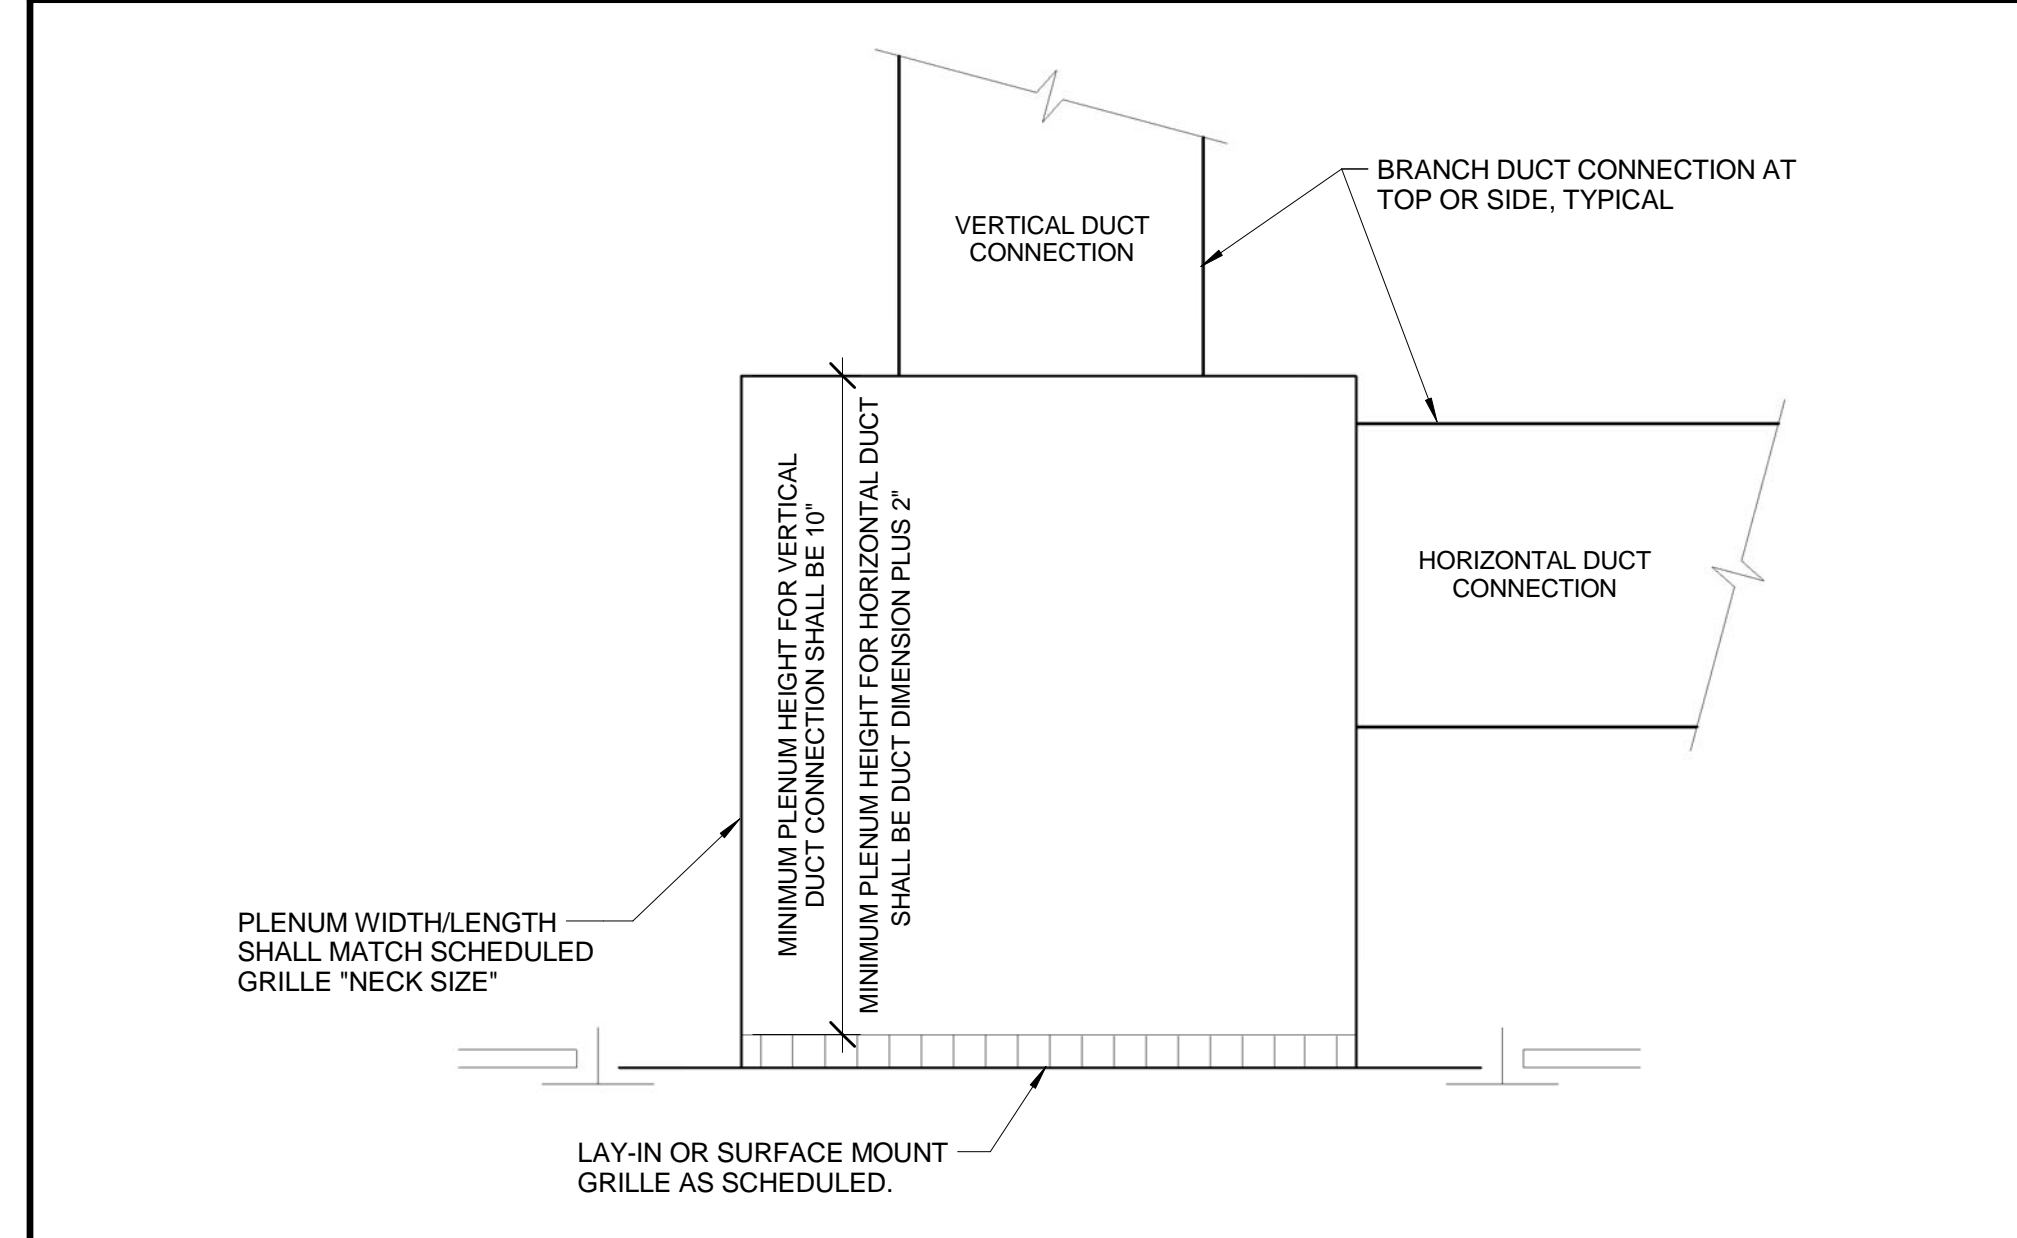


**C4 DETAIL - SUPPLY/RETURN AIR REGISTER BOOT**  
 NOT TO SCALE

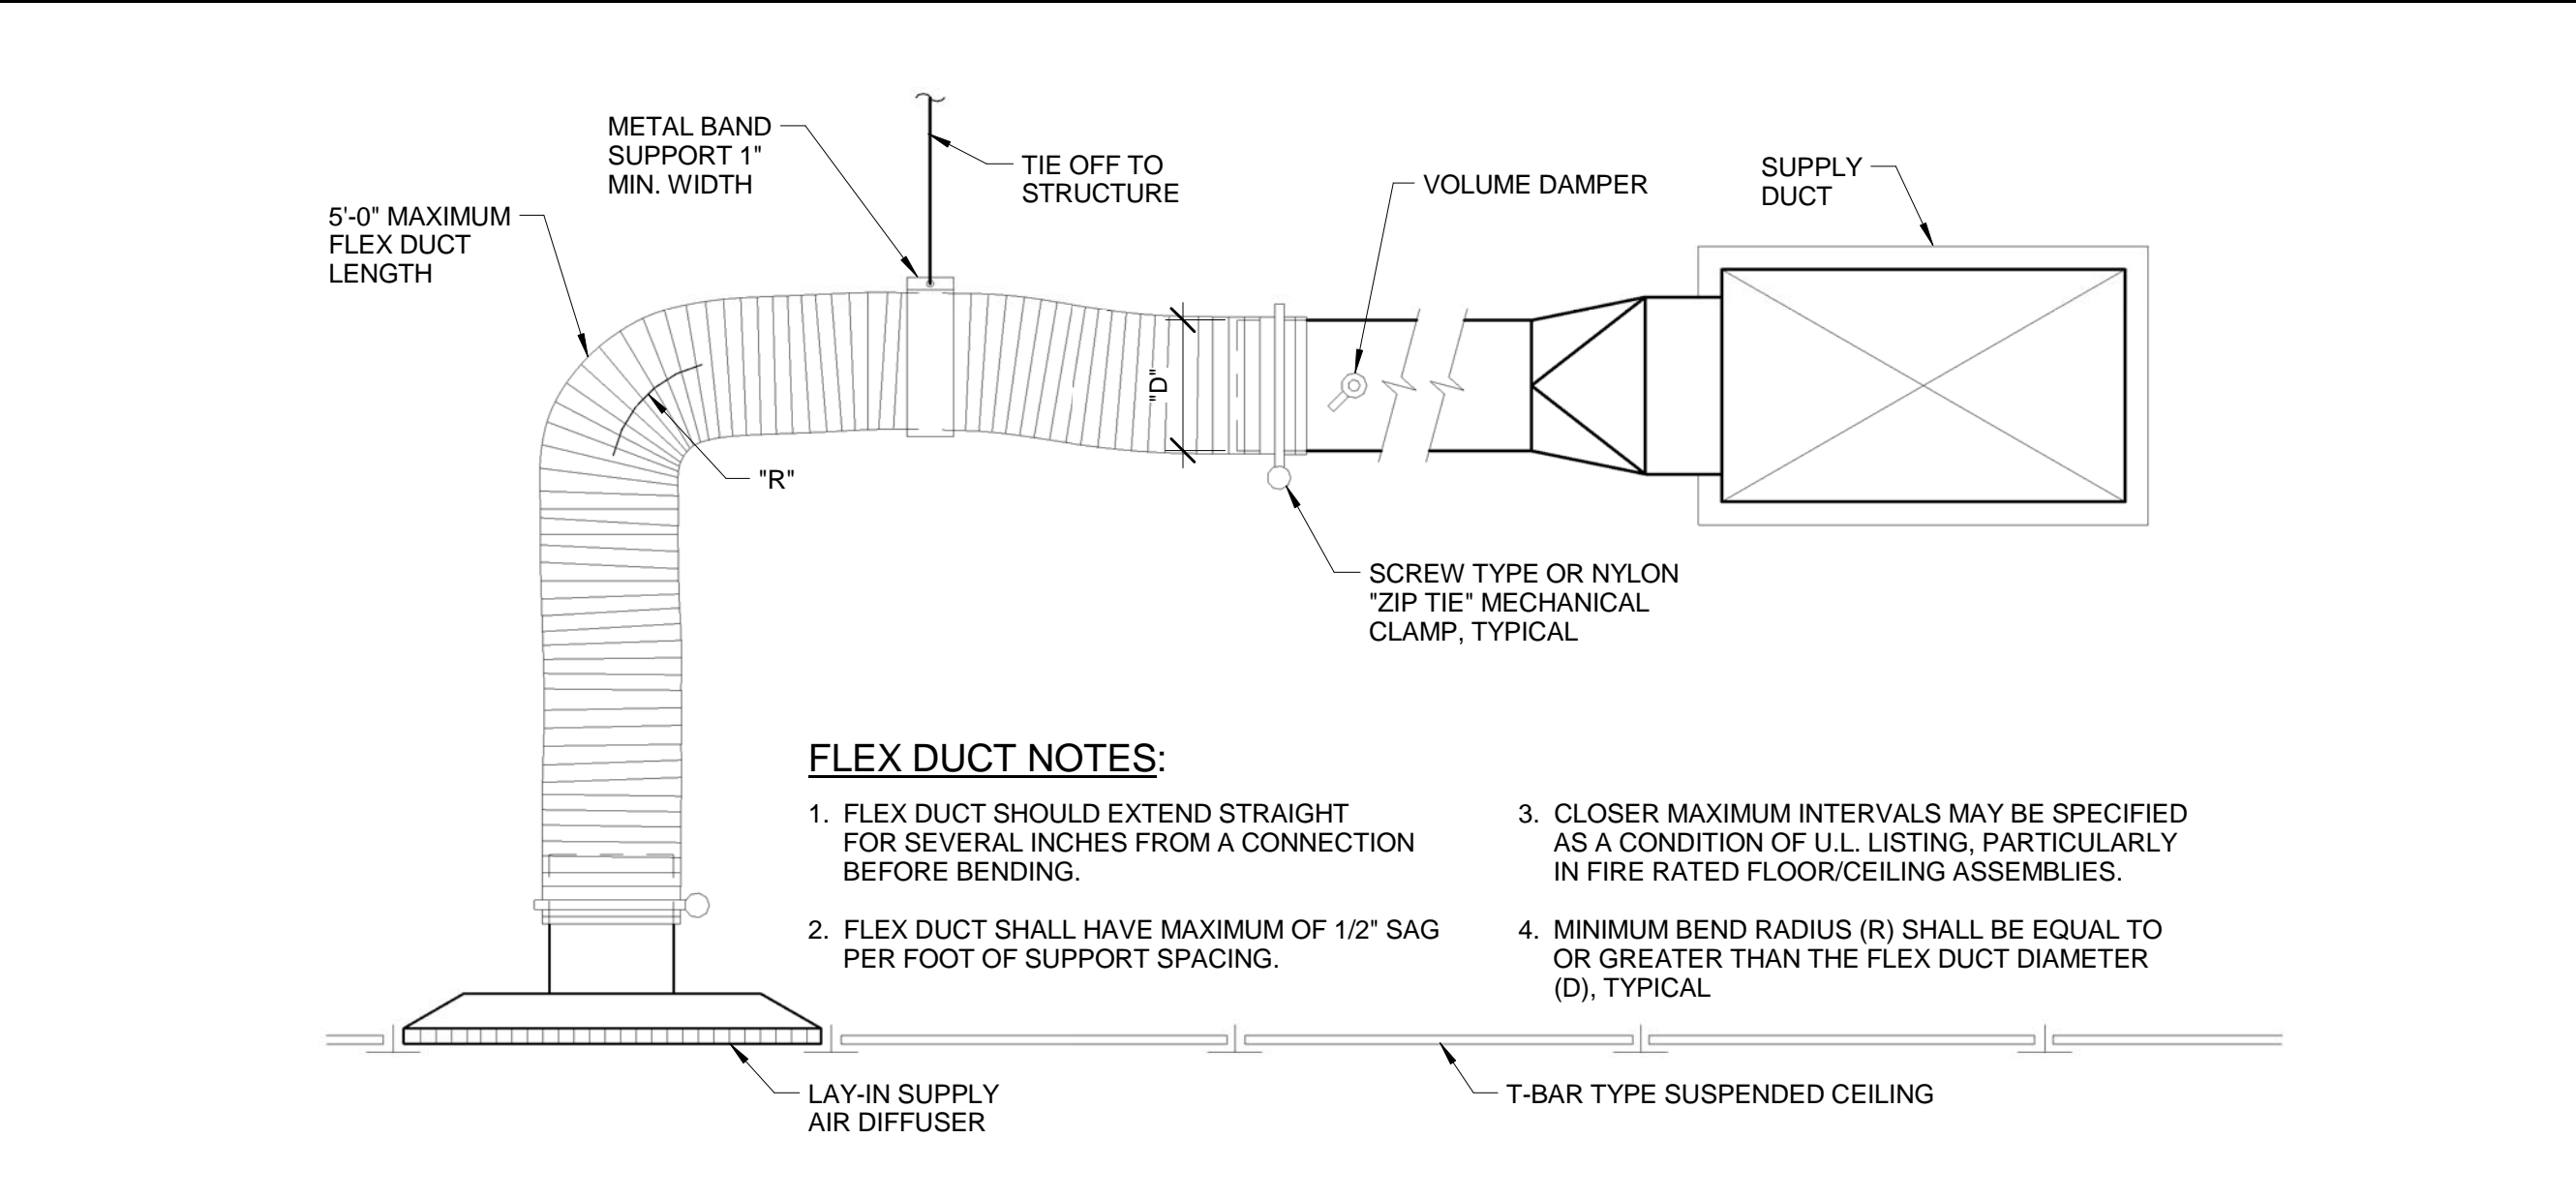

**C7 DETAIL - SUPPLY AIR BRANCH CONNECTION**  
 NOT TO SCALE

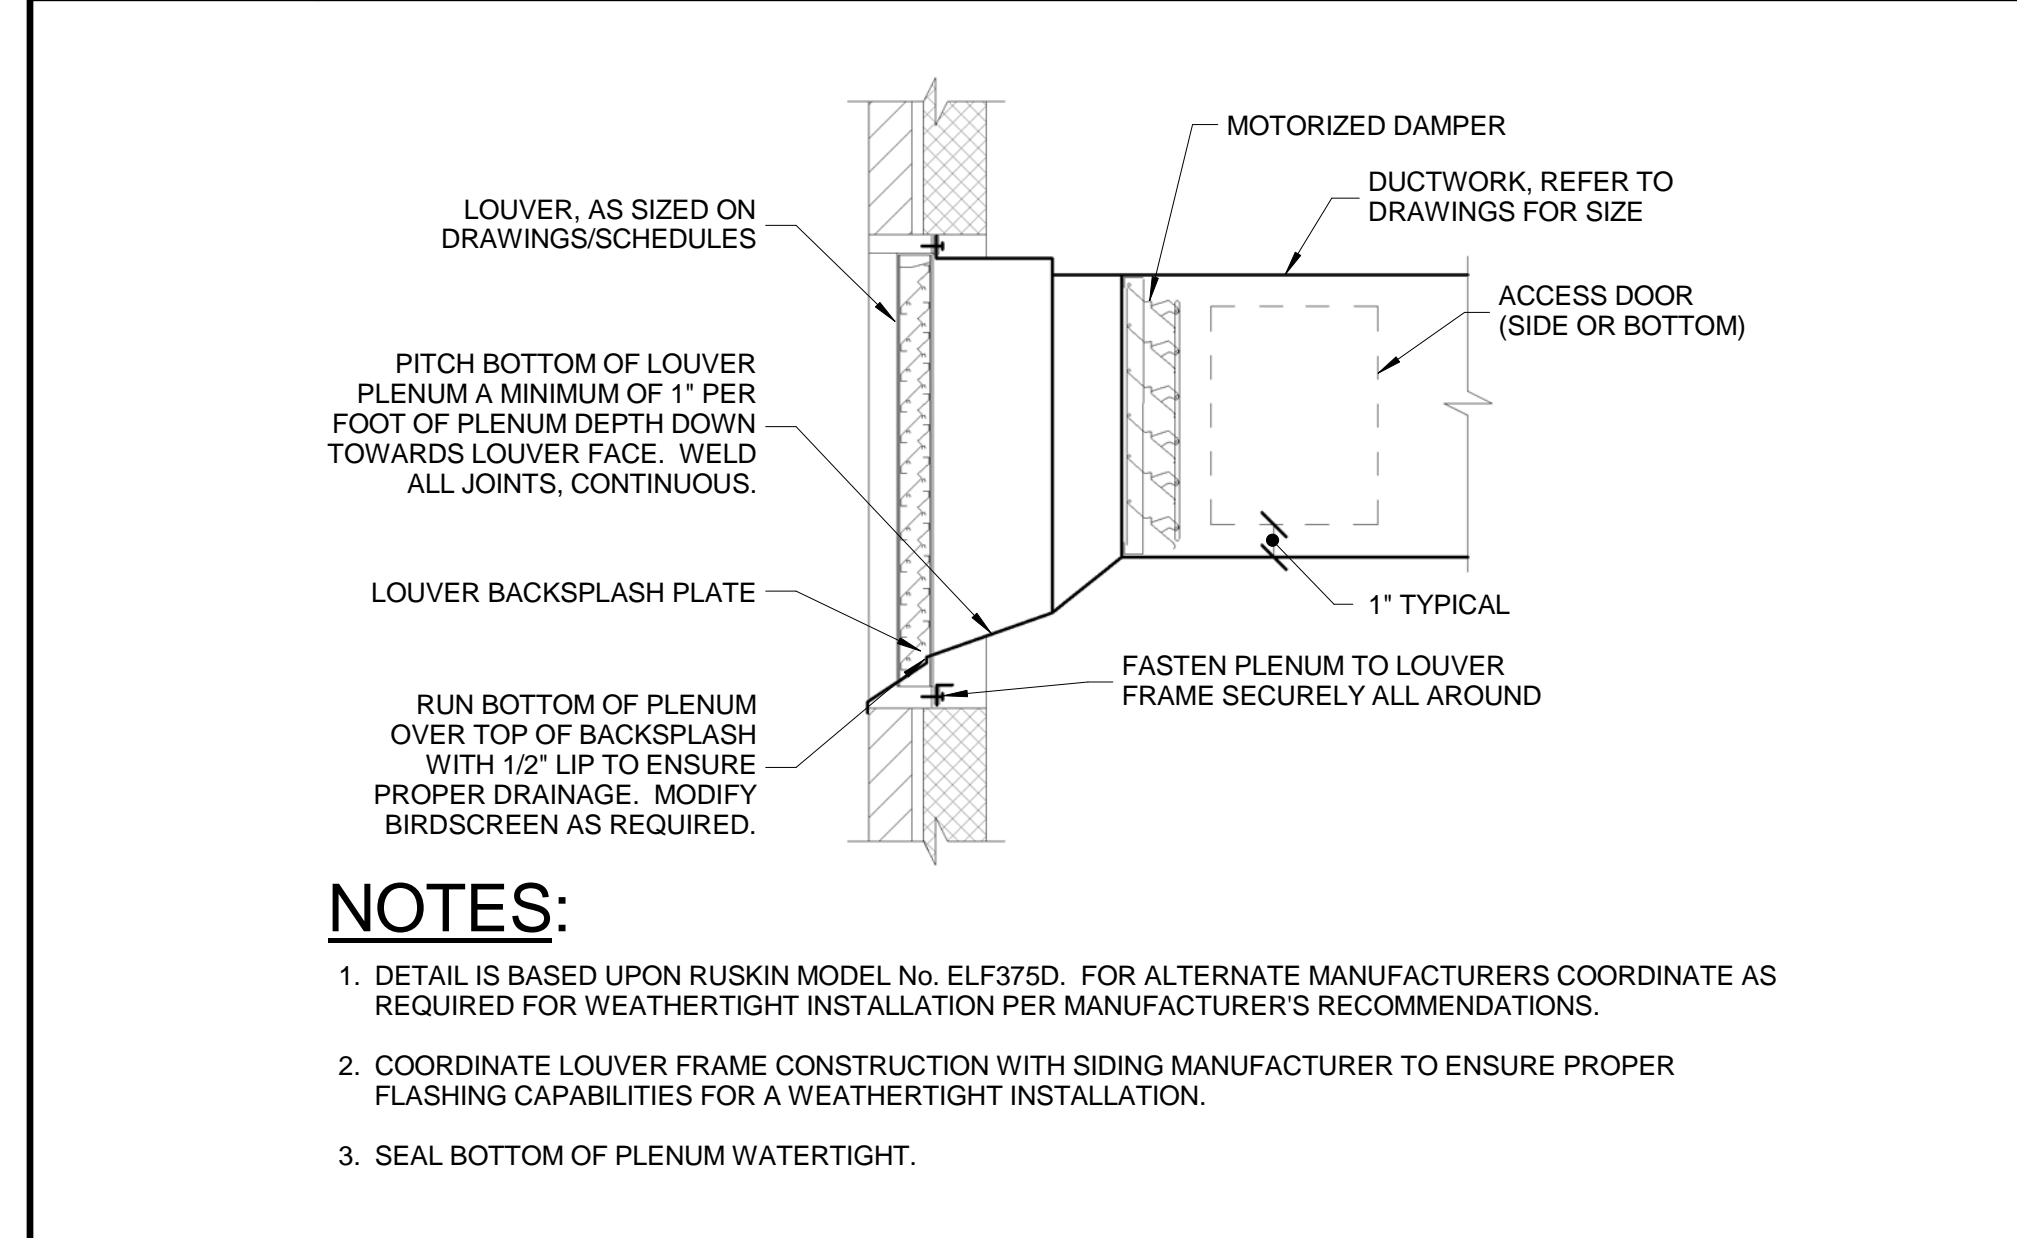

**A4 DETAIL - EXTERIOR LOUVER**  
 NOT TO SCALE

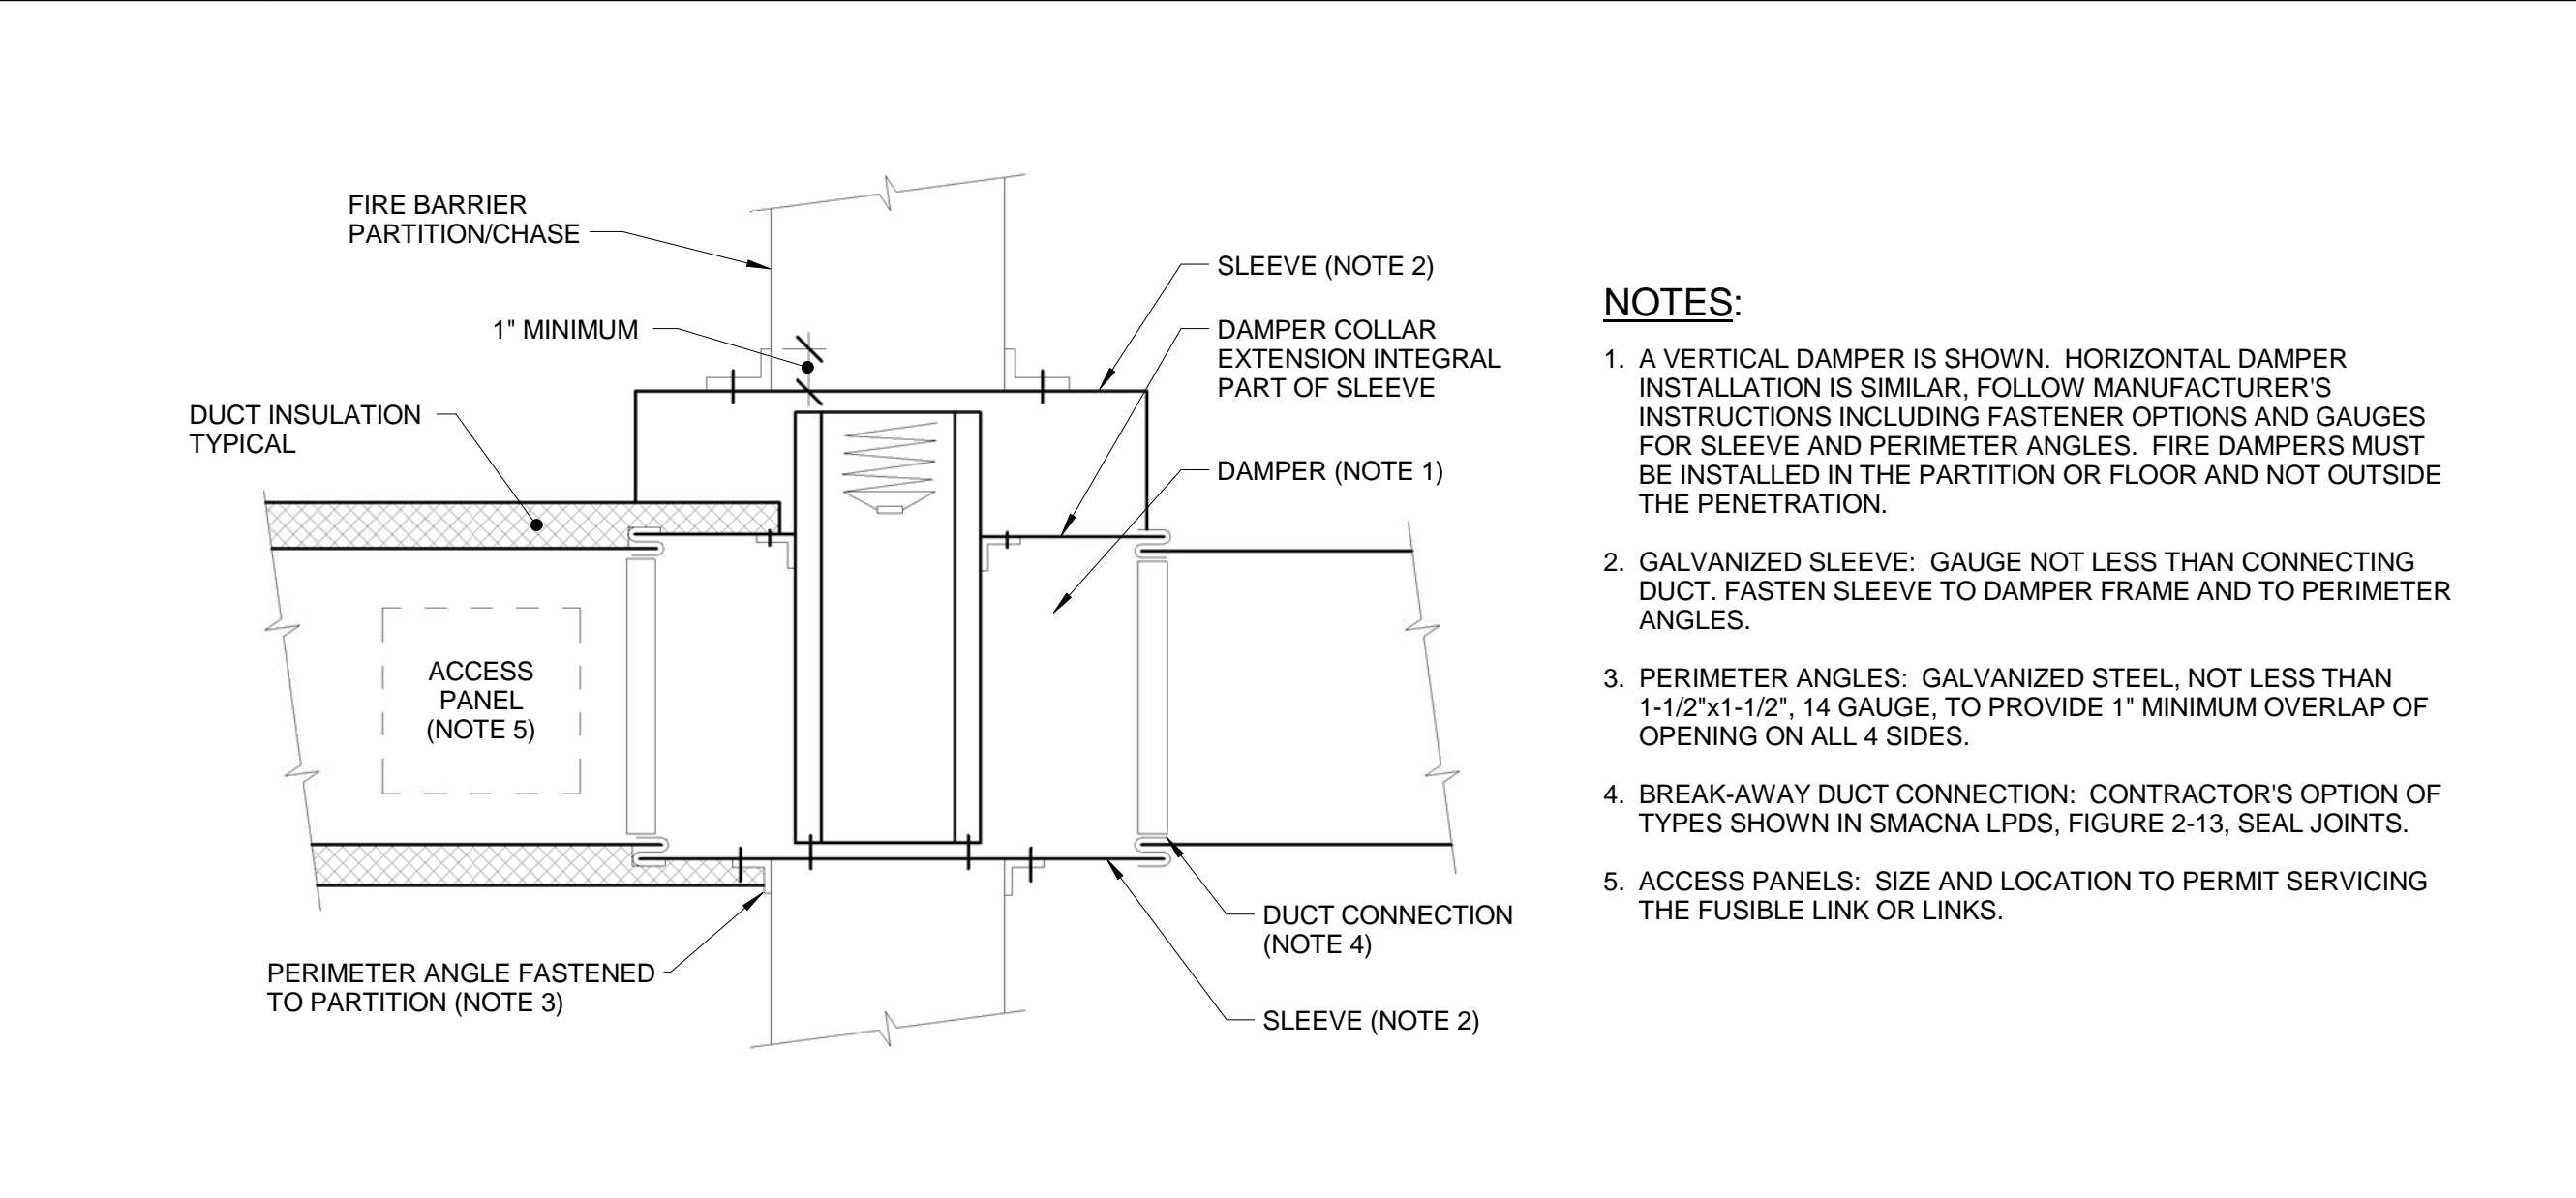

**A7 DETAIL - TYPICAL FIRE DAMPER**  
 NOT TO SCALE

N:\Projects\2015\10-1018 - Park Danforth\100 Drawing Files - REV\17 2015\1018.dwg  
 6/26/2015 9:27:01 AM