


160 Veranda Street
 Portland, Maine 04103
 T: 207.221.2240
 F: 207.221.2246
 Web: www.allied-eng.com

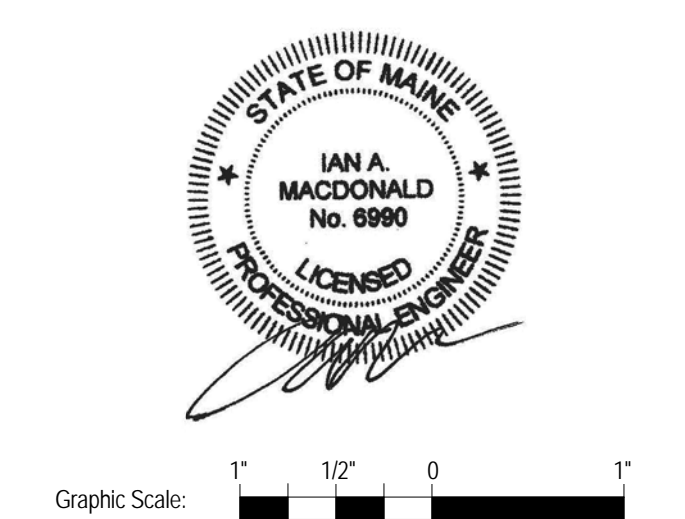


Graphic Scale: 1" = 10' 0"


The Park Danforth

777 Stevens Ave, Portland, ME, 04103

NO.	DESCRIPTION	DATE
1	Addendum No. 2	2015-06-25

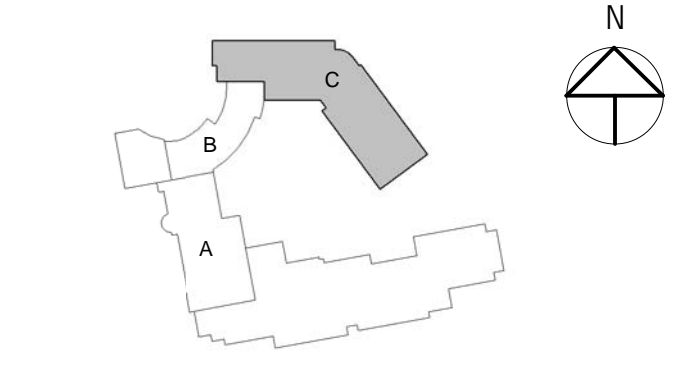

CONTENT: MECHANICAL PIPING PLAN - GARAGE LEVEL	
DRAWN BY:	REW
PROJECT NO.:	-
DATE:	06/05/2015
REVISED:	-
SCALE:	AS NOTED
MP1.0C	
Project Phase 100% CONSTRUCTION DOCUMENTS	
COPYRIGHT © 2014 BY LAVALLEE BRENSINGER PROFESSIONAL ASSOCIATION. ALL RIGHTS RESERVED. NO REPRODUCTION WITHOUT PERMISSION.	

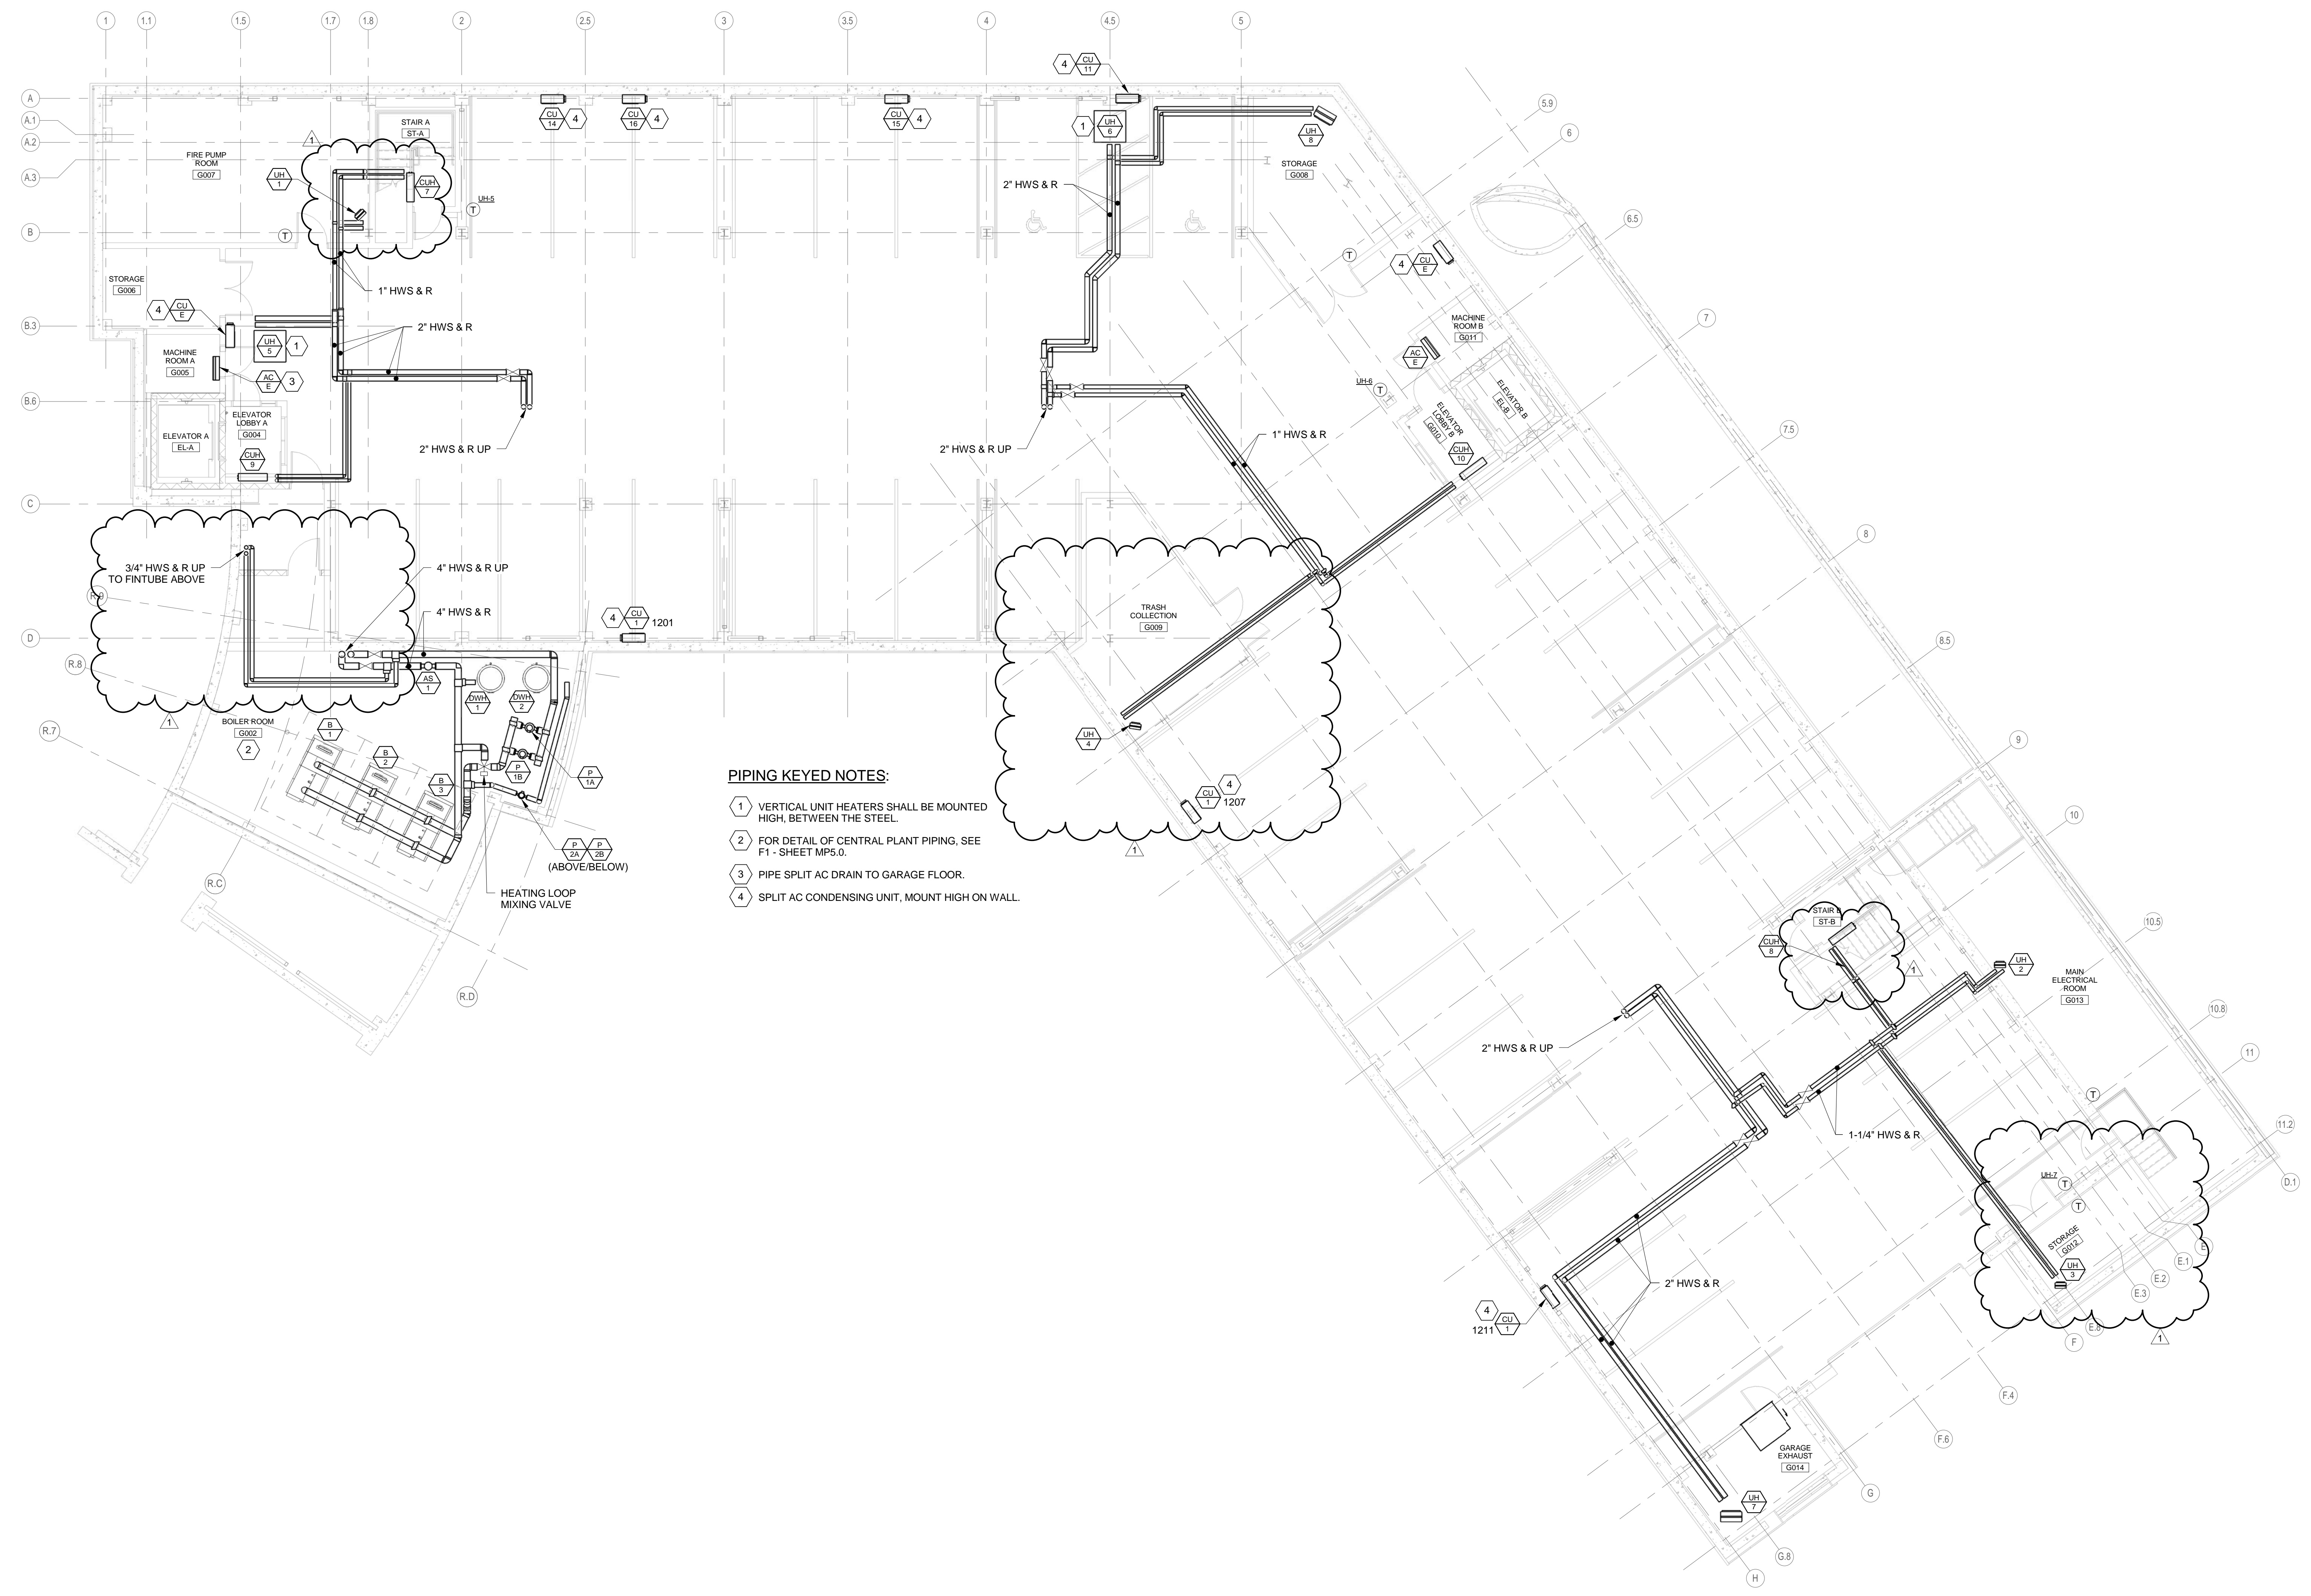

- PIPING KEYED NOTES:**
- 1 VERTICAL UNIT HEATERS SHALL BE MOUNTED HIGH, BETWEEN THE STEEL.
 - 2 FOR DETAIL OF CENTRAL PLANT PIPING, SEE F1 - SHEET MP5.0.
 - 3 PIPE SPLIT AC DRAIN TO GARAGE FLOOR.
 - 4 SPLIT AC CONDENSING UNIT, MOUNT HIGH ON WALL.

6/29/2015 9:26:02 AM N:\Projects\2015\161-0418 - Park Danforth\100 Drawing Files - REV\17 20151610BIM.dwg