

160 Veranda Street
 Portland, Maine 04103
 T: 207.221.2240
 F: 207.221.2246
 Web: www.allied-eng.com




Graphic Scale: 1" = 10'-0" 1" = 5'-0" 1" = 1'-0"

The Park Danforth

777 Stevens Ave, Portland, ME, 04103


NO.	DESCRIPTION	DATE
1	Addendum No. 2	2015-06-25

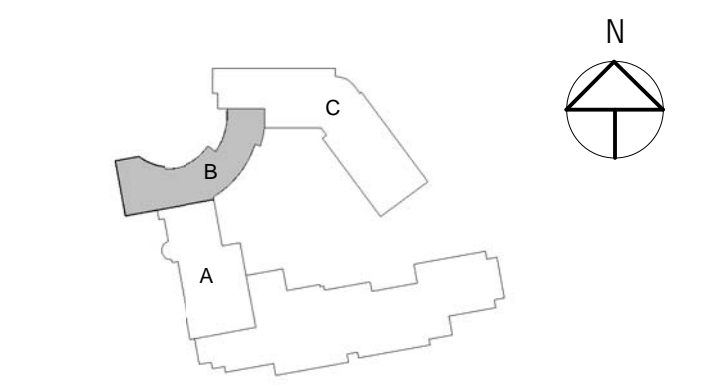

CONTENT:	
MECHANICAL PIPING PLAN - LEVEL 1 - AUDITORIUM & CONNECTOR	
DRAWN BY:	REW
PROJECT NO.:	-
DATE:	06/05/2015
REVISED:	
SCALE:	AS NOTED
MP1.1B	
Project Phase	
100% CONSTRUCTION DOCUMENTS	
<small>COPYRIGHT © 2014 BY LAVALLEE BRENSINGER PROFESSIONAL ASSOCIATION. ALL RIGHTS RESERVED. NO REPRODUCTION WITHOUT PERMISSION.</small>	

PIPING KEYED NOTES:

- 1 PIPE GRAVITY AC DRAIN TO NEAREST SINK TRAP.
- 2 PIPE PUMPED AC DRAIN TO NEAREST SINK TRAP.
- 3 PIPE GRAVITY AC DRAIN TO FLOOR DRAIN IN MECH ROOM BELOW.
- 4 ERU-B TEMPERATURE SENSOR.

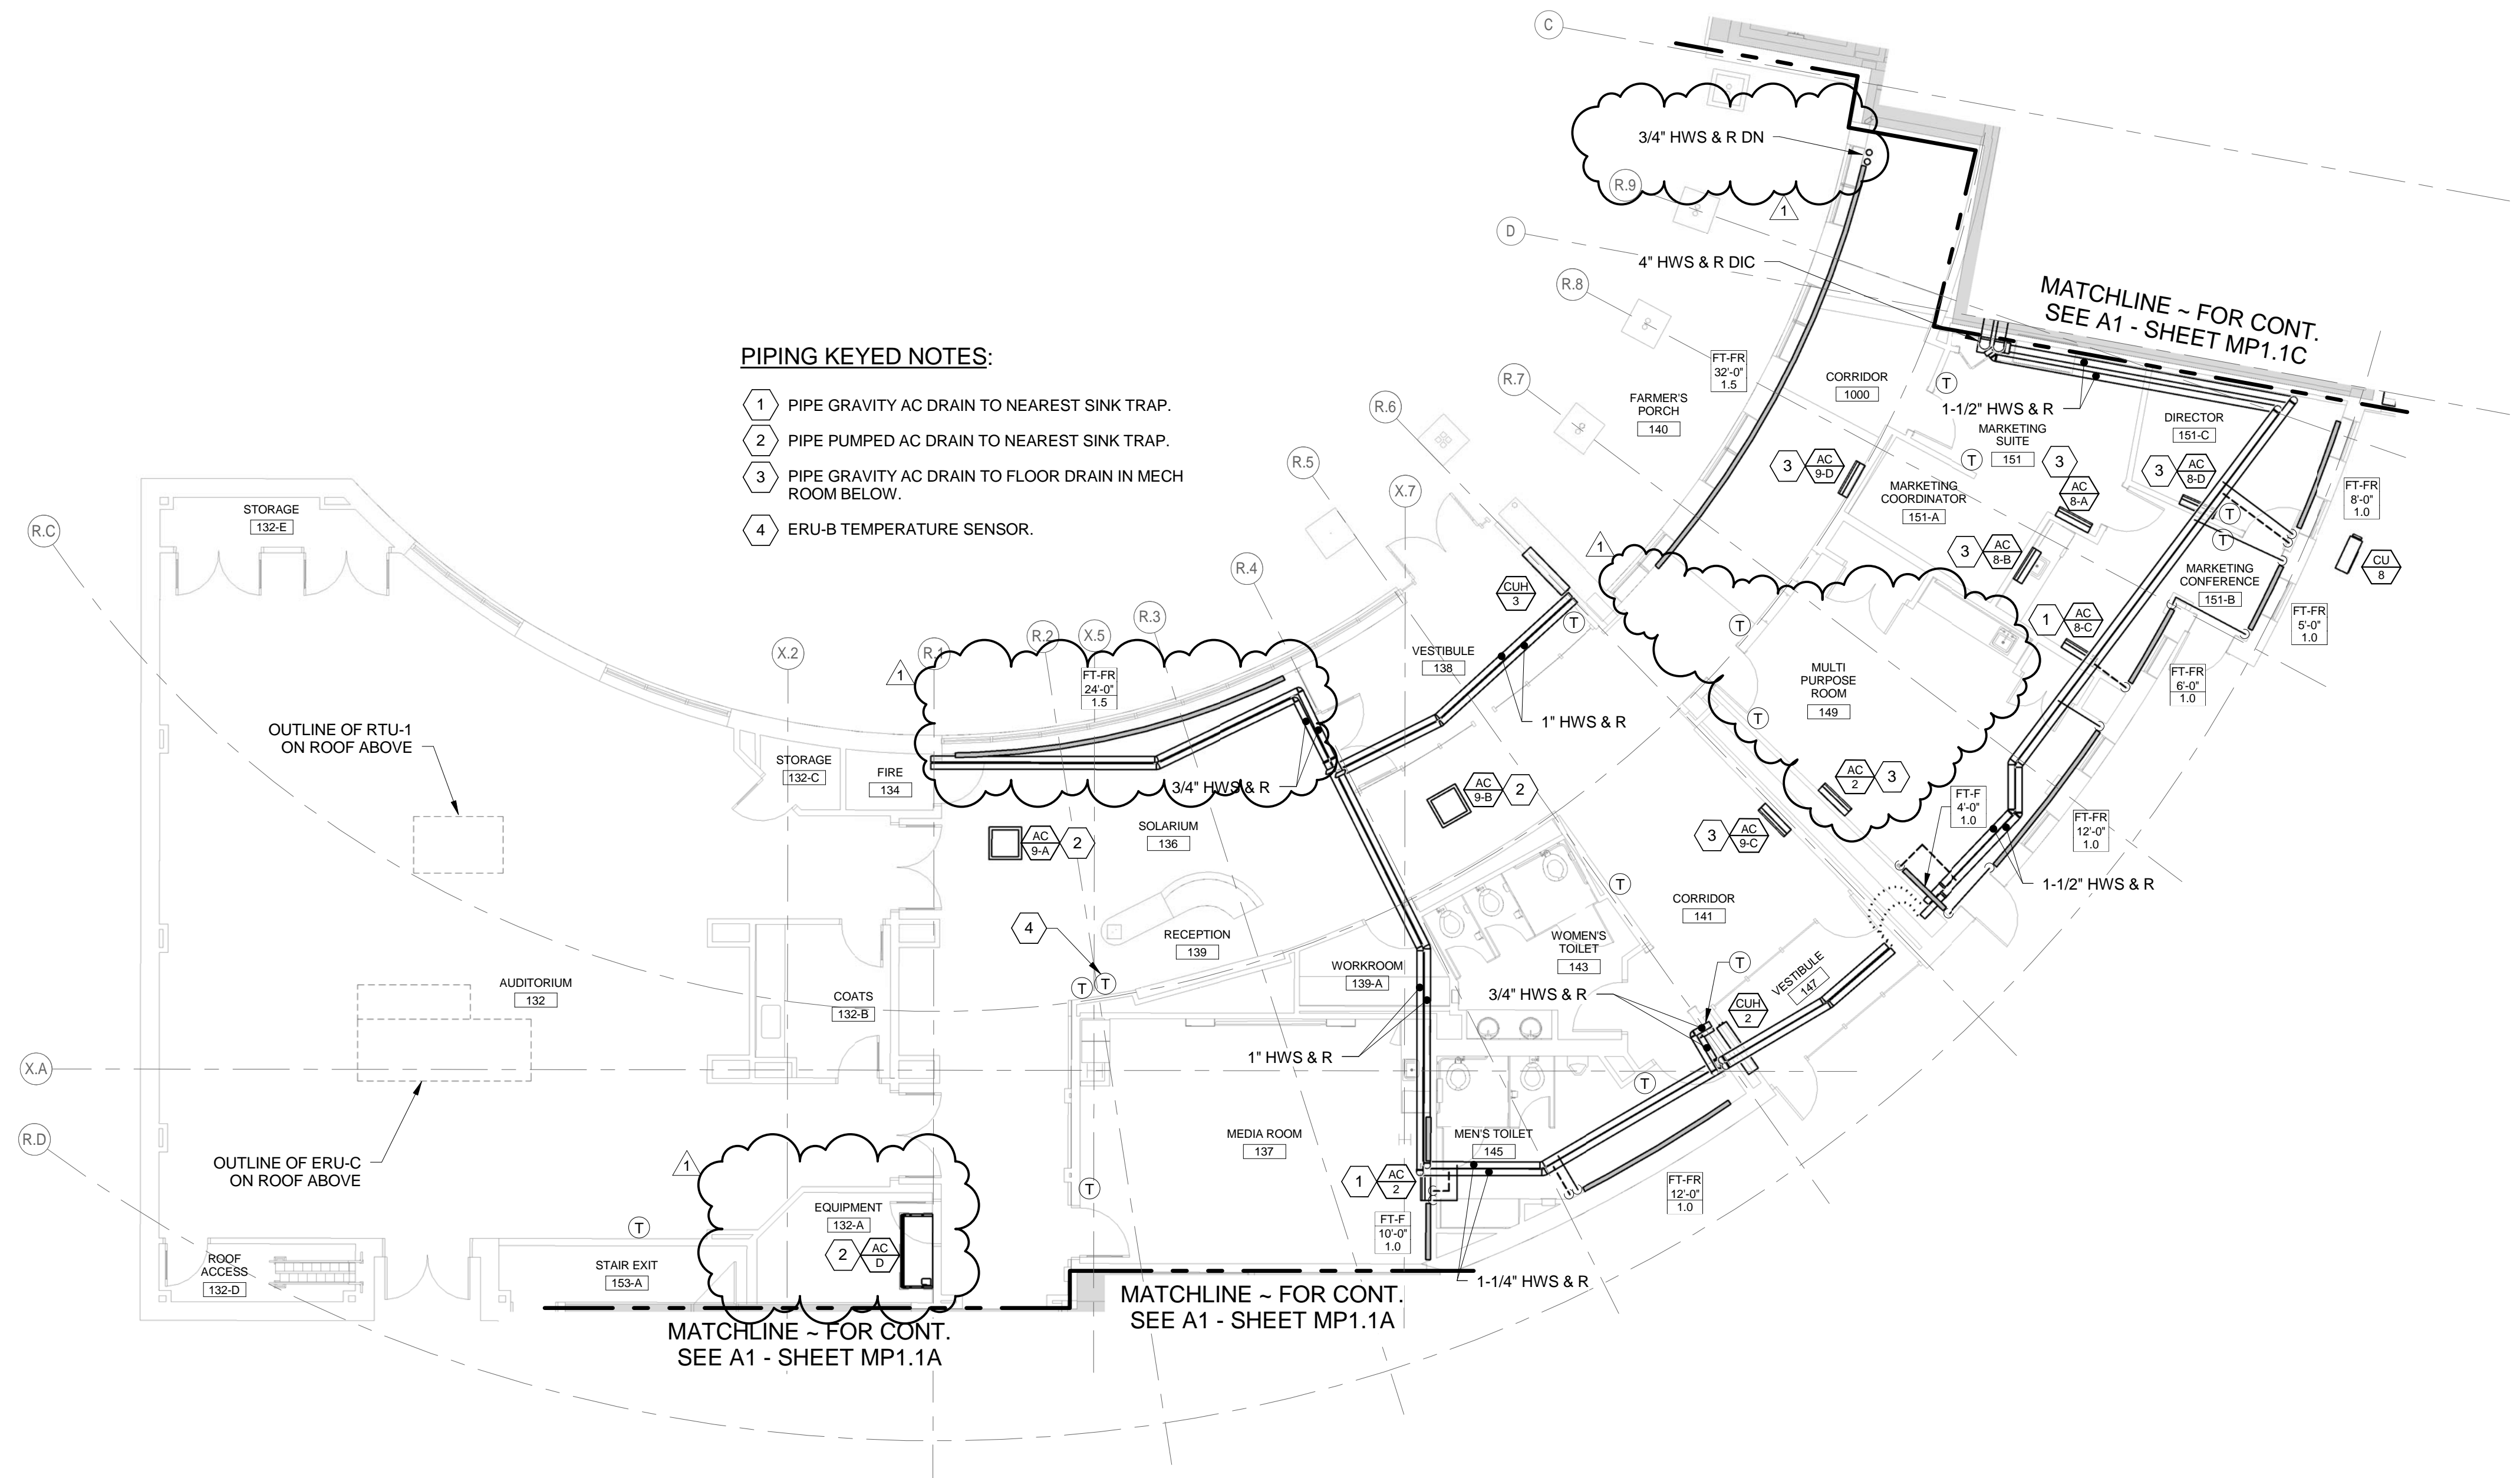

6/29/2015 9:31:09 AM N:\Projects\2015\1614018 - Park Danforth\100 Drawing files - REV\17 2015\1614018.rvt