

160 Veranda Street
 Portland, Maine 04103
 T: 207.221.2240
 F: 207.221.2246
 Web: www.allied-eng.com



Graphic Scale: 1" = 10'-0"


The Park Danforth

777 Stevens Ave, Portland, ME, 04103


NO.	DESCRIPTION	DATE
1	Addendum No. 2	2015-06-25




CONTENT: PLUMBING - DRAINAGE AND SUPPLY ROOF LEVEL - NEW BUILDING	
DRAWN BY:	SGH
PROJECT NO.:	-
DATE:	06/05/2015
REVISED:	-
SCALE:	AS NOTED
<h1>P1.6C</h1>	
Project Phase 100% CONSTRUCTION DOCUMENTS	
<small> COPYRIGHT © 2014 BY LAVALLEE BRENSINGER PROFESSIONAL ASSOCIATION. ALL RIGHTS RESERVED. NO REPRODUCTION WITHOUT PERMISSION. </small>	

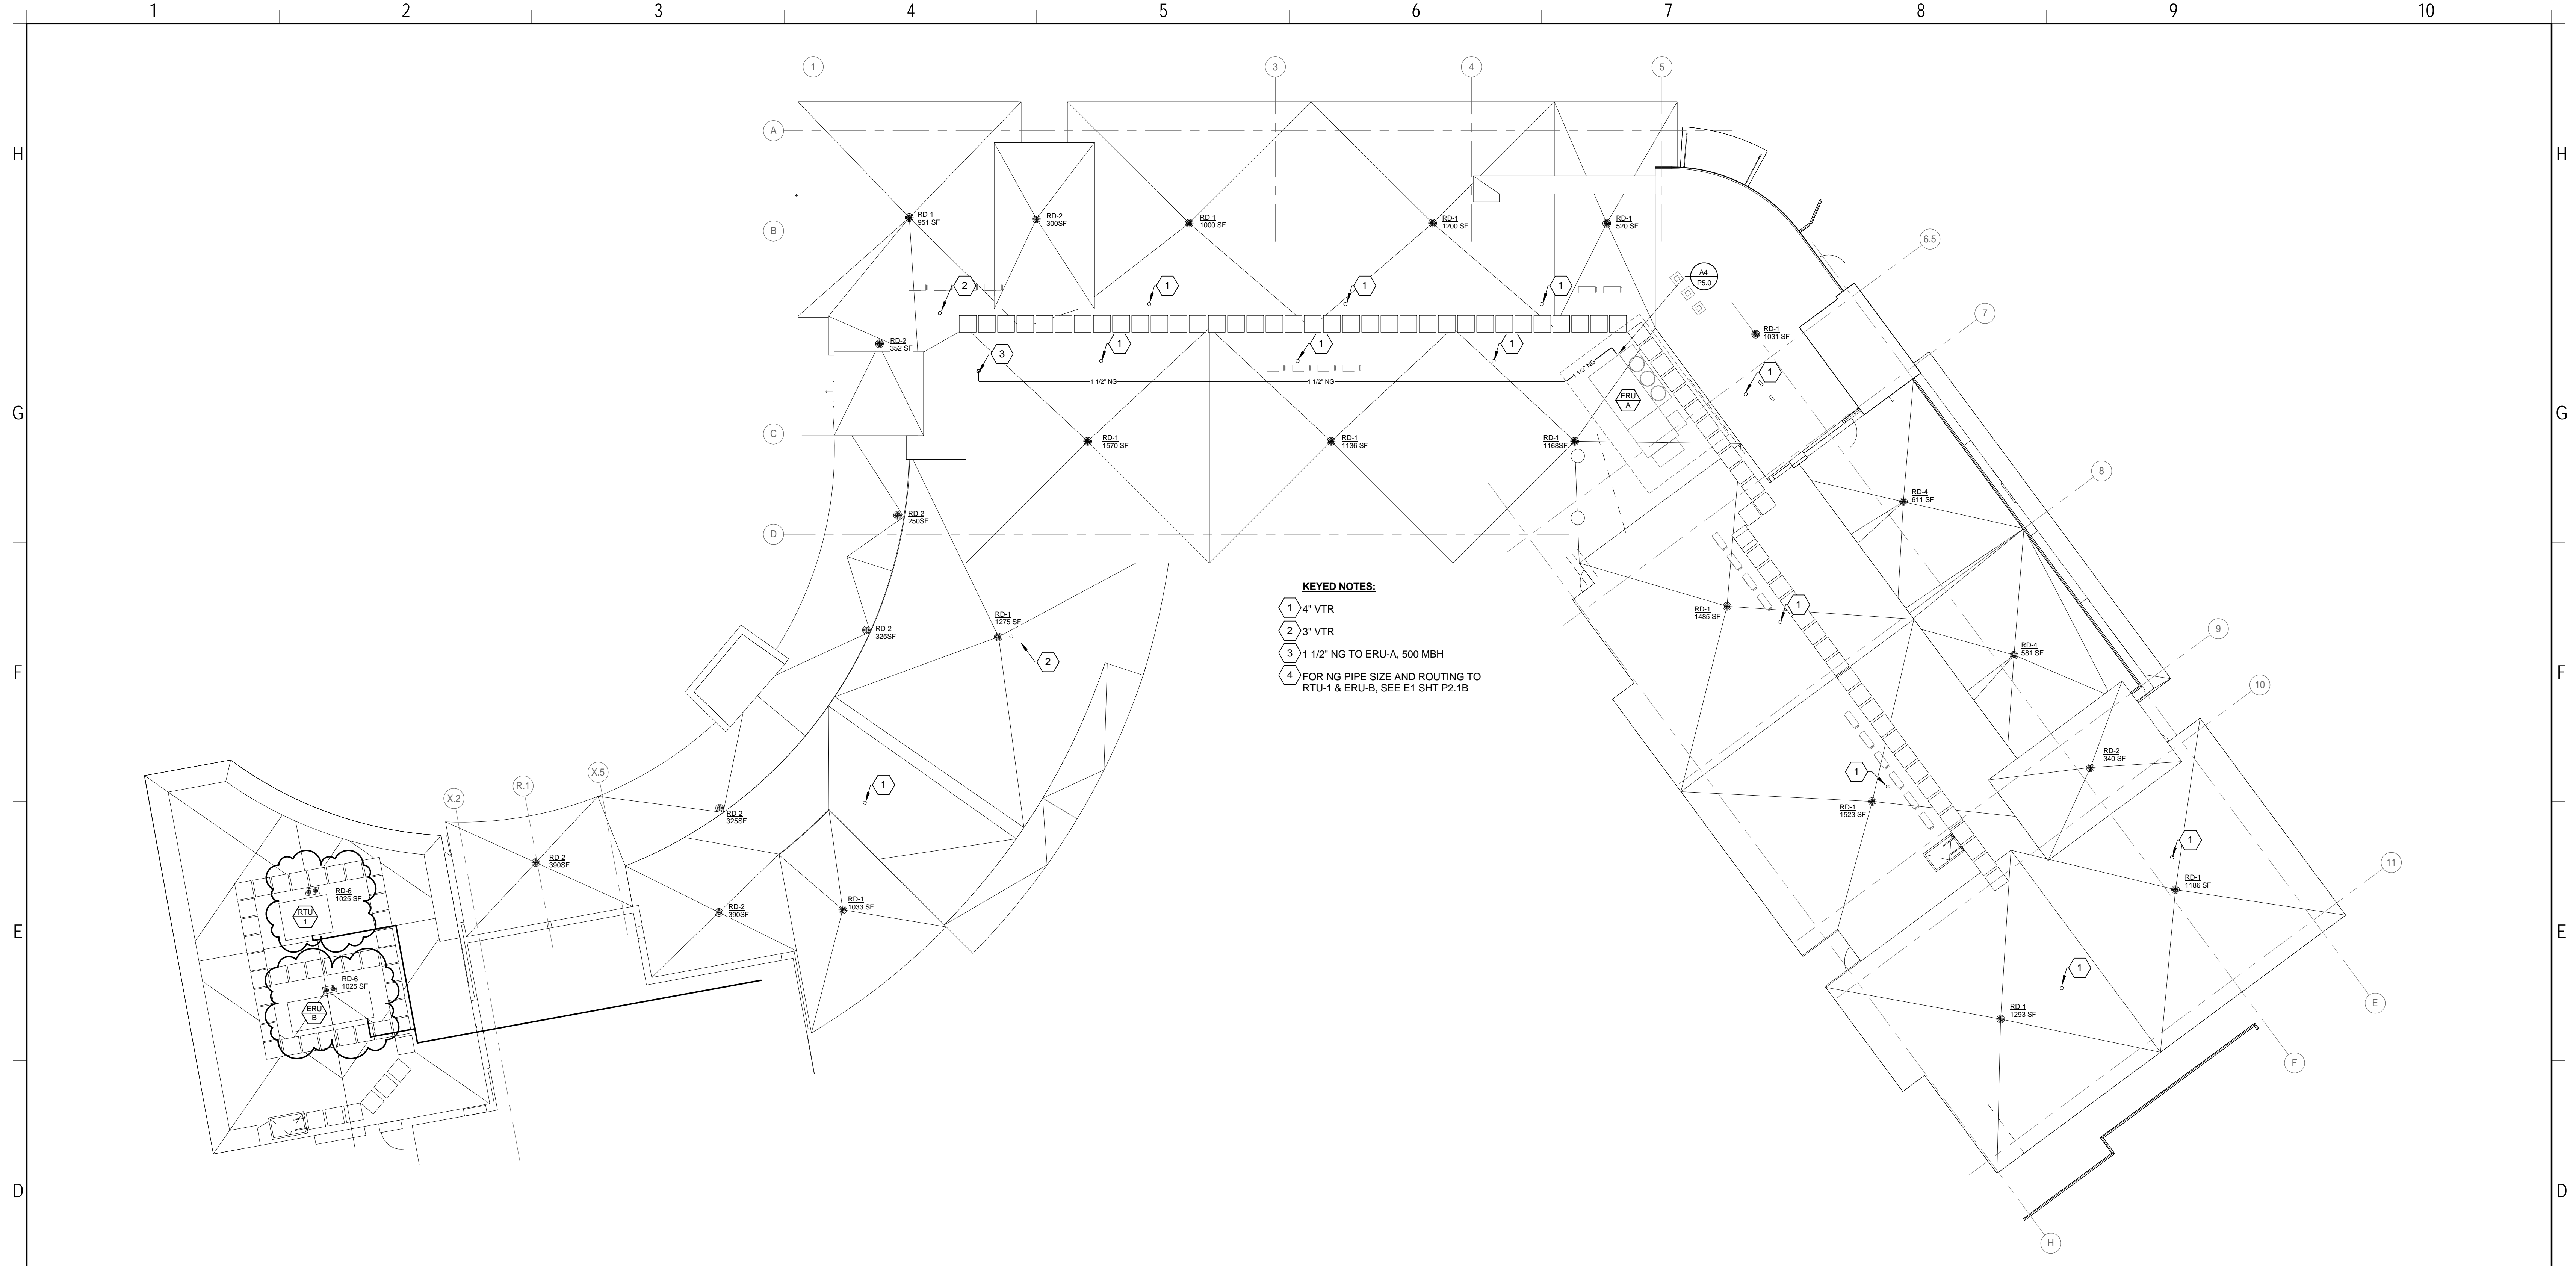


D1 MECHANICAL PLAN - ROOF - NEW BUILDING
 3/32" = 1'-0"

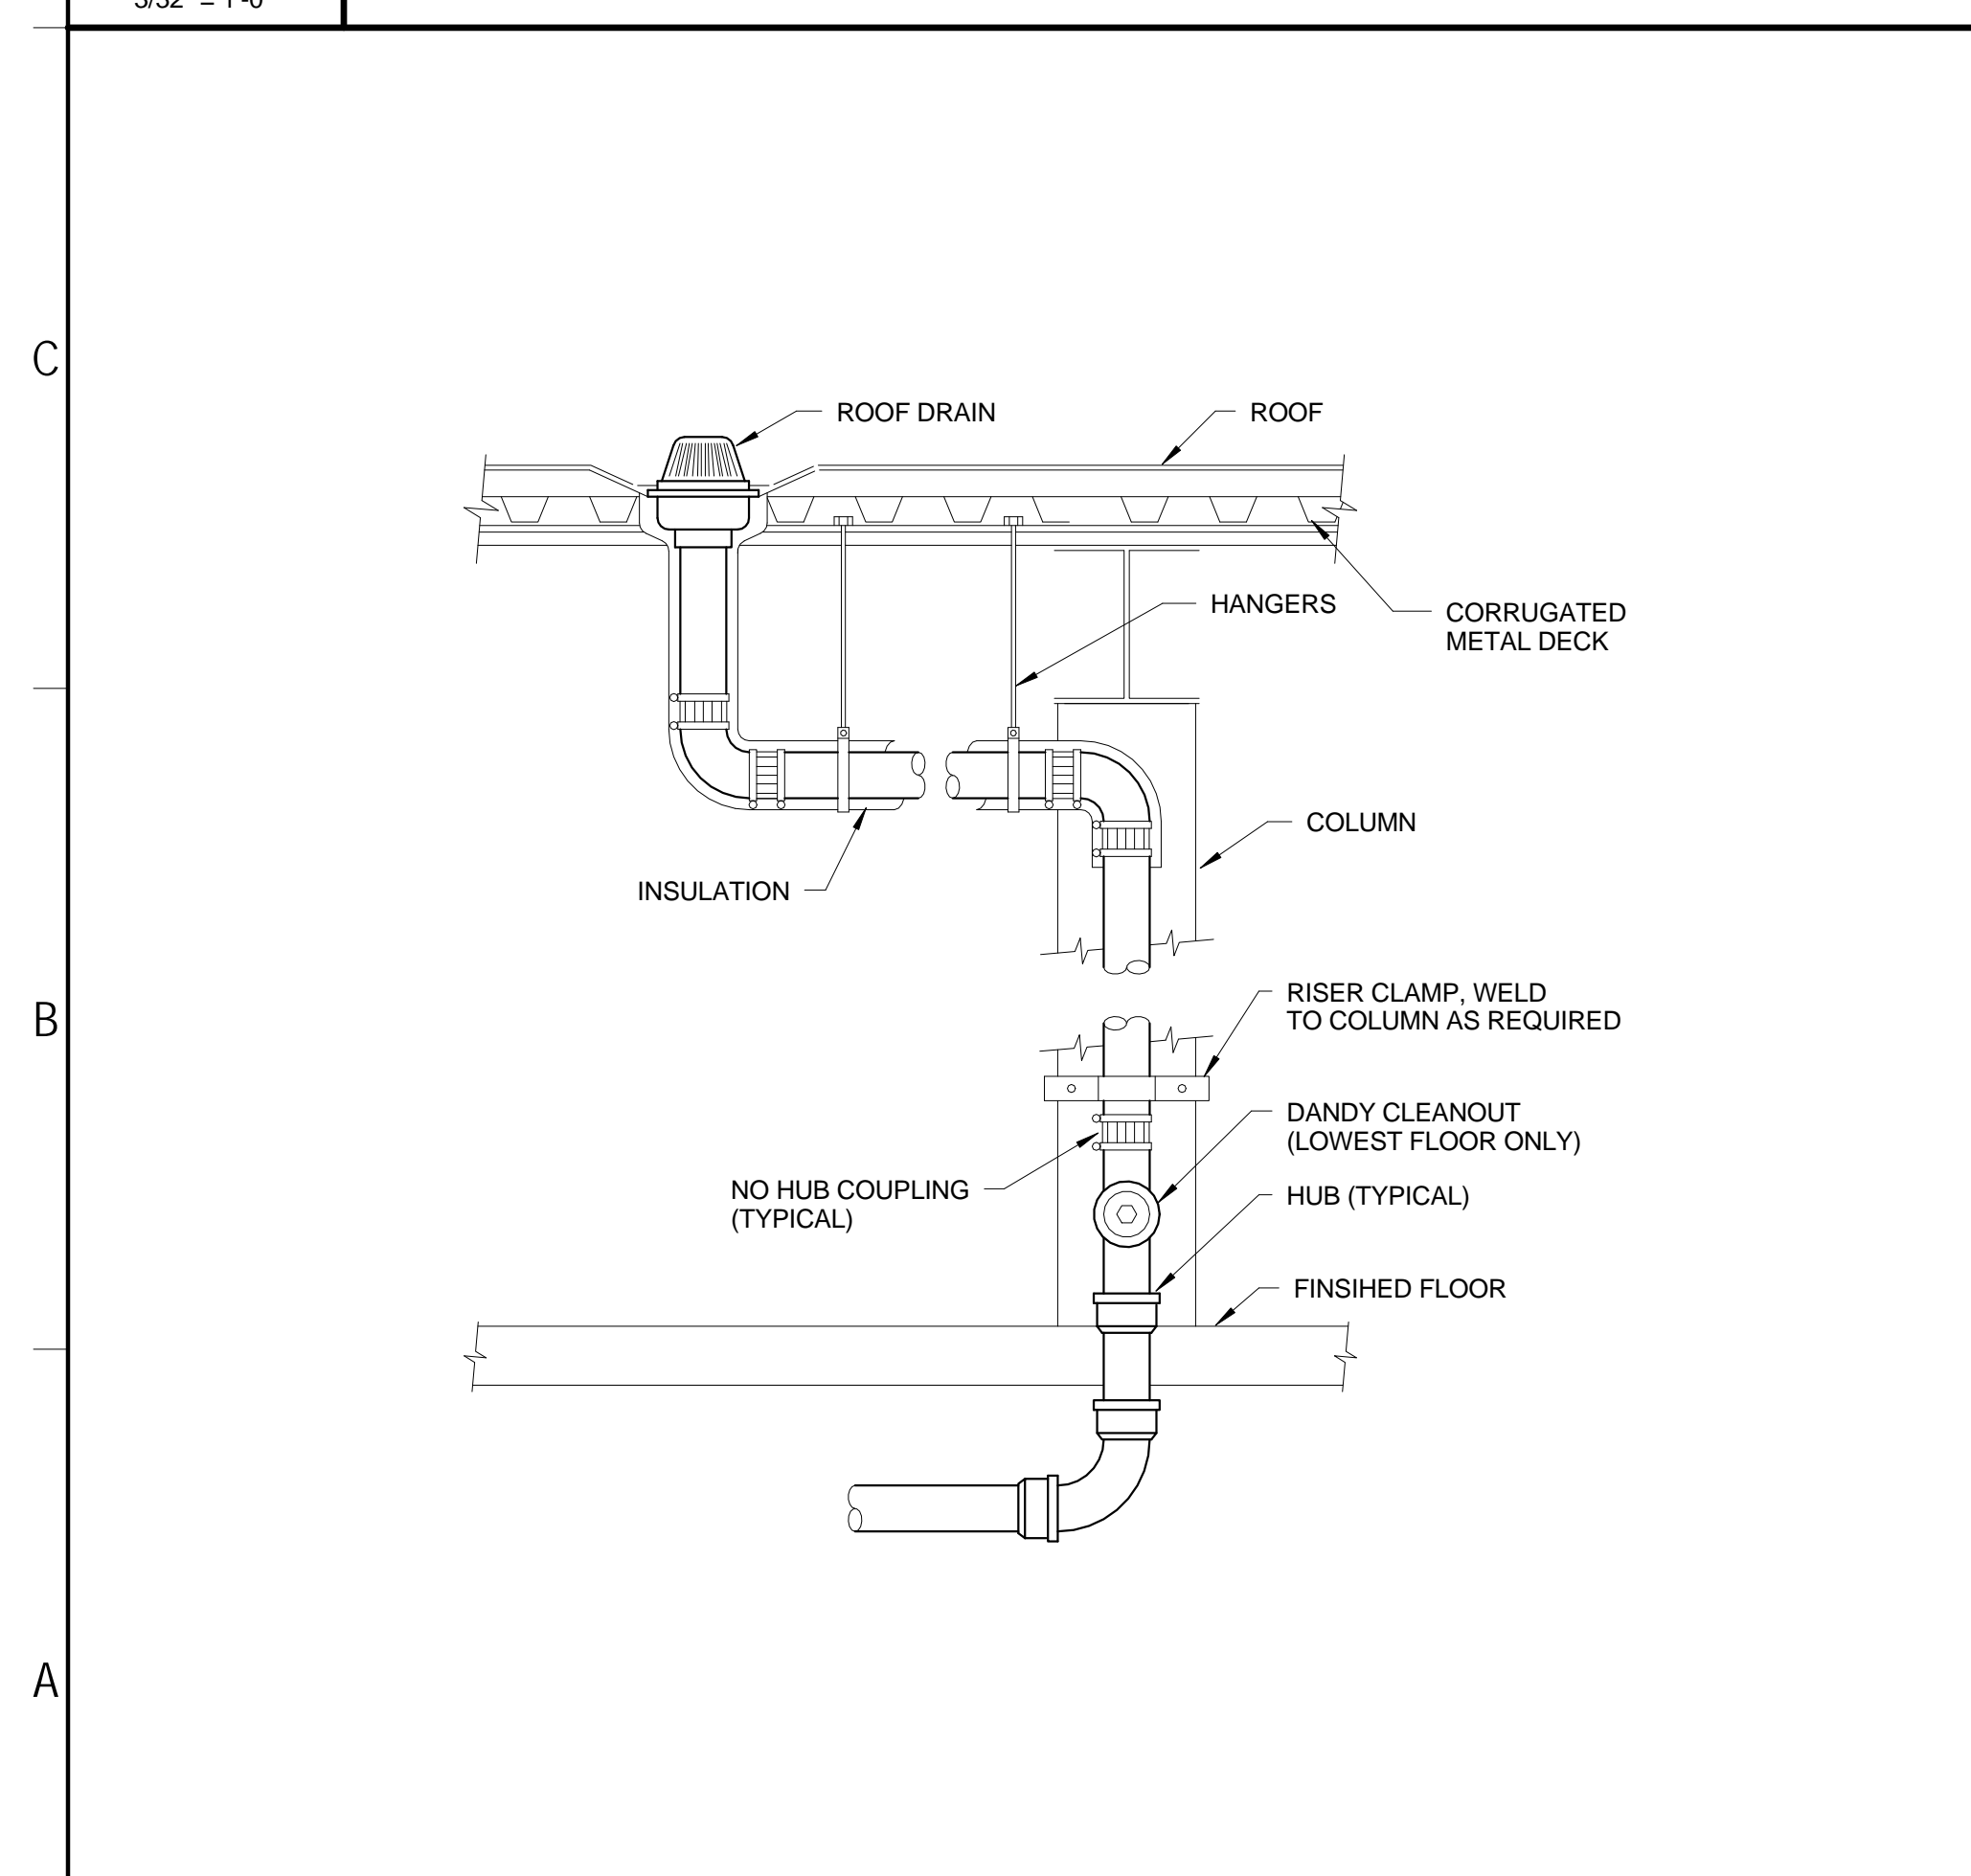

A1 DETAIL - ROOF DRAIN PIPING
 NOT TO SCALE

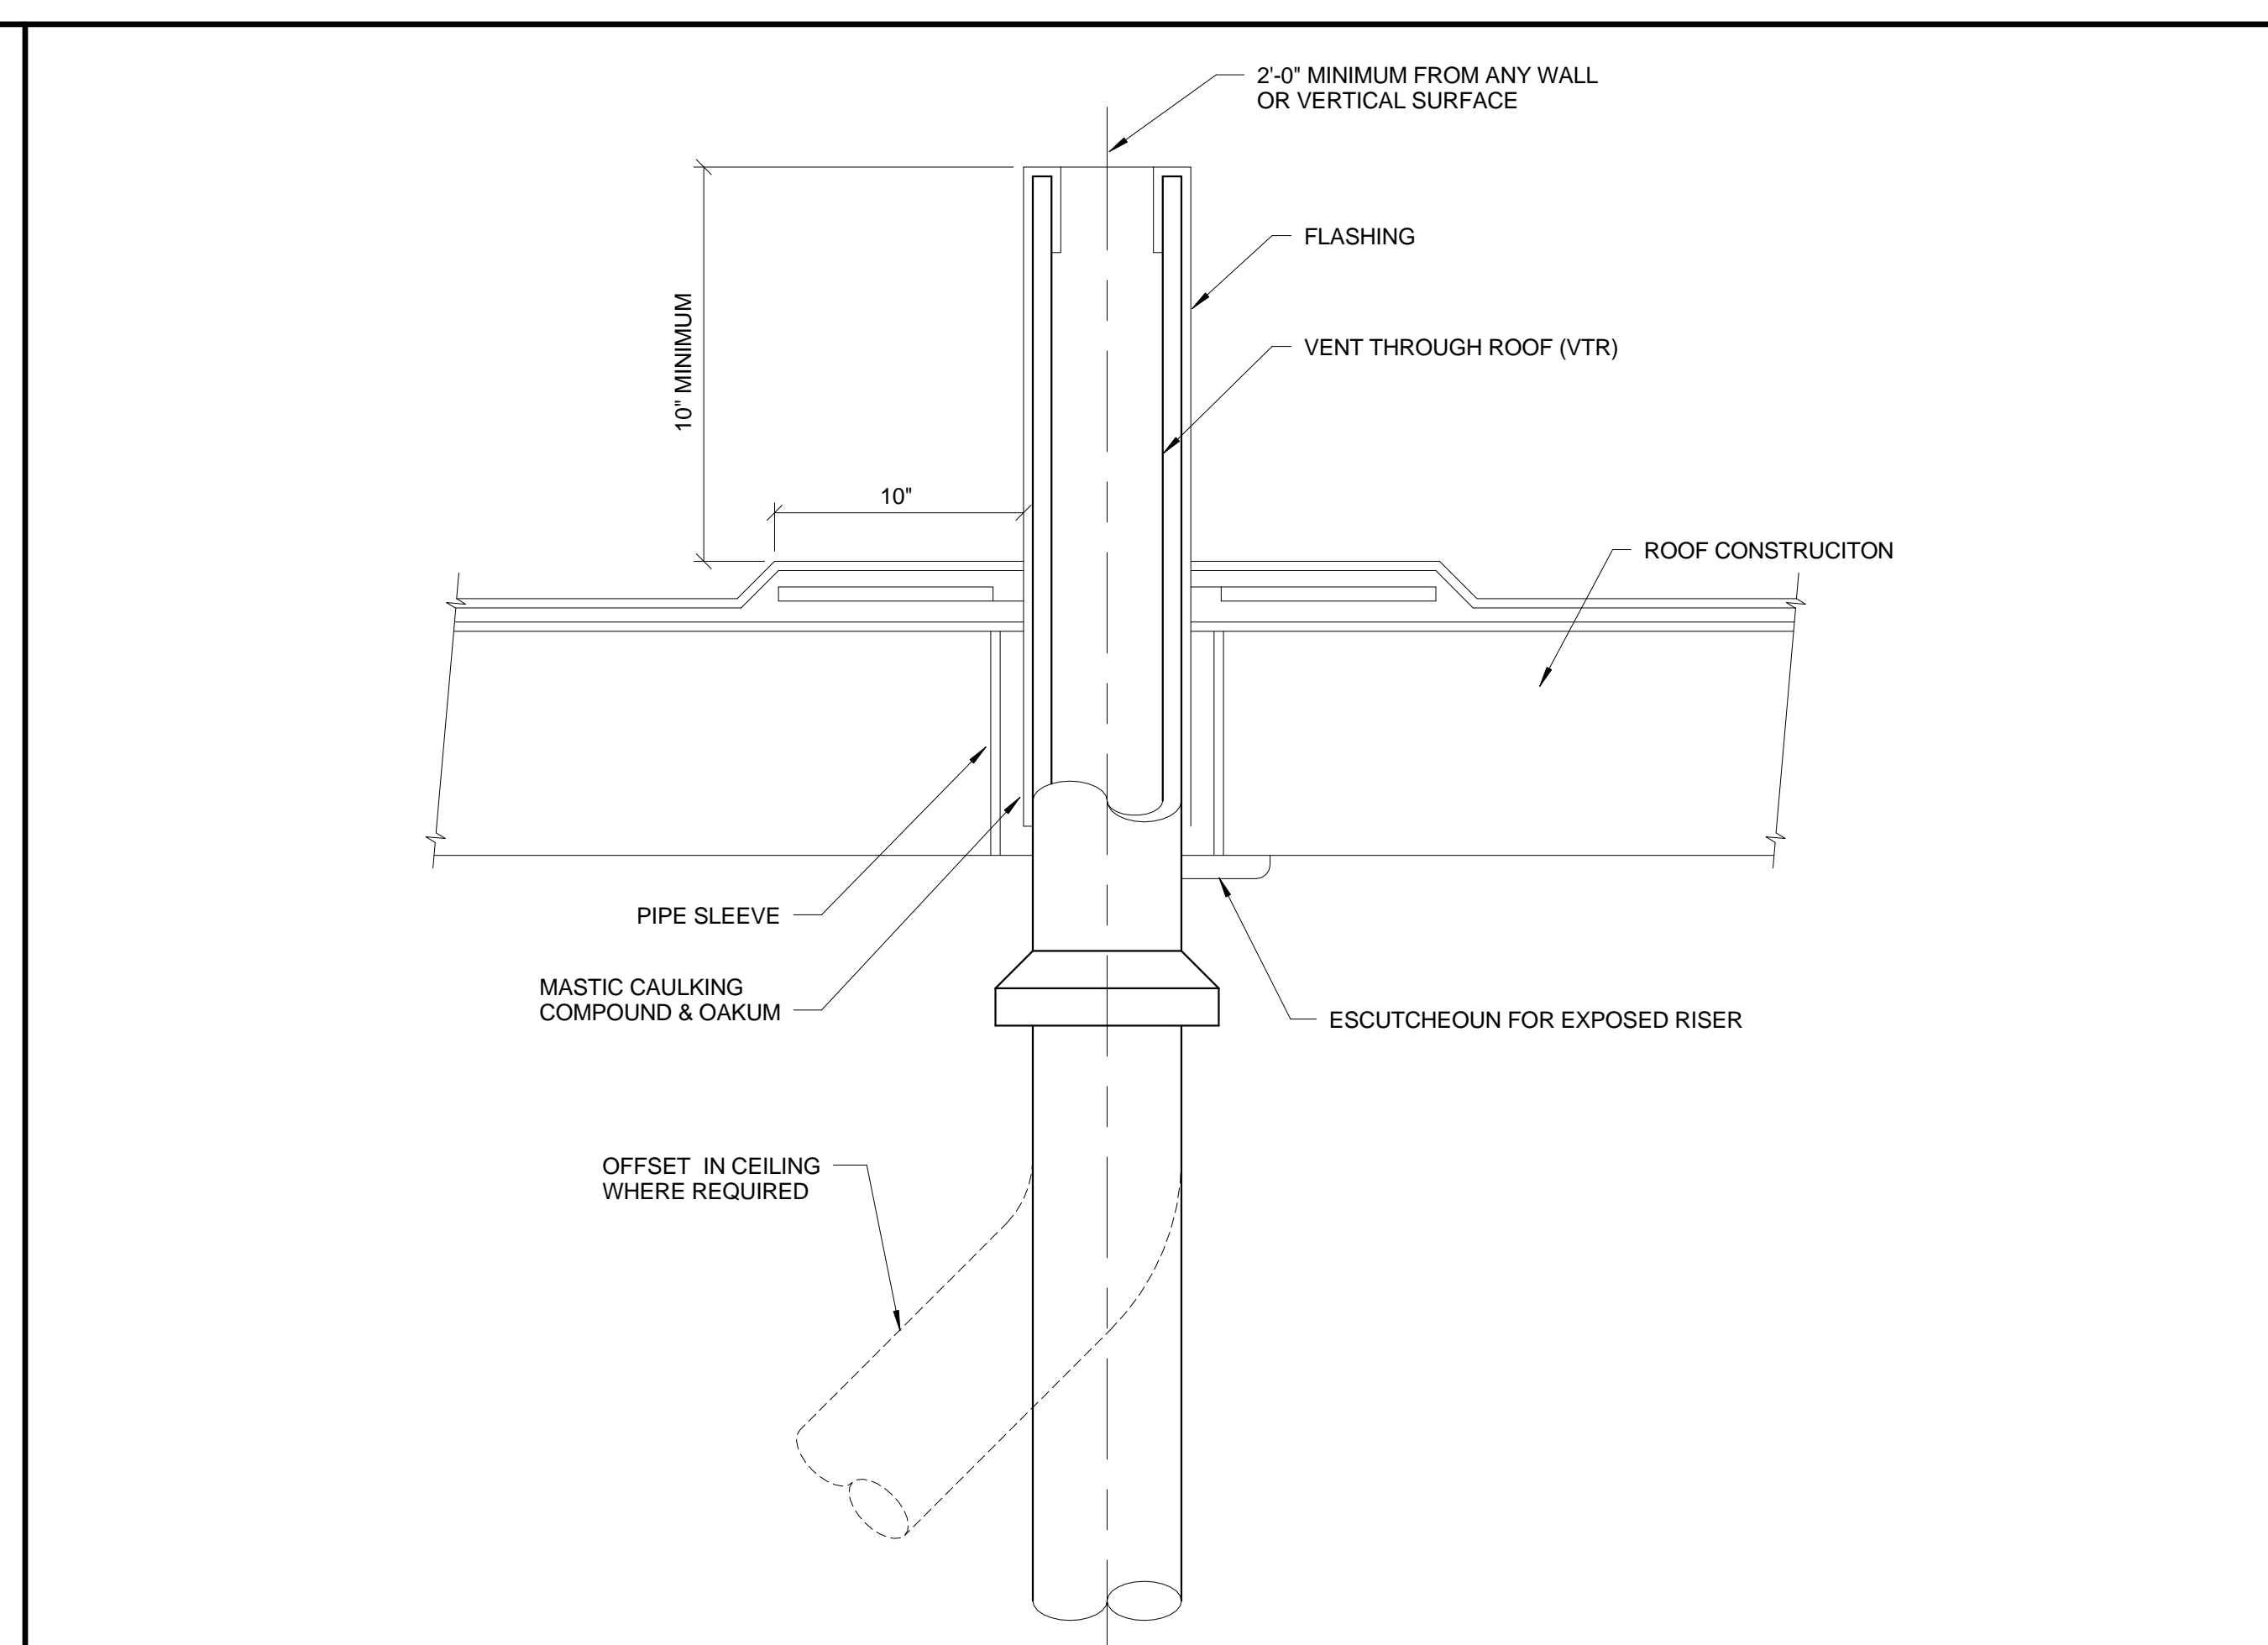

A4 DETAIL - GAS EQUIPMENT CONNECTION
 NOT TO SCALE

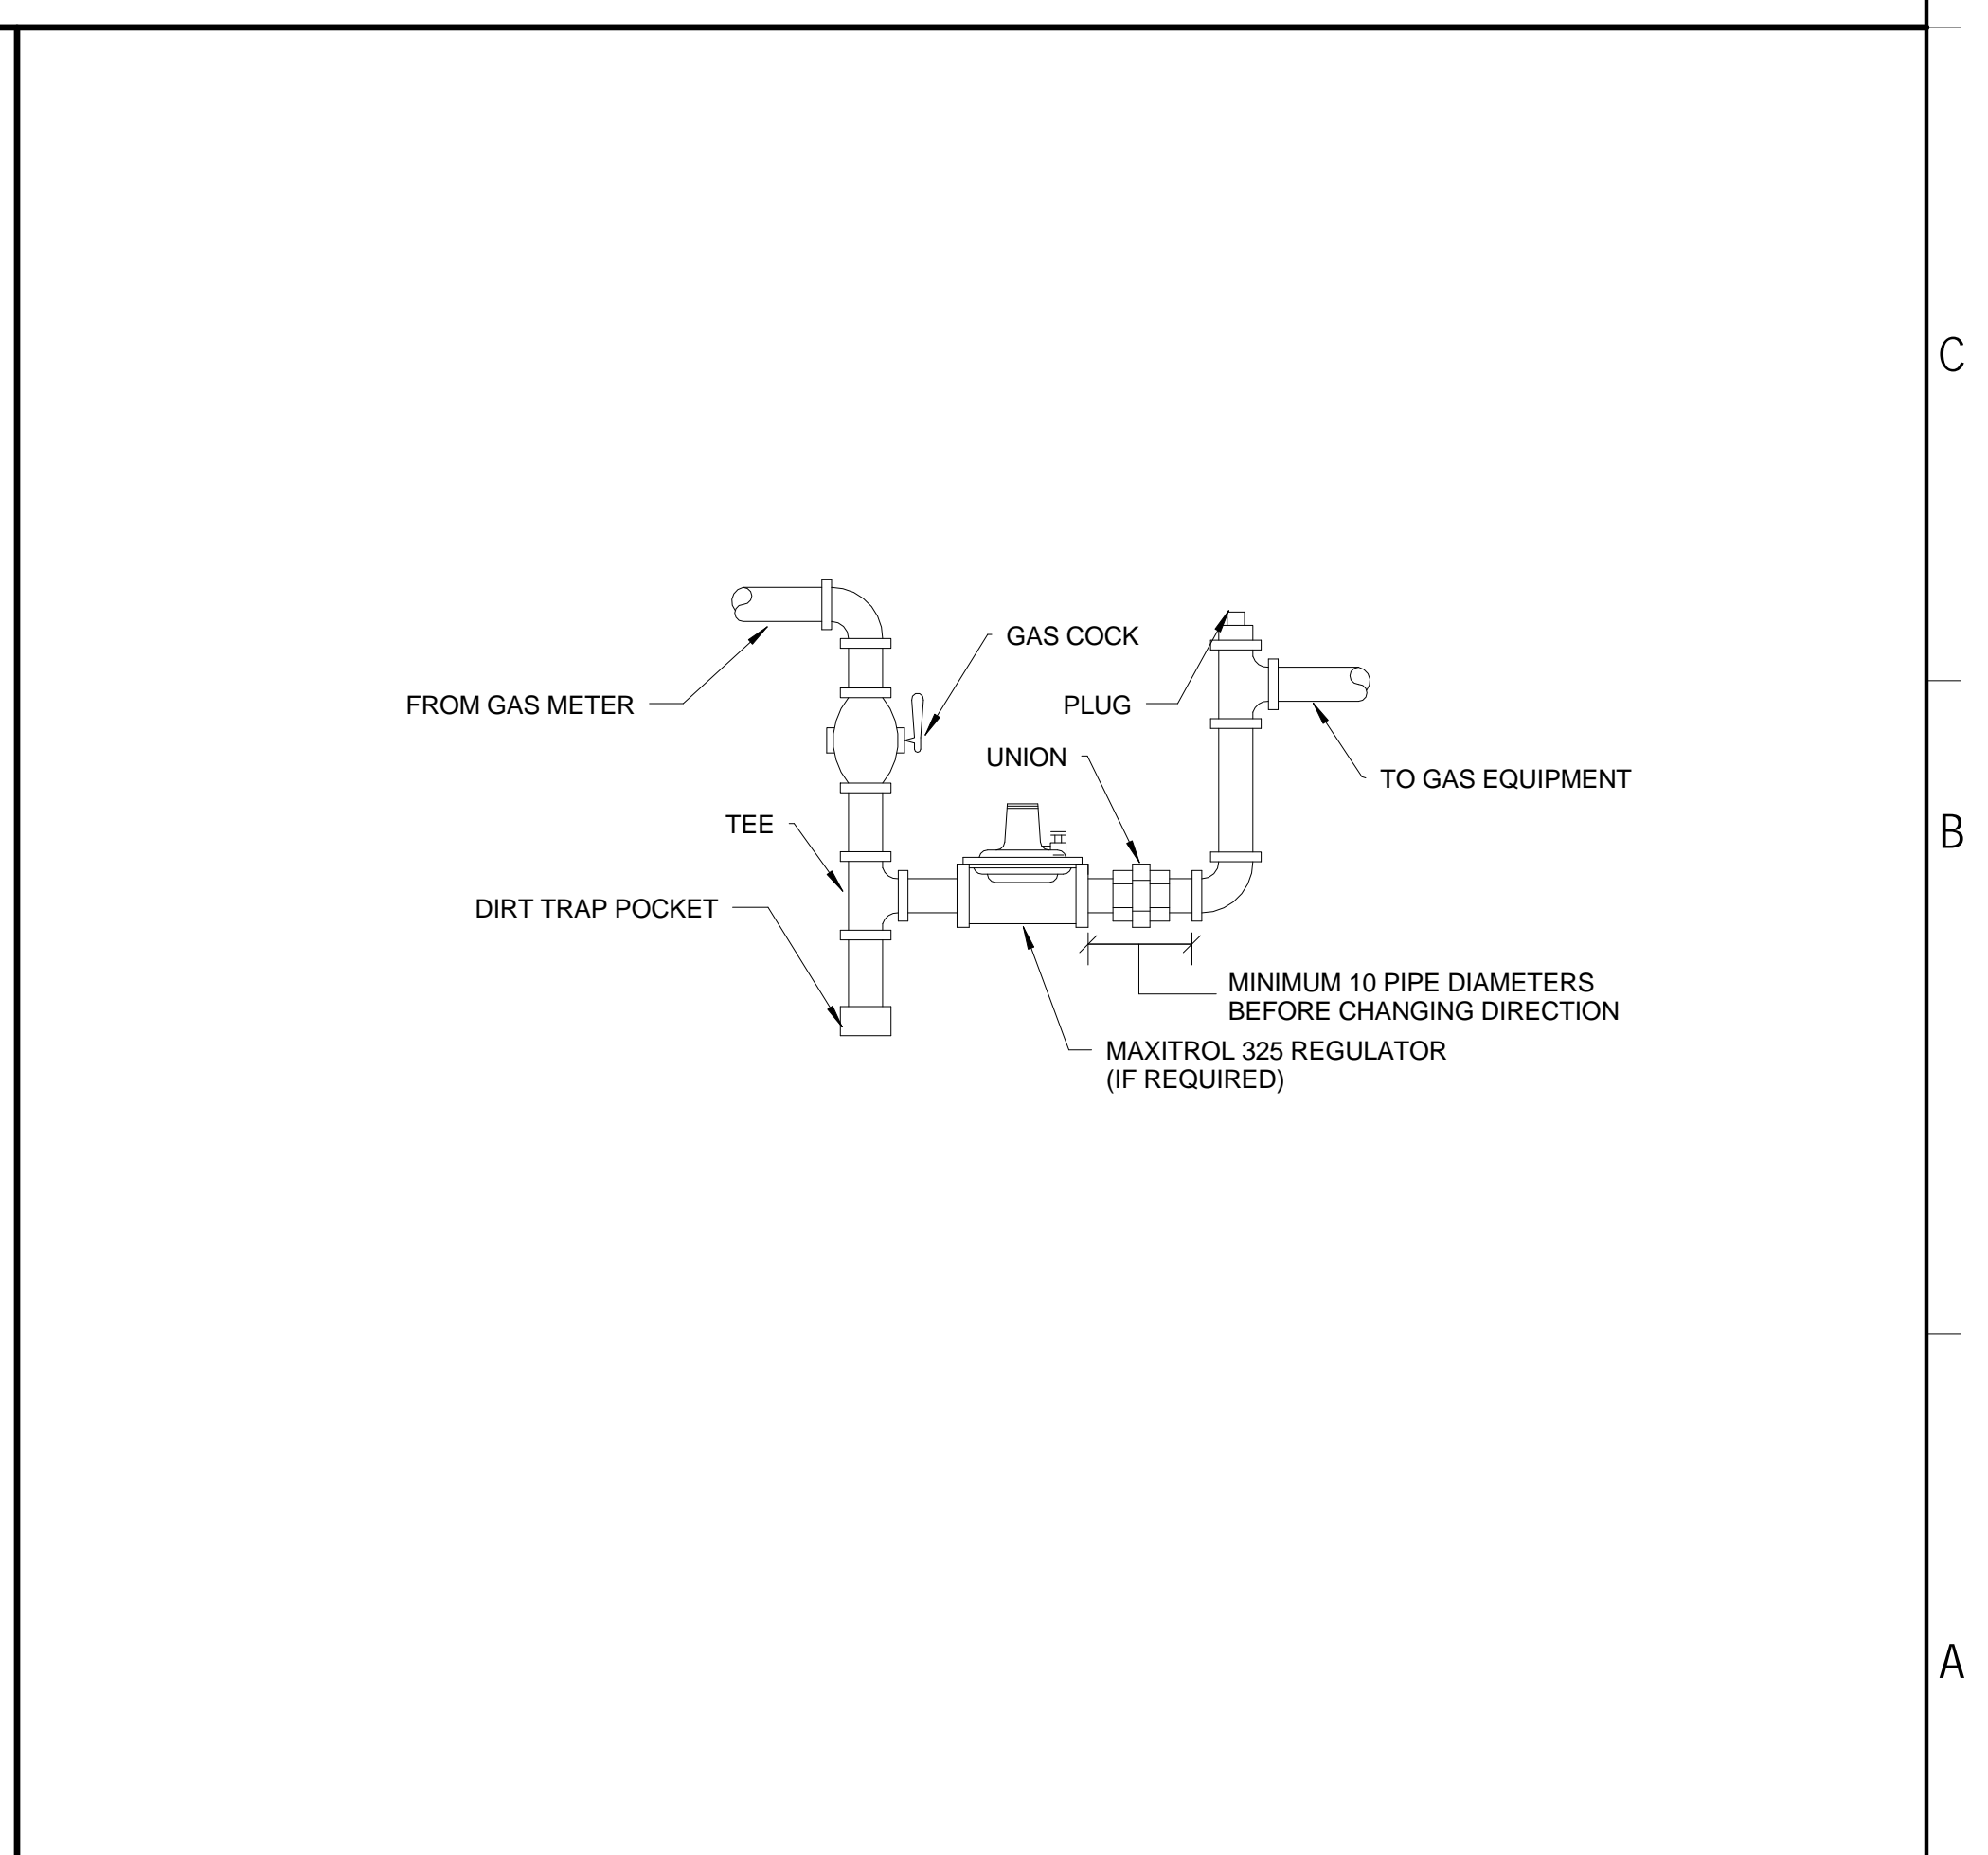

A8 DETAIL - GAS EQUIPMENT CONNECTION
 NOT TO SCALE

06/20/15 9:13:22 AM N:\Projects\2015\141018 - Park Danforth\00 Drawing files - REVIT\2015\141018.rvt